




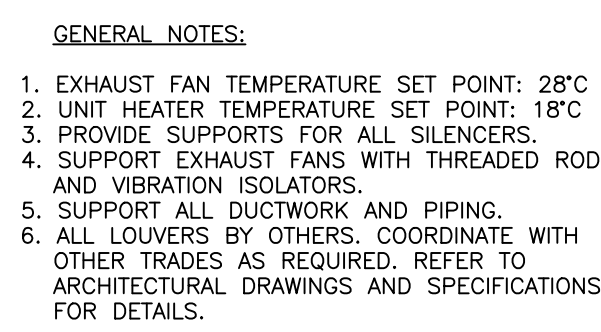


1802218	M-300
---------	-------

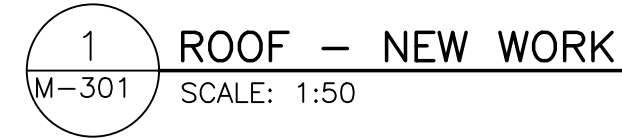


M-301

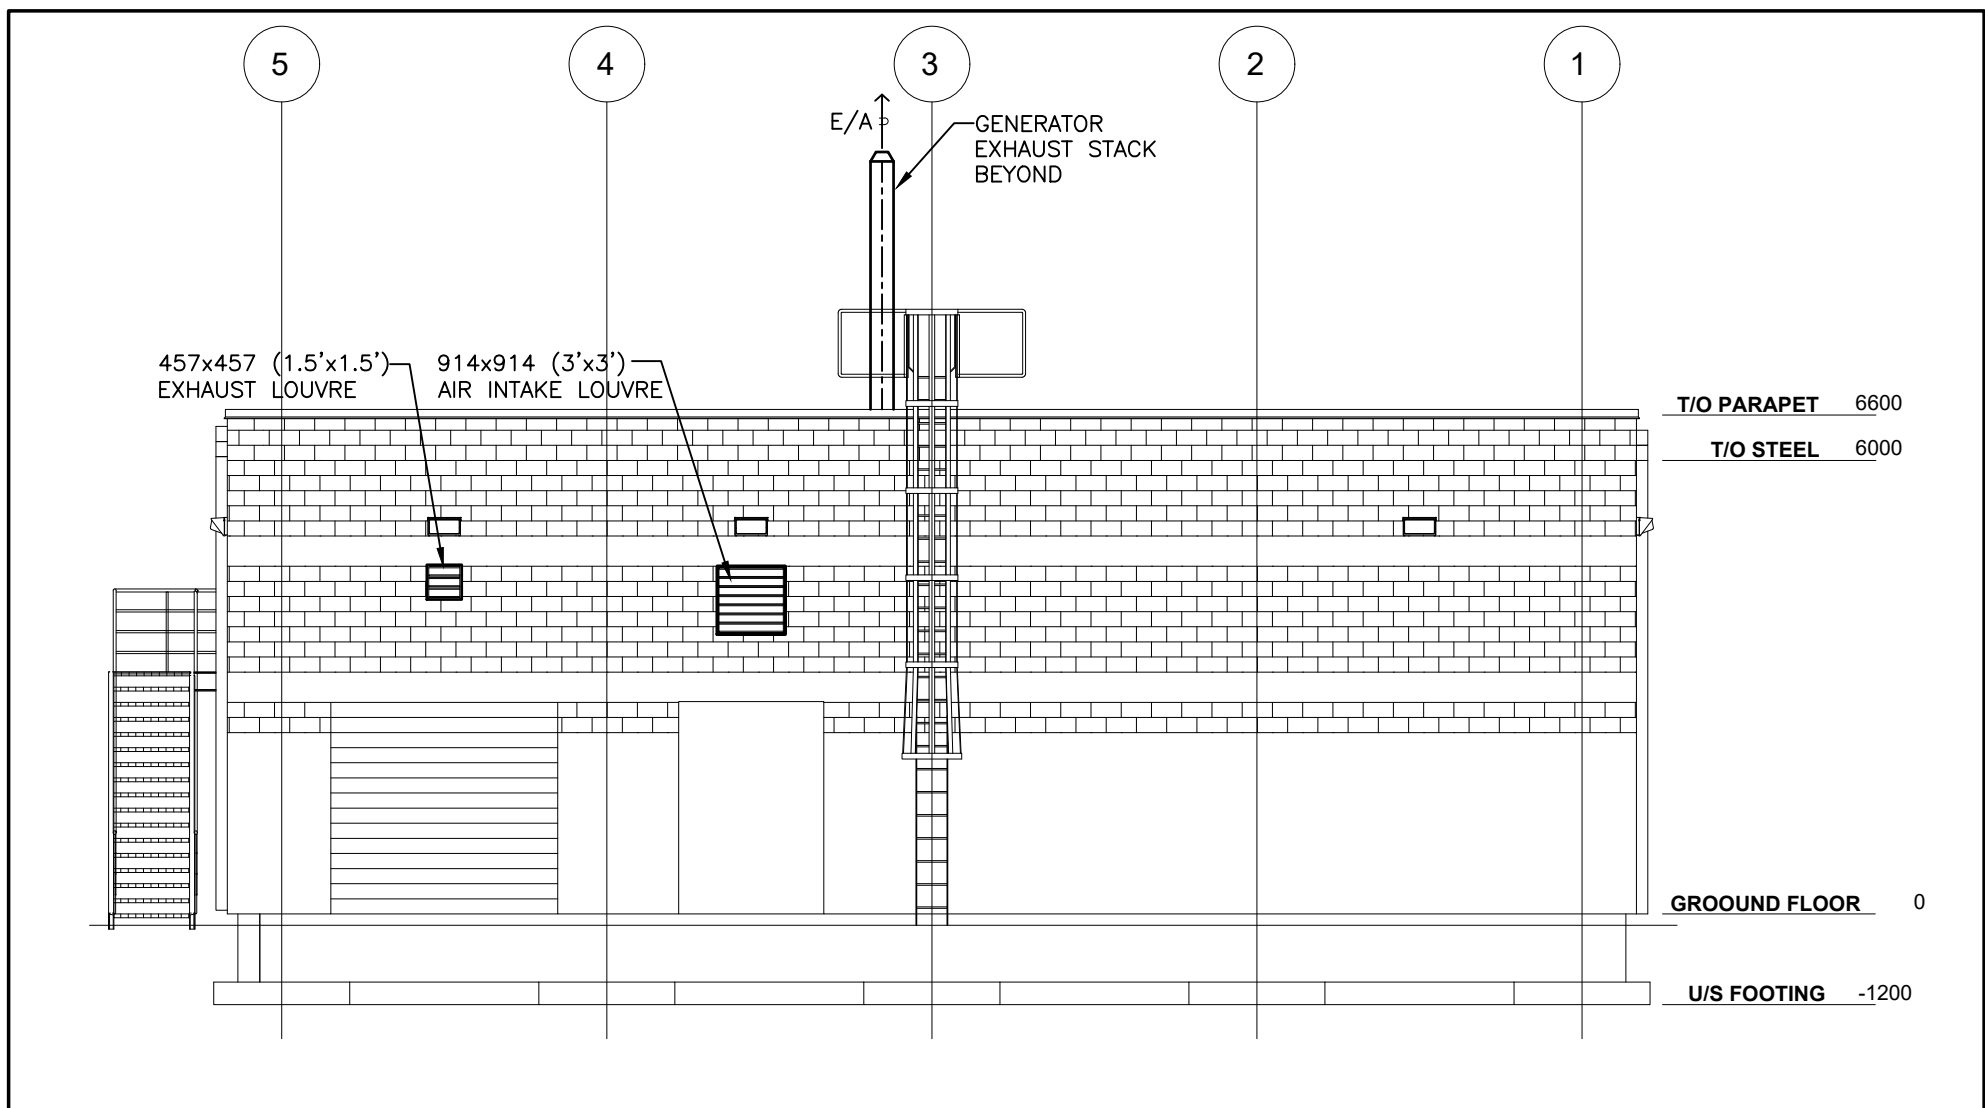


2 EAST ELEVATION
M-302 SCALE: 1:100

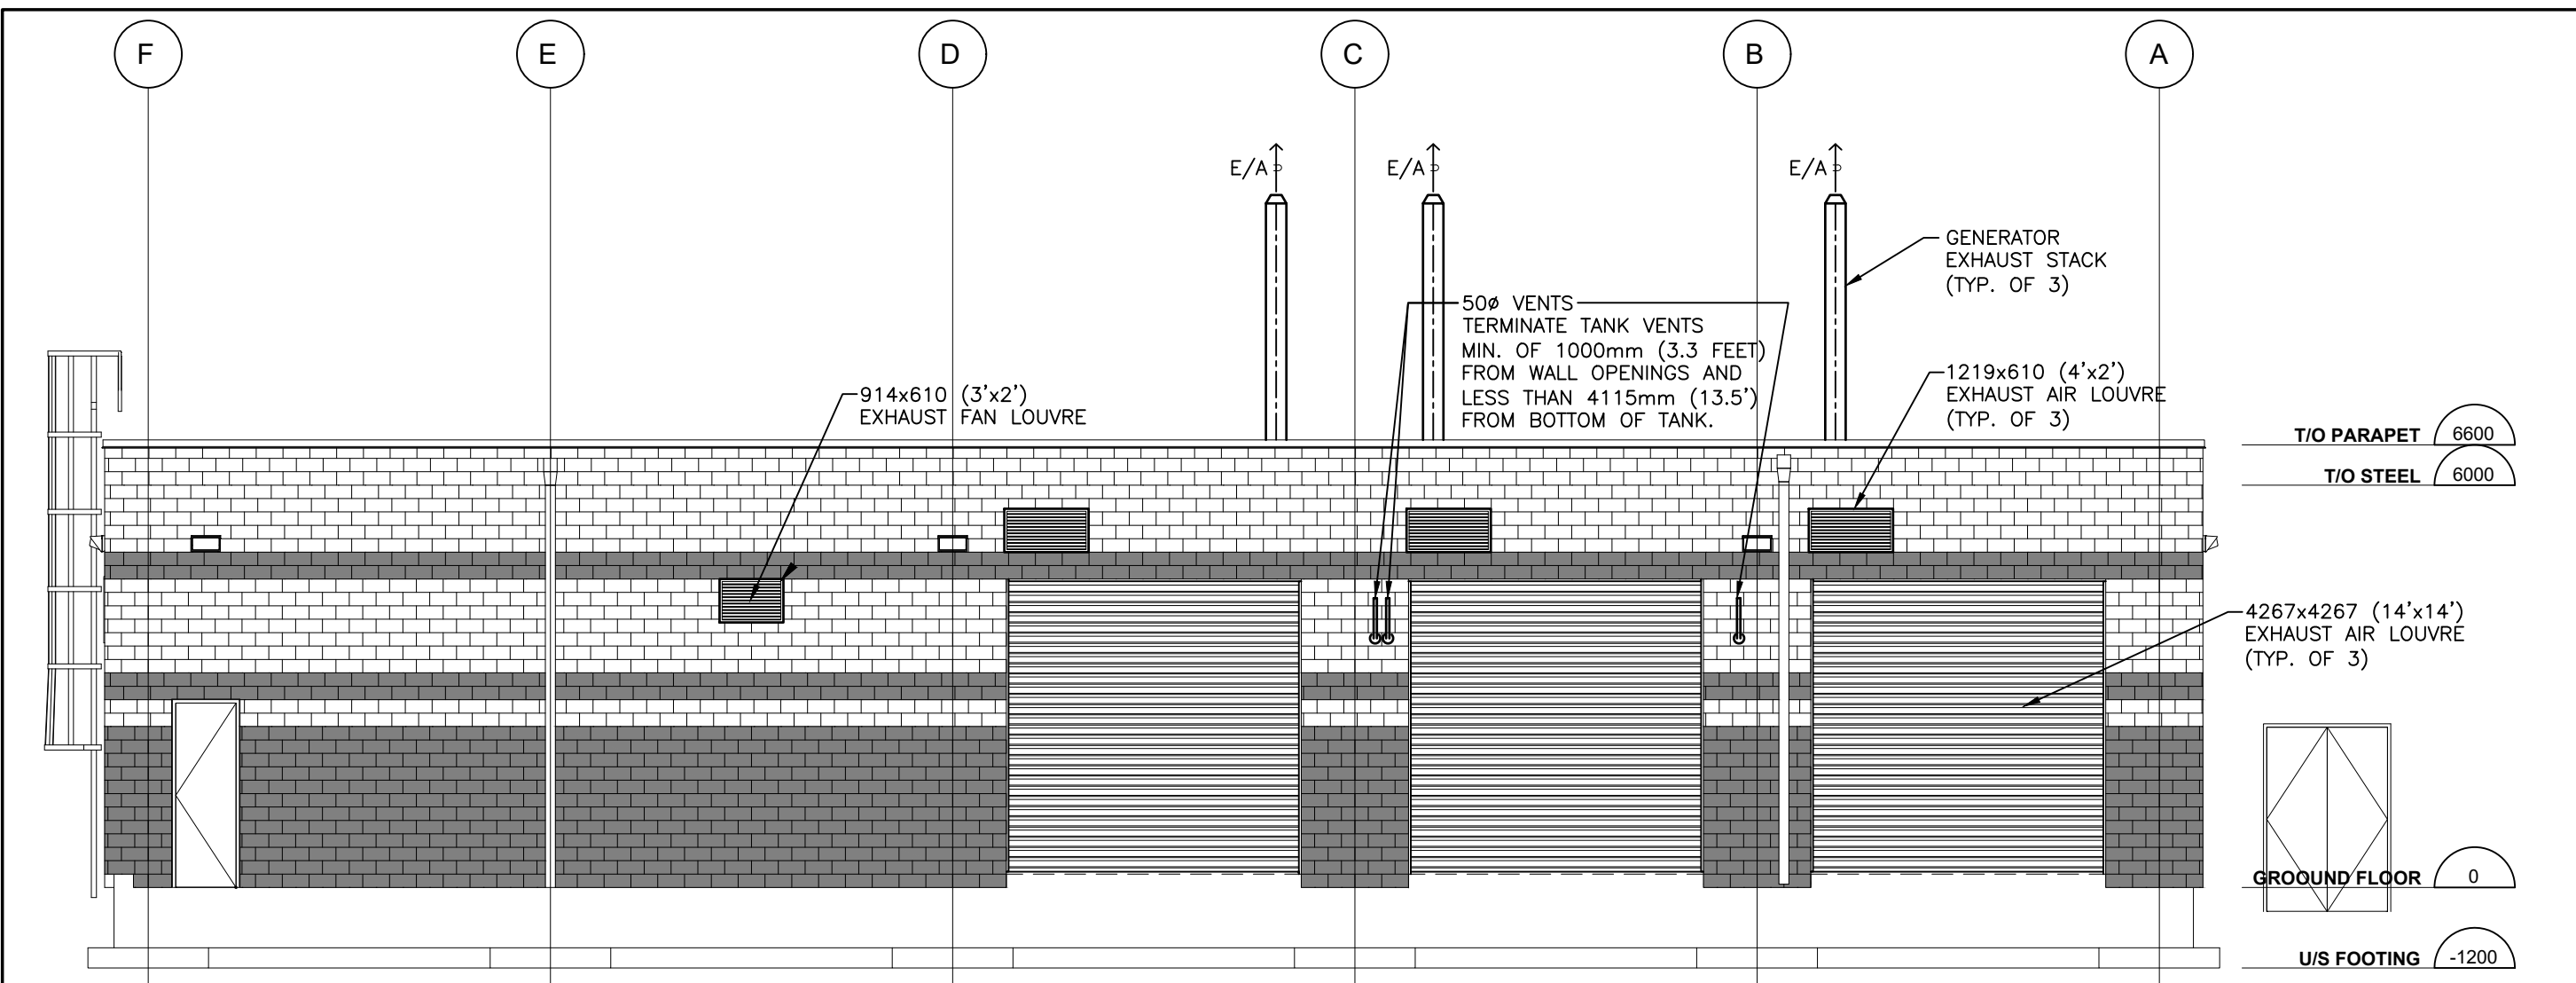


1 NORTH ELEVATION
M-302 SCALE: 1:100

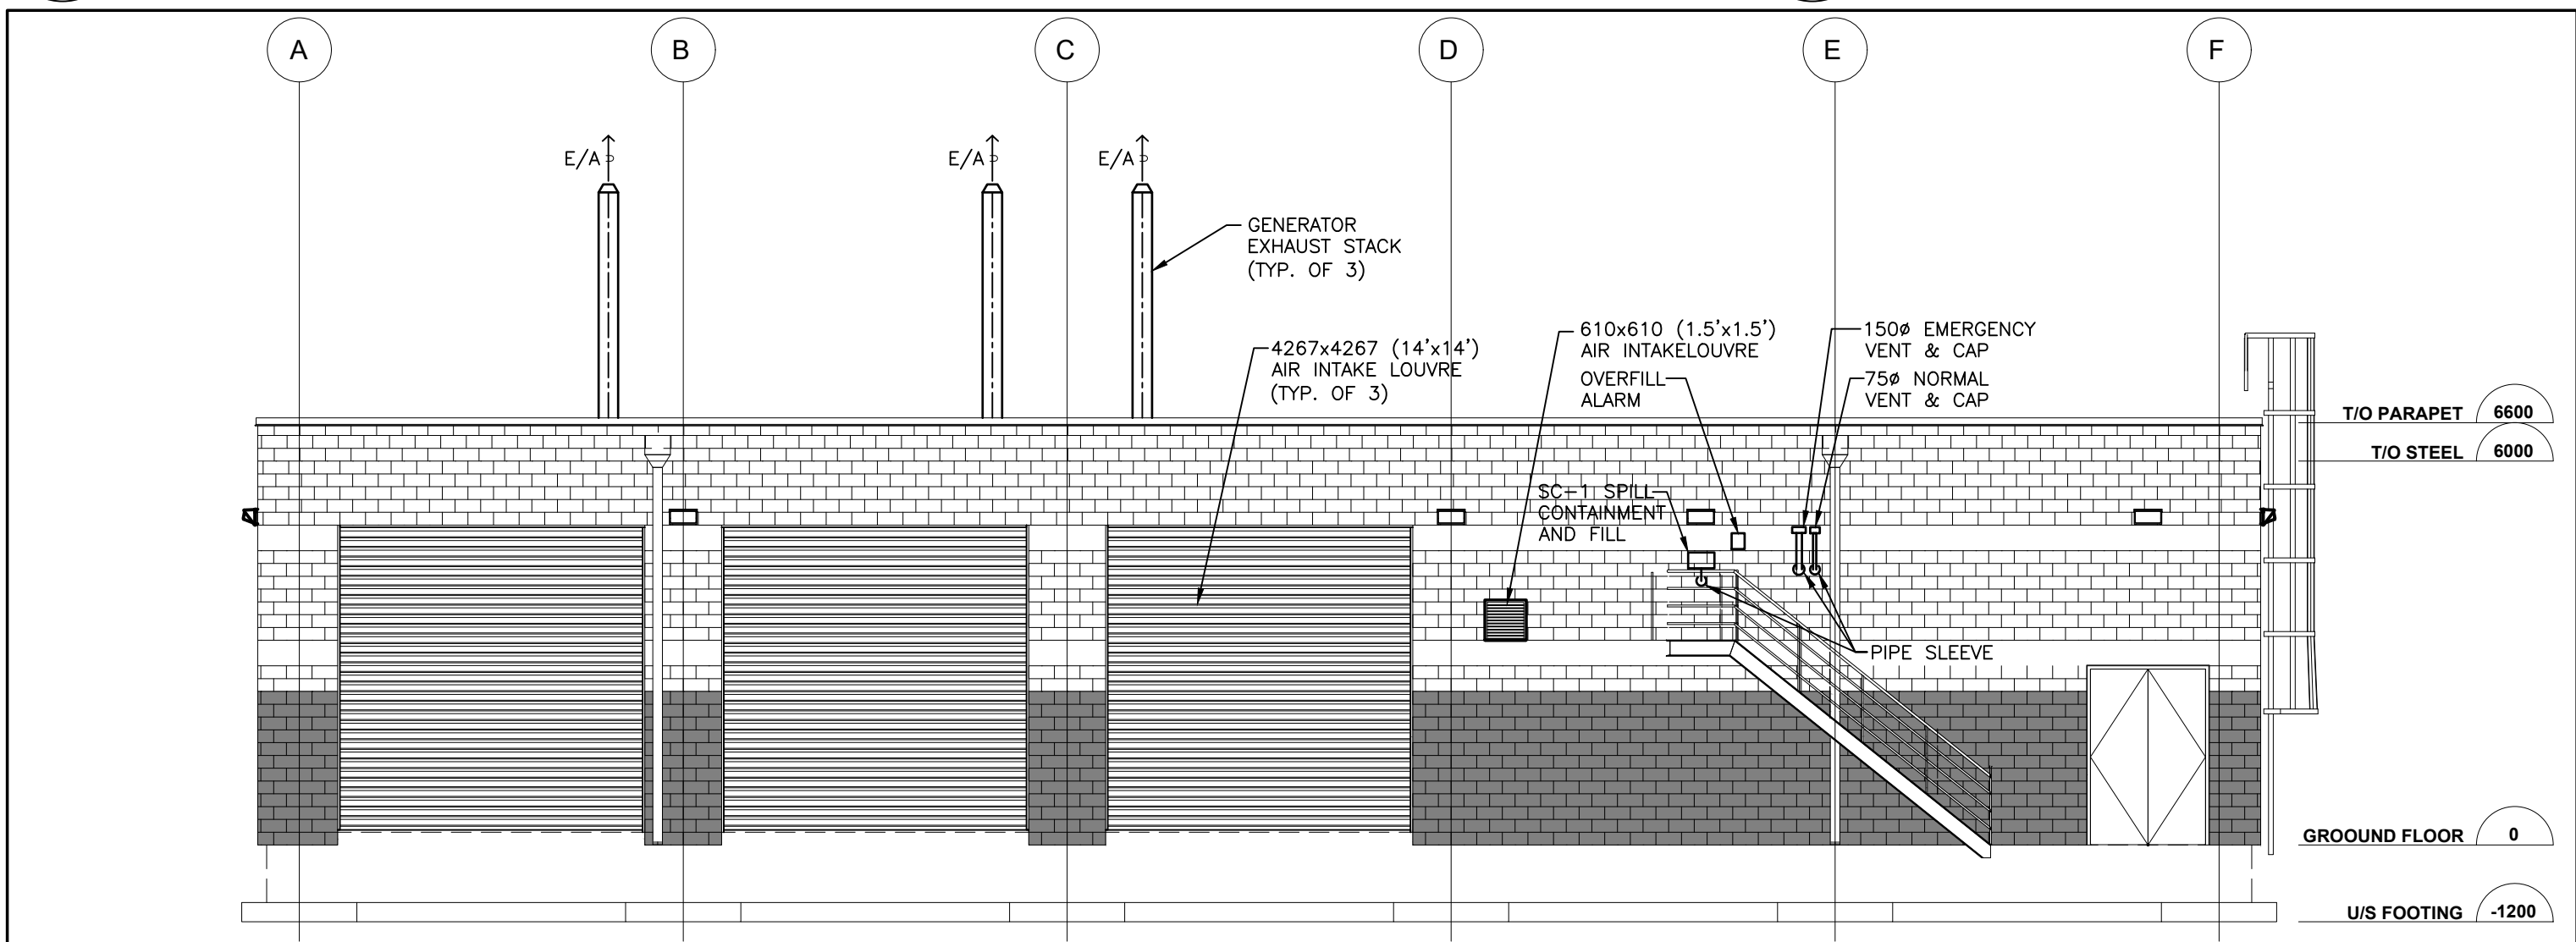


4 SOUTH ELEVATION
M-302 SCALE: 1:100

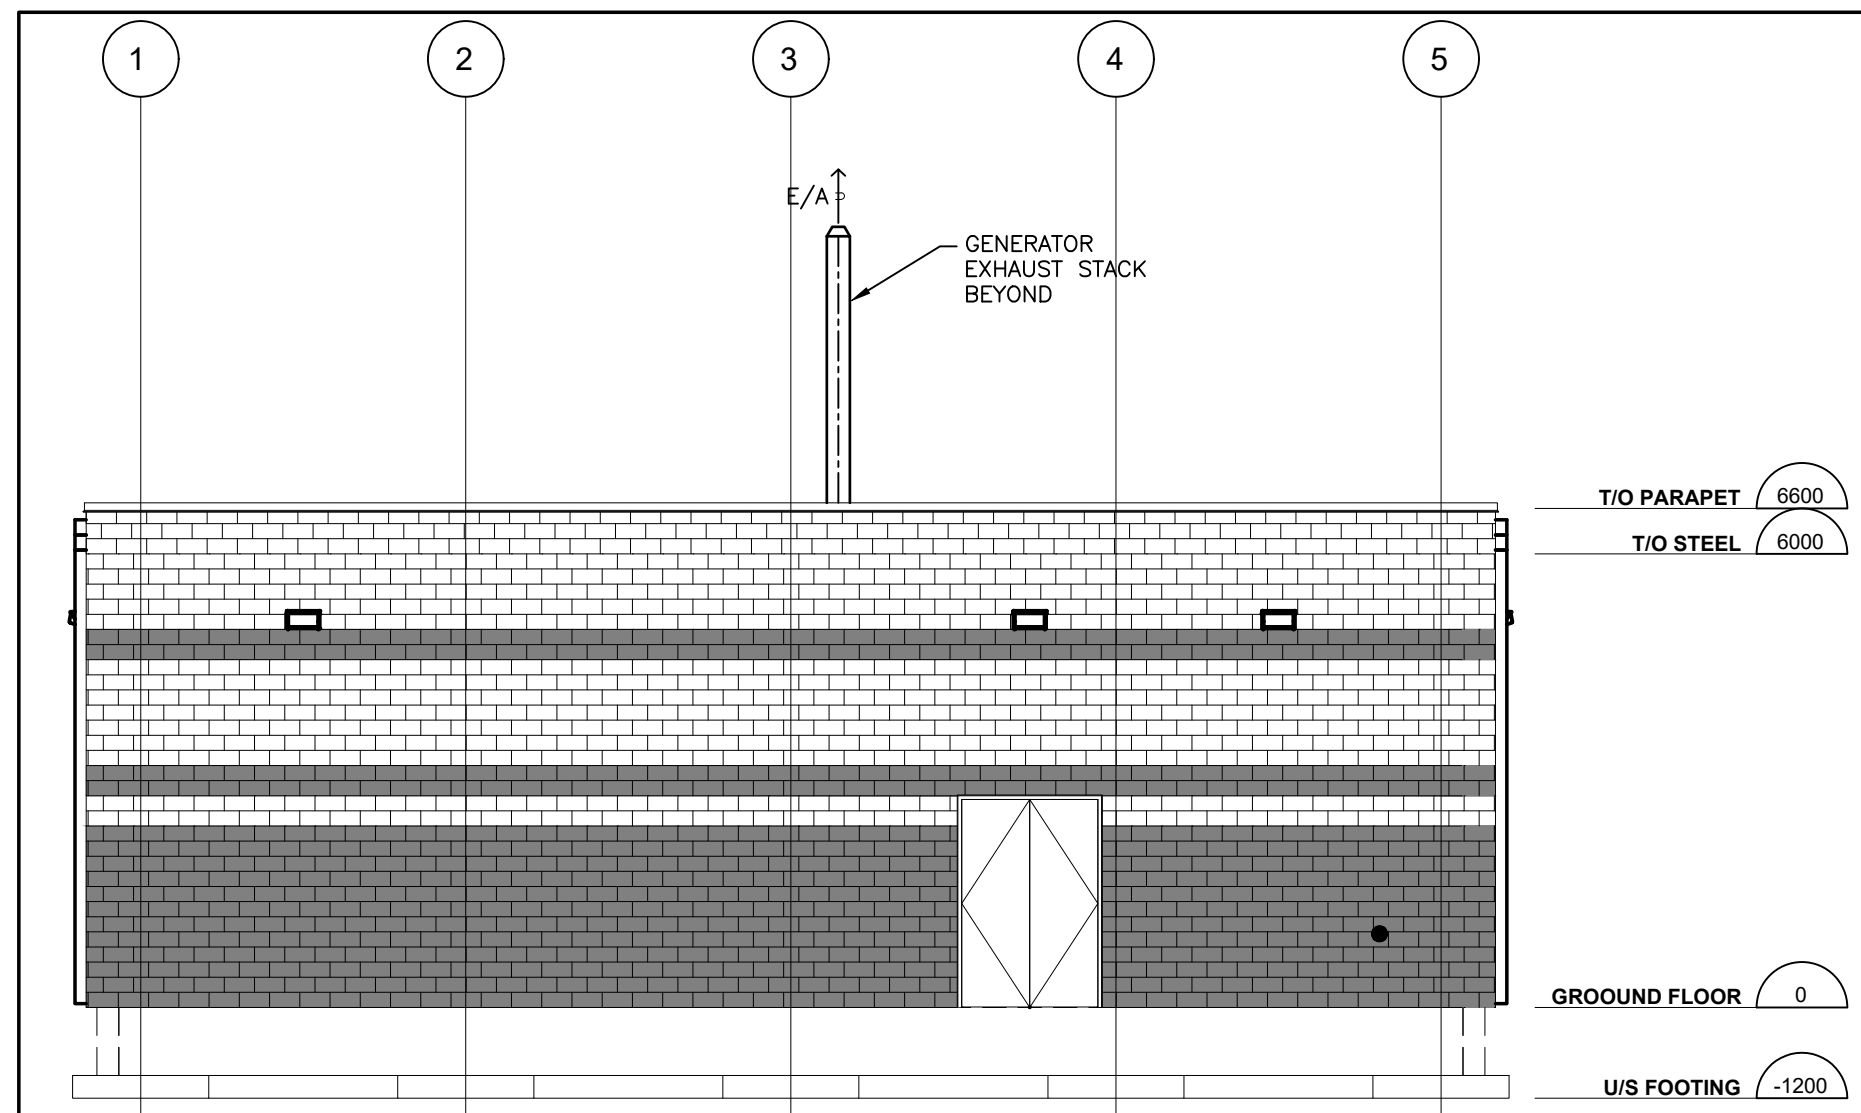

3 WEST ELEVATION
M-302 SCALE: 1:100

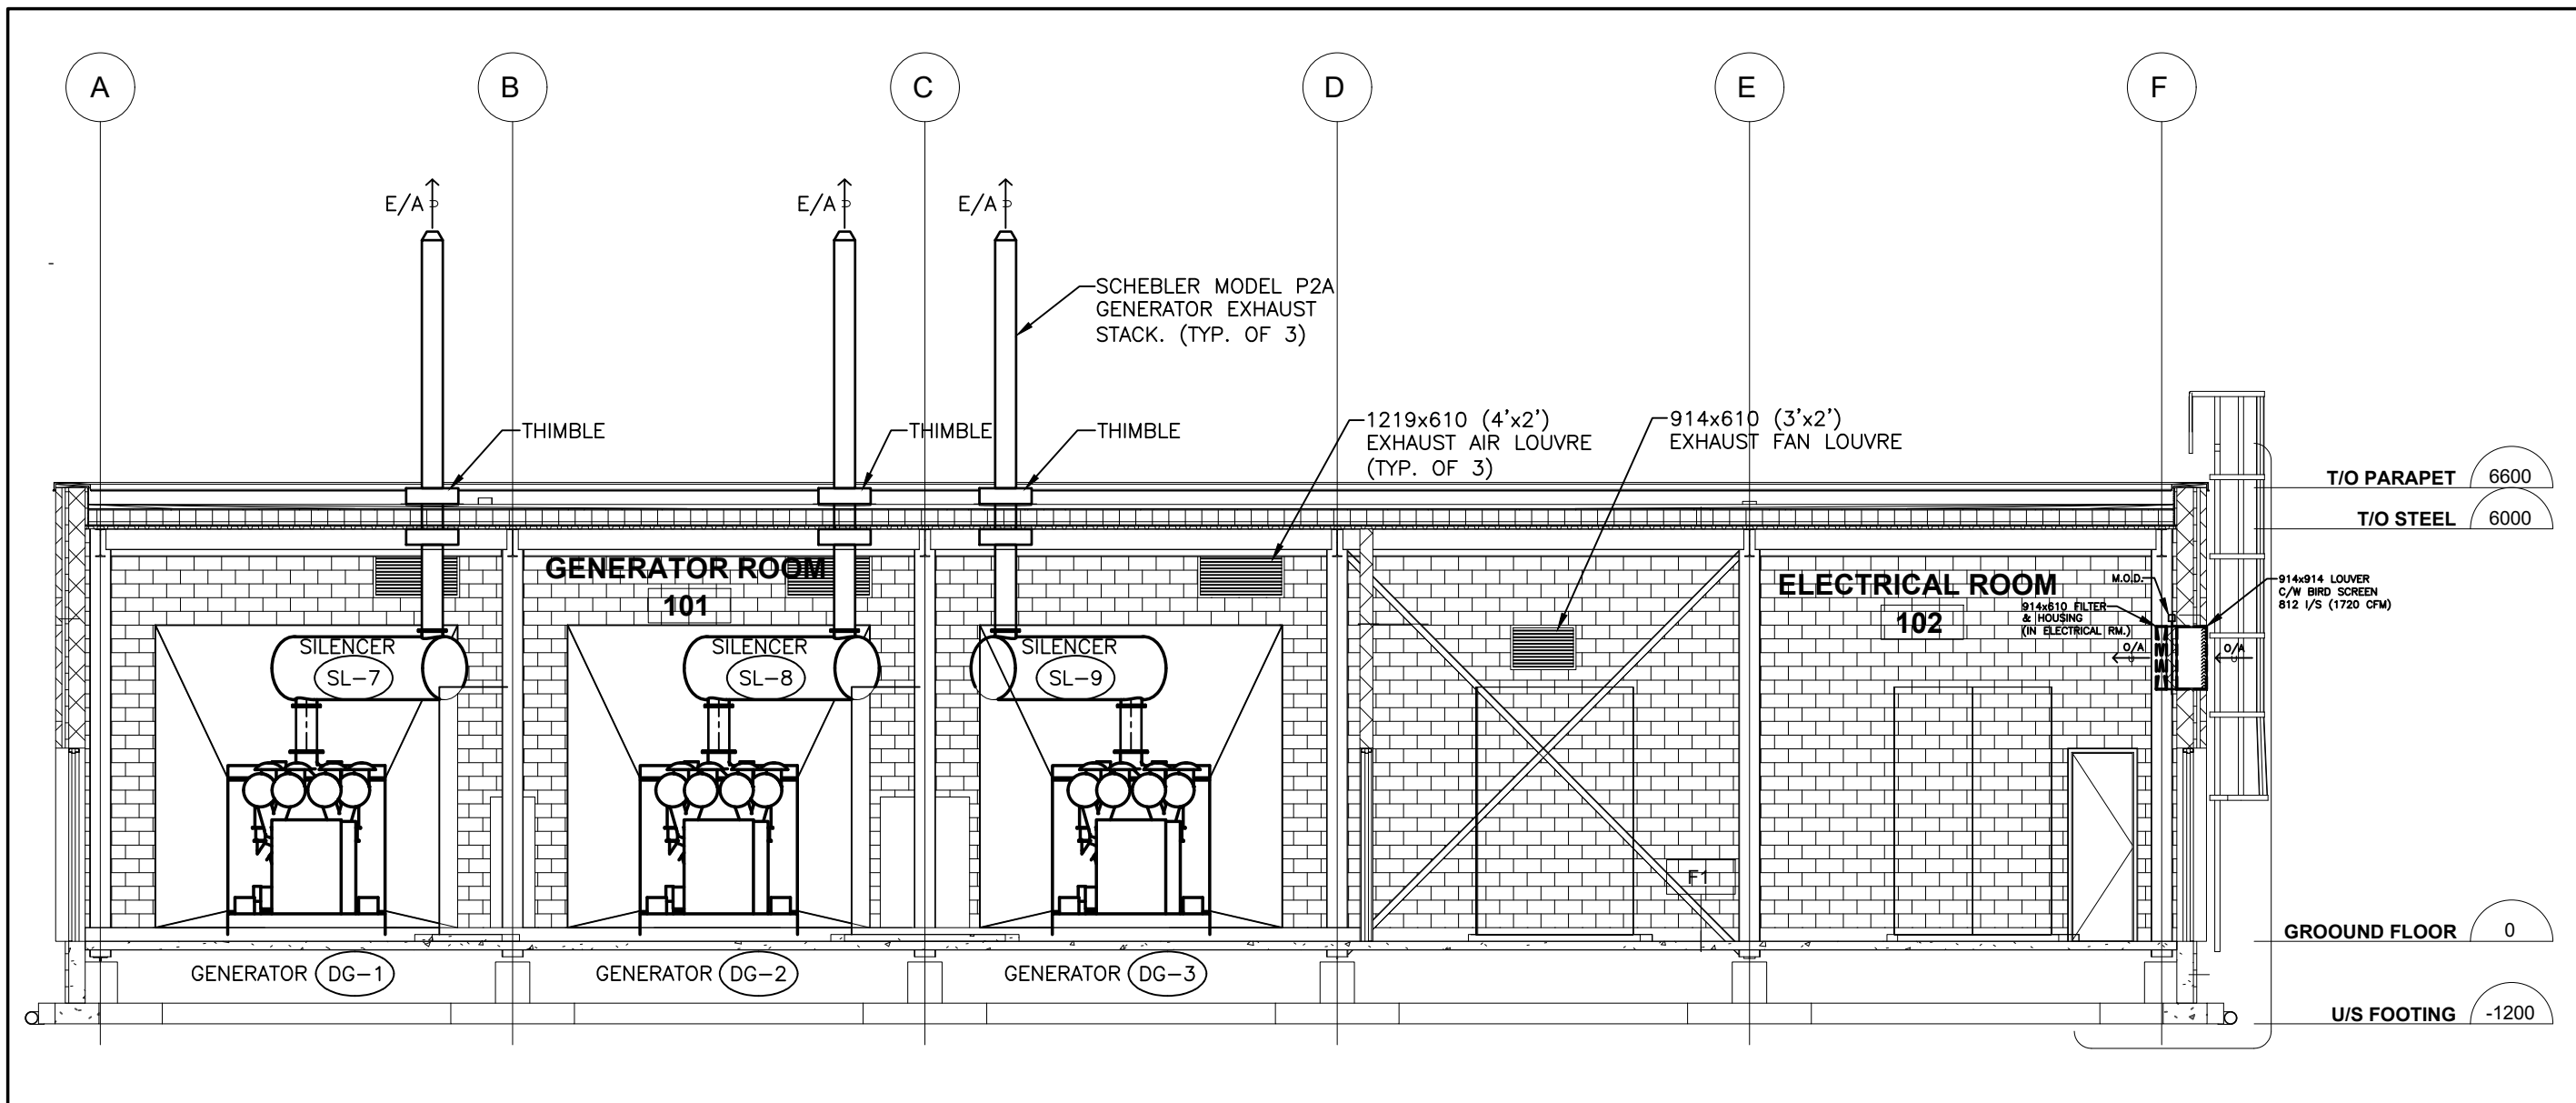

6 SECTION 2
M-302 SCALE: 1:100

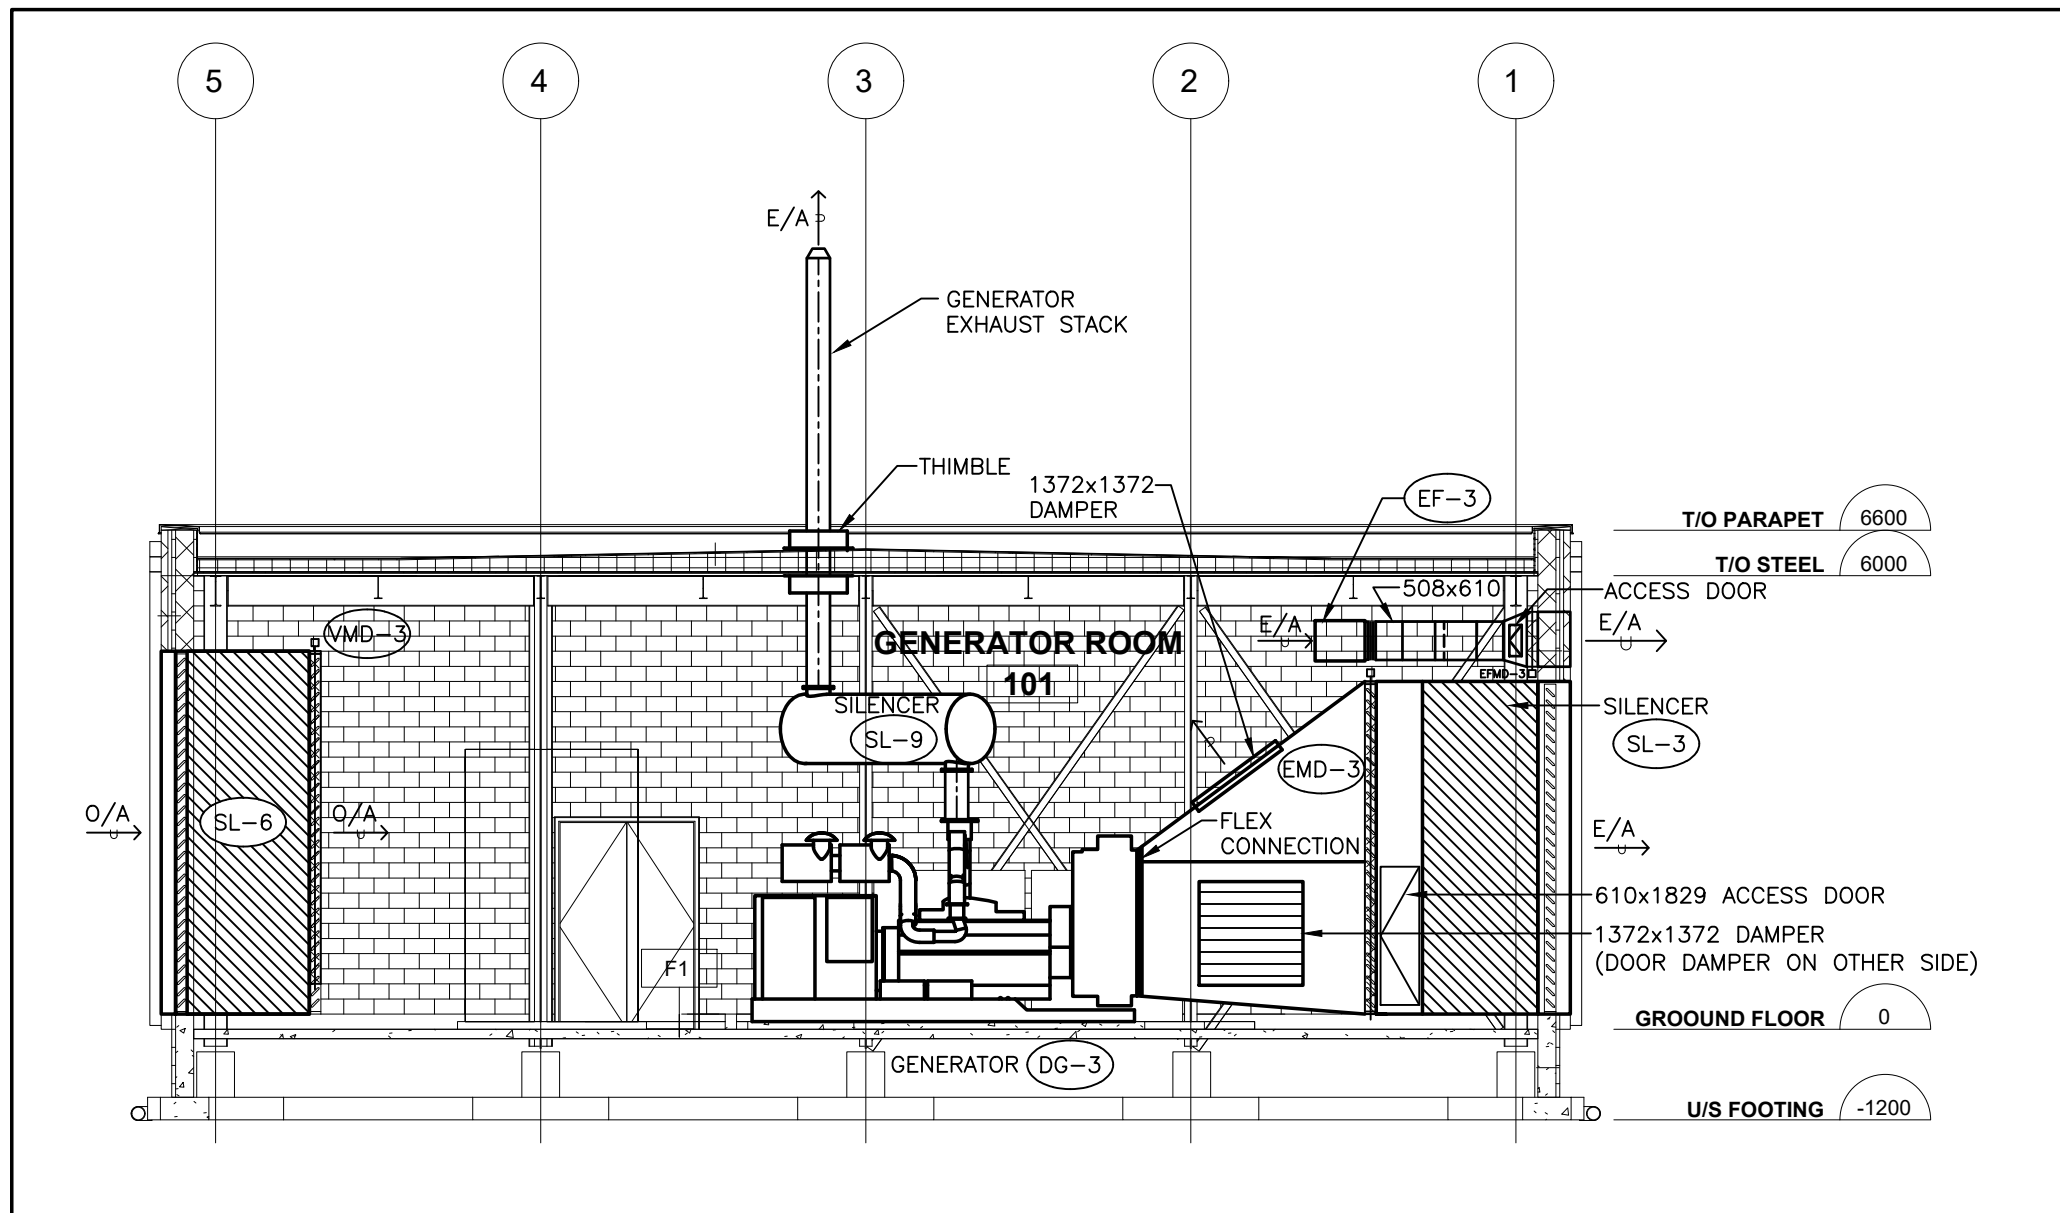

5 SECTION 1
M-302 SCALE: 1:100

Key Plan:

Consultant:

MORRISON HERSHFIELD
Suite 300, 125 Commerce Valley Drive W.
Markham, ON L3T 7W4
Tel: (416) 499-3110 Fax: (416) 499-9658

Seal:

4	ISSUED FOR TENDER	JUN 13/19	GF
3	ISSUED FOR BUILDING PERMIT	JUN 3/ 19	GF
1	ISSUED FOR 100% REVW	APR. 26/19	GF
A	ISSUED FOR CLIENT REVIEW	DEC 13/18	GF
REV	DESCRIPTION	DATE	BY

DO NOT SCALE DRAWINGS. CONTRACTOR MUST VERIFY ALL DIMENSIONS AND ADVISE CONSULTANTS OF ANY ERRORS OR OMISSIONS. NO VARIATIONS OR MODIFICATIONS TO WORK SHOWN SHALL BE IMPLEMENTED WITHOUT PRIOR WRITTEN APPROVAL. ALL PREVIOUS ISSUES OF THIS DRAWING ARE SUPERSEDED BY THE LATEST REVISION. ALL DRAWINGS AND SPECIFICATIONS REMAIN THE PROPERTY OF MORRISON HERSHFIELD LIMITED.

Client:

Ontario Shores
Centre for Mental Health Sciences

Project:


NEW POWERHOUSE
700 GORDON STREET, WHITBY, ON L1N 5S9

Sheet Title:

SECTIONS AND ELEVATIONS

Drawn By:	N.P.	Date:	08/20/18
Designed By:	G.F.	Checked By:	G.F.
Scale:	AS SHOWN	File Path:	B:\2018\1802218 - Ontario Shores Powerhouse\1802218-02-Sections and Elevations\1802218-02-01.dwg
Project No:	1802218	Drawing No:	M-302

BM 362/1/18 - 1802218 - Ontario Shores Powerhouse/1802218-Ontario Shores Powerhouse-REVISED.dwg
6/22/2018 11:07:37 AM

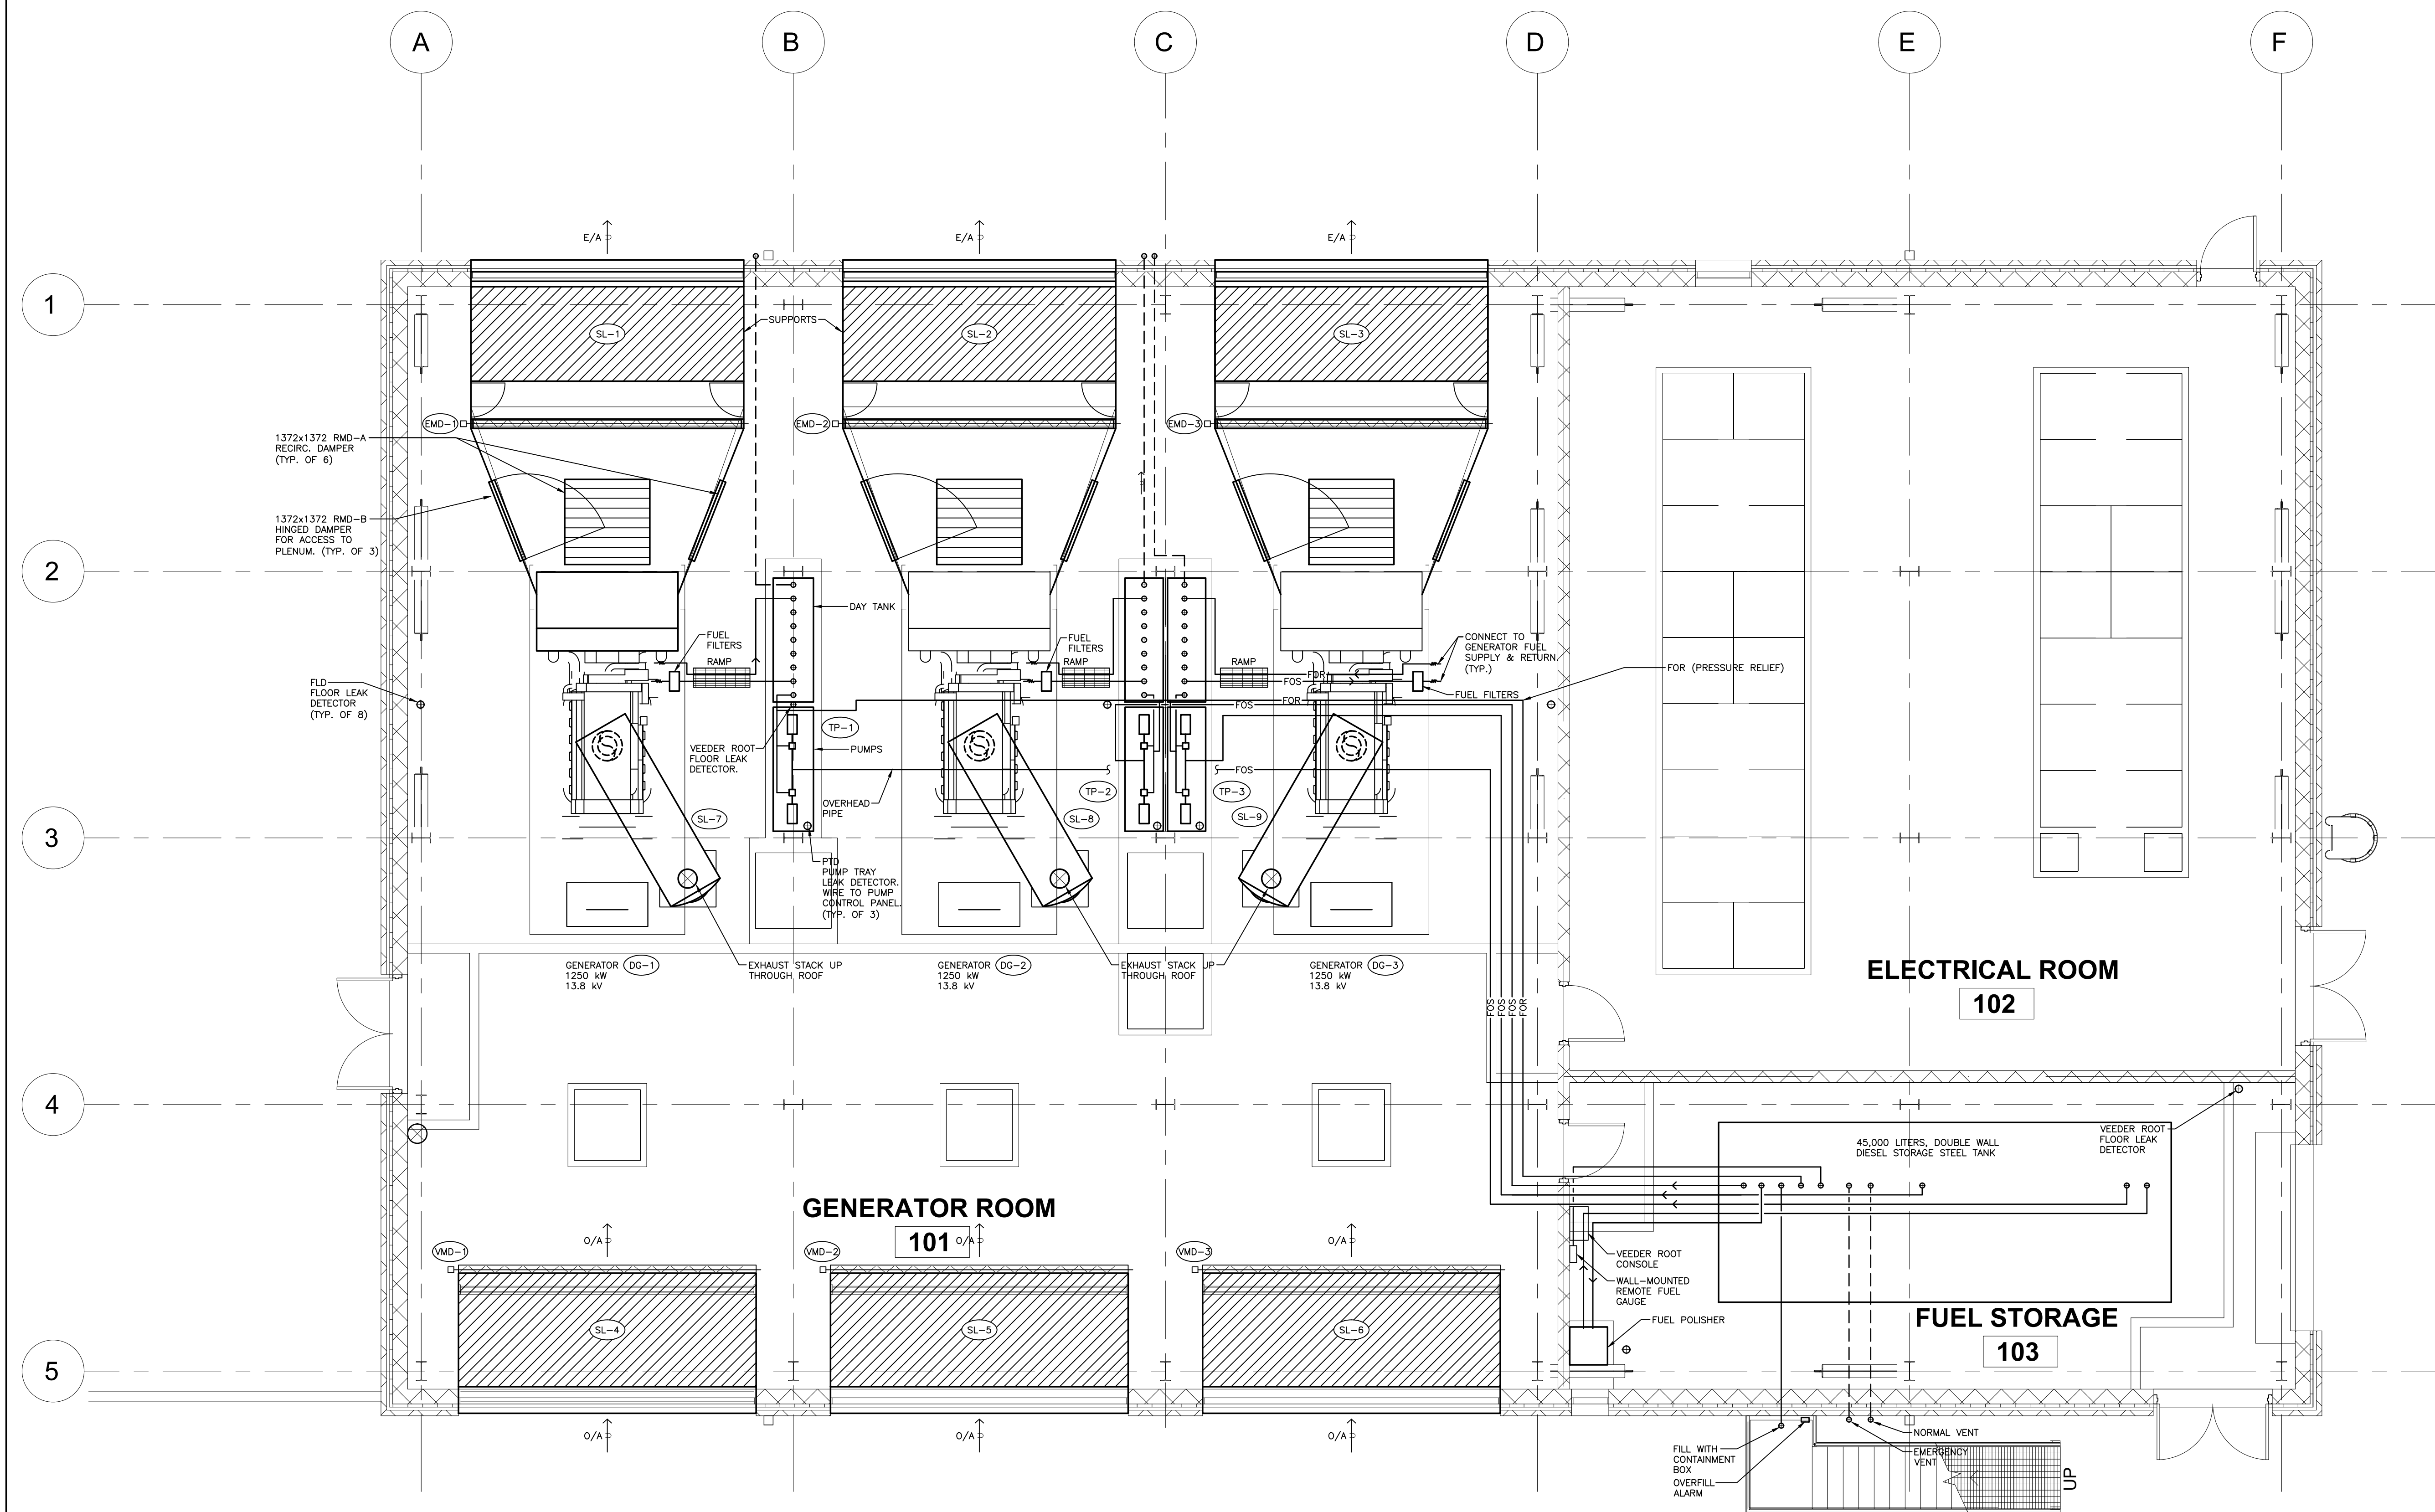


- NOTES:
1. REFER TO FUEL SCHEMATIC 1/M-703 FOR VALVING ARRANGEMENT.
 2. ALL PIPING SHALL BE WELDED WITH FLANGED FITTINGS.
 3. REFER TO FUEL SCHEMATIC 2/M-703 FOR CONTROLS.

Key Plan:

Consultant:

m MORRISON HERSHFIELD
Suite 300, 125 Commerce Valley Drive W.
Markham, ON L3T 7W4
Tel: (416) 499-3110 Fax: (416) 499-9658

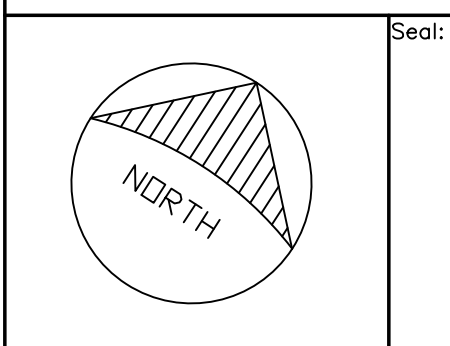

REV	DESCRIPTION	DATE	BY
4	ISSUED FOR TENDER	JUN 13/19	GF
3	ISSUED FOR BUILDING PERMIT	JUN 3/ 19	GF
1	ISSUED FOR 100% REVW	APR. 26/19	GF
A	ISSUED FOR CLIENT REVIEW	DEC 13/18	GF

DO NOT SCALE DRAWINGS. CONTRACTOR MUST VERIFY ALL DIMENSIONS AND ADVISE CONSULTANTS OF ANY ERRORS OR OMISSIONS. NO VARIATIONS OR MODIFICATIONS TO WORK SHOWN SHALL BE IMPLEMENTED WITHOUT PRIOR WRITTEN APPROVAL. ALL PREVIOUS ISSUES OF THIS DRAWING ARE SUPERSEDED BY THE LATEST REVISION. ALL DRAWINGS AND SPECIFICATIONS REMAIN THE PROPERTY OF MORRISON HERSHFIELD LIMITED.

Client:



Project:


NEW POWERHOUSE
700 GORDON STREET, WHITBY, ON L1N 5S9

Sheet Title:

**GENERATOR ROOM -
FUEL PIPE LAYOUT**

Drawn By:	N.P.	Date:	08/20/18
Designed By:	G.F.	Checked By:	G.F.
Scale:	1:50	File Path:	BM 362/1/18 - 1802218 - Ontario Shores Powerhouse/1802218-Ontario Shores Powerhouse-REVISED.dwg
Project No:	1802218	Drawing No:	M-400

BM 362/1/18 - 1802218 - Ontario Shores Powerhouse/1802218-Controls Shores Powerhouse-1802218-4024-v1
6/22/2018 11:07:37 AM

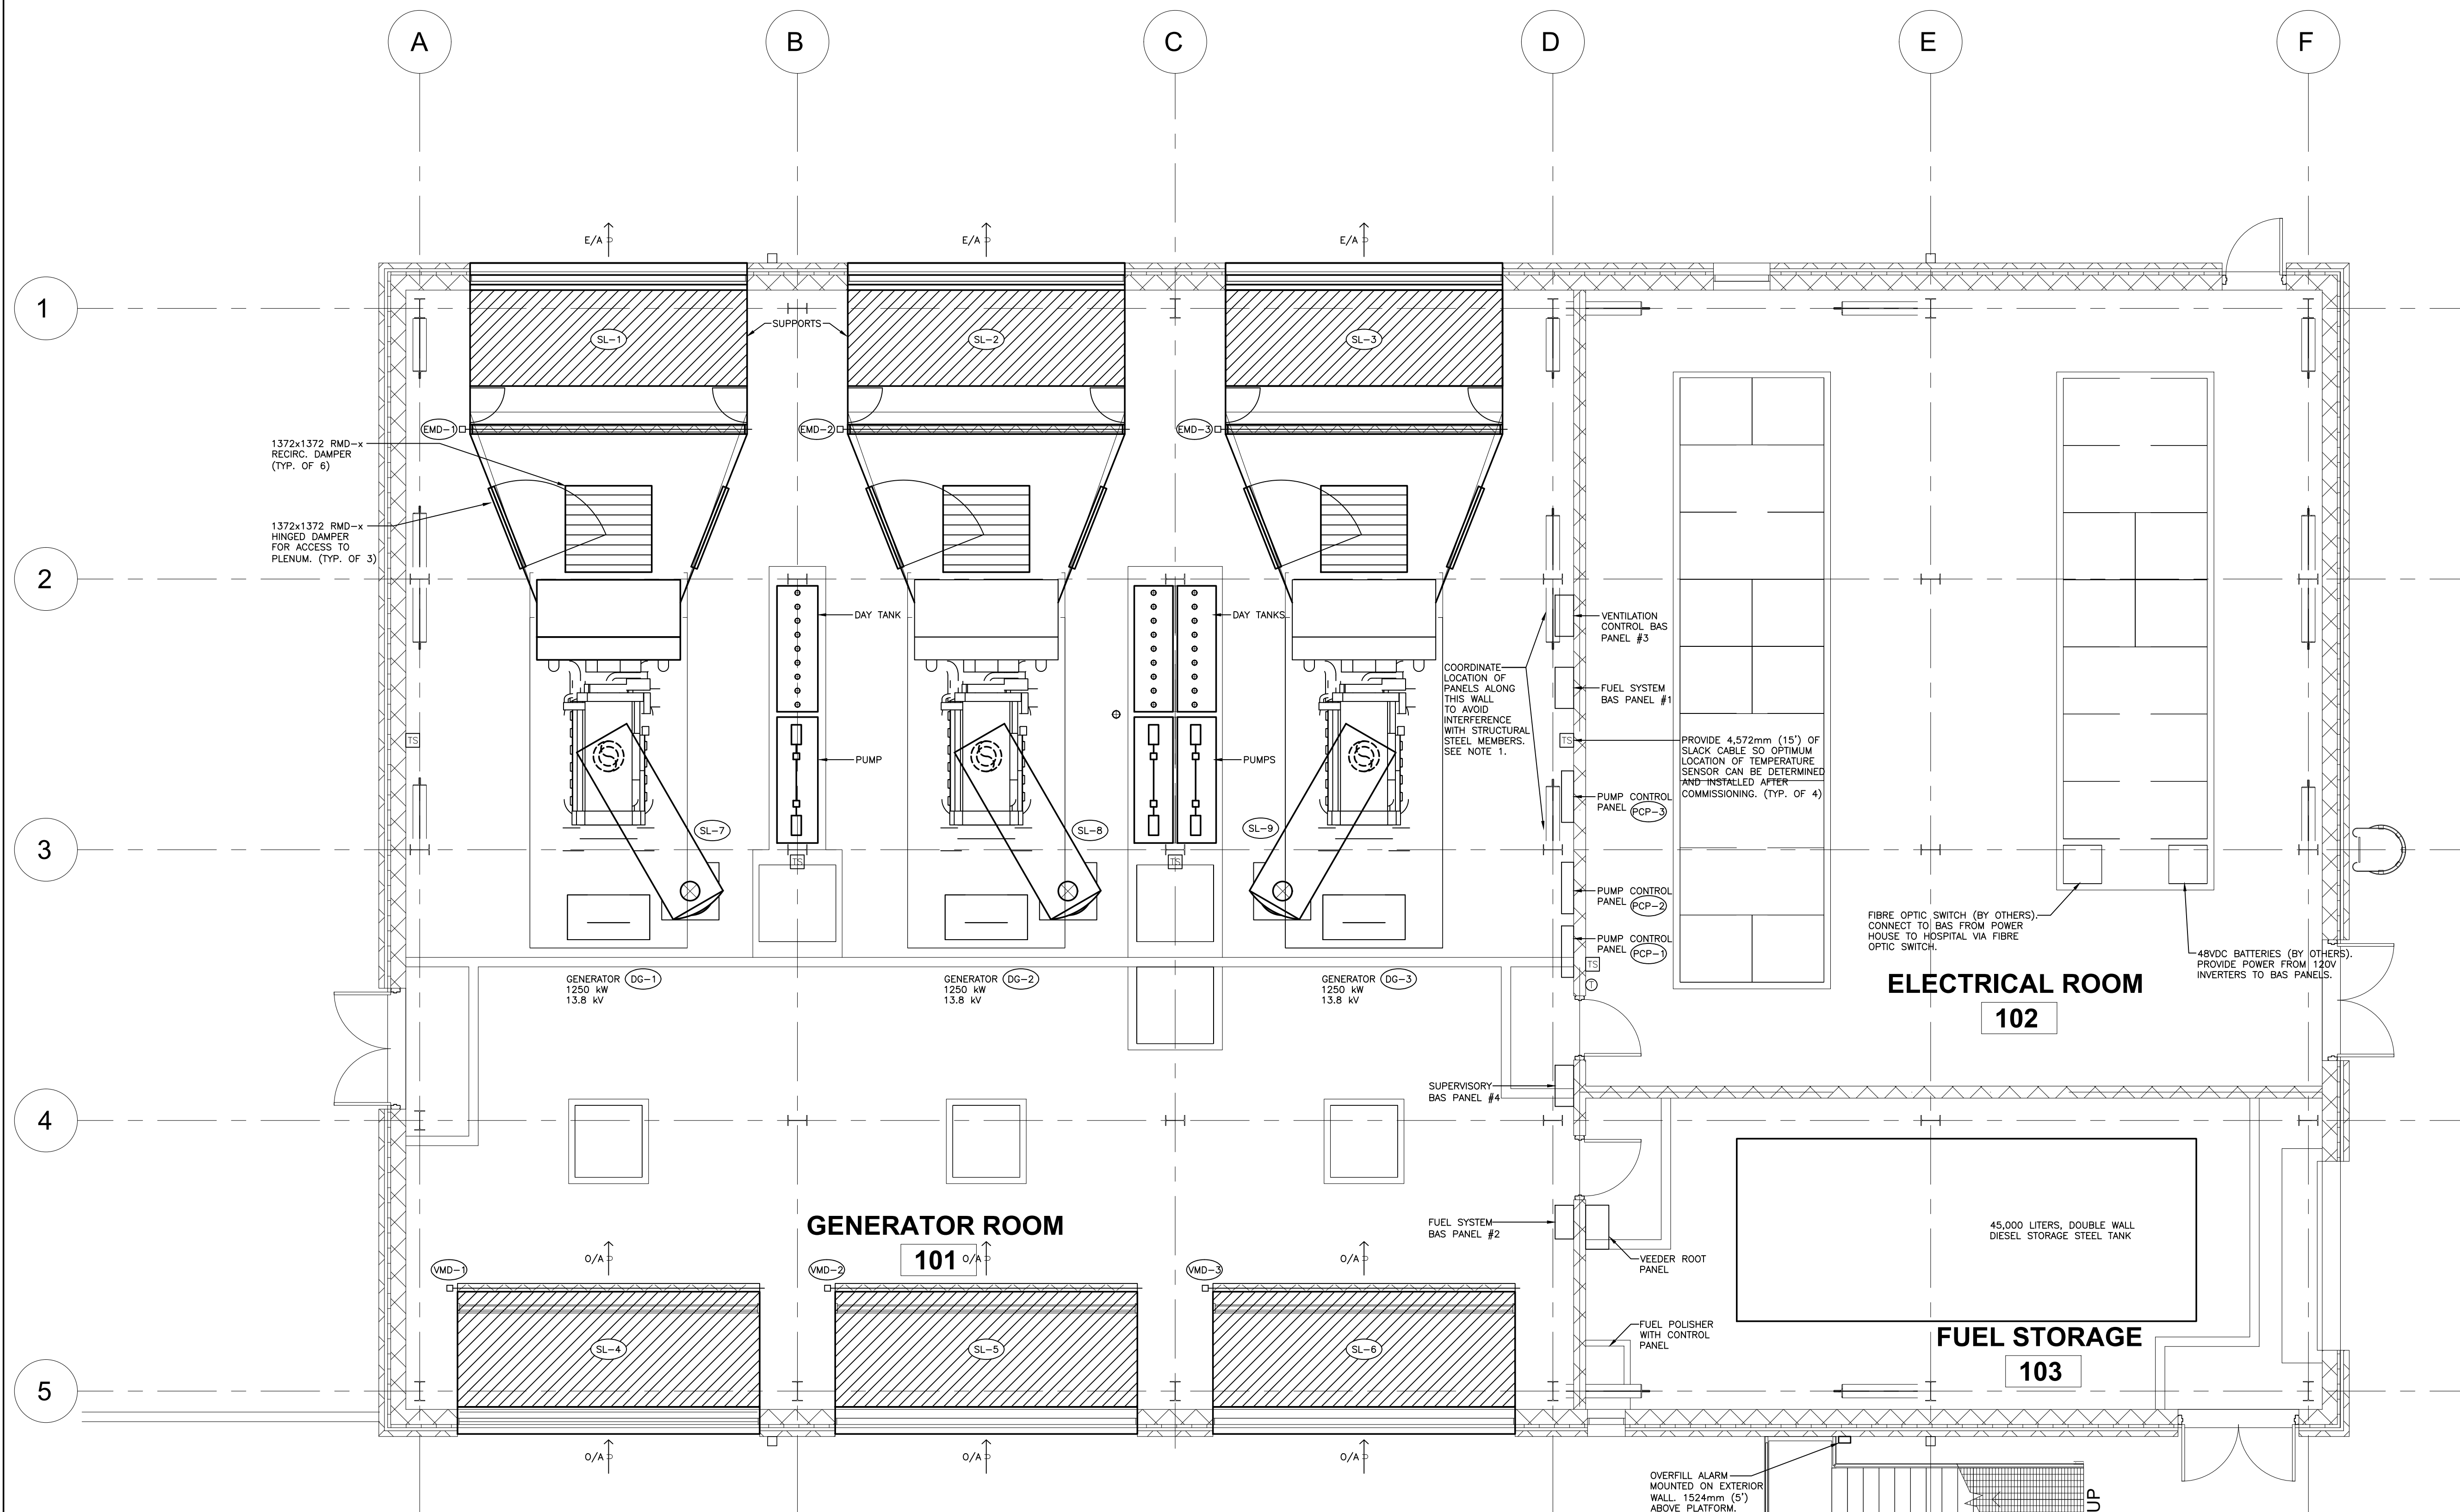


- GENERAL NOTES:
1. THERE ARE TWO SETS OF 48 VDC LITHIUM-ION STATION BATTERIES AVAILABLE (REFER TO ELECTRICAL DRAWINGS). PROVIDE A 48 VDC DUO REDUNDANT POWER SUPPLY FOR THE BAS PANELS TO MAKE USE OF THESE BATTERIES. REFER TO ELECTRICAL DRAWINGS FOR LOCATION OF BATTERIES. PROVIDE ALL WIRING AND COMPONENTS NECESSARY.
 2. PROVIDE 120 VOLT INVERTERS TO POWER BAS PANELS FROM THE BATTERIES. CONNECT TO FIBRE OPTIC ETHERNET SWITCH IN ELECTRICAL ROOM. PROVIDE ALL HARDWARE/SOFTWARE AND PROGRAMMING FOR COMPLETE COMMUNICATION INTERFACE WITH FIBRE OPTICS.
 4. REFER TO DRAWING M-701, M-702 AND M-703 FOR BAS SCHEMATICS AND DETAILS.

Key Plan:

Consultant:



Suite 300, 125 Commerce Valley Drive W.
Markham, ON L3T 7W4
Tel: (416) 499-3110 Fax: (416) 499-9658

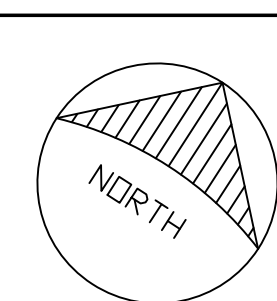

Seal:

4	ISSUED FOR TENDER	JUN 13/19	GF
3	ISSUED FOR BUILDING PERMIT	JUN 3/ 19	GF
1	ISSUED FOR 100% REVIV	APR. 26/19	GF
A	ISSUED FOR CLIENT REVIEW	DEC 13/18	GF
REV	DESCRIPTION	DATE	BY

DO NOT SCALE DRAWINGS. CONTRACTOR MUST VERIFY ALL DIMENSIONS AND ADVISE CONSULTANTS OF ANY ERRORS OR OMISSIONS. NO VARIATIONS OR MODIFICATIONS TO WORK SHOWN SHALL BE IMPLEMENTED WITHOUT PRIOR WRITTEN APPROVAL. ALL PREVIOUS ISSUES OF THIS DRAWING ARE SUPERSEDED BY THE LATEST REVISION. ALL DRAWINGS AND SPECIFICATIONS REMAIN THE PROPERTY OF MORRISON HERSHFIELD LIMITED.

Client:



Project:

NEW POWERHOUSE

700 GORDON STREET, WHITBY, ON L1N 5S9

Sheet Title:


CONTROLS EQUIPMENT LAYOUT

Drawn By: N.P. Date: 08/20/18

Designed By: G.F. Checked By: G.F.


Scale: 1:50 File Path: BM 362/1/18 - 1802218 - Ontario Shores Powerhouse/1802218-Controls Shores Powerhouse-1802218-4024-v1

Project No: 1802218 Drawing No: M-700

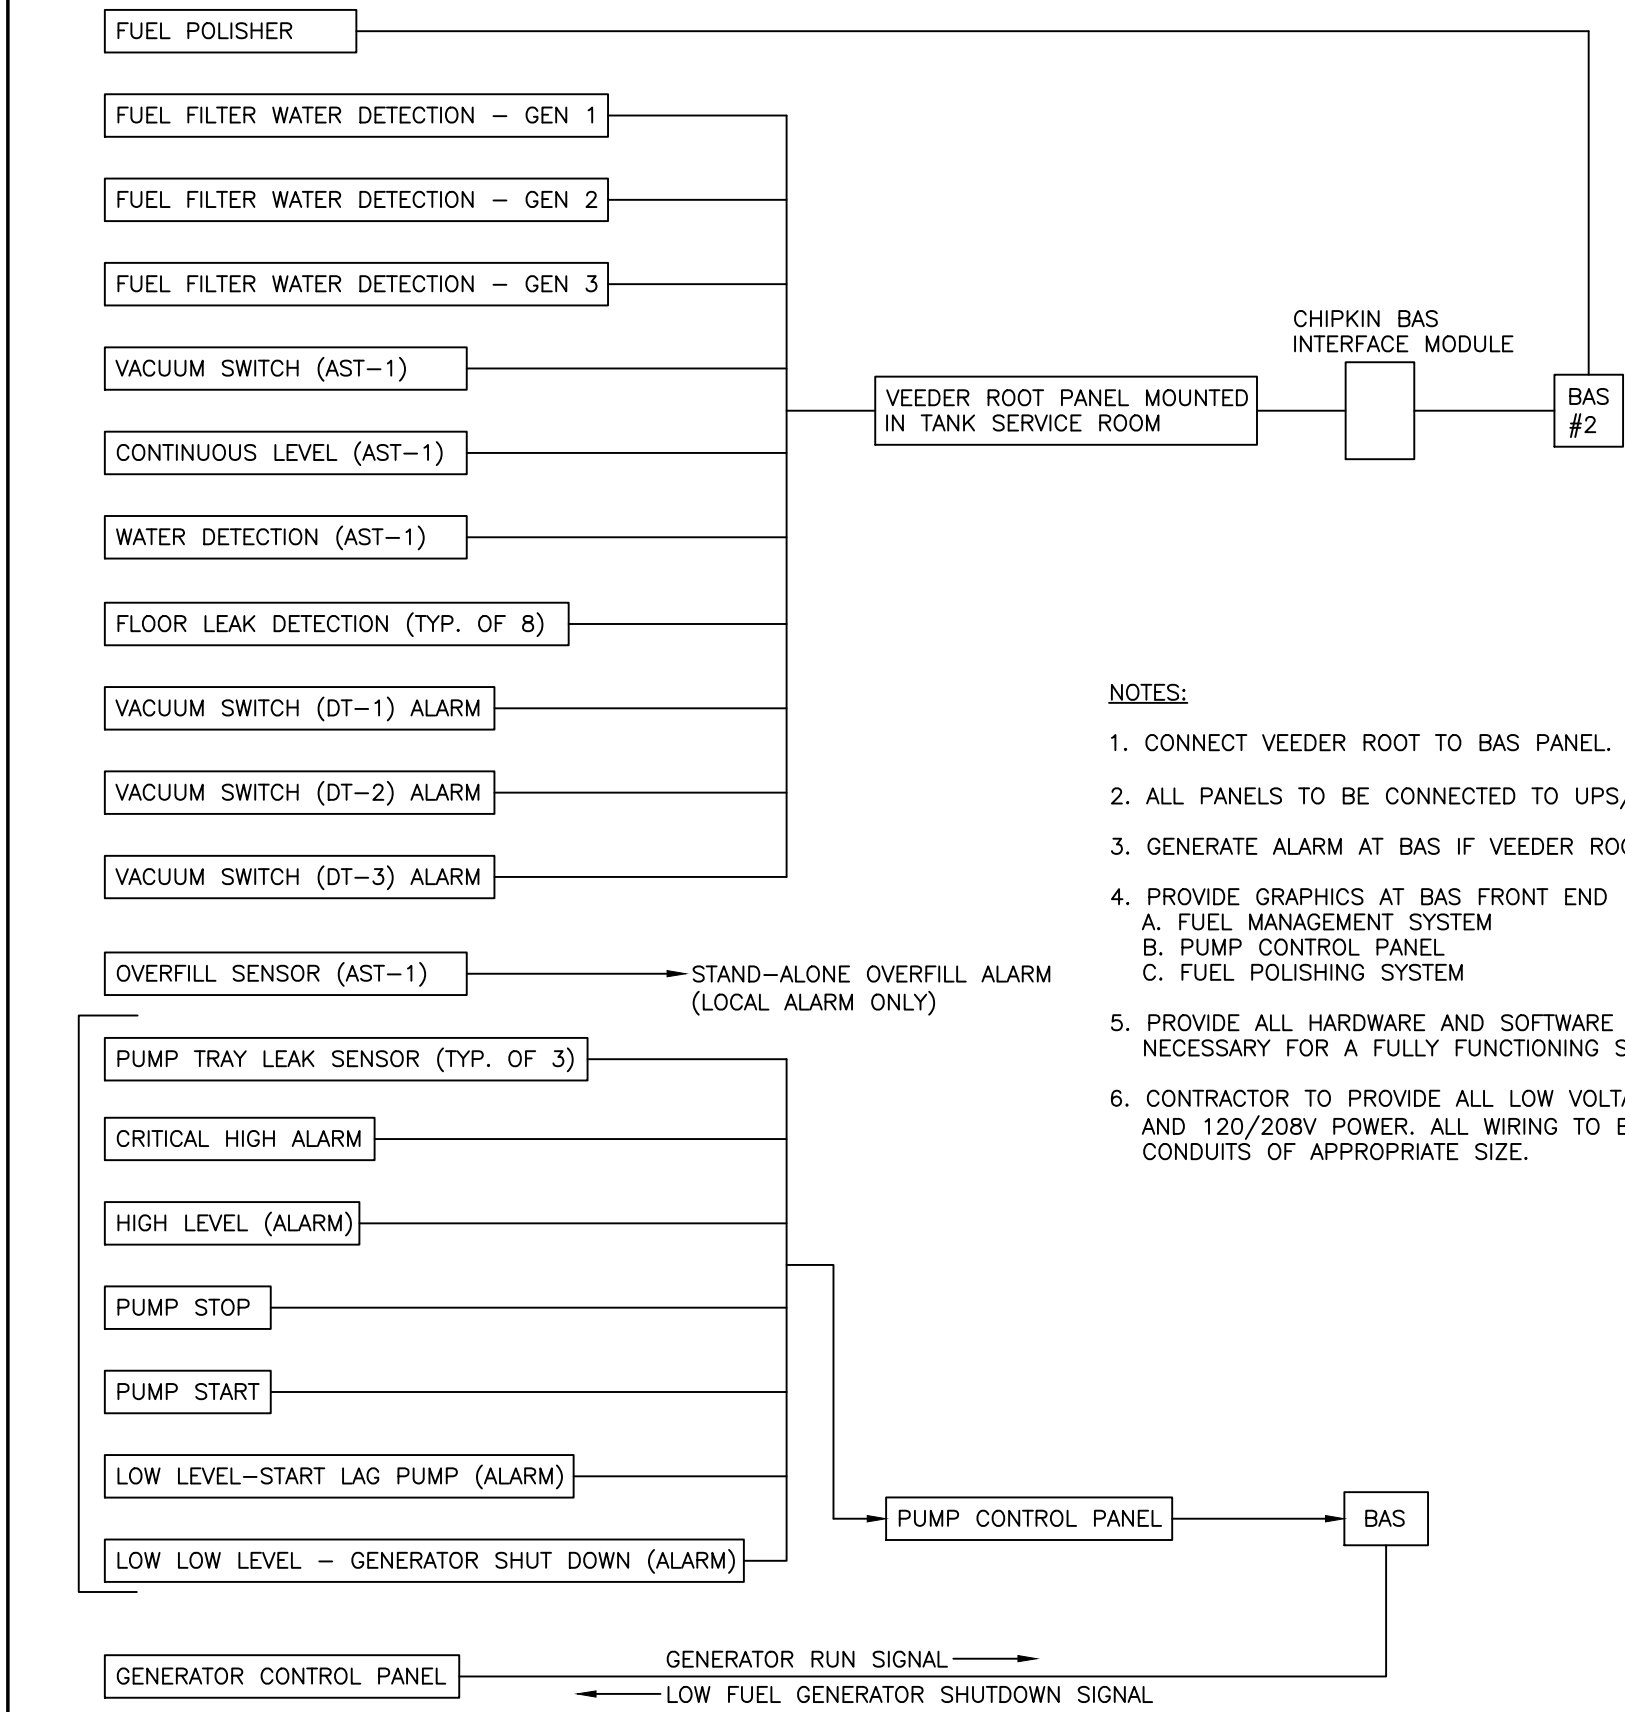


- NOTES:
1. CONNECT VEEDER ROOT TO BAS PANEL.
 2. ALL PANELS TO BE CONNECTED TO UPS/BATTERY POWER.
 3. GENERATE ALARM AT BAS IF VEEDER ROOT CONSOLE FAILS.
 4. PROVIDE GRAPHICS AT BAS FRONT END FOR
A. FUEL MANAGEMENT SYSTEM
B. PUMP CONTROL PANEL
C. FUEL POLISHING SYSTEM
 5. PROVIDE ALL HARDWARE AND SOFTWARE AND PROGRAMMING NECESSARY FOR A FULLY FUNCTIONING SYSTEM.
 6. CONTRACTOR TO PROVIDE ALL LOW VOLTAGE, CONTROL WIRING AND 120/208V POWER, ALL WIRING TO BE INSTALLED IN CONDUITS OF APPROPRIATE SIZE.

2 FUEL SYSTEM CONTROLS ARCHITECTURE
M-701 N.T.S.

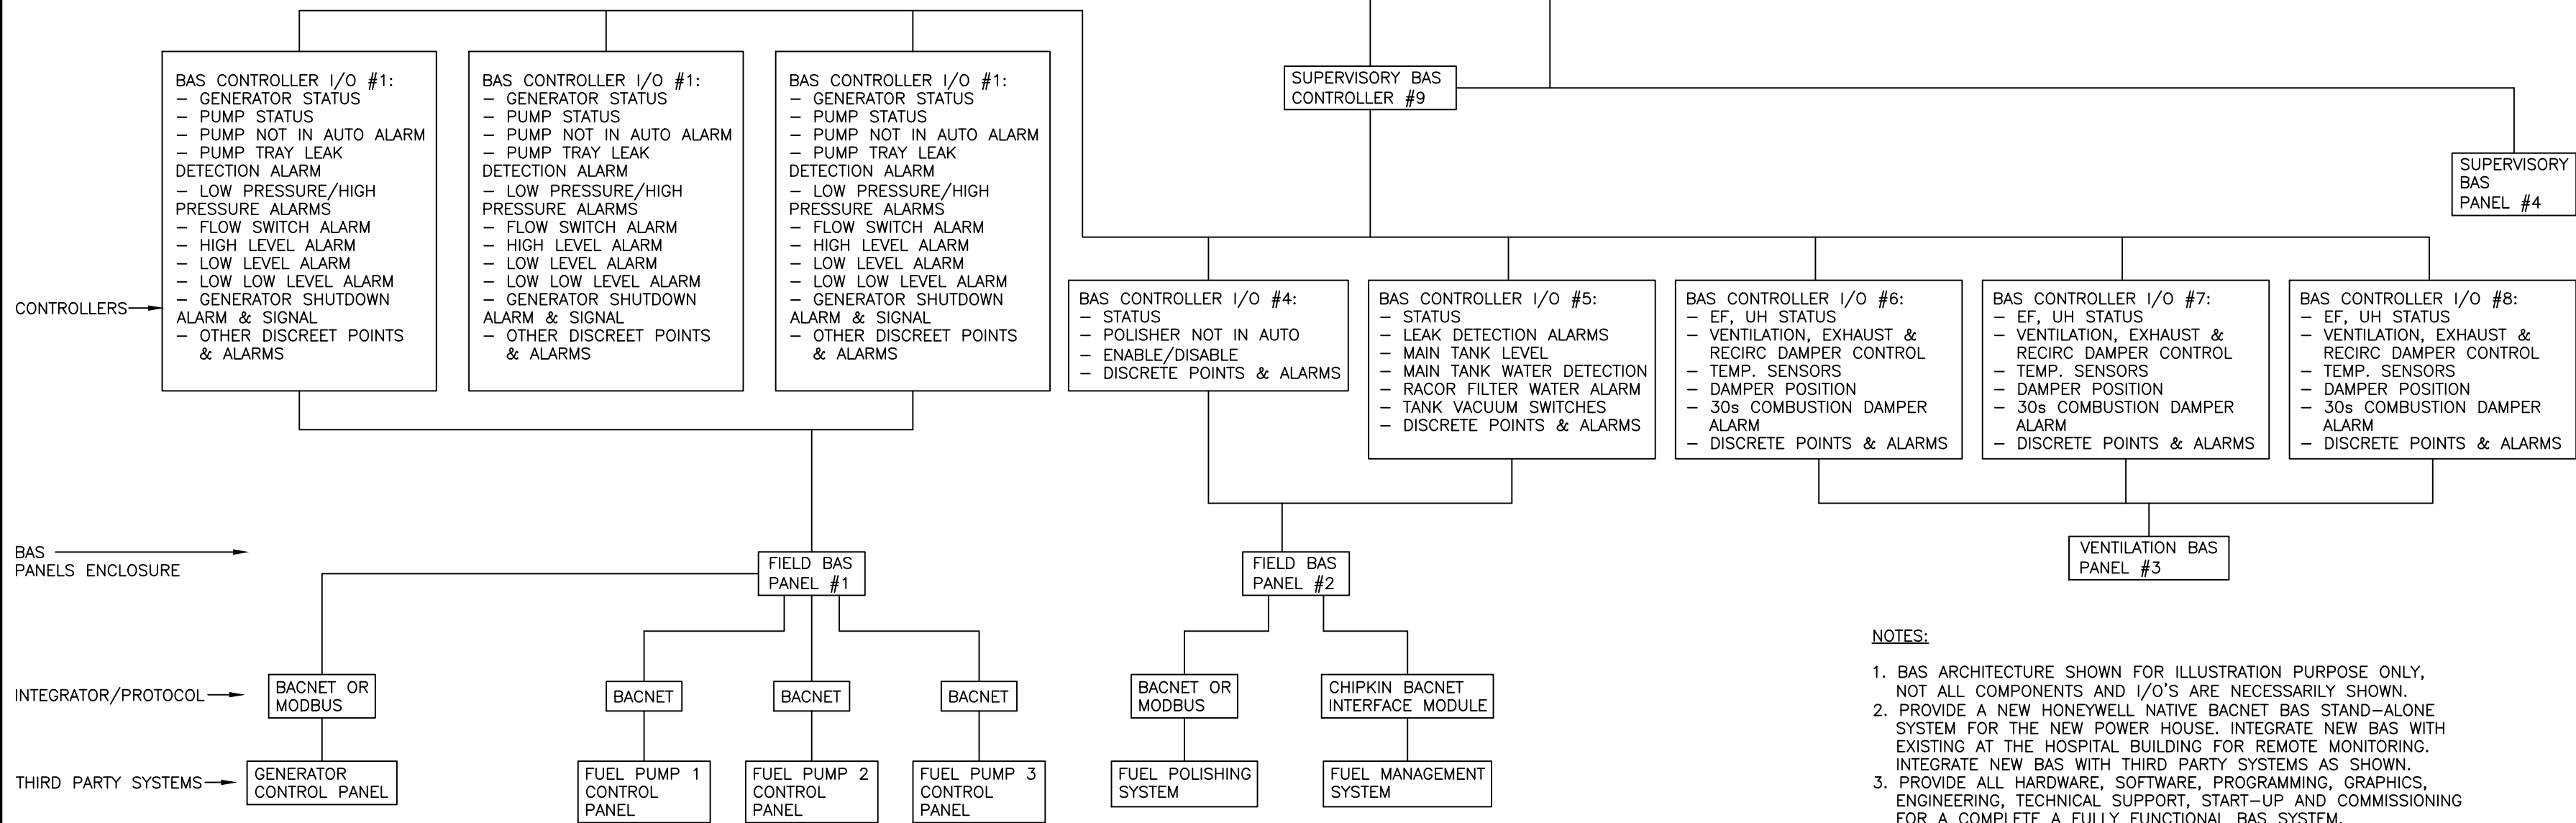

- NOTES:
1. BAS ARCHITECTURE SHOWN FOR ILLUSTRATION PURPOSE ONLY, NOT ALL COMPONENTS AND I/O'S ARE NECESSARILY SHOWN.
 2. PROVIDE A NEW HONEYWELL NATIVE BACNET BAS STAND-ALONE SYSTEM FOR THE NEW POWER HOUSE. INTEGRATE NEW BAS WITH EXISTING AT THE HOSPITAL BUILDING FOR REMOTE MONITORING. INTEGRATE NEW BAS WITH THIRD PARTY SYSTEMS AS SHOWN.
 3. PROVIDE ALL HARDWARE, SOFTWARE, PROGRAMMING, GRAPHICS, ENGINEERING, TECHNICAL SUPPORT, START-UP AND COMMISSIONING FOR A COMPLETE A FULLY FUNCTIONAL BAS SYSTEM.
 4. BAS SHALL PICK-UP ALL DISCRETE ALARMS FROM OTHER THIRD PARTY SYSTEMS SUCH AS BUT NOT LIMITED TO: PUMP CONTROL PANELS, FUEL POLISHER, FUEL MANAGEMENT SYSTEM, ETC.
 5. ALL CONNECTIONS BETWEEN HONEYWELL AND THIRD PARTY SYSTEMS TO BE BACNET MS/TIP OR BACNET IP SO THAT ALL POINTS ARE VISIBLE AT FRONT END, INDIVIDUAL POINTS CAN BE MONITORED/CONTROLLED AND DISCRETE ALARMS RECEIVED.
 6. FIBRE OPTIC TERMINATION IS LOCATED IN THE POWER HOUSE ELECTRICAL ROOM AND HOSPITAL BUILDING 1/2 ELECTRICAL ROOM.
 7. HONEYWELL TO PROVIDE REQUIRED HARDWARE/SOFTWARE AND PROGRAMMING INTERFACE BETWEEN THE BAS PANELS AND THE FIBRE OPTIC TERMINATION. THE SAME APPLIES AT THE HOSPITAL END WHERE THE FIBRE OPTIC TERMINATION IS LOCATED IN BUILDING 1/2 ELECTRICAL ROOM.
 8. ALL WIRING UNLESS NOTED OTHERWISE IS THE RESPONSIBILITY OF THE BAS CONTRACTOR. ALL WIRING SHALL BE IN CONDUITS OF APPROPRIATE SIZE.
 9. PROVIDE COMPLETE GRAPHICS PACKAGE AT THE HOSPITAL BAS FOR MECHANICAL EQUIPMENT ADDED IN POWER HOUSE.
 10. PROVIDE SPARE I/Os IN BAS PANELS FOR FUTURE USE.
 11. MAKE ALLOWANCE FOR ADDITIONAL POINTS (I/O & ALARMS) NOT SHOWN.
 12. CONTACT VIDA SAFARI AT HONEYWELL - VIDA.SAFARI@HONEYWELL.COM

1 BAS ARCHITECTURE
M-701 N.T.S.

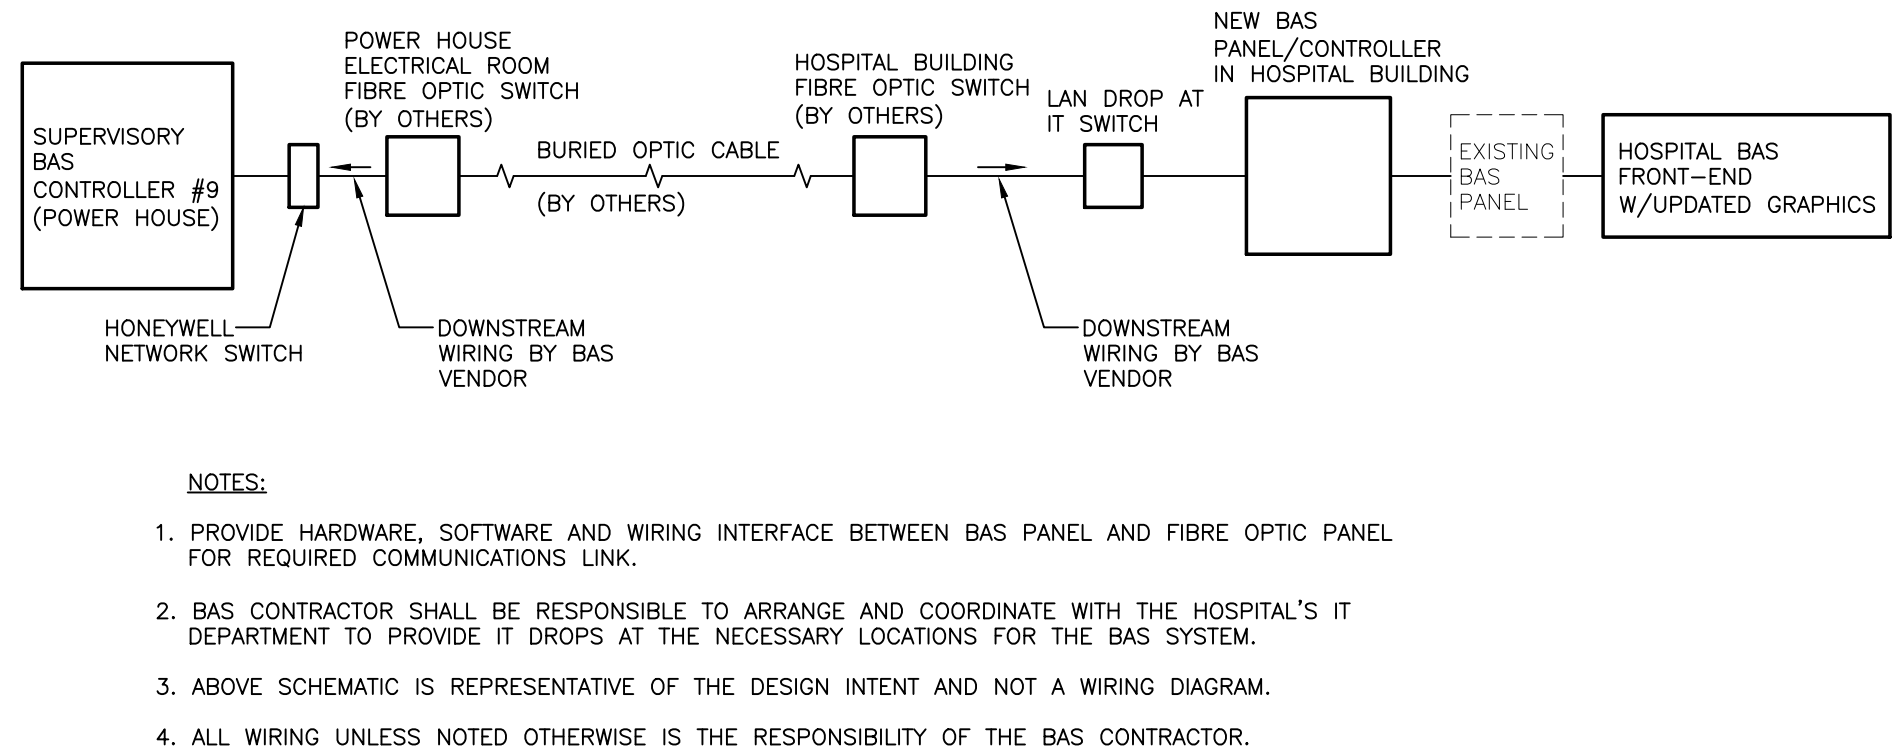

- NOTES:
1. PROVIDE HARDWARE, SOFTWARE AND WIRING INTERFACE BETWEEN BAS PANEL AND FIBRE OPTIC PANEL FOR REQUIRED COMMUNICATIONS LINK.
 2. BAS CONTRACTOR SHALL BE RESPONSIBLE TO ARRANGE AND COORDINATE WITH THE HOSPITAL'S IT DEPARTMENT TO PROVIDE IT DROPS AT THE NECESSARY LOCATIONS FOR THE BAS SYSTEM.
 3. ABOVE SCHEMATIC IS REPRESENTATIVE OF THE DESIGN INTENT AND NOT A WIRING DIAGRAM.
 4. ALL WIRING UNLESS NOTED OTHERWISE IS THE RESPONSIBILITY OF THE BAS CONTRACTOR.

3 BAS COMMUNICATION LINK BETWEEN NEW POWER HOUSE AND HOSPITAL
M-701 N.T.S.

Key Plan:

Consultant:



Suite 300, 125 Commerce Valley Drive W.
Markham, ON L3T 7W4
Tel: (416) 499-3110 Fax: (416) 499-9658

Seal:

4	ISSUED FOR TENDER	JUN 13/19	GF
3	ISSUED FOR BUILDING PERMIT	JUN 3/ 19	GF
1	ISSUED FOR 100% REVW	APR. 26/19	GF
A	ISSUED FOR CLIENT REVIEW	DEC 13/18	GF
REV	DESCRIPTION	DATE	BY

DO NOT SCALE DRAWINGS. CONTRACTOR MUST VERIFY ALL DIMENSIONS AND ADVISE CONSULTANTS OF ANY ERRORS OR OMISSIONS. NO VARIATIONS OR MODIFICATIONS TO WORK SHOWN SHALL BE IMPLEMENTED WITHOUT PRIOR WRITTEN APPROVAL. ALL PREVIOUS ISSUES OF THIS DRAWING ARE SUPERSEDED BY THE LATEST REVISION. ALL DRAWINGS AND SPECIFICATIONS REMAIN THE PROPERTY OF MORRISON HERSHFIELD LIMITED.

Client:



Project:


NEW POWERHOUSE

700 GORDON STREET, WHITBY, ON L1N 5S9


Sheet Title:

CONTROLS


Drawn By:	N.P.	Date:	08/20/18
Designed By:	G.F.	Checked By:	G.F.
Scale:	N.T.S.	File Path:	B:\2018\1802218 - Ontario Shores Powerhouse\1802218 Controls (Shores Powerhouse-W701-BAS-01.dwg)
Project No:	1802218	Drawing No:	M-701

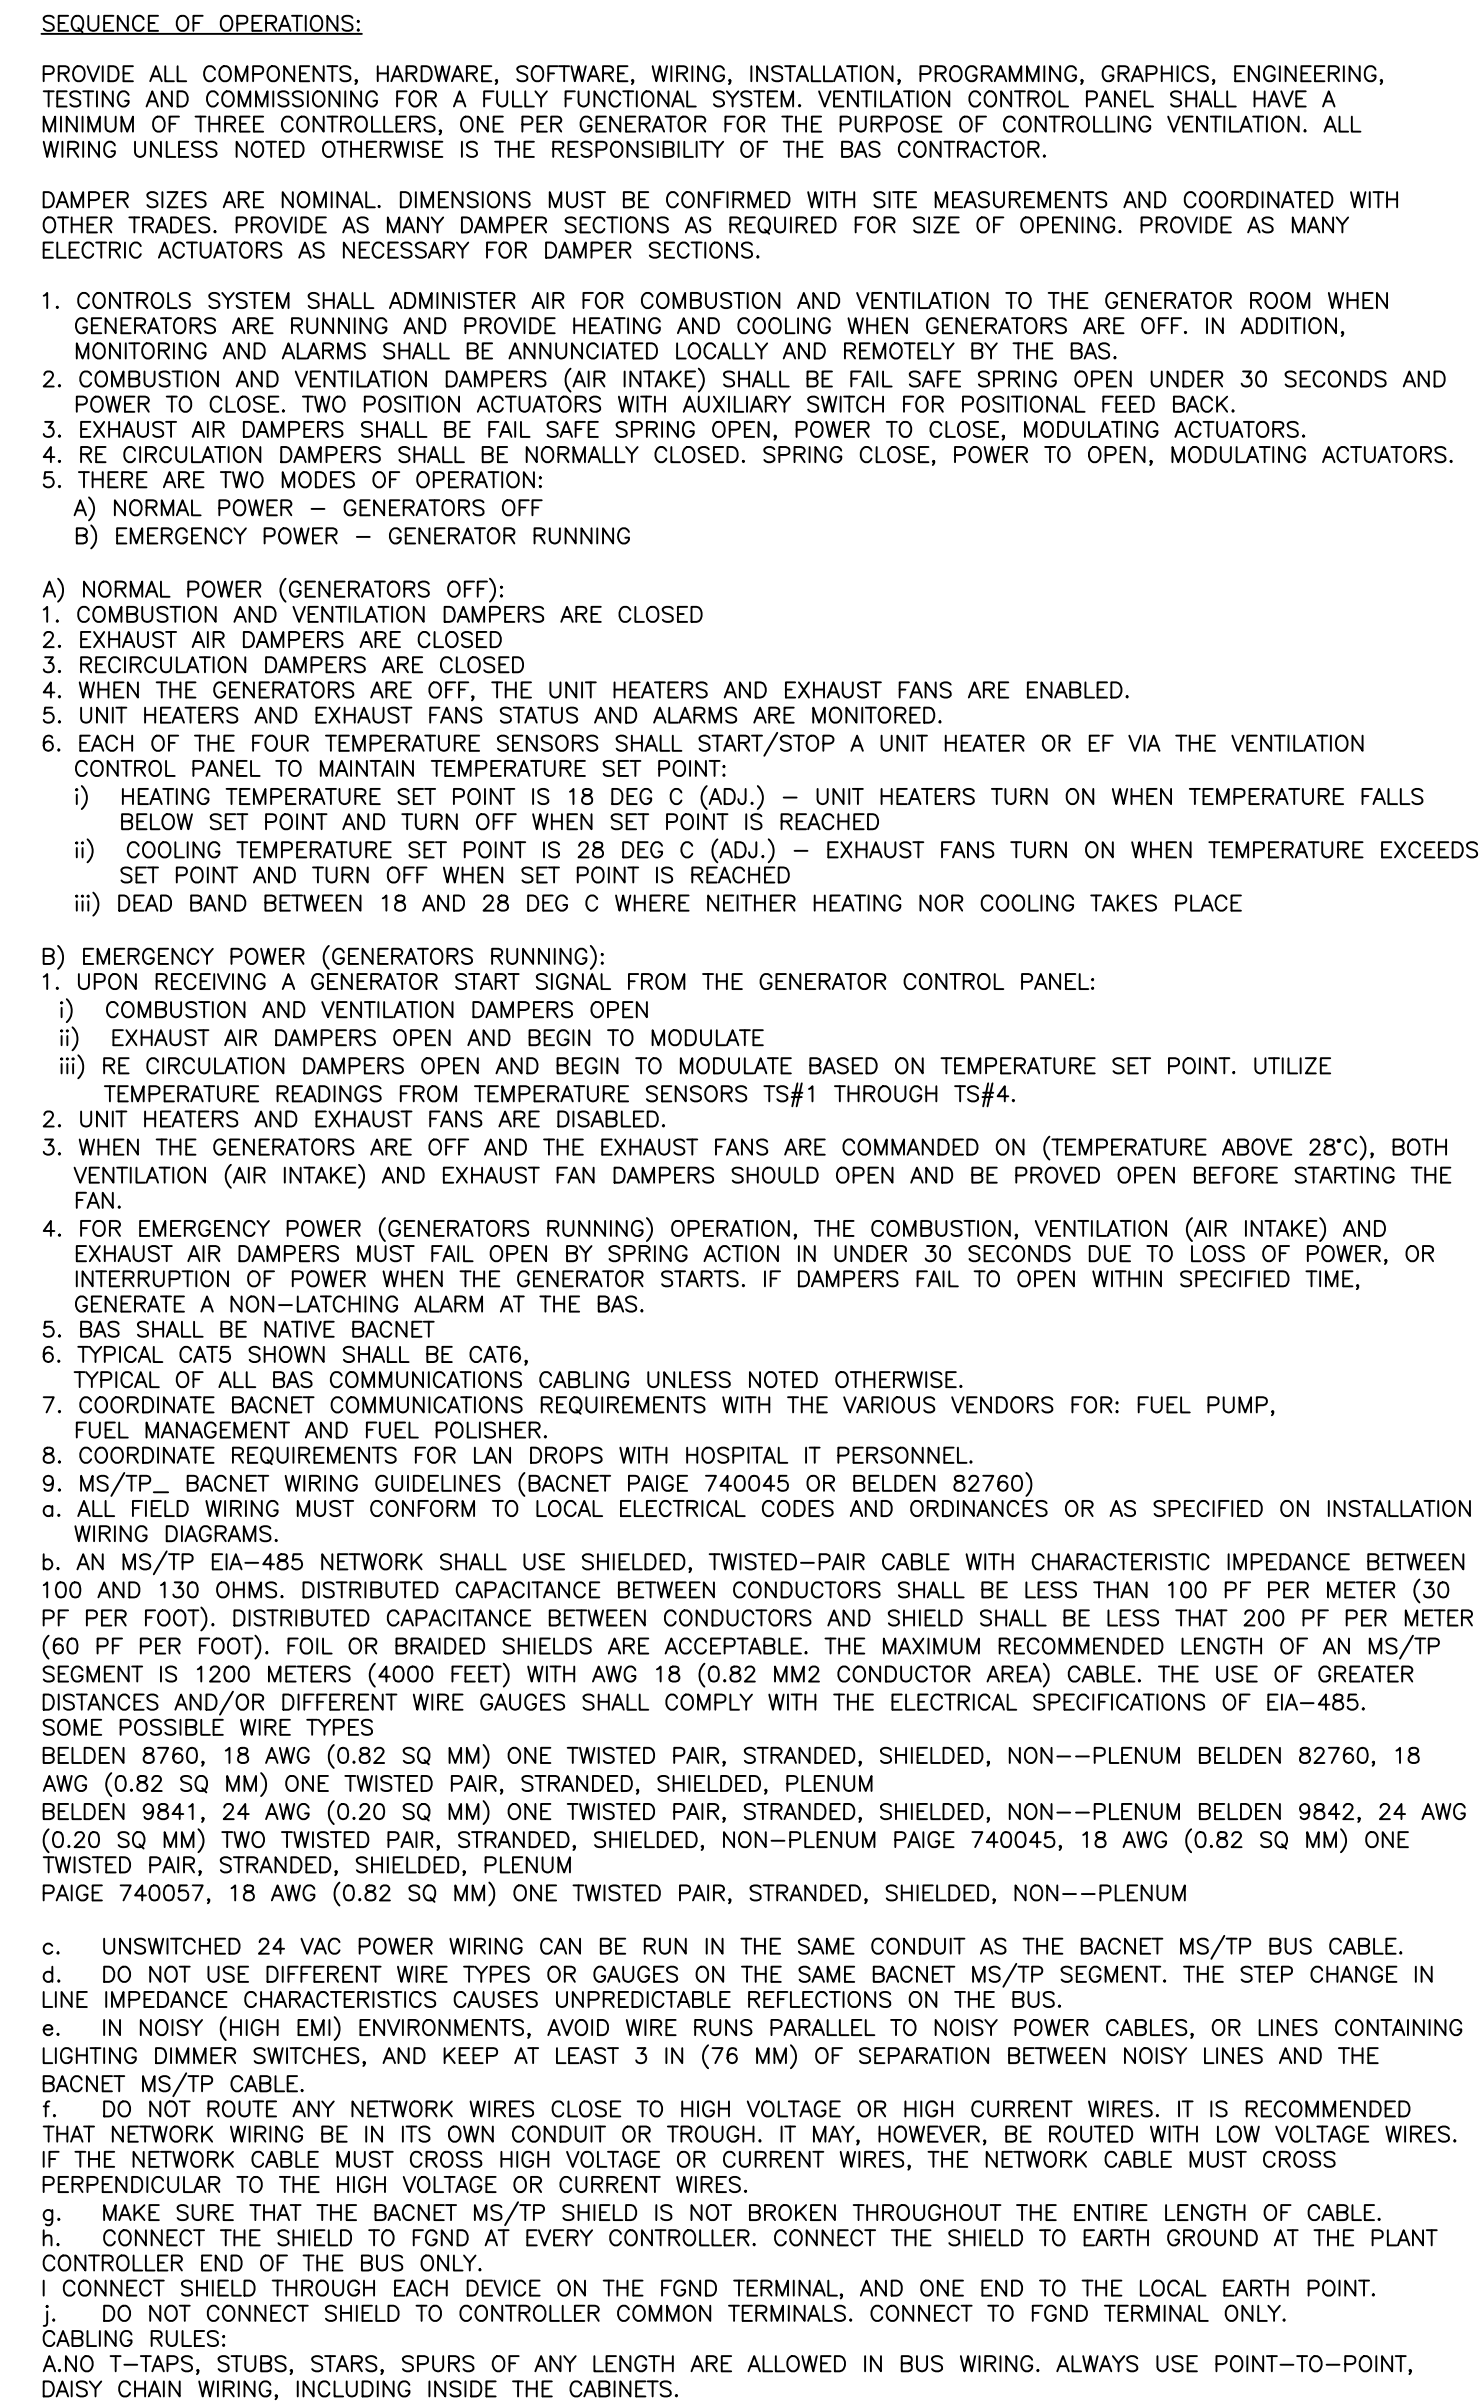

M-702

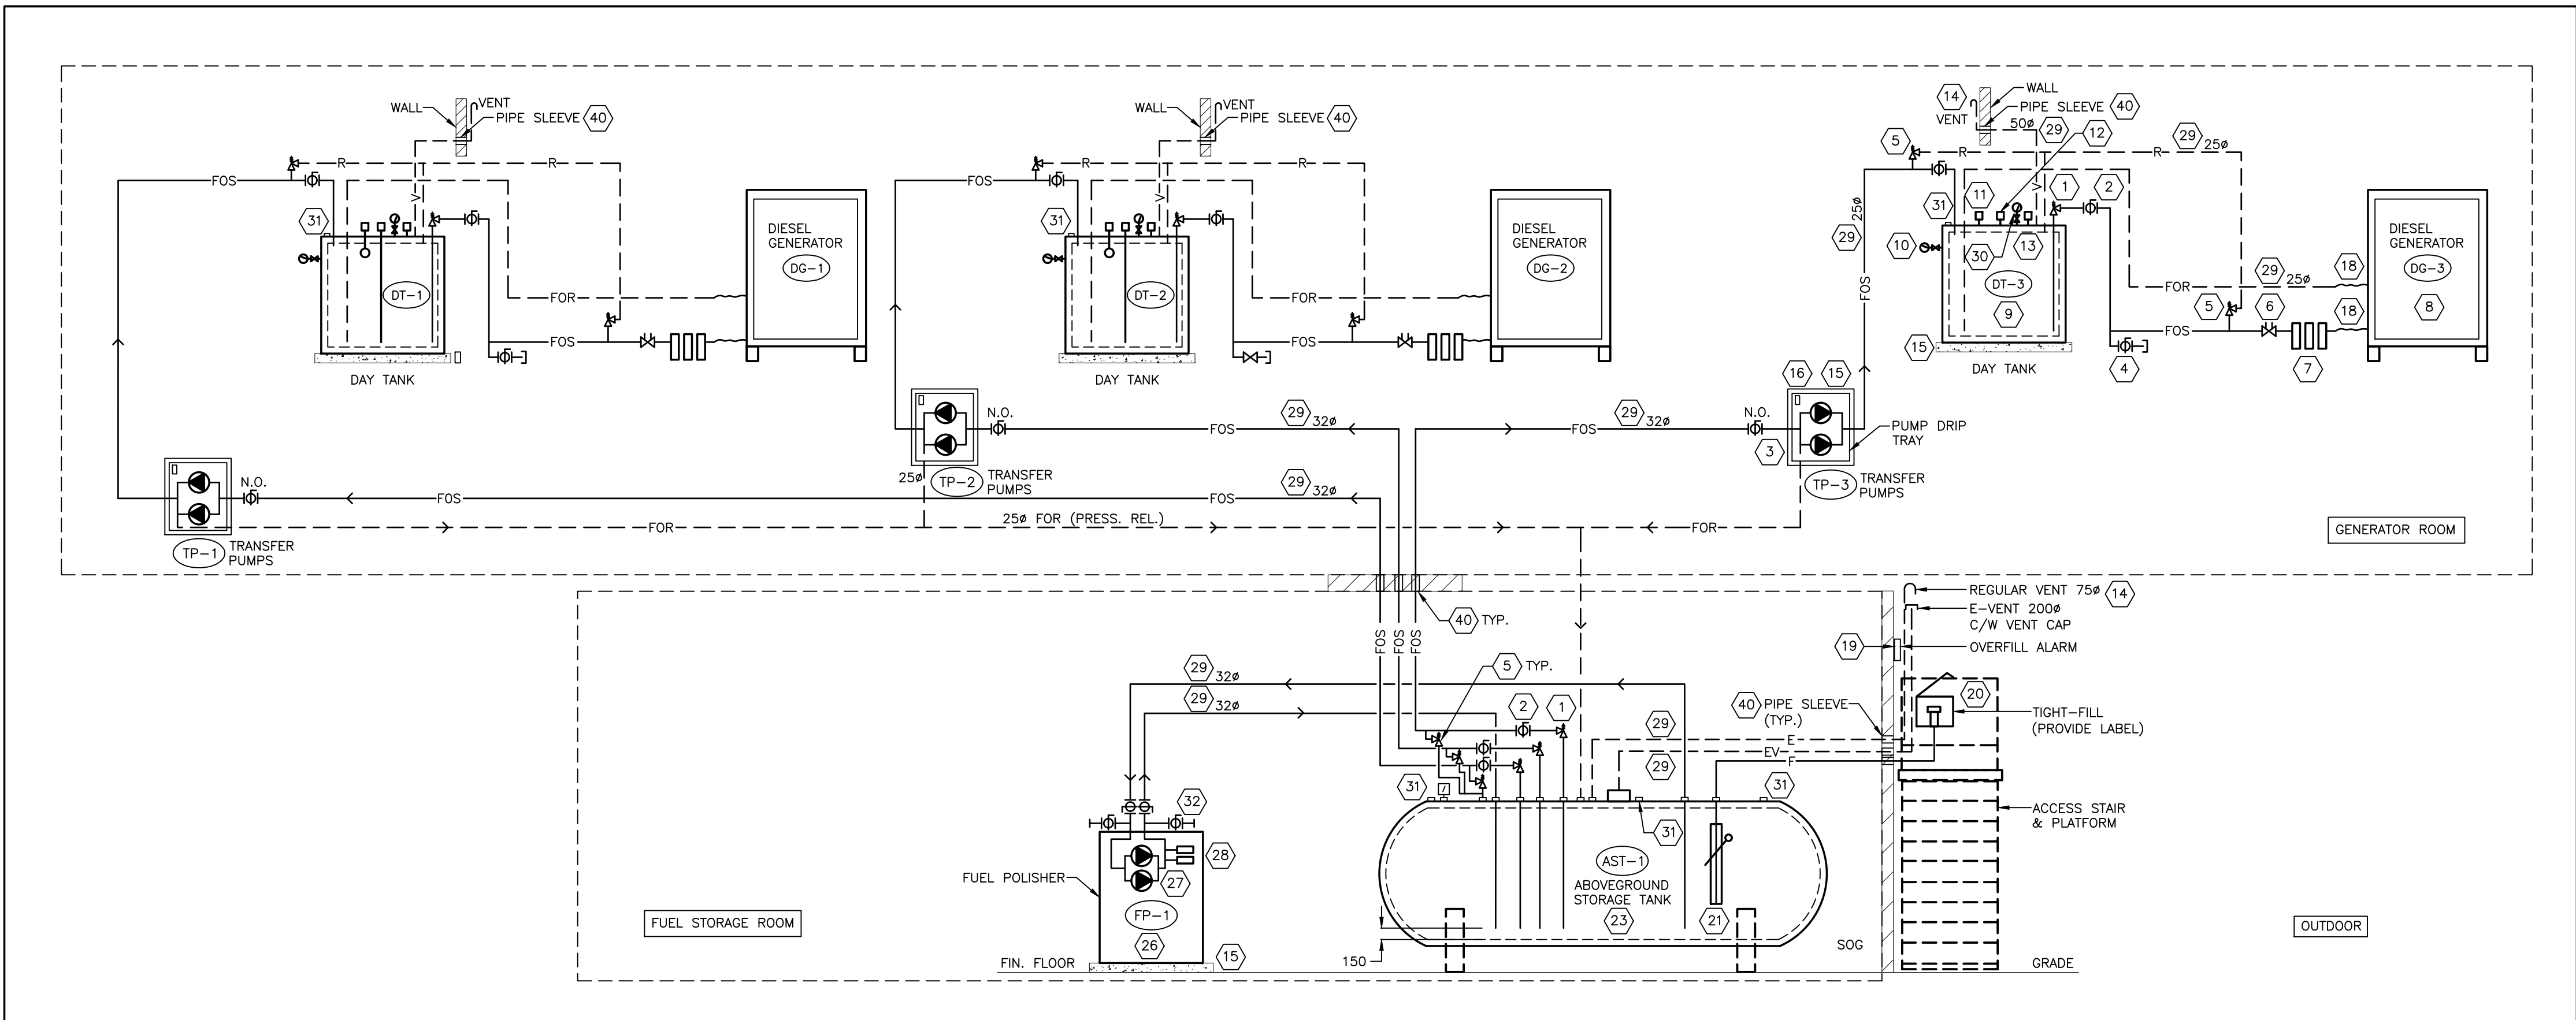

1 FUEL SYSTEM PIPING SCHEMATIC
M-703 N.T.S.

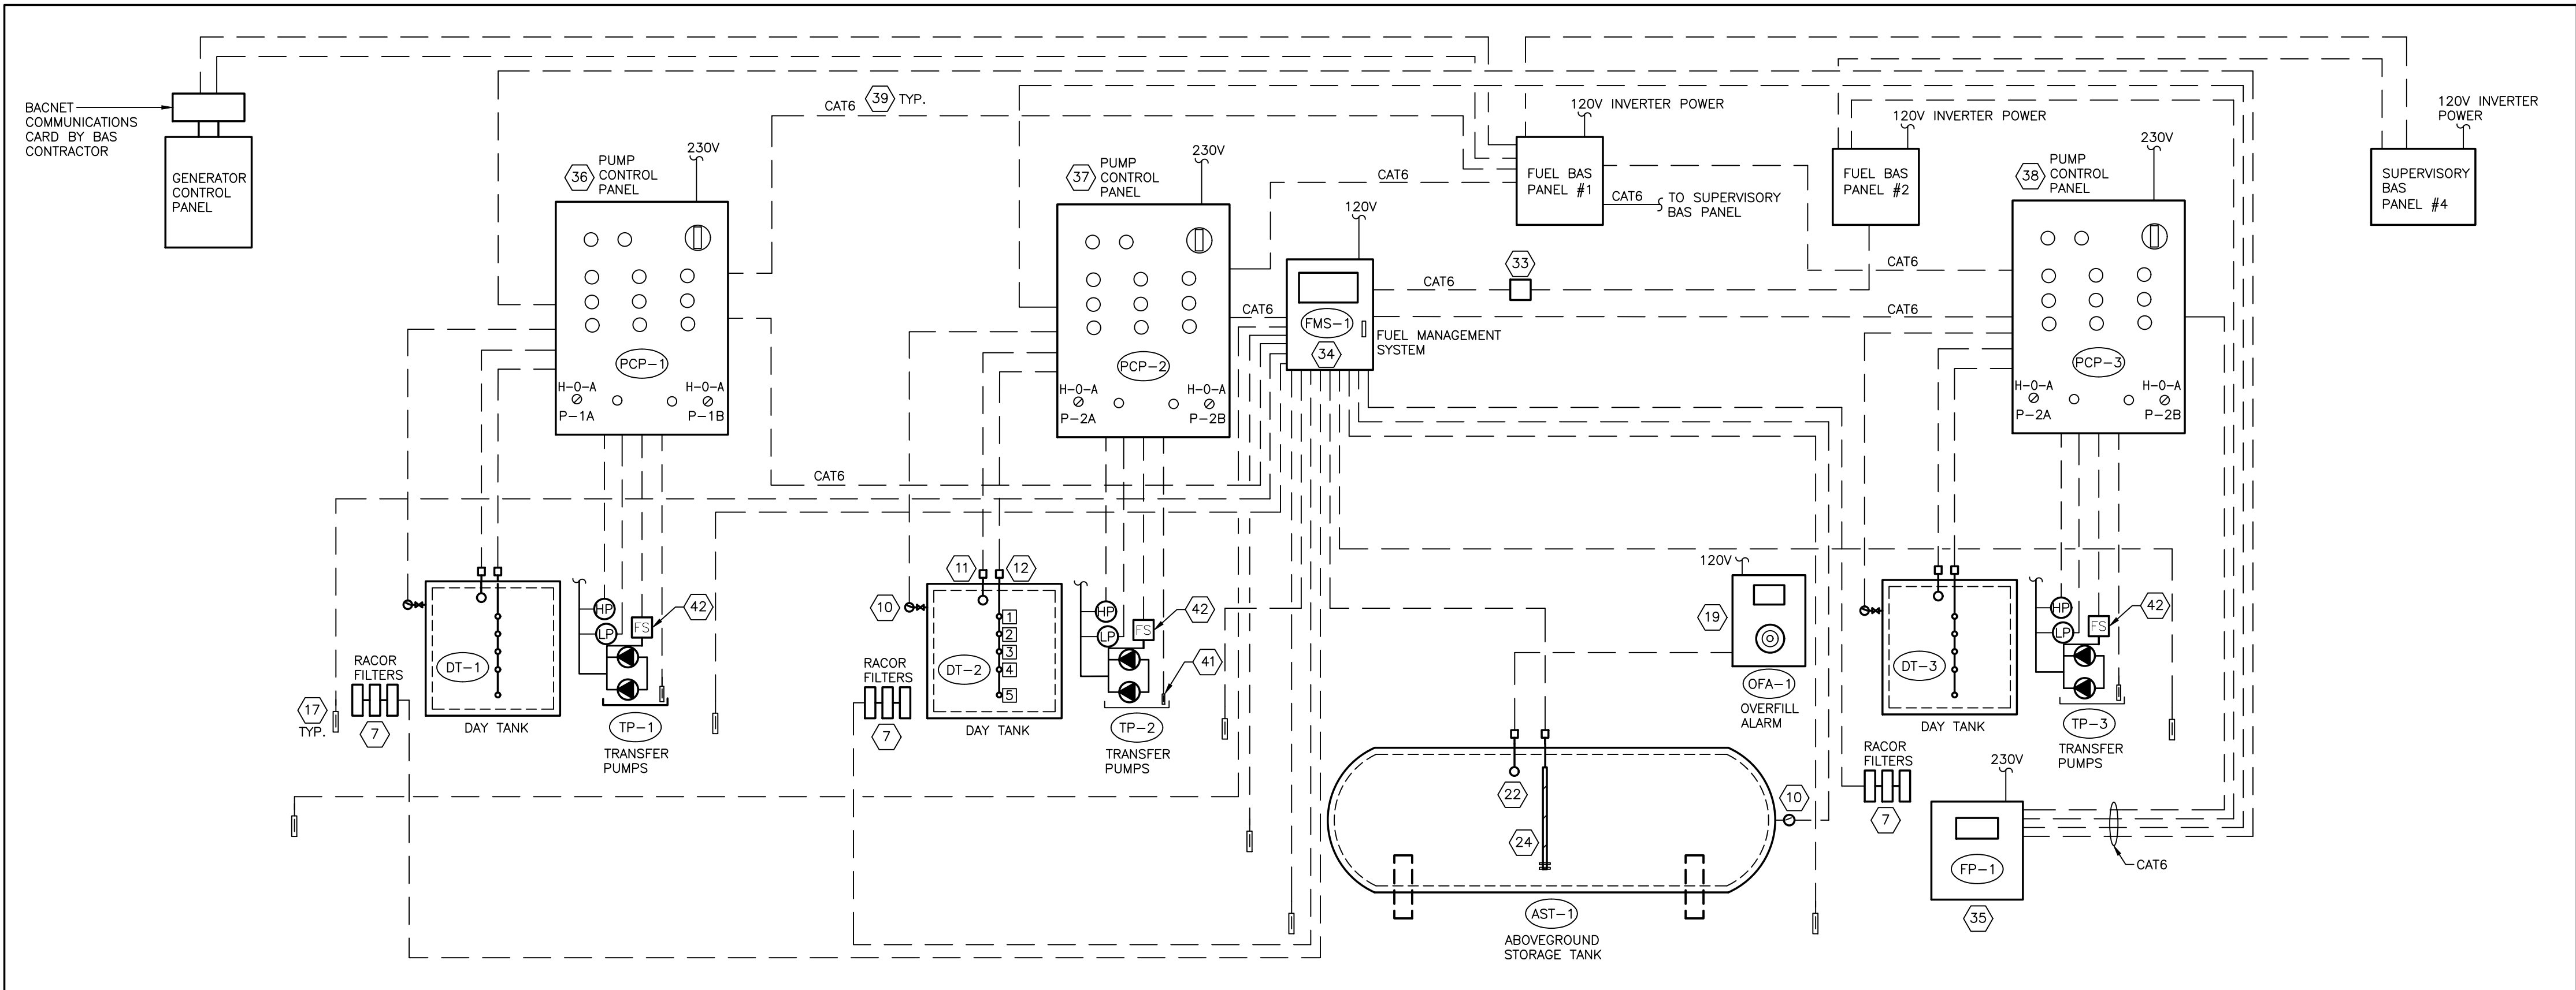

2 FUEL SYSTEM CONTROLS SCHEMATIC
M-703 N.T.S.

- REFERENCE NOTES:
- ANTI-SIPHON VALVE (ASV-1) - EBW C/W BUILT-IN PRESSURE RELIEF. ULC LISTED
 - SHUT-OFF VALVE (SV-1) - JOMAR BALL VALVE. ULC LISTED
 - DUPLEX PUMPS C/W BACNET COMMUNICATIONS CARD, SHUT-OFF VALVES, PRESSURE SWITCHES, FLOW SWITCHES, DRIP TRAY AND 100mm HIGH HOUSEKEEPING PAD.
 - TEST-TEE FOR ANTI-SIPHON VALVE. INSTALL AT LOWEST POINT.
 - PRESSURE RELIEF VALVE (PRV-1) - FULFLO
 - FIRE VALVE (FS-1) - MORRISON BROS
 - FUEL FILTERS - RACOR, 3 CARTRIDGE WITH WATER SEPARATOR. MONITOR WATER ALARM AT FILTERS.
 - GENERATOR
 - DAY TANK - DOUBLE WALL ULC S602
 - VACUUM GAUGE & SWITCH. WIRE TO PUMP CONTROL PANEL UNLESS NOTED OTHERWISE.
 - CRITICAL HIGH LEVEL PROBE CH-1 SET AT 95% LEVEL. WIRE TO PUMP CONTROL PANEL
 - 5-LEVEL PUMP CONTROL PROBE (HLF). WIRE TO PUMP CONTROL PANEL
1 90% - PUMP STOP & HIGH LEVEL ALARM
2 85% - PUMP STOP
3 70% - PUMP START
4 60% - START LAG PUMP & LOW LEVEL ALARM
5 10% - VERY LOW LEVEL. SHUT DOWN GENERATOR
 - ANALOG GAUGE
 - NORMAL VENT C/W ULC VENT CAP TERMINATION AND PIPE SLEEVE
 - HOUSEKEEPING PAD - 100mm HIGH
 - LEAK DETECTOR IN DRIP TRAY. WIRE TO PUMP CONTROL PANEL
 - FLOOR LEAK DETECTOR (FLD) - VEEDER ROOT. WIRE TO VEEDER ROOT CONSOLE (TYP. OF 8)
 - FIRE HOSE - STAINLESS STEEL, ULC LISTED
 - OVERFILL ALARM - K-TECH
 - SPILL BOX (SC-1) C/W CAM-LOCK CONNECTION, ULC LISTED
 - OVERFILL VALVE
 - OVERFILL PROBE (CH-2). CONNECT TO OVERFILL ALARM OUTDOORS
 - ABOVEGROUND STORAGE TANK. DOUBLE-WALL, ULC S601
 - CONTINUOUS LEVEL PROBE (CL) - VEEDER ROOT, MAGNETO-STRICTIVE PROBE
 - RESERVED
 - FUEL POLISHER, SHUT-OFF POLISHER, IF RUN STATUS SIGNAL IS RECEIVED FROM GENERATOR, WIRE TO PUMP CONTROL PANEL.
 - PUMPS
 - FILTERS
 - SCHEDULE 40 STEEL PIPE AND FITTINGS. SOCKET WELDED PIPE WITH FLANGED AND/OR THREADED FITTINGS.
 - ANALOG FUEL GAUGE
 - SPARE TANK OPENING FOR BRIGHT & CLEAR TEST
 - DRAIN VALVES INSTALLED AT LOWEST POINT
 - CHIPKIN BAS BACNET INTERFACE MODULE
 - VEEDER ROOT FUEL MANAGEMENT SYSTEM
 - FUEL POLISHING SYSTEM CONTROL PANEL C/W BACNET COMMUNICATIONS CARD
 - PUMP CONTROL PANEL
 - PUMP CONTROL PANEL
 - PUMP CONTROL PANEL
 - TYPICAL CATS SHOWN SHALL BE CAT5e OR CAT6, TYPICAL OF ALL BAS COMMUNICATIONS CABLING UNLESS NOTED OTHERWISE.
 - WALL PIPE SLEEVE (TYP.). ALL WALL SLEEVES SHALL BE WEATHERPROOF AND/OR FILLED WITH FIRE PROOF MATERIAL.
 - PUMP TRAY LEAK DETECTOR (PTD)
 - PUMP FLOW SWITCHES, MFR: GEMS SENSORS & CONTROLS, MODEL: FS-10798

Key Plan:

Consultant:

MORRISON HERSHFIELD
Suite 300, 125 Commerce Valley Drive W.
Markham, ON L3T 7W4
Tel: (416) 499-3110 Fax: (416) 499-9658

Seal:

4	ISSUED FOR TENDER	JUN 13/19	GF
3	ISSUED FOR BUILDING PERMIT	JUN 3/ 19	GF
1	ISSUED FOR 100% REVW	APR. 26/19	GF
A	ISSUED FOR CLIENT REVIEW	DEC 13/18	GF
REV	DESCRIPTION	DATE	BY

DO NOT SCALE DRAWINGS. CONTRACTOR MUST VERIFY ALL DIMENSIONS AND ADVISE CONSULTANTS OF ANY ERRORS OR OMISSIONS. NO VARIATIONS OR MODIFICATIONS TO WORK SHOWN SHALL BE IMPLEMENTED WITHOUT PRIOR WRITTEN APPROVAL. ALL PREVIOUS ISSUES OF THIS DRAWING ARE SUPERSEDED BY THE LATEST REVISION. ALL DRAWINGS AND SPECIFICATIONS REMAIN THE PROPERTY OF MORRISON HERSHFIELD LIMITED.

Client:



Project:


NEW POWERHOUSE
700 GORDON STREET, WHITBY, ON L1N 5S9

Sheet Title:

FUEL SYSTEM SCHEMATICS

Drawn By:	N.P.	Date:	08/20/18
Designed By:	G.F.	Checked By:	G.F.
Scale:	N.T.S.	File Path:	B:\2018\1802218 - Ontario Shores Powerhouse\1802218 Ontario Shores Powerhouse-REV 0018-MHC1.mxd
Project No:	1802218	Drawing No:	M-703

BM 362/1/14 - 1802218 - Ontario Shores Powerhouse/1802218-Ontario Shores Powerhouse-REV0318-4020-14
6/22/2018 1:07:37 AM

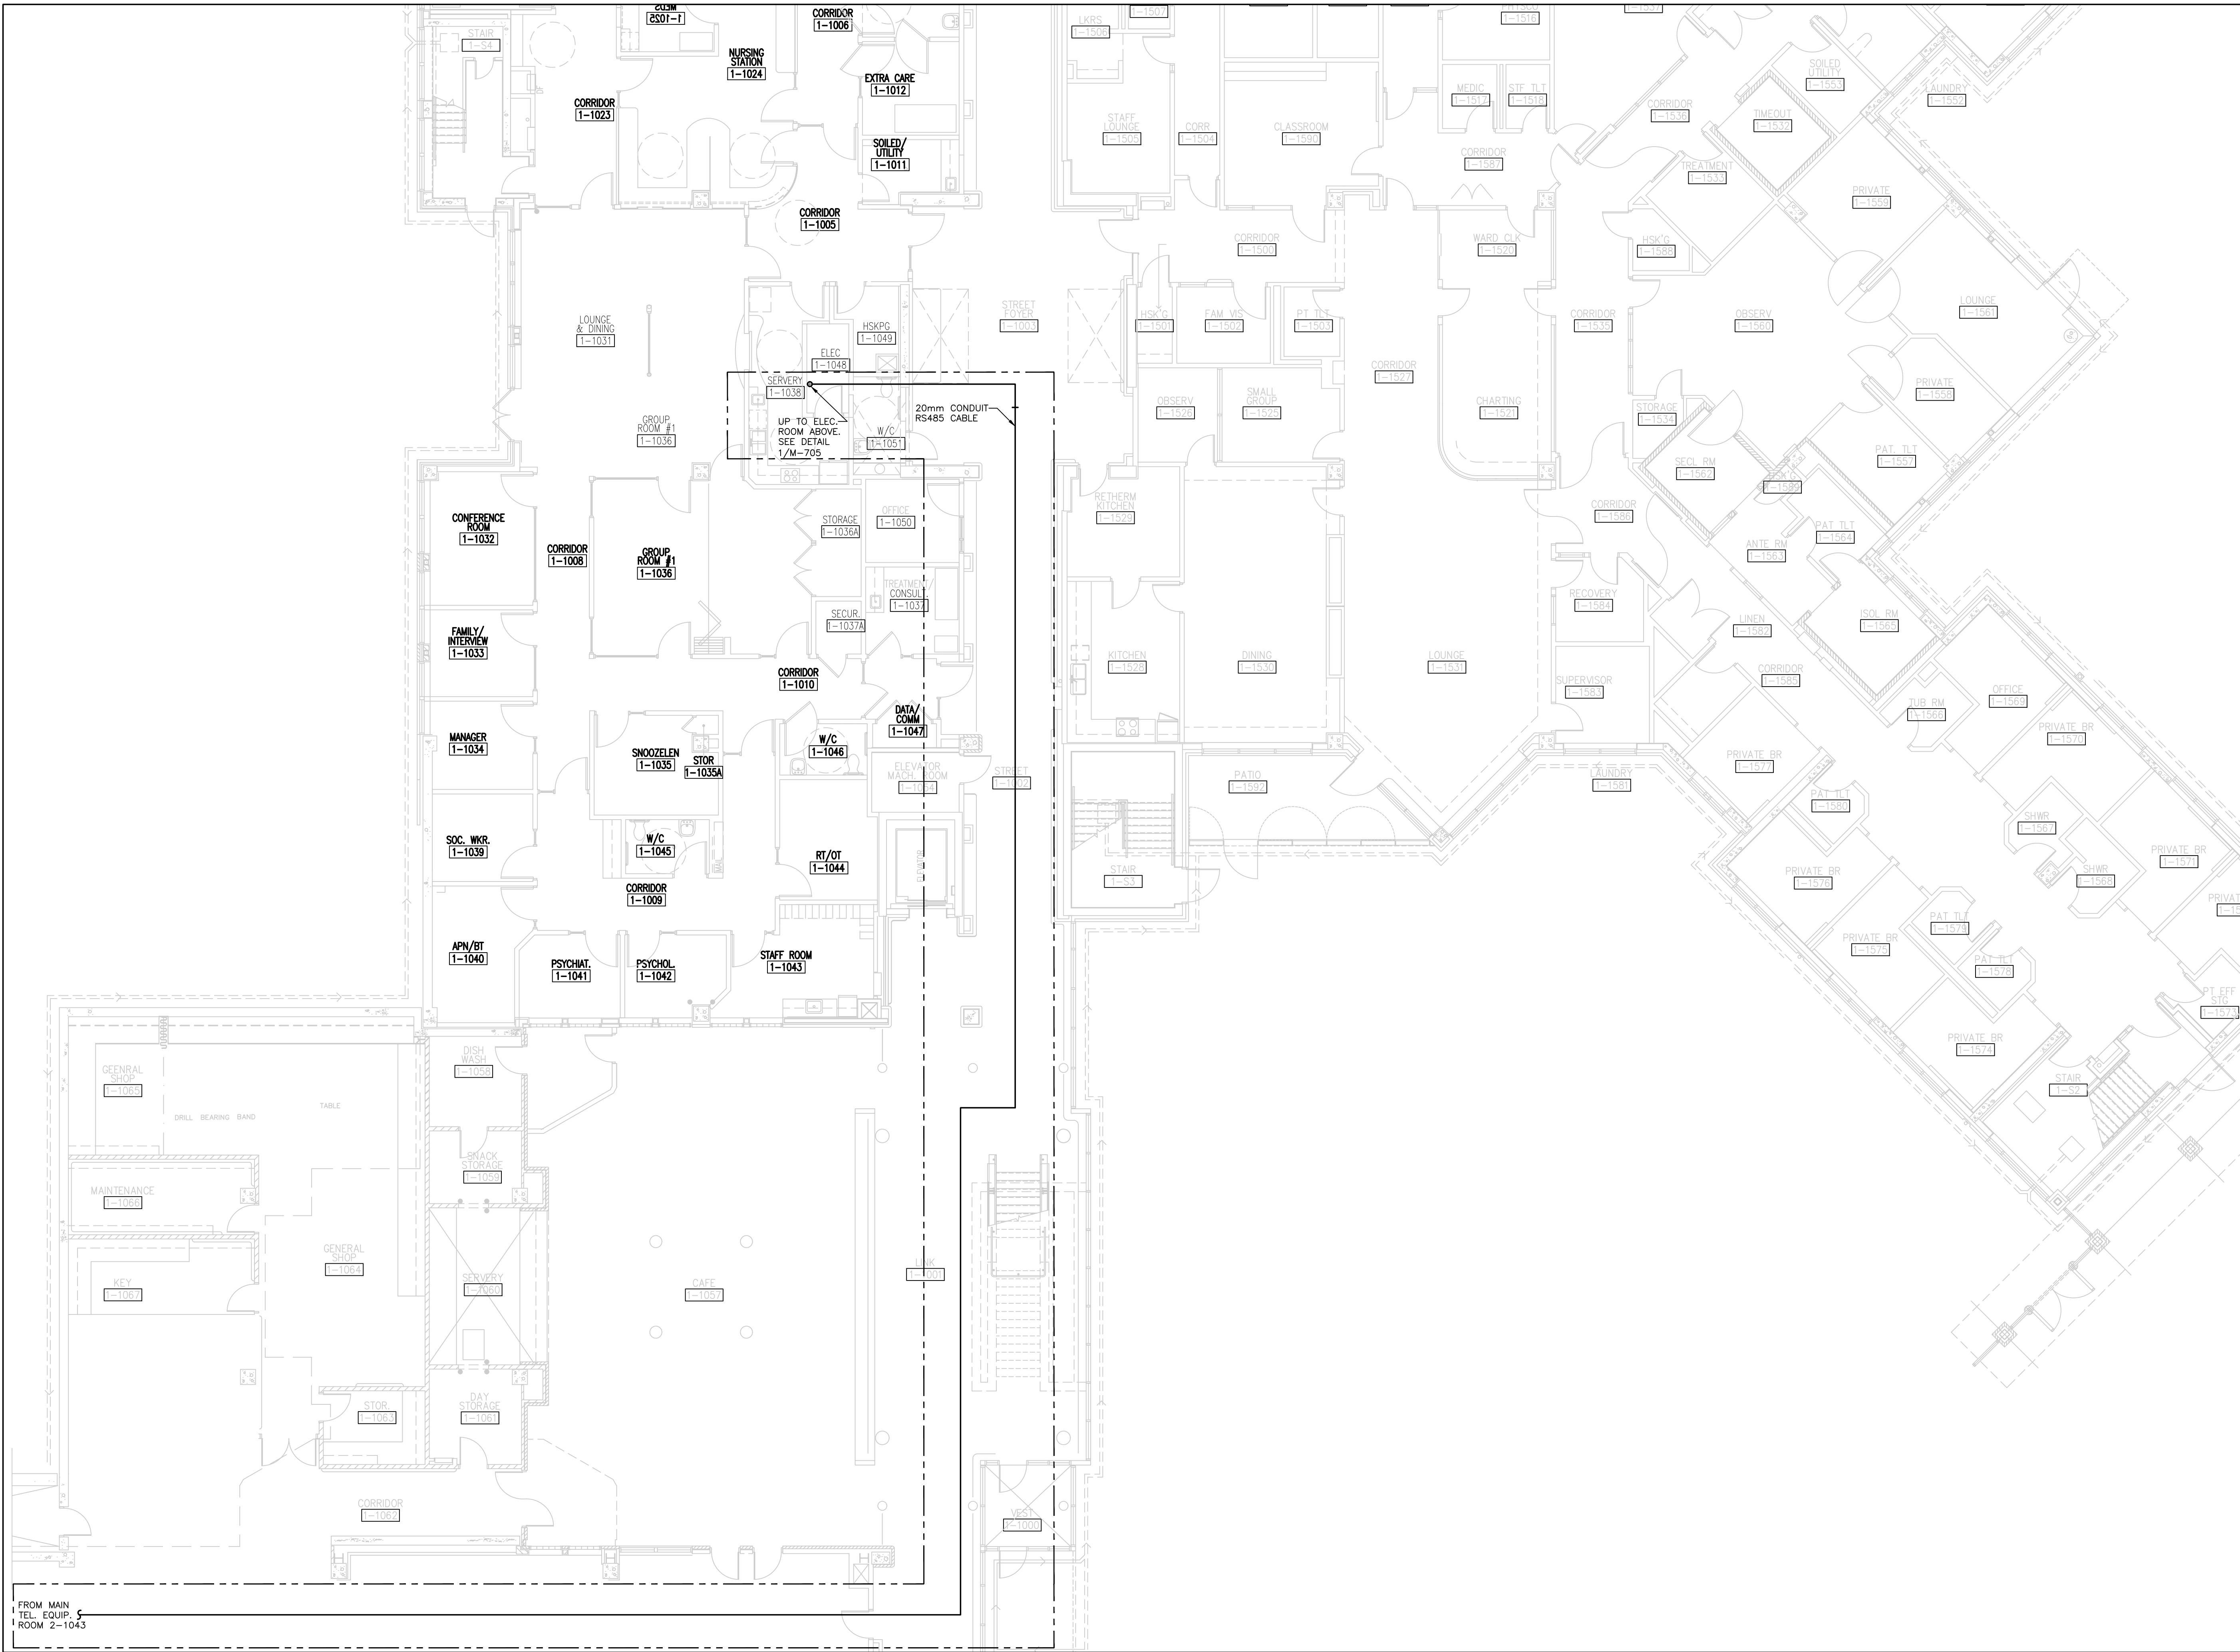


FROM MAIN
TEL. EQUIP.
ROOM 2-1043

1 BUILDING 1 LEVEL 1 - MECHANICAL
M-704 SCALE: 1:100

Key Plan:

Consultant:

m MORRISON HERSHFIELD
Suite 300, 125 Commerce Valley Drive W.
Markham, ON L3T 7W4
Tel: (416) 499-3110 Fax: (416) 499-9658

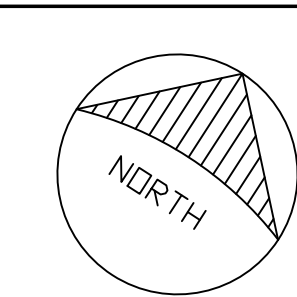

Seal:

4	ISSUED FOR TENDER	JUN 13/19	GF
3	ISSUED FOR BUILDING PERMIT	JUN 3/ 19	GF
1	ISSUED FOR 100% REVW	APR. 26/19	GF
A	ISSUED FOR CLIENT REVIEW	DEC 13/18	GF
REV	DESCRIPTION	DATE	BY

DO NOT SCALE DRAWINGS. CONTRACTOR MUST VERIFY ALL DIMENSIONS AND ADVISE CONSULTANTS OF ANY ERRORS OR OMISSIONS. NO VARIATIONS OR MODIFICATIONS TO WORK SHOWN SHALL BE IMPLEMENTED WITHOUT PRIOR WRITTEN APPROVAL. ALL PREVIOUS ISSUES OF THIS DRAWING ARE SUPERSEDED BY THE LATEST REVISION. ALL DRAWINGS AND SPECIFICATIONS REMAIN THE PROPERTY OF MORRISON HERSHFIELD LIMITED.

Client:



Project:

NEW POWERHOUSE

700 GORDON STREET, WHITBY, ON L1N 5S9

Sheet Title:

BUILDING 1 LEVEL 1 - MECHANICAL

Drawn By: N.P. Date: 08/20/18

Designed By: G.F. Checked By: G.F.


Scale: AS SHOWN File Path: B:\1802218-Ontario Shores Powerhouse\1802218-Ontario Shores Powerhouse-REV0318-4020-14

Project No: 1802218 Drawing No: M-704

BM 362/1/14 - 1802218 - Ontario Shores Powerhouse/1802218-04018-00014
6/22/2016 11:07:37 AM



1 BUILDING 1 LEVEL 2 – MECHANICAL
M-705 SCALE: 1:100

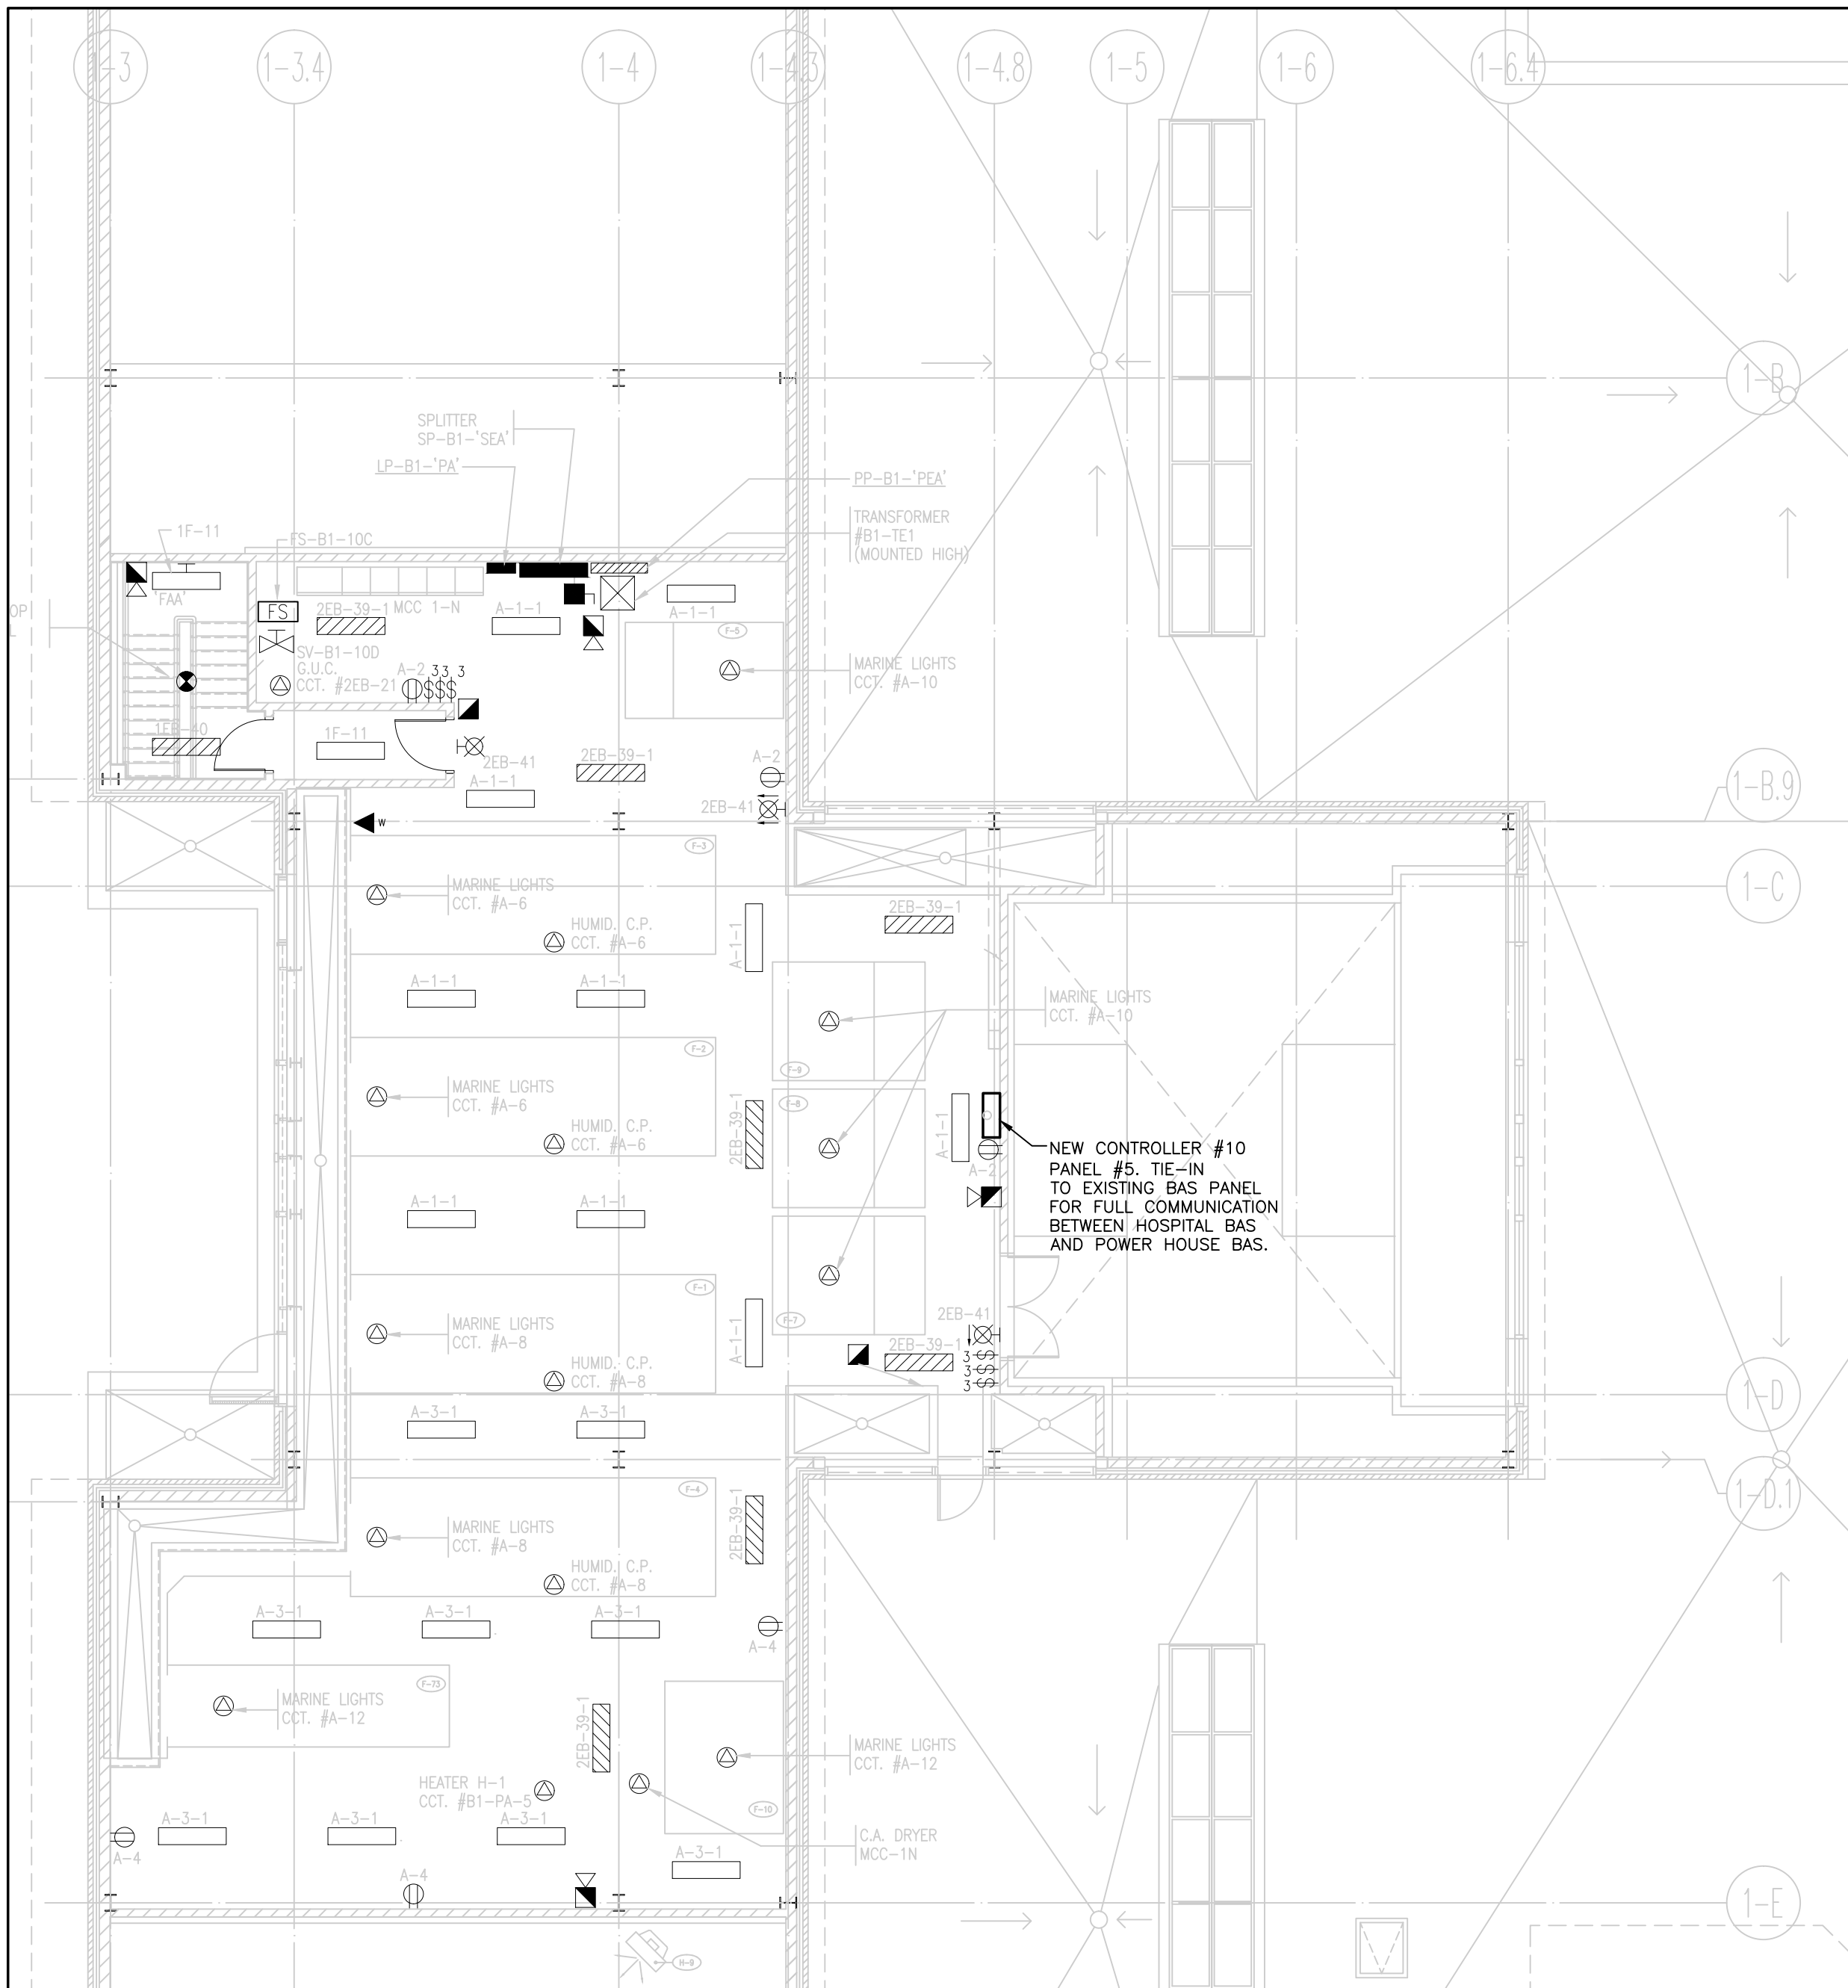


2 BUILDING 1 PENTHOUSE – ELECTRICAL
M-705 SCALE: 1:100

Key Plan:

Consultant:

MORRISON HERSHFIELD
Suite 300, 125 Commerce Valley Drive W.
Markham, ON L3T 7W4
Tel: (416) 499-3110 Fax: (416) 499-9658

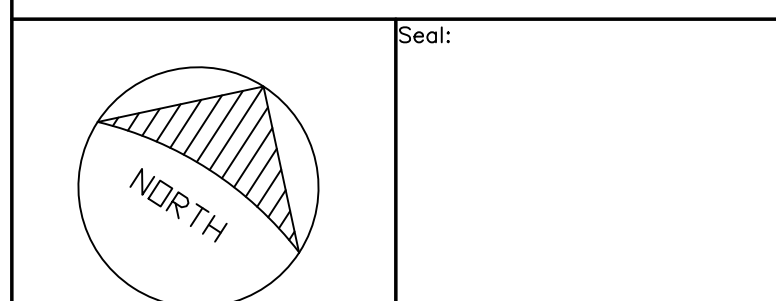

REV	DESCRIPTION	DATE	BY
4	ISSUED FOR TENDER	JUN 13/19	GF
3	ISSUED FOR BUILDING PERMIT	JUN 3/ 19	GF
1	ISSUED FOR 100% REVW	APR. 26/19	GF
A	ISSUED FOR CLIENT REVIEW	DEC 13/18	GF

DO NOT SCALE DRAWINGS. CONTRACTOR MUST VERIFY ALL DIMENSIONS AND ADVISE CONSULTANTS OF ANY ERRORS OR OMISSIONS. NO VARIATIONS OR MODIFICATIONS TO WORK SHOWN SHALL BE IMPLEMENTED WITHOUT PRIOR WRITTEN APPROVAL. ALL PREVIOUS ISSUES OF THIS DRAWING ARE SUPERSEDED BY THE LATEST REVISION. ALL DRAWINGS AND SPECIFICATIONS REMAIN THE PROPERTY OF MORRISON HERSHFIELD LIMITED.

Client:




Project:

NEW POWERHOUSE
700 GORDON STREET, WHITBY, ON L1N 5S9

Sheet Title:

BUILDING 1 LEVEL 2 AND PENTHOUSE - MECHANICAL

Drawn By:	N.P.	Date:	08/20/18
Designed By:	G.F.	Checked By:	G.F.
Scale:	N.T.S.	File Path:	BM 362/1/14 - 1802218 - Ontario Shores Powerhouse/1802218-04018-00014
Project No:	1802218	Drawing No:	M-705


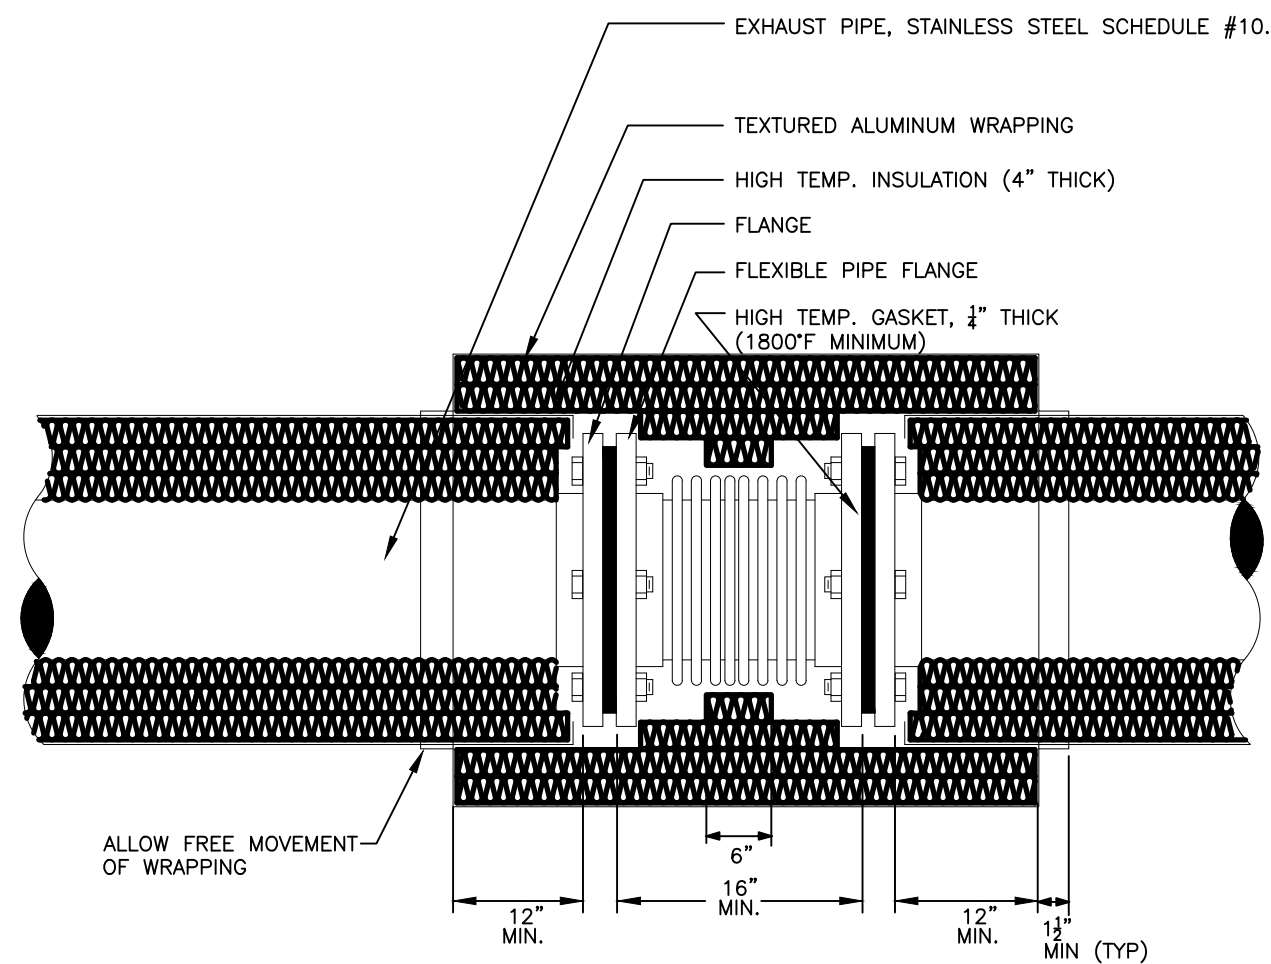


REMARKS

1. INSTALL THE FLEXIBLE JOINT WITH THE TEMPORARY JOINT SUPPORT RODS IN PLACE UNTIL SUCH A TIME THAT THE ENTIRE EXHAUST SYSTEM IS ADEQUATELY SUPPORTED. THIS SHALL PREVENT THE FLEXIBLE JOINT FROM BECOMING DAMAGED.
2. THE NUTS & BOLTS FOR THE CONNECTION OF THE FLEXIBLE JOINT SHALL HAVE THE SAME CHARACTERISTICS AS THE FLEXIBLE JOINT AND SHALL ALLOW FOR EASY REMOVAL OF THE JOINT.
3. THE FLEXIBLE JOINT SHALL NOT BE DAMAGED PRIOR TO BEING PUT INTO SERVICE. IF DAMAGED THE JOINT MUST BE REPLACED AT NO EXTRA COST TO THE OWNER.

DESCRIPTION							
Ø EXHAUST (PIPE) mm	A	B	C	D	E	F	G
75	324	273	152	178	13	102	152
100	394	336	190	211	16	102	152
150	467	432	235	297	19	127	203
200	568	514	279	336	19	127	203
250	711	660	349	387	22	127	203
300	864	800	413	476	25	127	203


H: THERMAL EXPANSION OF PIPE, MAXIMUM 1/2 OF "G".
I: FREE SPACE (NO INSULATION) TO ALLOW PIPE MOVEMENT (MINIMUM, "H" + 50mm).
J: INSULATION OVERLAP (300mm) ATTACHED TO THE GUIDE, WHICH TRAVELS ALONG METALLIC WRAPPING OF THE EXHAUST PIPE.

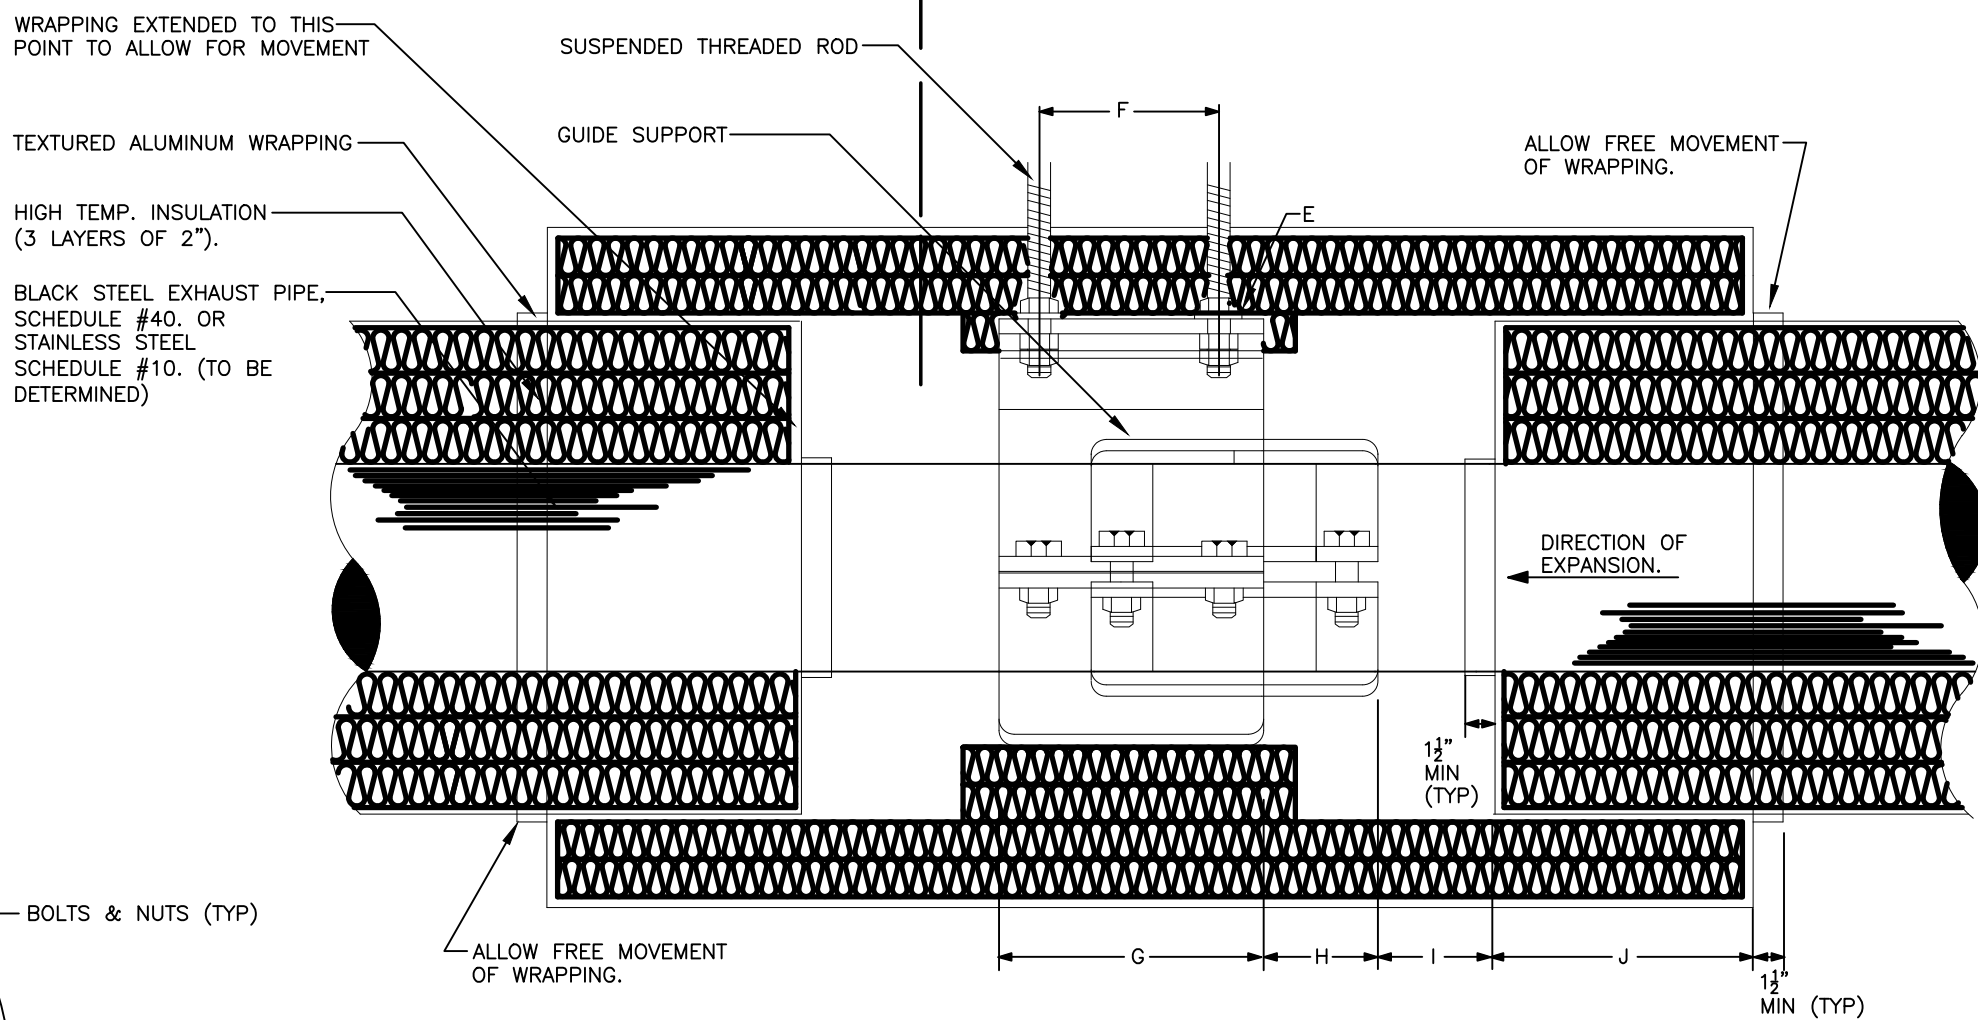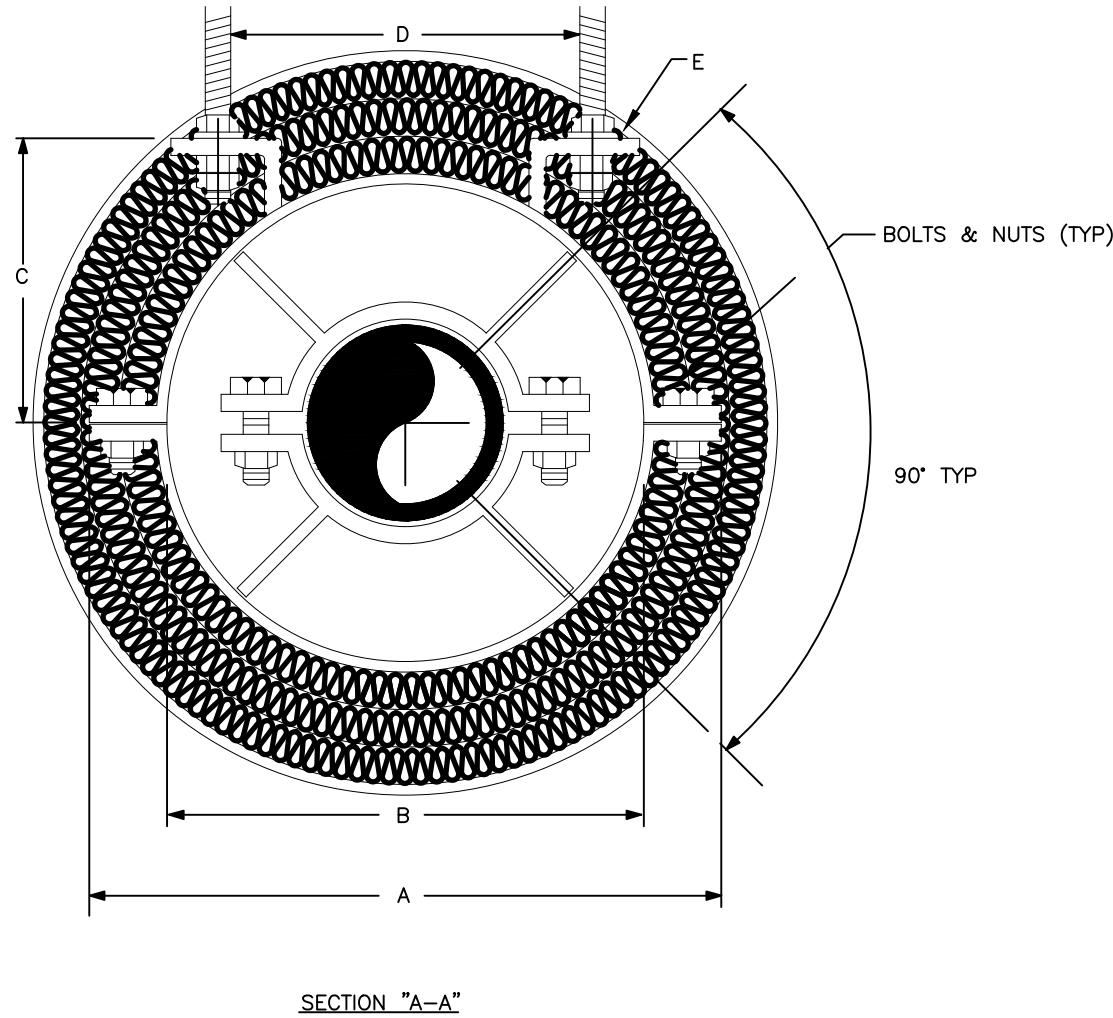

REMARKS

1. THE GUIDE SUPPORTS SHALL BE IDENTICAL TO #PG794, THOMAS & BETTS OR EQUIVALENT "FEXI-TUBE".
2. GUIDE SUPPORT SHALL BE IDENTICAL TO THE PIPE MATERIAL USED (STAINLESS STEEL).
3. CUT SHORT THE INSULATION INSIDE THE GUIDE SUPPORT TO PREVENT DAMAGE TO INSULATION & ALUMINUM WRAPPING.
4. THE EXHAUST PIPE SHALL HAVE 3 LAYERS (2\"/>




2 GENERAL CONFIGURATION OF EXPANSION & COMPRESSION JOINT-INSULATION
M-901 N.T.S.

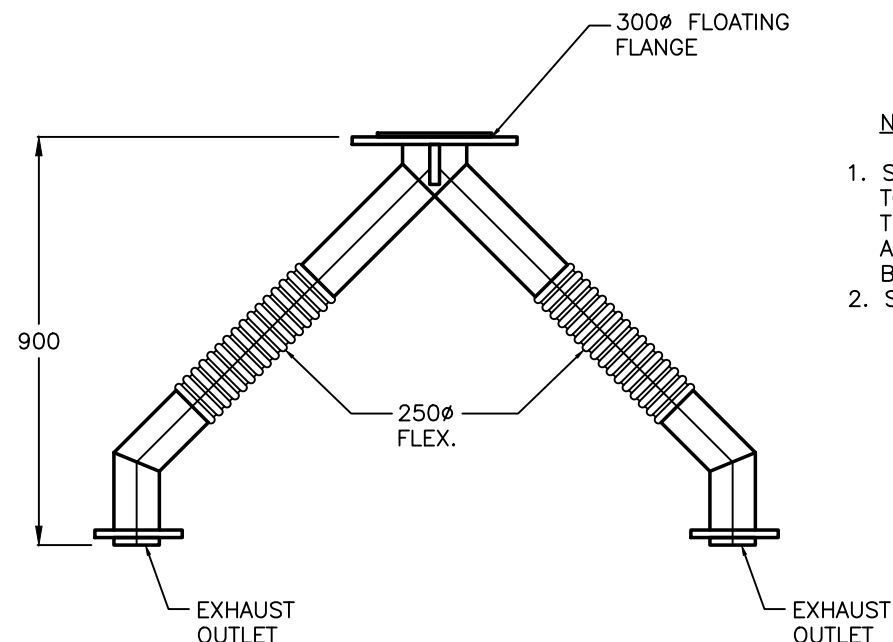

NOTES:


1. SOME VARIATIONS MAY EXIST FOR THIS WYE-CONNECTION TO SUIT VARIOUS GENERATOR MANUFACTURERS. IT IS SHOWN THUS FOR ILLUSTRATION PURPOSES. MAKE THE NECESSARY ALLOWANCES FOR VARIATIONS IN CONSTRUCTION THAT MAY BE REQUIRED.
2. SELECT A LOW PRESSURE DROP WYE.

1 EXHAUST PIPE SUSPENSION DETAIL
M-901 N.T.S.

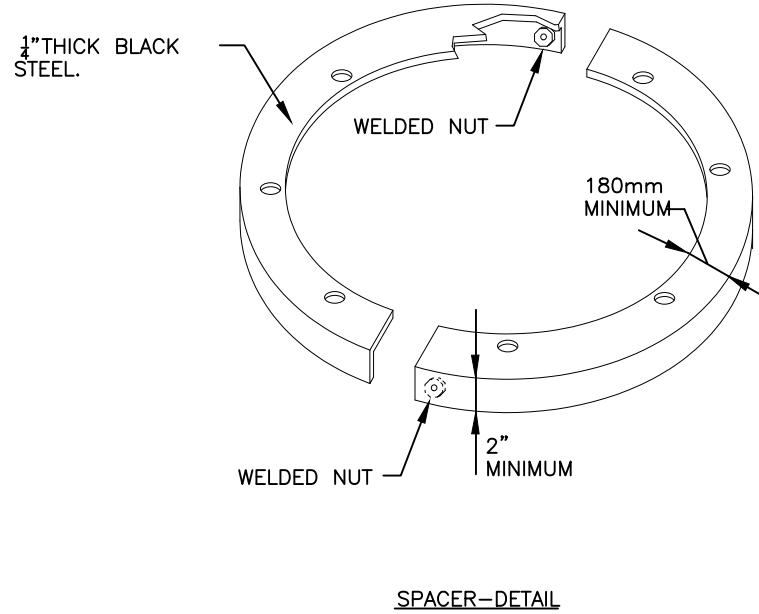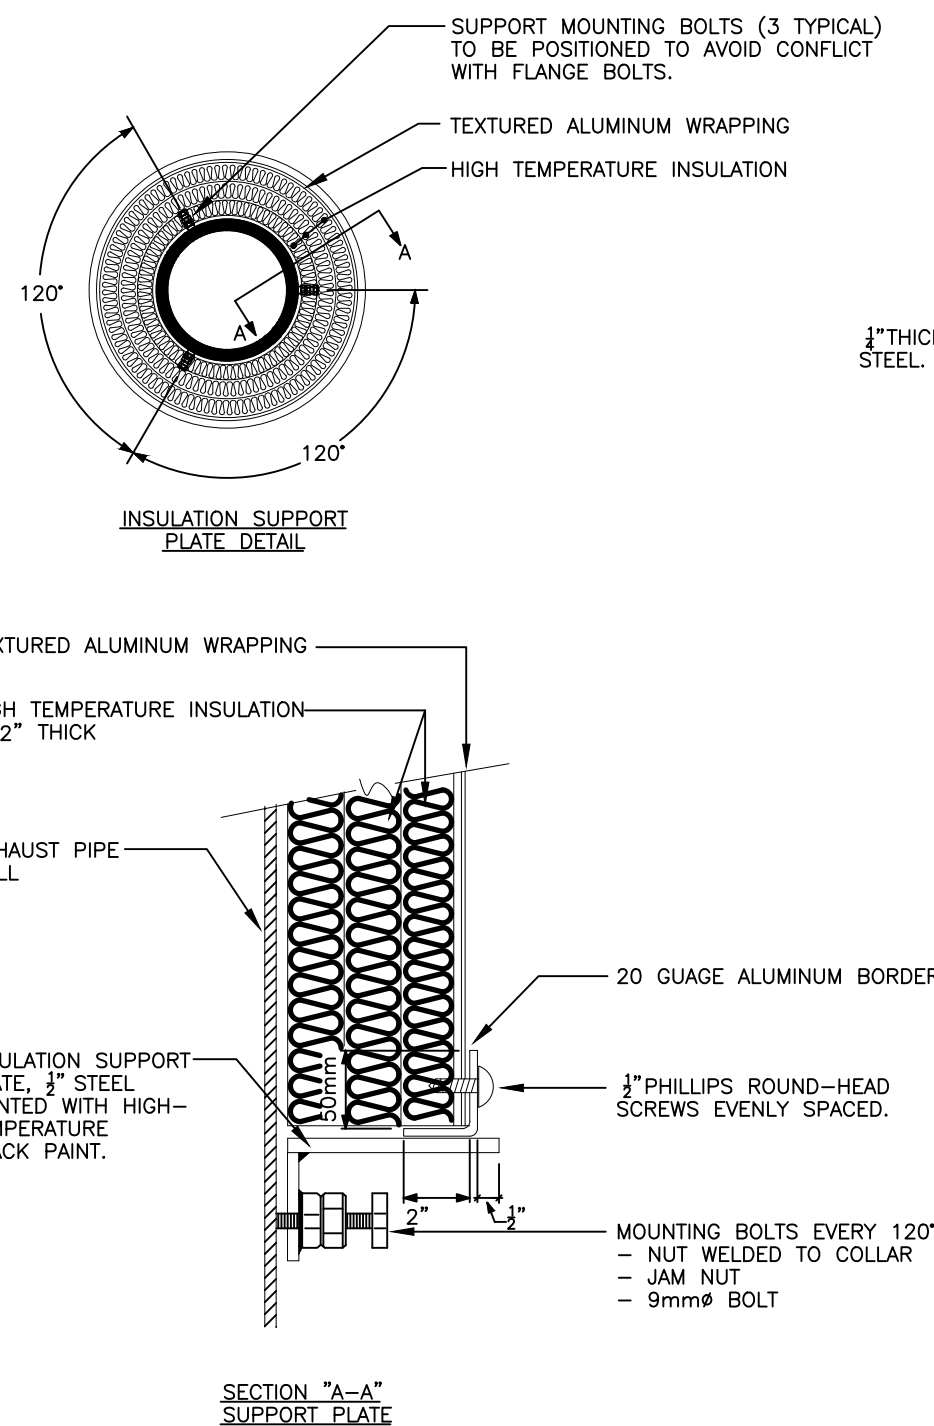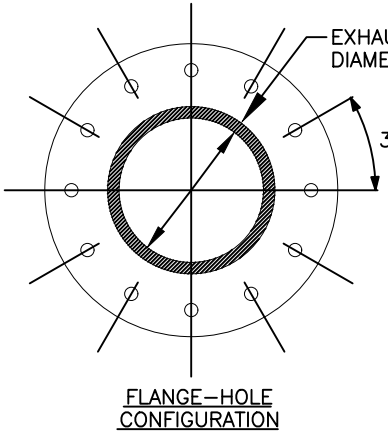

REMARKS

- A) THE MUFFLER, THE FLEXIBLE PIPE SAFETY SHIELD SHALL BE INSTALLED BY DIV.#15.
- B) THE FLANGE FOLLOWING THE FLEXIBLE PIPE SHALL BE INSTALLED BY DIV.#15.
- C) THE FLEXIBLE PIPE SHALL BE PERFECTLY ALIGNED IN BOTH AXIS. IT SHALL NOT BE COMPRESSED AND/OR STRETCHED DURING INSTALLATION ON THE GEN-SET. THE EXHAUST SYSTEM SHALL BE INSTALLED IN THE PRESENCE OF THE GEN-SET MANUFACTURER. ALL FLEXIBLE PIPE ADJUSTMENT SHALL BE MADE BY THE GEN-SET MANUFACTURER IN COORDINATION WITH THE DIV.#15 CONTRACTOR.
- D) REFER TO THE SPECIFICATIONS DOCUMENTS FOR MATERIAL CHARACTERISTICS.

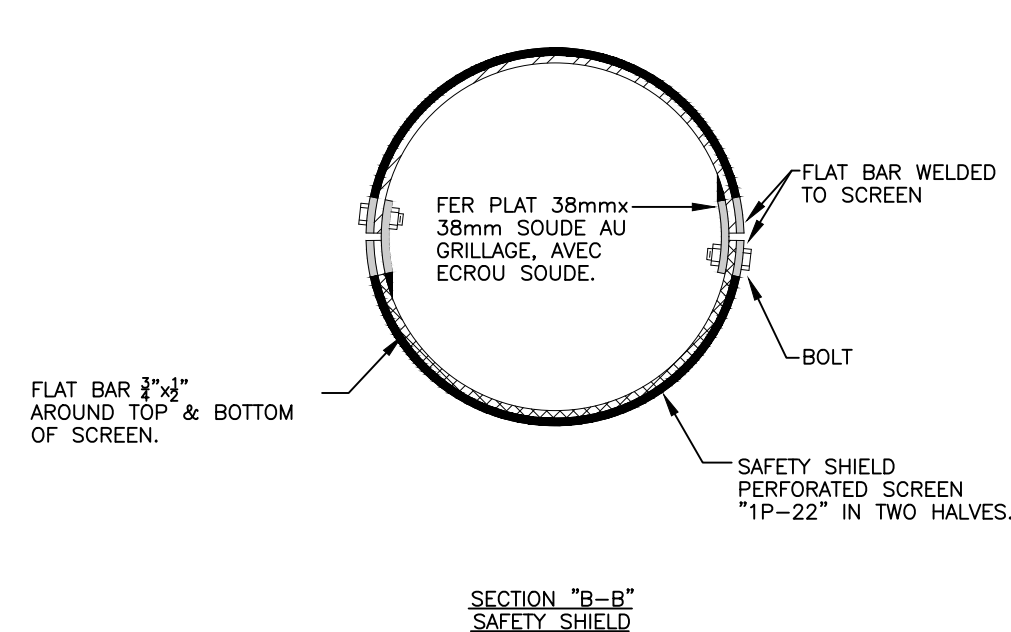

4 WYE FLEX. EXHAUST
M-901 N.T.S.

3 DETAILED INSTALLATION OF ENGINE PIPE
M-901 N.T.S.

Key Plan:

Consultant:



Suite 300, 125 Commerce Valley Drive W.
Markham, ON L3T 7W4
Tel: (416) 499-3110 Fax: (416) 499-9658

Seal:

4	ISSUED FOR TENDER	JUN 13/19	GF
3	ISSUED FOR BUILDING PERMIT	JUN 3/ 19	GF
1	ISSUED FOR 100% REVW	APR. 26/19	GF
A	ISSUED FOR CLIENT REVIEW	DEC 13/18	GF
REV	DESCRIPTION	DATE	BY

DO NOT SCALE DRAWINGS. CONTRACTOR MUST VERIFY ALL DIMENSIONS AND ADVISE CONSULTANTS OF ANY ERRORS OR OMISSIONS. NO VARIATIONS OR MODIFICATIONS TO WORK SHOWN SHALL BE IMPLEMENTED WITHOUT PRIOR WRITTEN APPROVAL. ALL PREVIOUS ISSUES OF THIS DRAWING ARE SUPERSEDED BY THE LATEST REVISION. ALL DRAWINGS AND SPECIFICATIONS REMAIN THE PROPERTY OF MORRISON HERSHFIELD LIMITED.

Client:



Project:

NEW POWERHOUSE

700 GORDON STREET, WHITBY, ON L1N 5S9

Sheet Title:

STANDARD DETAILS

Drawn By: N.P. Date: 08/20/18


Designed By: G.F. Checked By: G.F.

Scale: N.T.S. File Path: B:\2018\1802218 - Ontario Shores Powerhouse\1802218 Ontario Shores Powerhouse\REV C\1802218.MXD


Project No: 1802218 Drawing No: M-901




M-902

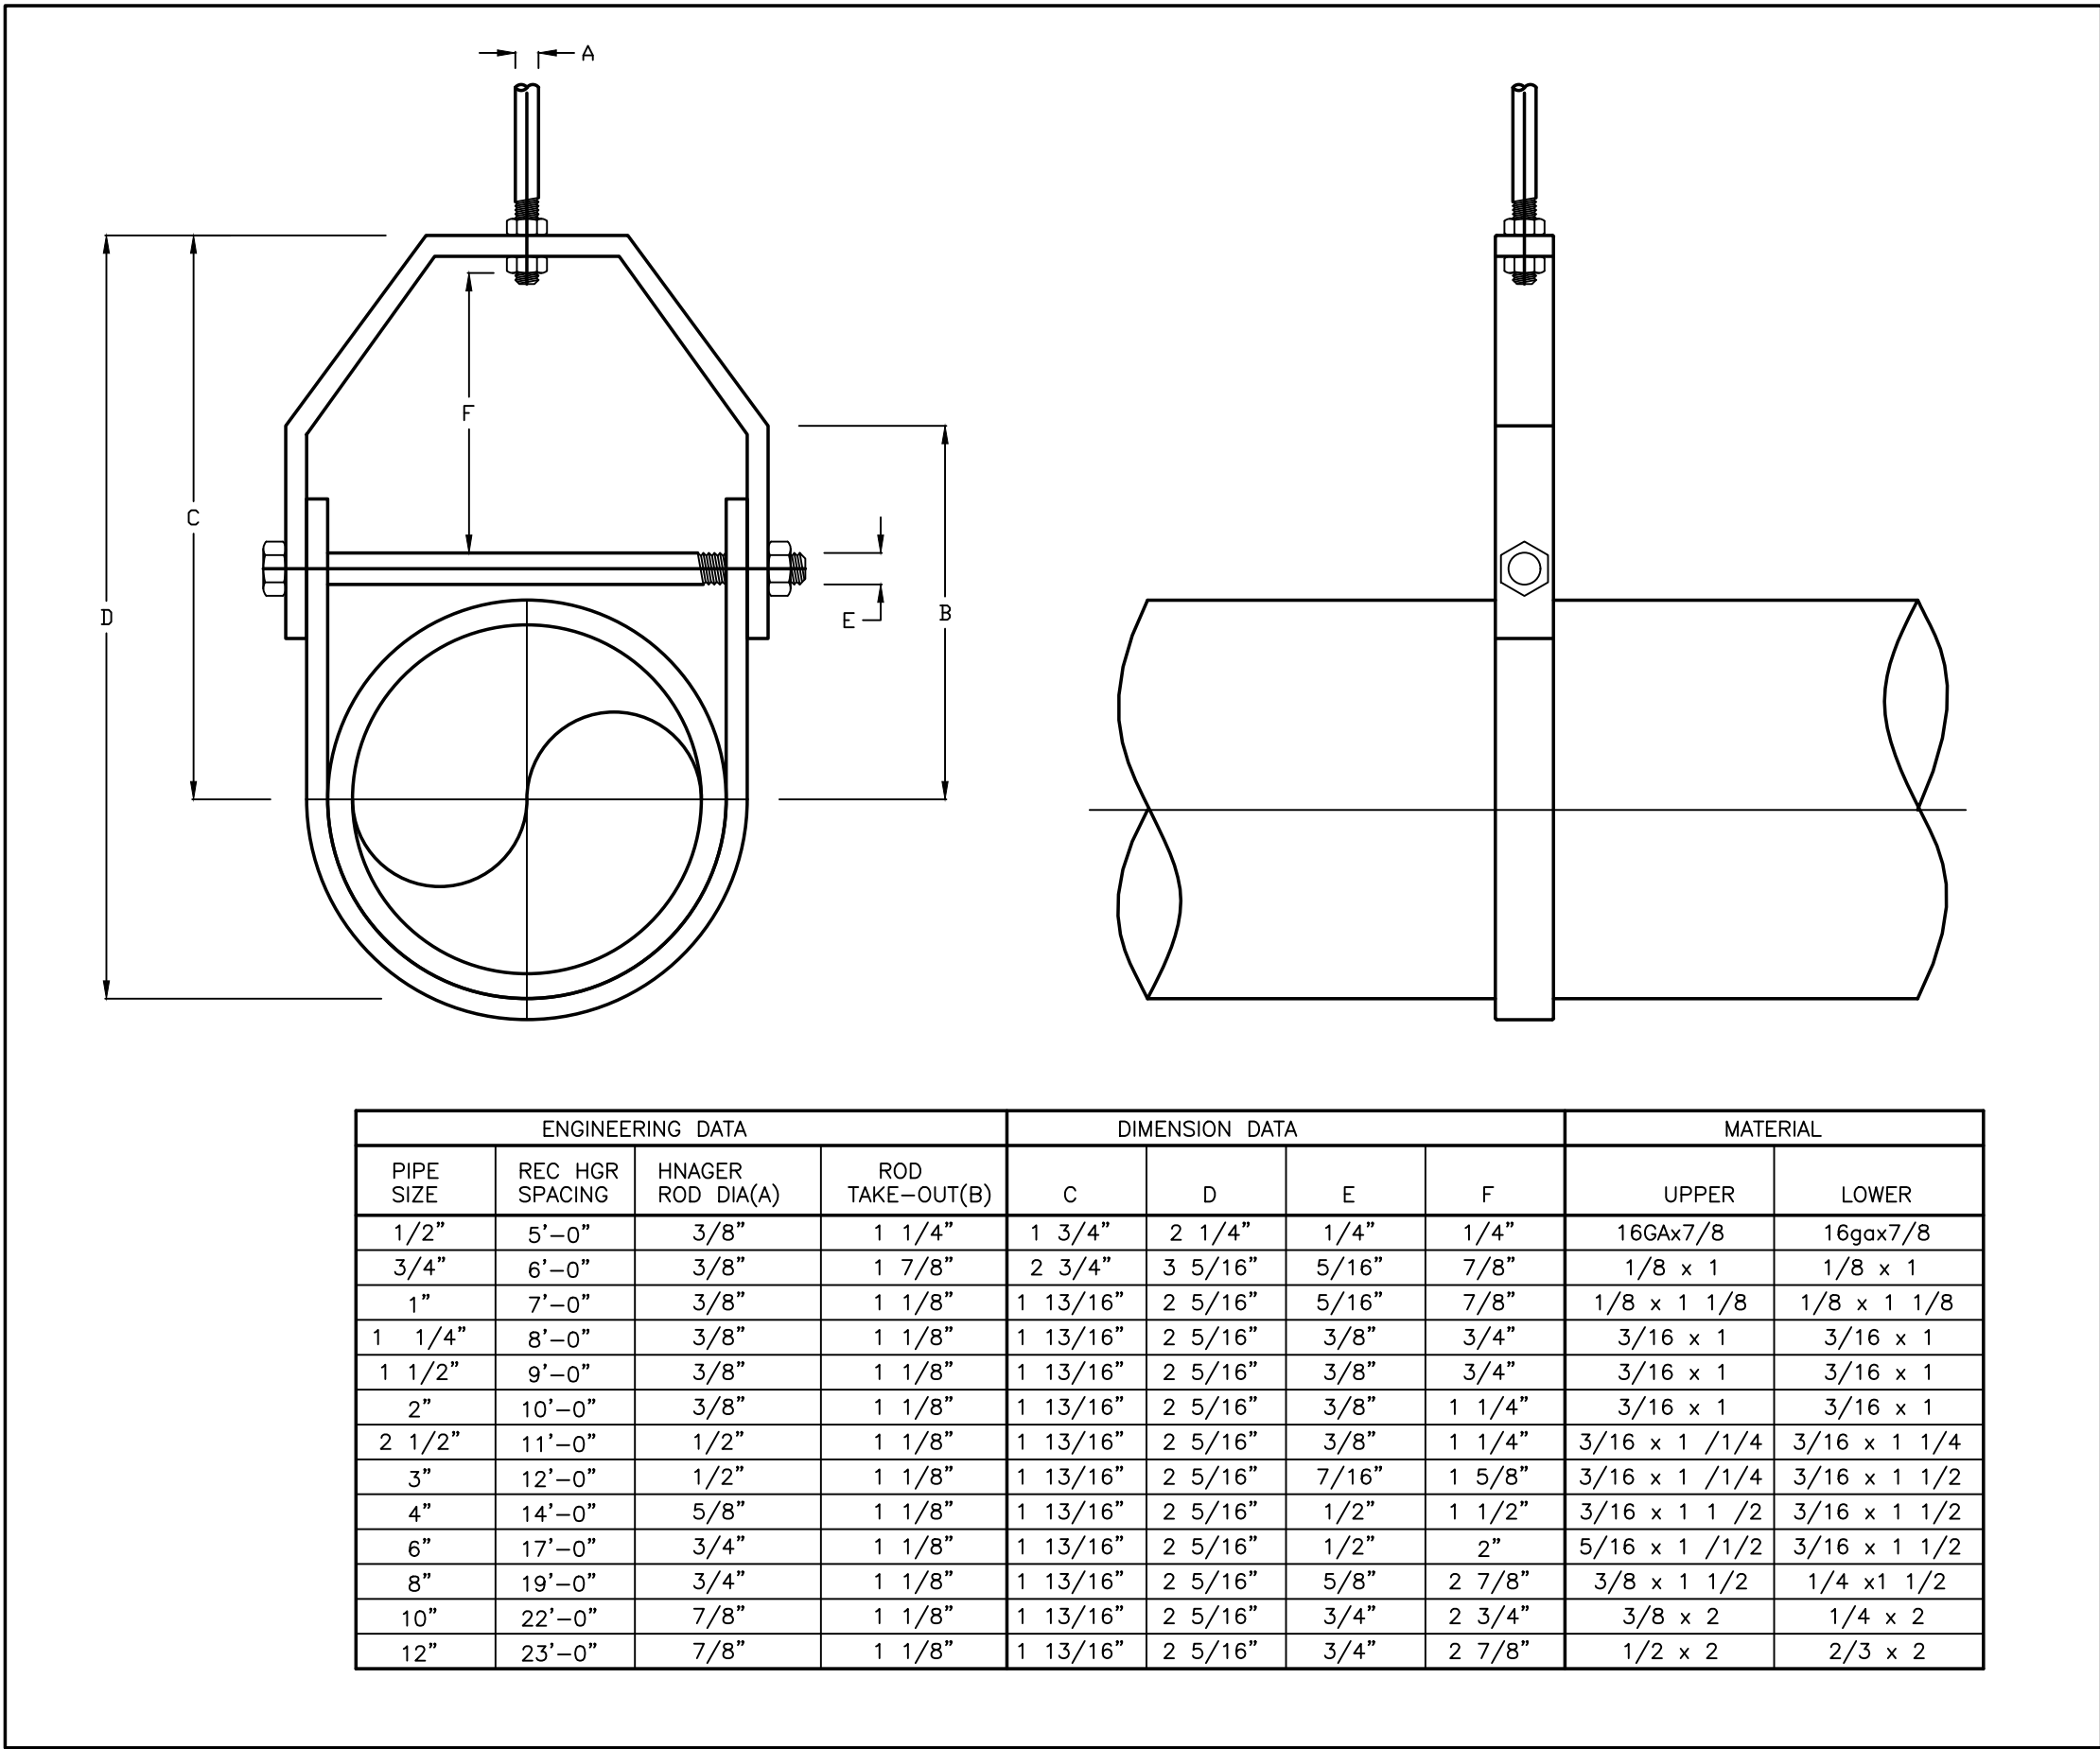

2 STANDARD CLEVIS HANGER
M-903 N.T.S.

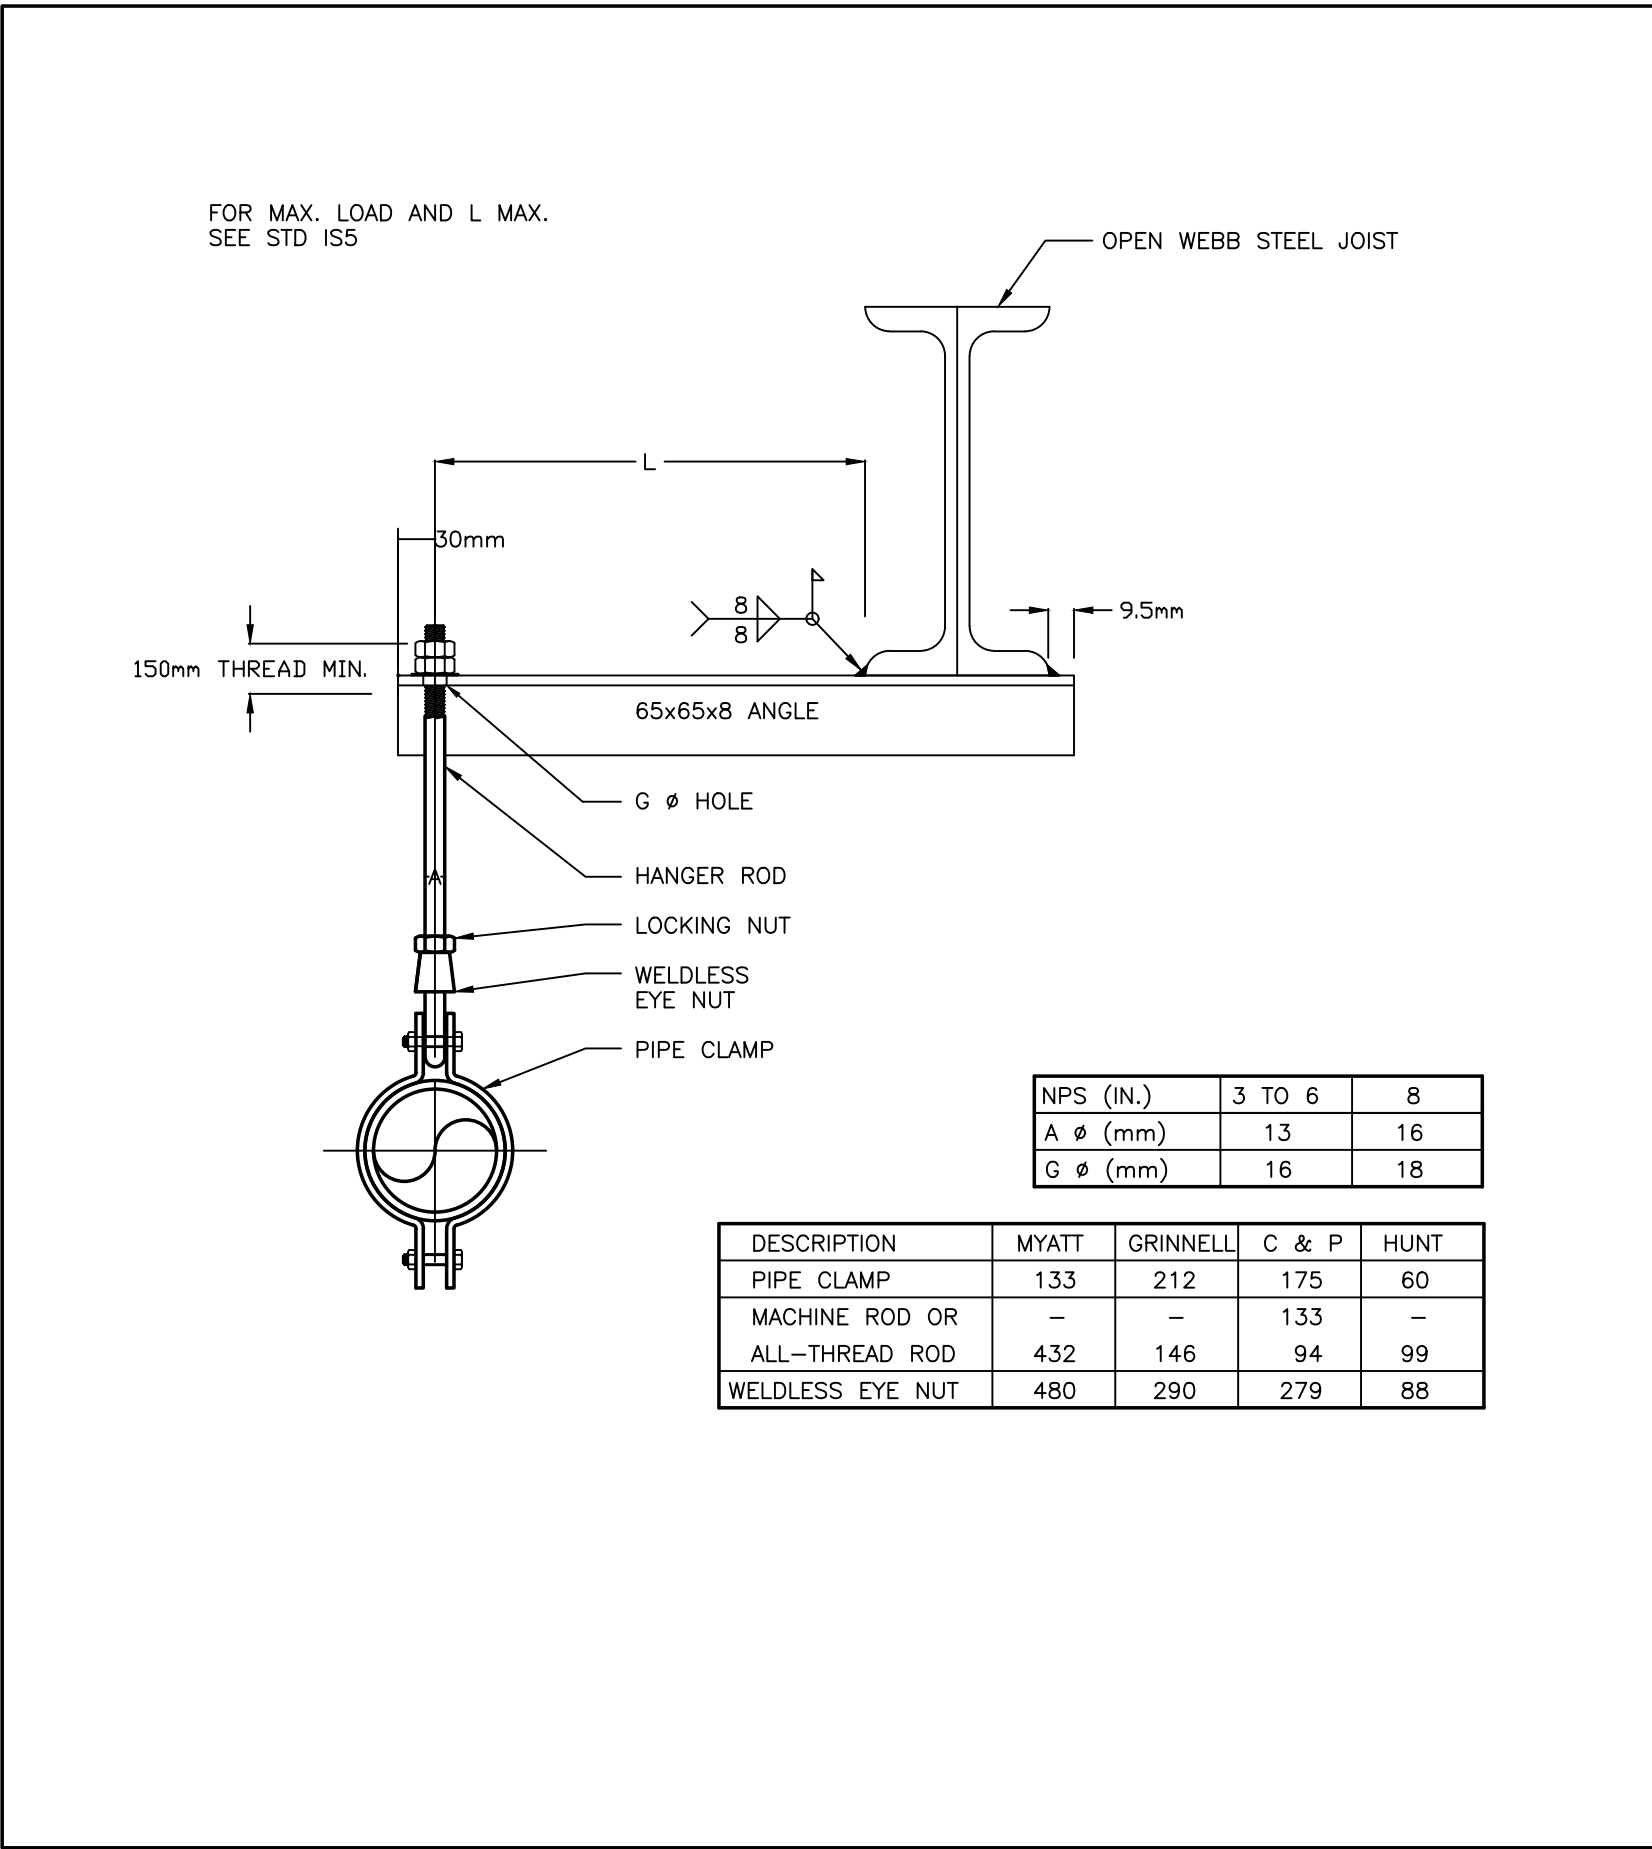

1 PS-01 WELDED BRACKET WITH HANGER (UNINSULATED 3-8")
M-903 N.T.S.

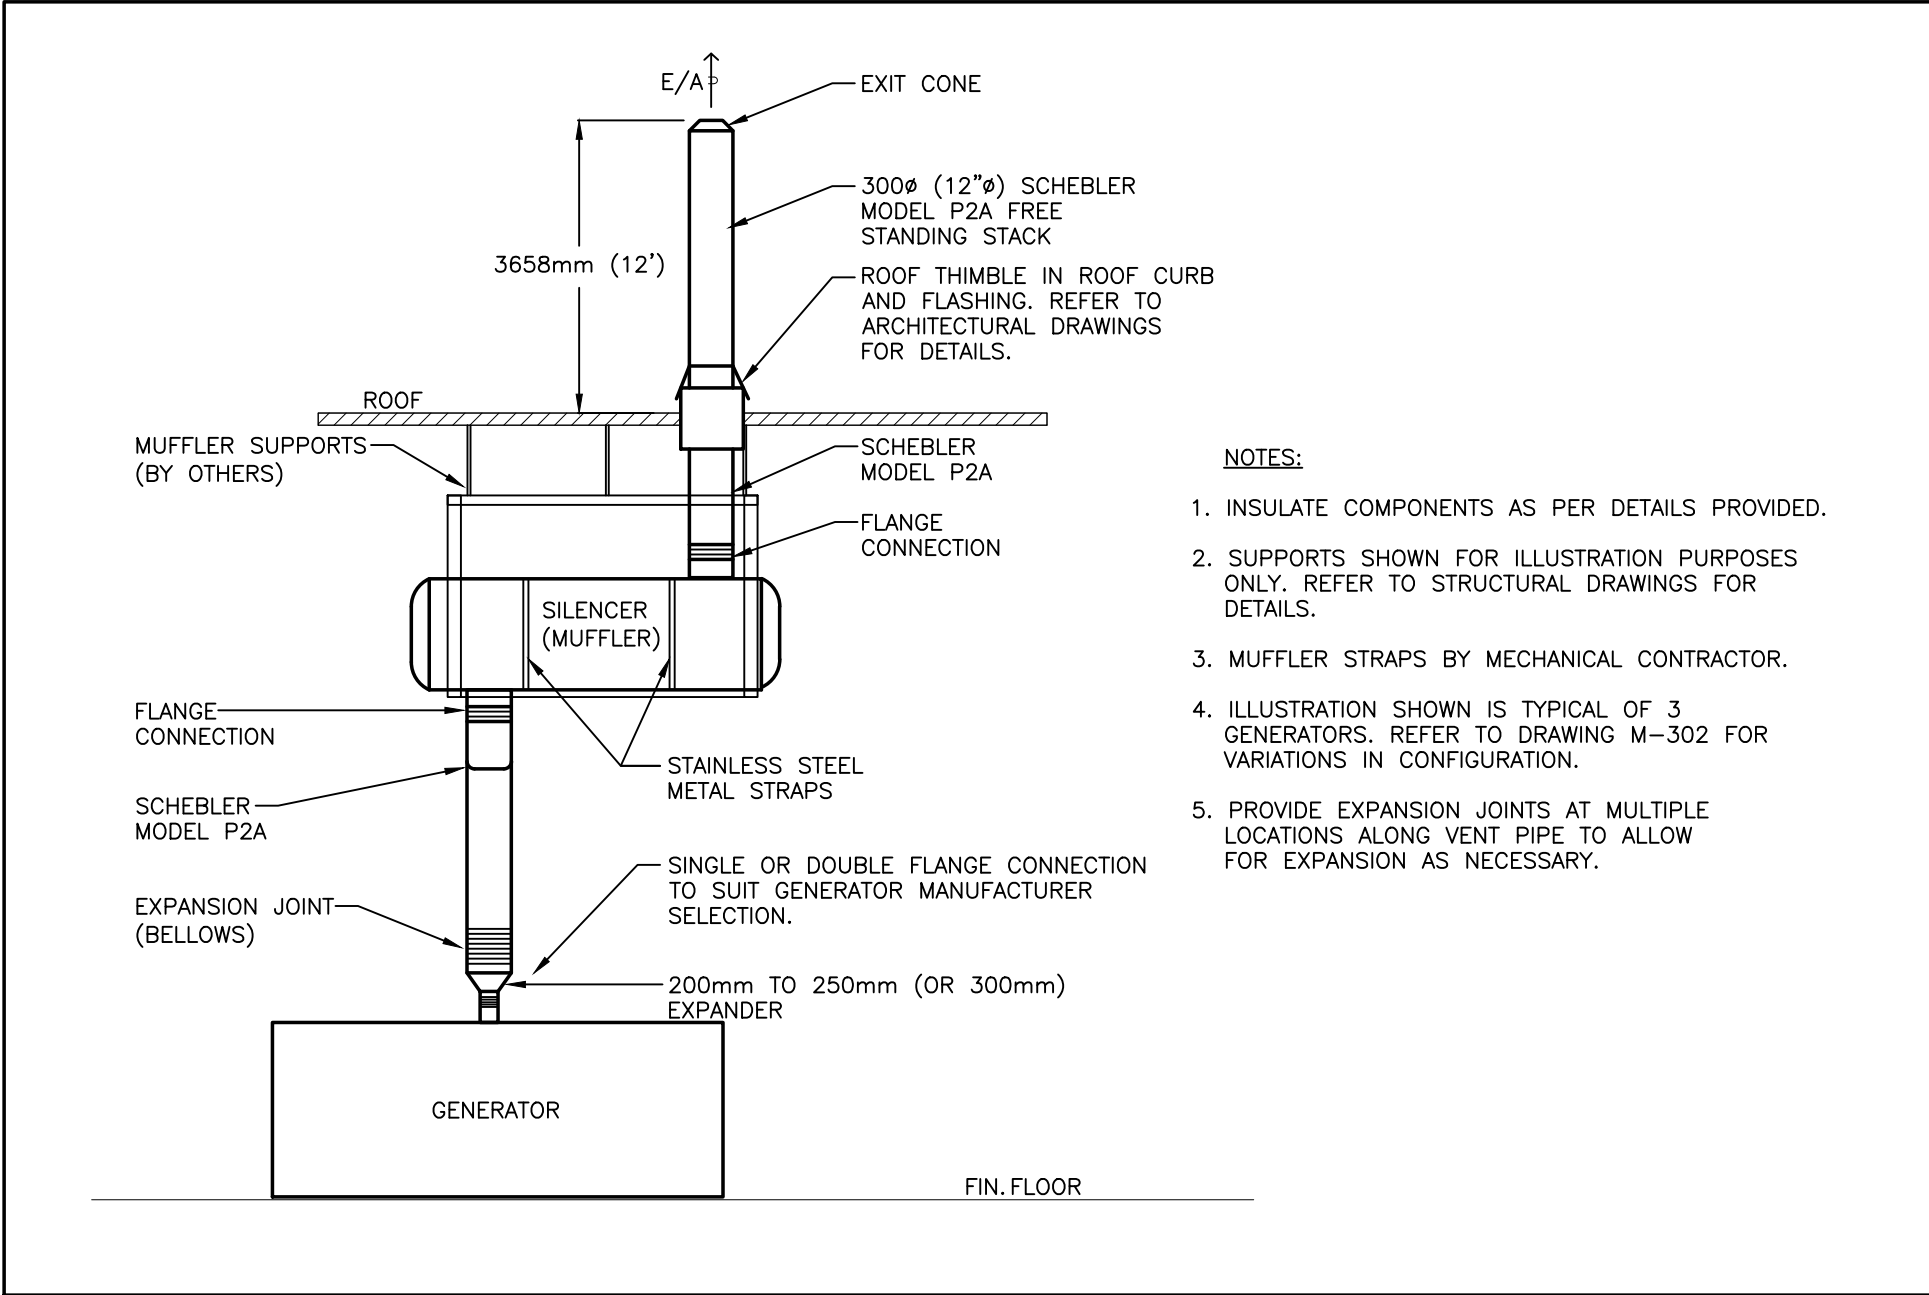

3 GENERATOR EXHAUST SYSTEM - ELEVATION
M-903 N.T.S.

Key Plan:

Consultant:

m MORRISON HERSHFIELD
Suite 300, 125 Commerce Valley Drive W.
Markham, ON L3T 7W4
Tel: (416) 499-3110 Fax: (416) 499-9658

Seal:

4	ISSUED FOR TENDER	JUN 13/19	GF
3	ISSUED FOR BUILDING PERMIT	JUN 3/ 19	GF
1	ISSUED FOR 100% REVW	APR. 26/19	GF
A	ISSUED FOR CLIENT REVIEW	DEC 13/18	GF
REV	DESCRIPTION	DATE	BY

DO NOT SCALE DRAWINGS. CONTRACTOR MUST VERIFY ALL DIMENSIONS AND ADVISE CONSULTANTS OF ANY ERRORS OR OMISSIONS. NO VARIATIONS OR MODIFICATIONS TO WORK SHOWN SHALL BE IMPLEMENTED WITHOUT PRIOR WRITTEN APPROVAL. ALL PREVIOUS ISSUES OF THIS DRAWING ARE SUPERSEDED BY THE LATEST REVISION. ALL DRAWINGS AND SPECIFICATIONS REMAIN THE PROPERTY OF MORRISON HERSHFIELD LIMITED.

Client:

Ontario Shores
Centre for Mental Health Sciences

Project:

NEW POWERHOUSE
700 GORDON STREET, WHITBY, ON L1N 5S9

Sheet Title:

STANDARD DETAILS

Drawn By:	N.P.	Date:	08/20/18
Designed By:	G.F.	Checked By:	G.F.
Scale:	N.T.S.	File Path:	BM_302/1/18 - 1802218 - Ontario Shores Powerhouse/1802218-Ontario Shores Powerhouse-M-903-18-0001.vnt
Project No:	1802218	Drawing No:	M-903