



THE REGIONAL MUNICIPALITY OF DURHAM
WORKS DEPARTMENT
EXPAND GARAGE
SCUGOG DEPOT
TOWNSHIP OF SCUGOG
CONTRACT NO. T-1038-2019

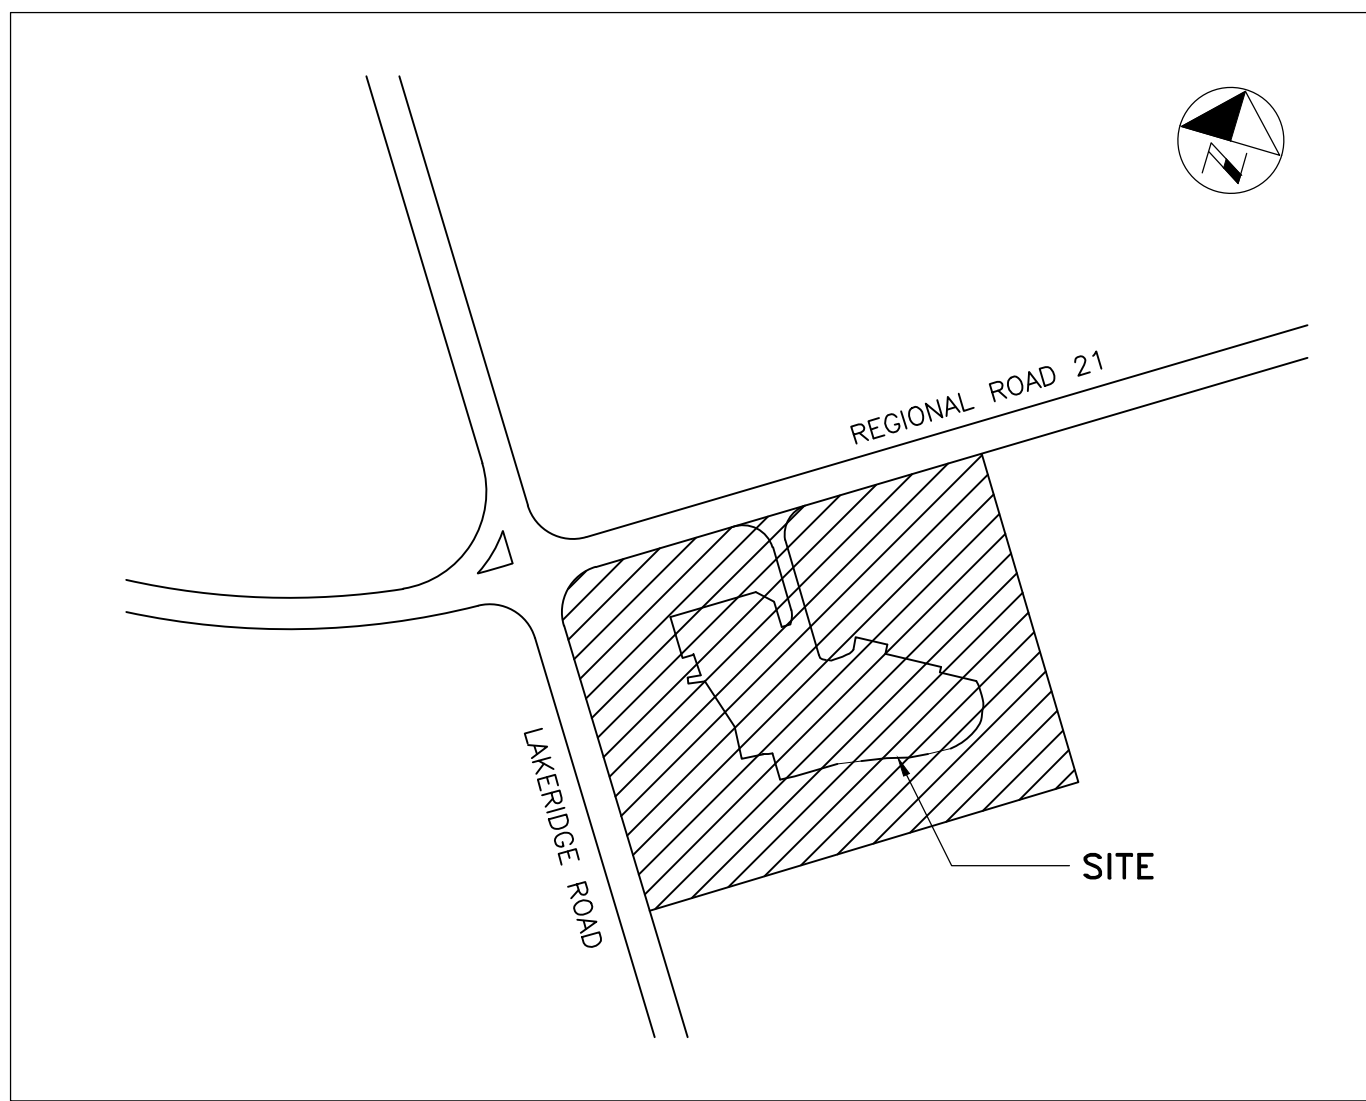

KEY PLAN
N.T.S.

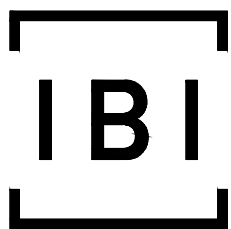

IBI GROUP
100-175 Galaxy Boulevard
Toronto ON M9W 0C9 Canada
tel 416 679 1930 fax 416 675 4620
ibigroup.com

PROJECT NO. 24RX12.0113

D R A W I N G L I S T

GENERAL	ARCHITECTURAL	STRUCTURAL	MECHANICAL	ELECTRICAL	PROCESS
02-G00-00-00 COVER PAGE, DRAWING LIST	02-A00-00-01 CODE DATA MATRIX, FIRE SEPARATION PLAN 02-A10-00-00 SITE PLAN 02-A21-01-01 FIRST FLOOR PLAN 02-A23-00-01 ROOF PLAN 02-A30-00-01 BUILDING ELEVATIONS 02-A31-00-01 BUILDING CROSS SECTIONS 02-A40-00-01 WALL SECTIONS 02-A41-00-01 SECTION DETAILS 02-A42-00-01 PLAN DETAILS 02-A42-00-02 PLAN DETAILS 02-A43-00-01 ROOF DETAILS 02-A45-00-01 DOOR DETAILS 02-A46-00-01 MISCELLANEOUS DETAILS 02-A83-00-01 LADDER DETAILS 02-A90-00-01 ROOM AND DOOR SCHEDULE	02-S00-00-01 GENERAL NOTES 02-S00-00-02 ROOF SNOW AND WIND LOAD DIAGRAMS 02-S00-00-03 TYPICAL DETAILS 02-S00-00-04 TYPICAL DETAILS 02-S10-00-01 FOUNDATION PLAN 02-S11-00-01 SLAB ON GRADE PLAN 02-S20-00-01 ROOF FRAMING PLAN 02-S30-00-01 ELEVATIONS 02-S40-00-01 SECTIONS AND DETAILS 02-S40-00-01 FOOTING, PIER AND COLUMN SCHEDULES 02-S40-00-02 SECTIONS AND DETAILS 02-S50-00-01 SECTIONS AND DETAILS 02-S50-00-02 SECTIONS AND DETAILS	02-M01-00-01 LEGEND AND SYMBOLS 02-M10-00-01 EQUIPMENT SCHEDULES 02-M21-00-01 U/G DRAINAGE FLOOR PLAN 02-M21-01-01 A/G PLUMBING & STORM DRAINAGE FLOOR PLAN 02-M26-00-01 PLUMBING & DRAINAGE DETAILS 02-M46-00-01 FIRE PROTECTION DETAILS 02-M51-01-01 HVAC & FIRE PROTECTION FLOOR PLAN 02-M51-03-01 HVAC ROOF PLAN 02-M56-00-01 HVAC DETAILS 02-M63-00-01 HVAC SECTIONS 02-M74-00-01 CONTROL SCHEMATICS 02-M74-01-01 CONTROL SCHEMATICS & BMS ARCHITECTURE 02-M80-00-01 DEMOLITION FLOOR PLAN	02-E00-00-01 ELECTRICAL LAYOUT LEGEND 02-E00-00-02 ELECTRICAL SINGLE LINE SYMBOLS 02-E01-00-01 ELECTRICAL SITE PLAN 02-E09-00-01 ELECTRICAL SITE DETAILS 02-E09-00-02 ELECTRICAL SITE DETAILS 02-E10-00-01 ELECTRICAL SINGLE LINE DIAGRAM 02-E11-01-01 MAIN BUILDING POWER LAYOUT 02-E19-01-01 PANEL SCHEDULES 02-E21-01-01 MAIN BUILDING LIGHTING LAYOUT 02-E29-00-01 LIGHTING DETAILS, LV CONTROL DIAGRAM 02-E29-00-02 LUMINAIRE SCHEDULE, LIGHTING CONTROL SEQUENCE 02-E30-00-01 AUXILIARY SYSTEM RISER DIAGRAM -1 02-E30-00-02 AUXILIARY SYSTEM RISER DIAGRAM -2 02-E31-01-01 MAIN BUILDING AUXILIARY SYSTEM LAYOUT 02-E39-00-01 TELECOM ROOM LAYOUT AND DETAILS 02-E39-00-02 SECURITY SYSTEM DETAIL 02-E39-00-03 SECURITY SYSTEM DETAIL 02-E61-01-01 MAIN BUILDING GROUNDING & LIGHTNING PROTECTION LAYOUT	02-Q20-01-01 PROCESS FLOW DIAGRAMS 02-Q40-01-01 REPAIR BAYS PROCESS LAYOUT
CIVIL	02-C00-00-01 LEGEND AND NOTES 02-C00-00-02 TOPOGRAPHIC SURVEY 02-C10-00-01 SITE GRADING PLAN 02-C20-00-01 SITE SERVICING PLAN				



BUILDING CLASSIFICATION :

PROPOSED ADDITION
GROUP F, DIVISION 2
F2 MEDIUM HAZARD INDUSTRIAL
OBC 3.2.2.70

SURVEY REFERENCE & LEGAL DESCRIPTION:

TOPOGRAPHIC PLAN OF
PART OF LOT 1
CONCESSION 4
TOWNSHIP OF SCUGOG
REGIONAL MUNICIPALITY OF DURHAM

J.D. BARNES LIMITED
LAND INFORMATION SPECIALISTS
JAN 08 2013

REF. NO. 12-25-724-00


SITE PLAN NOTES:

- EXISTING SITE INFORMATION REFER TO CIVIL DRAWINGS
- ALL GRADING ELEVATIONS AND UNDERGROUND SERVICES SHOWN ON THE DRAWING ARE FOR REFERENCE ONLY. FOR LOT GRADING AND STORM WATER DRAINAGE REFER TO SITE GRADING AND SERVISING DRAWINGS.
- FOR EXTERIOR SITE LIGHTING REFER TO ELECTRICAL DRAWINGS.
- ALL CONSTRUCTION WORK SHALL COMPLY WITH THE REGIONAL MUNICIPALITY OF DURHAM AND ONTARIO PROVINCIAL STANDARDS AND SPECIFICATIONS.

SITE LEGEND:

- PROPERTY LINE
- SETBACK LINE
- FIRE ACCESS ROUTE
- EXISTING CHAIN LINK FENCE (CLF)
- PEDESTRIAN DOOR LOCATION (EXIT/ACCESS DOOR)
- OVERHEAD DOOR LOCATION
- BARRIER FREE PARKING SPACE
- BARRIER FREE RAMP COMPLETE WITH CURB DEPRESSION
- CONCRETE CURB
- PARKING COUNT
- FIRE HYDRANT
- BOREHOLE LOCATION
- SETTING OUT POINT
- LIGHT STANDARD
- EXISTING TREE TO REMAIN
- EXISTING TREE TO REMOVE
- EXISTING FACILITY
- PROPOSED ADDITION



DATE (mm dd yyyy)	ISSUED FOR	REV
OCT 01 2018	TENDER	0

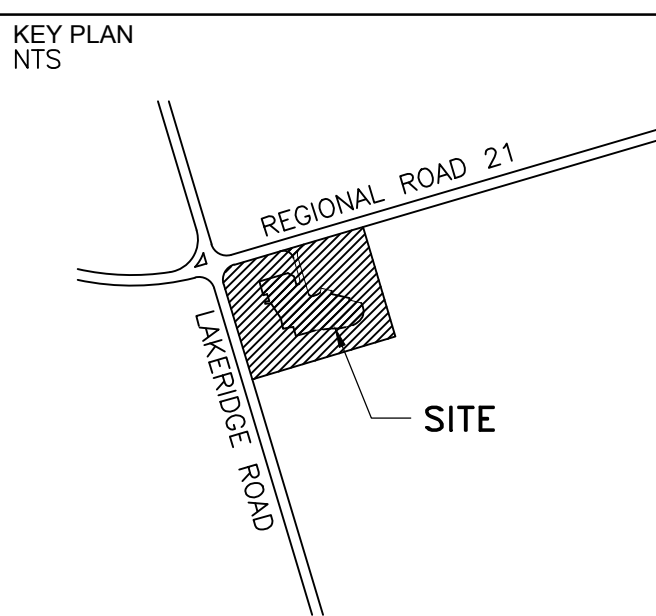


CONSULTANTS



This drawing has been prepared solely for the use of the Regional Municipality of Durham and there are no representations of any kind made by IBI Group to any party with whom IBI Group has not entered into a contract

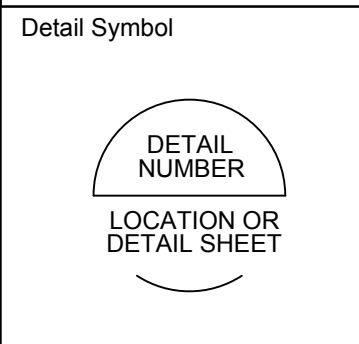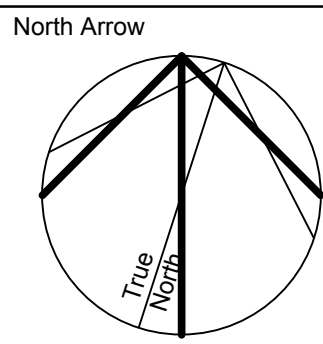


Project Manager A. VAN VEEN	Architect/Engineer A.V.V. / S.K.
Project Leader R.K. / R.F.	Drawn D.V.
Date NOV 2012	Checked L. BANDIERA

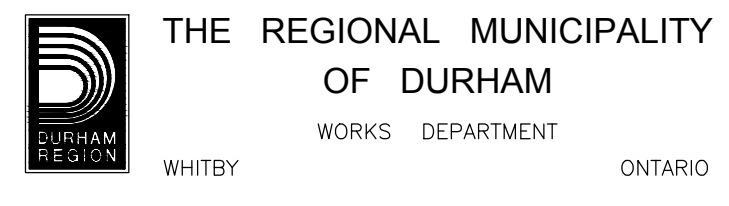


Project
**EXPAND GARAGE
SCUGOG DEPOT**
10 REGIONAL RD. 21, R.R.#14, PORT PERRY

Drawing Title
SITE PLAN

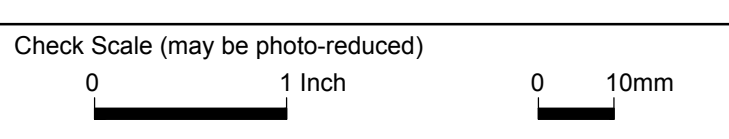

Project No. 24RX12.0113	Drawing No. 02-A10-00-00
----------------------------	-----------------------------

ROD Contract No.
T-1038-2019

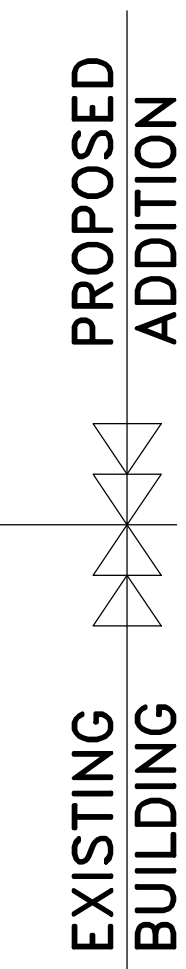


VERIFY AHU AND AC CURB AND ROOF OPENING
CLEARANCES WITH AHU AND AC CONTRACTOR AND
SHOP DRAWINGS

EXHAUST STACKS AND VENTS REFER
DET. 1/02-A43-00-01 AND MECHANICAL DWGS
FOR QUANTITY AND LOCATIONS

GAS VENTS REFER DET. 2/02-A43-00-01
AND MECHANICAL DWGS FOR QUANTITY AND LOCATIONS

Project No.	Drawing No.
24RX12.0113	02-A23-00-01

ROD Contract No.
T-1038-2019

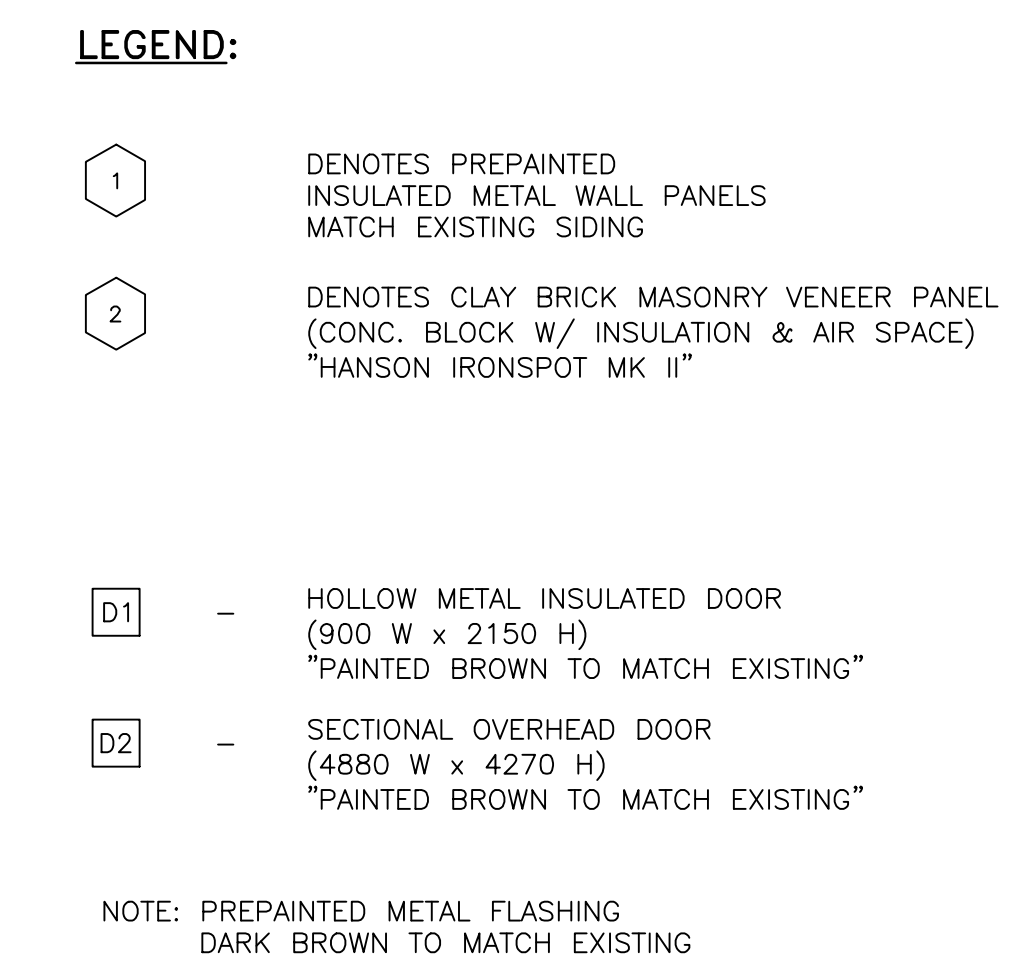

Architectural section drawing showing the existing building and proposed addition. The drawing includes various annotations and elevation markers.

EXISTING BUILDING (Solid lines)

PROPOSED ADDITION (Dashed lines)

Annotations:

- EXIST. STEEL STAIR TO UPPER LEVEL
- PREPARED METAL CAP FLASHING (TYP)
- T.O.S. EL. 7000 (L.P.)
- T.O.S. EL. 7810 (L.P.)
- T.O.S. EL. 3700 (L.P.)
- FIN. FLOOR EL. 0000

Grid Lines: 1, 2, 3, 4, 5, 6, 7, 8, 9

Other Markers: 01, 02, 03, 99, 100

LADDER No. 2
 REFER DWG. 02-A83-00-01

EXIST. REPAIR BAY

Dimensions: 1200, 1200, 1200, 1200, 1200, 1200, 1200

Elevations:
 T.O.S. EL. 7032
 T.O.S. EL. 7000 (LP)
 T.O. EAVE EL. 6299
 T.O.S. EL. 3790 (HP)
 T.O. EAVE EL. 6095
 T.O.S. EL. 3700 (LP)

Structural Details:
 PREPARED METAL CAP FLASHING (TYP)
 STIFFENERS (TYP)
 SCUPPER REFER DET. 13/02-A23-00-01
 STIFFENERS REFER DET. 8/ 02-A41-00-01 (TYP)
 PROVIDE 1800Wx2200H WALL OPENING

Handrail Guard:
 HANDRAIL GUARD
 02-A31-00-01

Other Labels:
 G.1, G, E.1, E, C.1, C, A.1, A, B', B, A, 1, 2, C.J., 2

SCUPPER
REFER DET.
12/02-A23-00-01

PREPARED METAL
CAP FLASHING
(TYP)

T.O.S.
EL. 7810 (LP)

T.O.S.
EL. 3700 (LP)

T.O.S.
EL. 7930 (HP)

T.O.S.
EL. 3790 (HP)






FIN. FLOOR
EL. 0000

EXHAUST FAN W/ HOOD
REFER MECH. DWG
3/02-A46-00-01

CONTROL JOINT (C-J)
REFER
DET. 3/02-A46-00-01
(TYP)

DATE (mm dd yyyy)	ISSUED FOR	REV
OCT 01 2018	TENDER	0
KEY PLAN		
CONSULTANTS		
IBI GROUP 100-175 Galaxy Boulevard Toronto ON M5W 0G9 Canada tel 416 679 1930 fax 416 675 4620 ibigroup.com This drawing has been prepared solely for the use of the Regional Municipality of Durham and there are no representations of any kind made by IBI Group to any party with whom IBI Group has not entered into a contract		
ONTARIO ASSOCIATION OF ARCHITECTS ANTHONY VAN VEEEN LICENSEE 3706 Mon 18/19 North Arrow Detail Symbol DETAIL NUMBER LOCATION OR DETAIL SHEET		
Project Manager A. VAN VEEEN Project Leader P.K. / R.F. Date NOV 2012 Client Architect/Engineer A.V.V. / S.K. Drawn D.V. Checked L. BANDIERA THE REGIONAL MUNICIPALITY OF DURHAM WORKS DEPARTMENT ONTARIO Project EXPAND GARAGE SCUGOG DEPOT 10 REGIONAL RD. 21, R.R.#14, PORT PERRY Drawing Title BUILDING ELEVATIONS Check Scale (may be photo-reduced) 0 1 inch 0 10mm Project No. 24RX12.0113 Drawing No. 02-A30-00-01		

User Name: Joseph Patel Plot Date: Time: Monday, March 18, 2019 2:42:35 PM Path and File Name: j:\24rx12.01\3. Durham region orono & scugog depot\5.3 drawing\3.dwg\layouts\02-a31-00-01.dwg

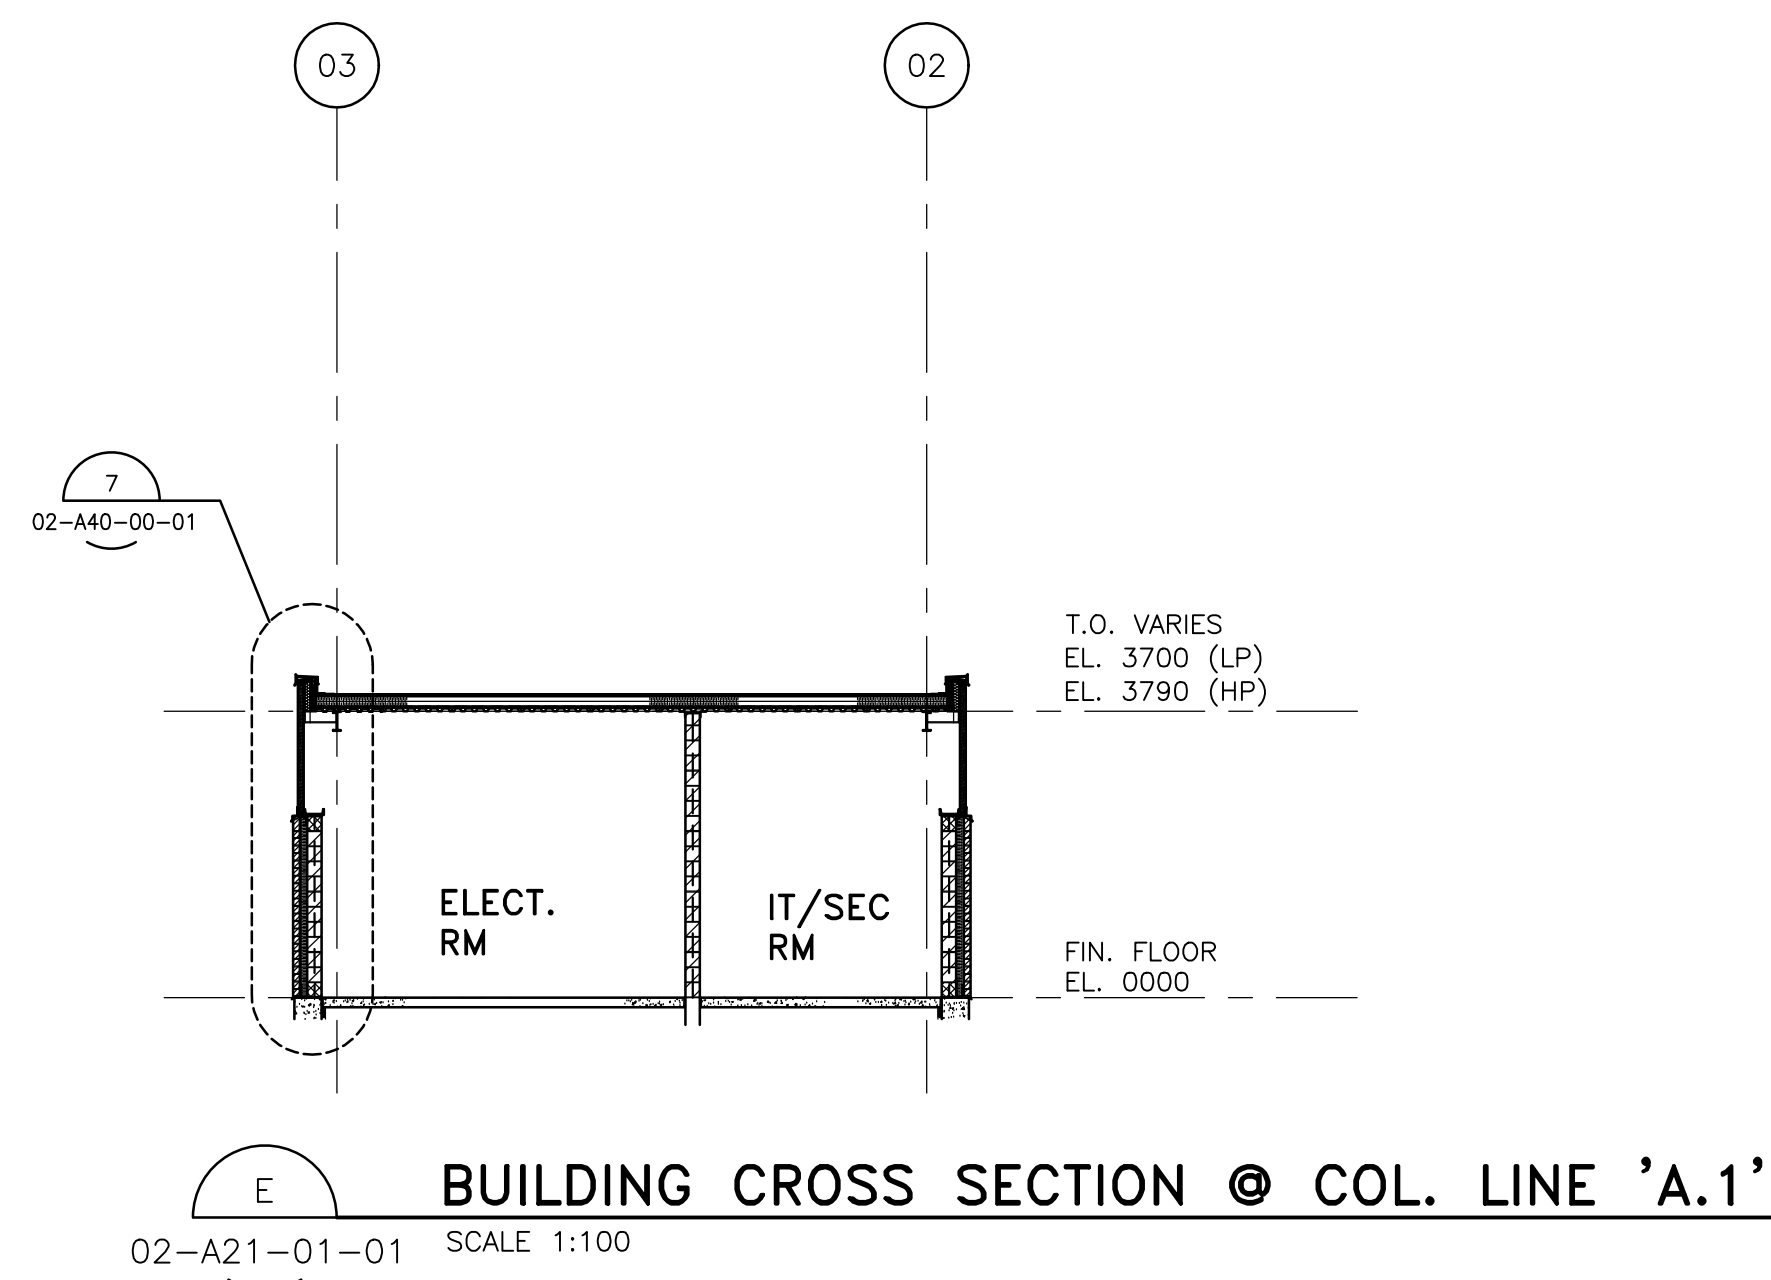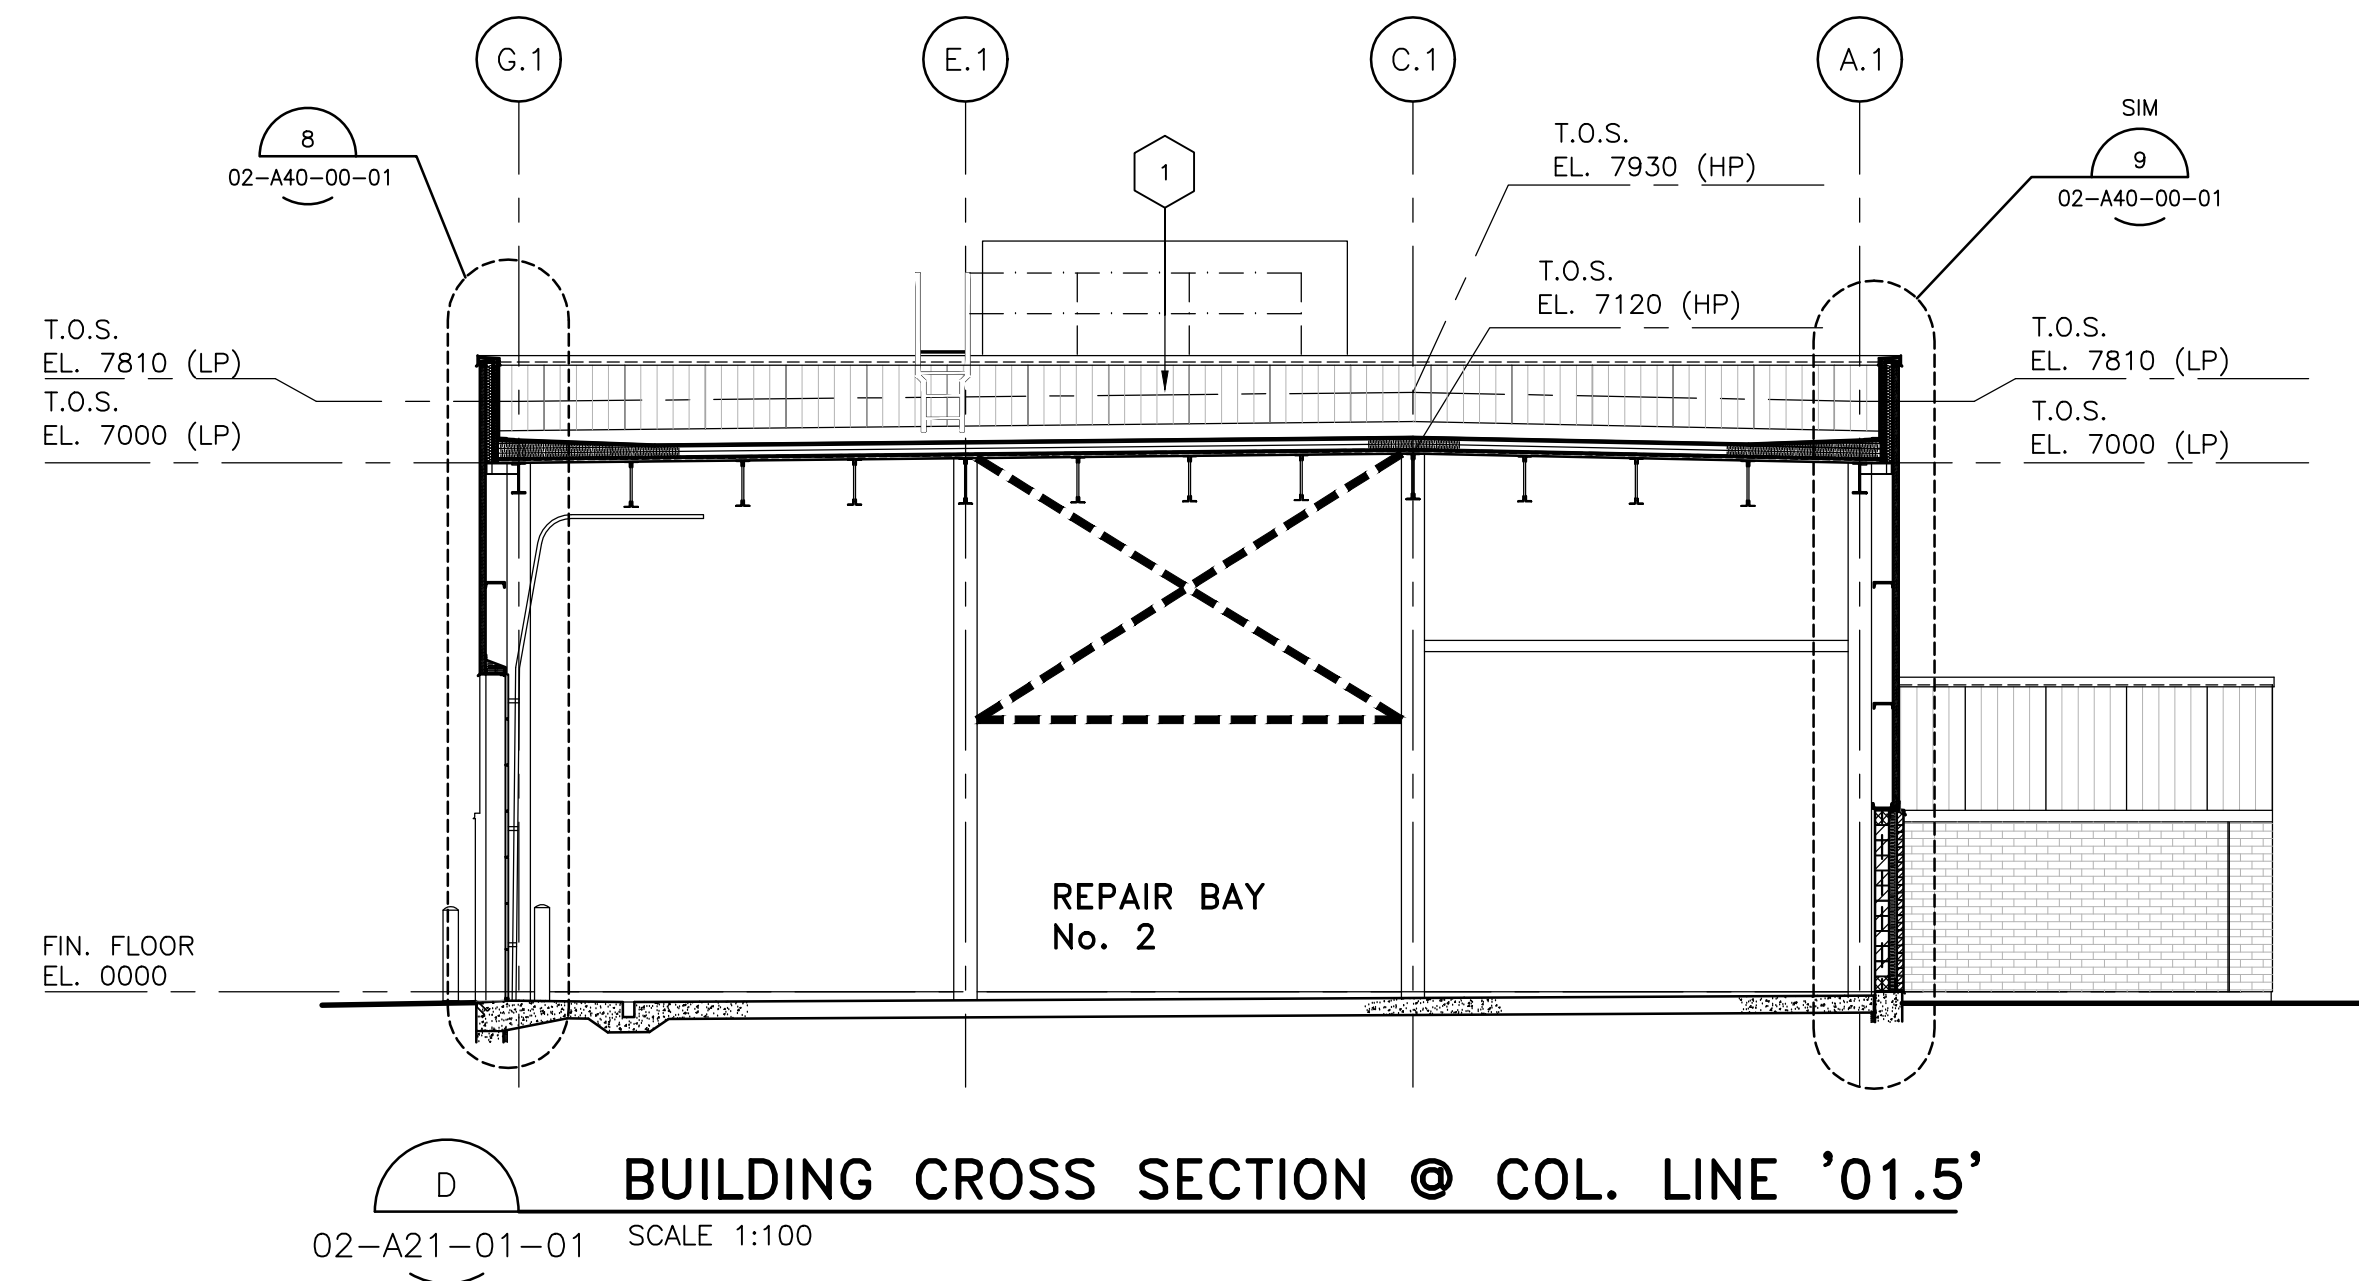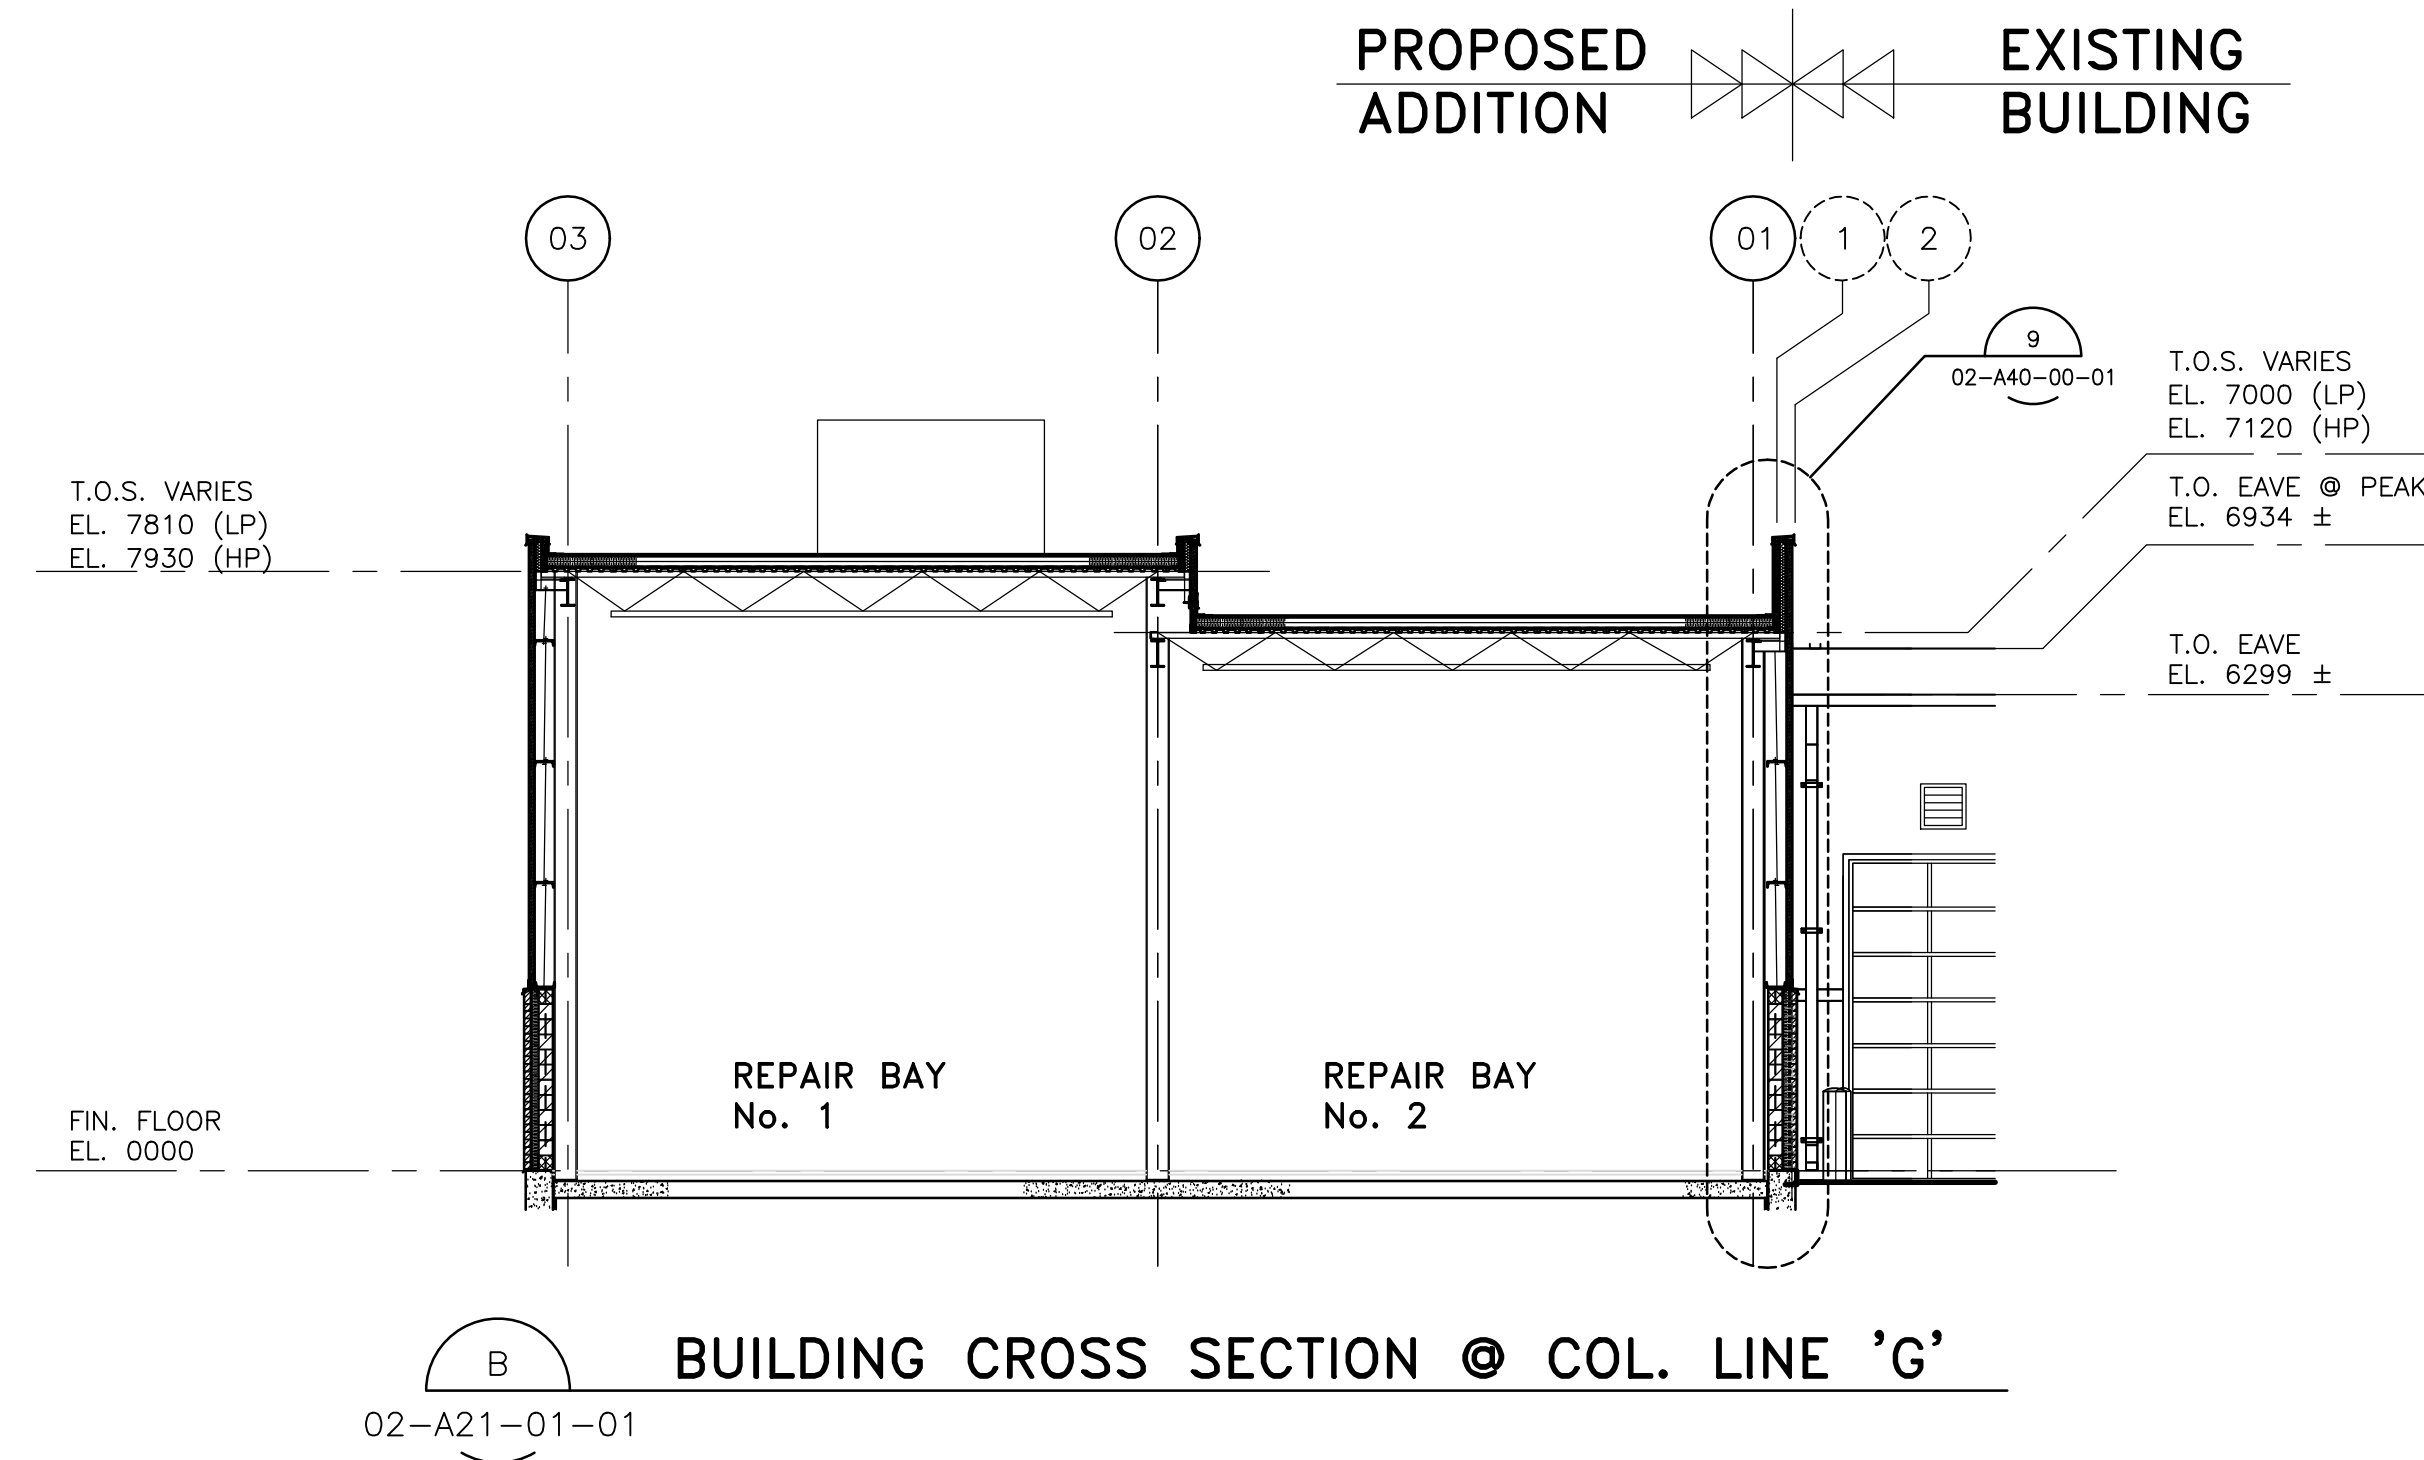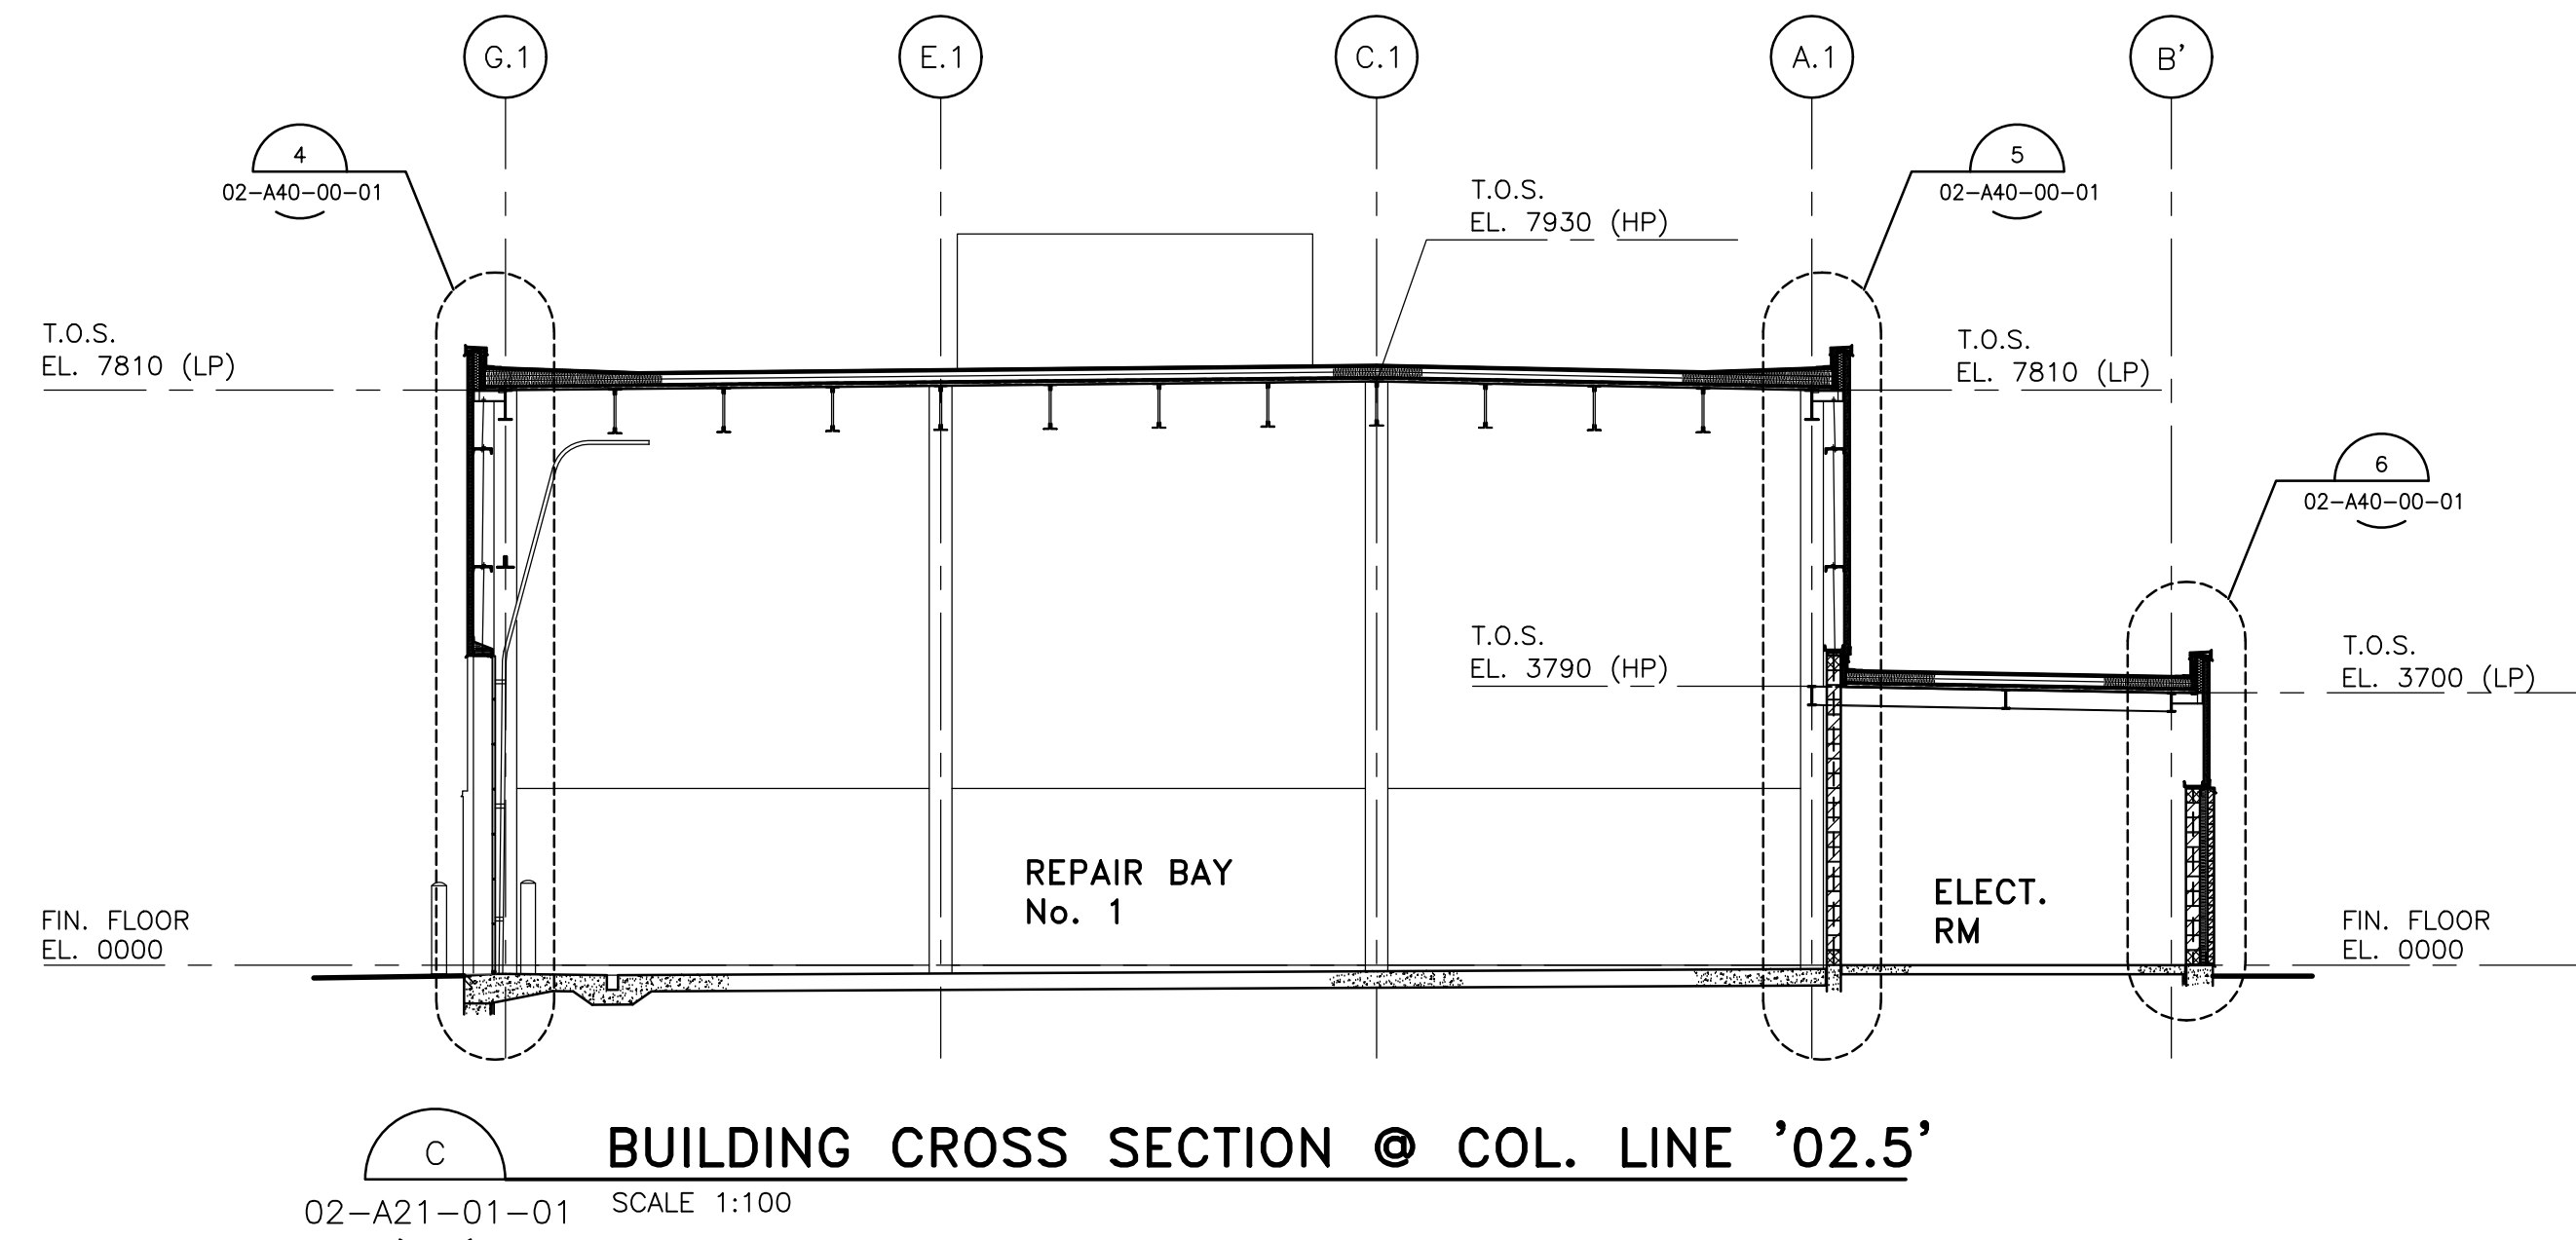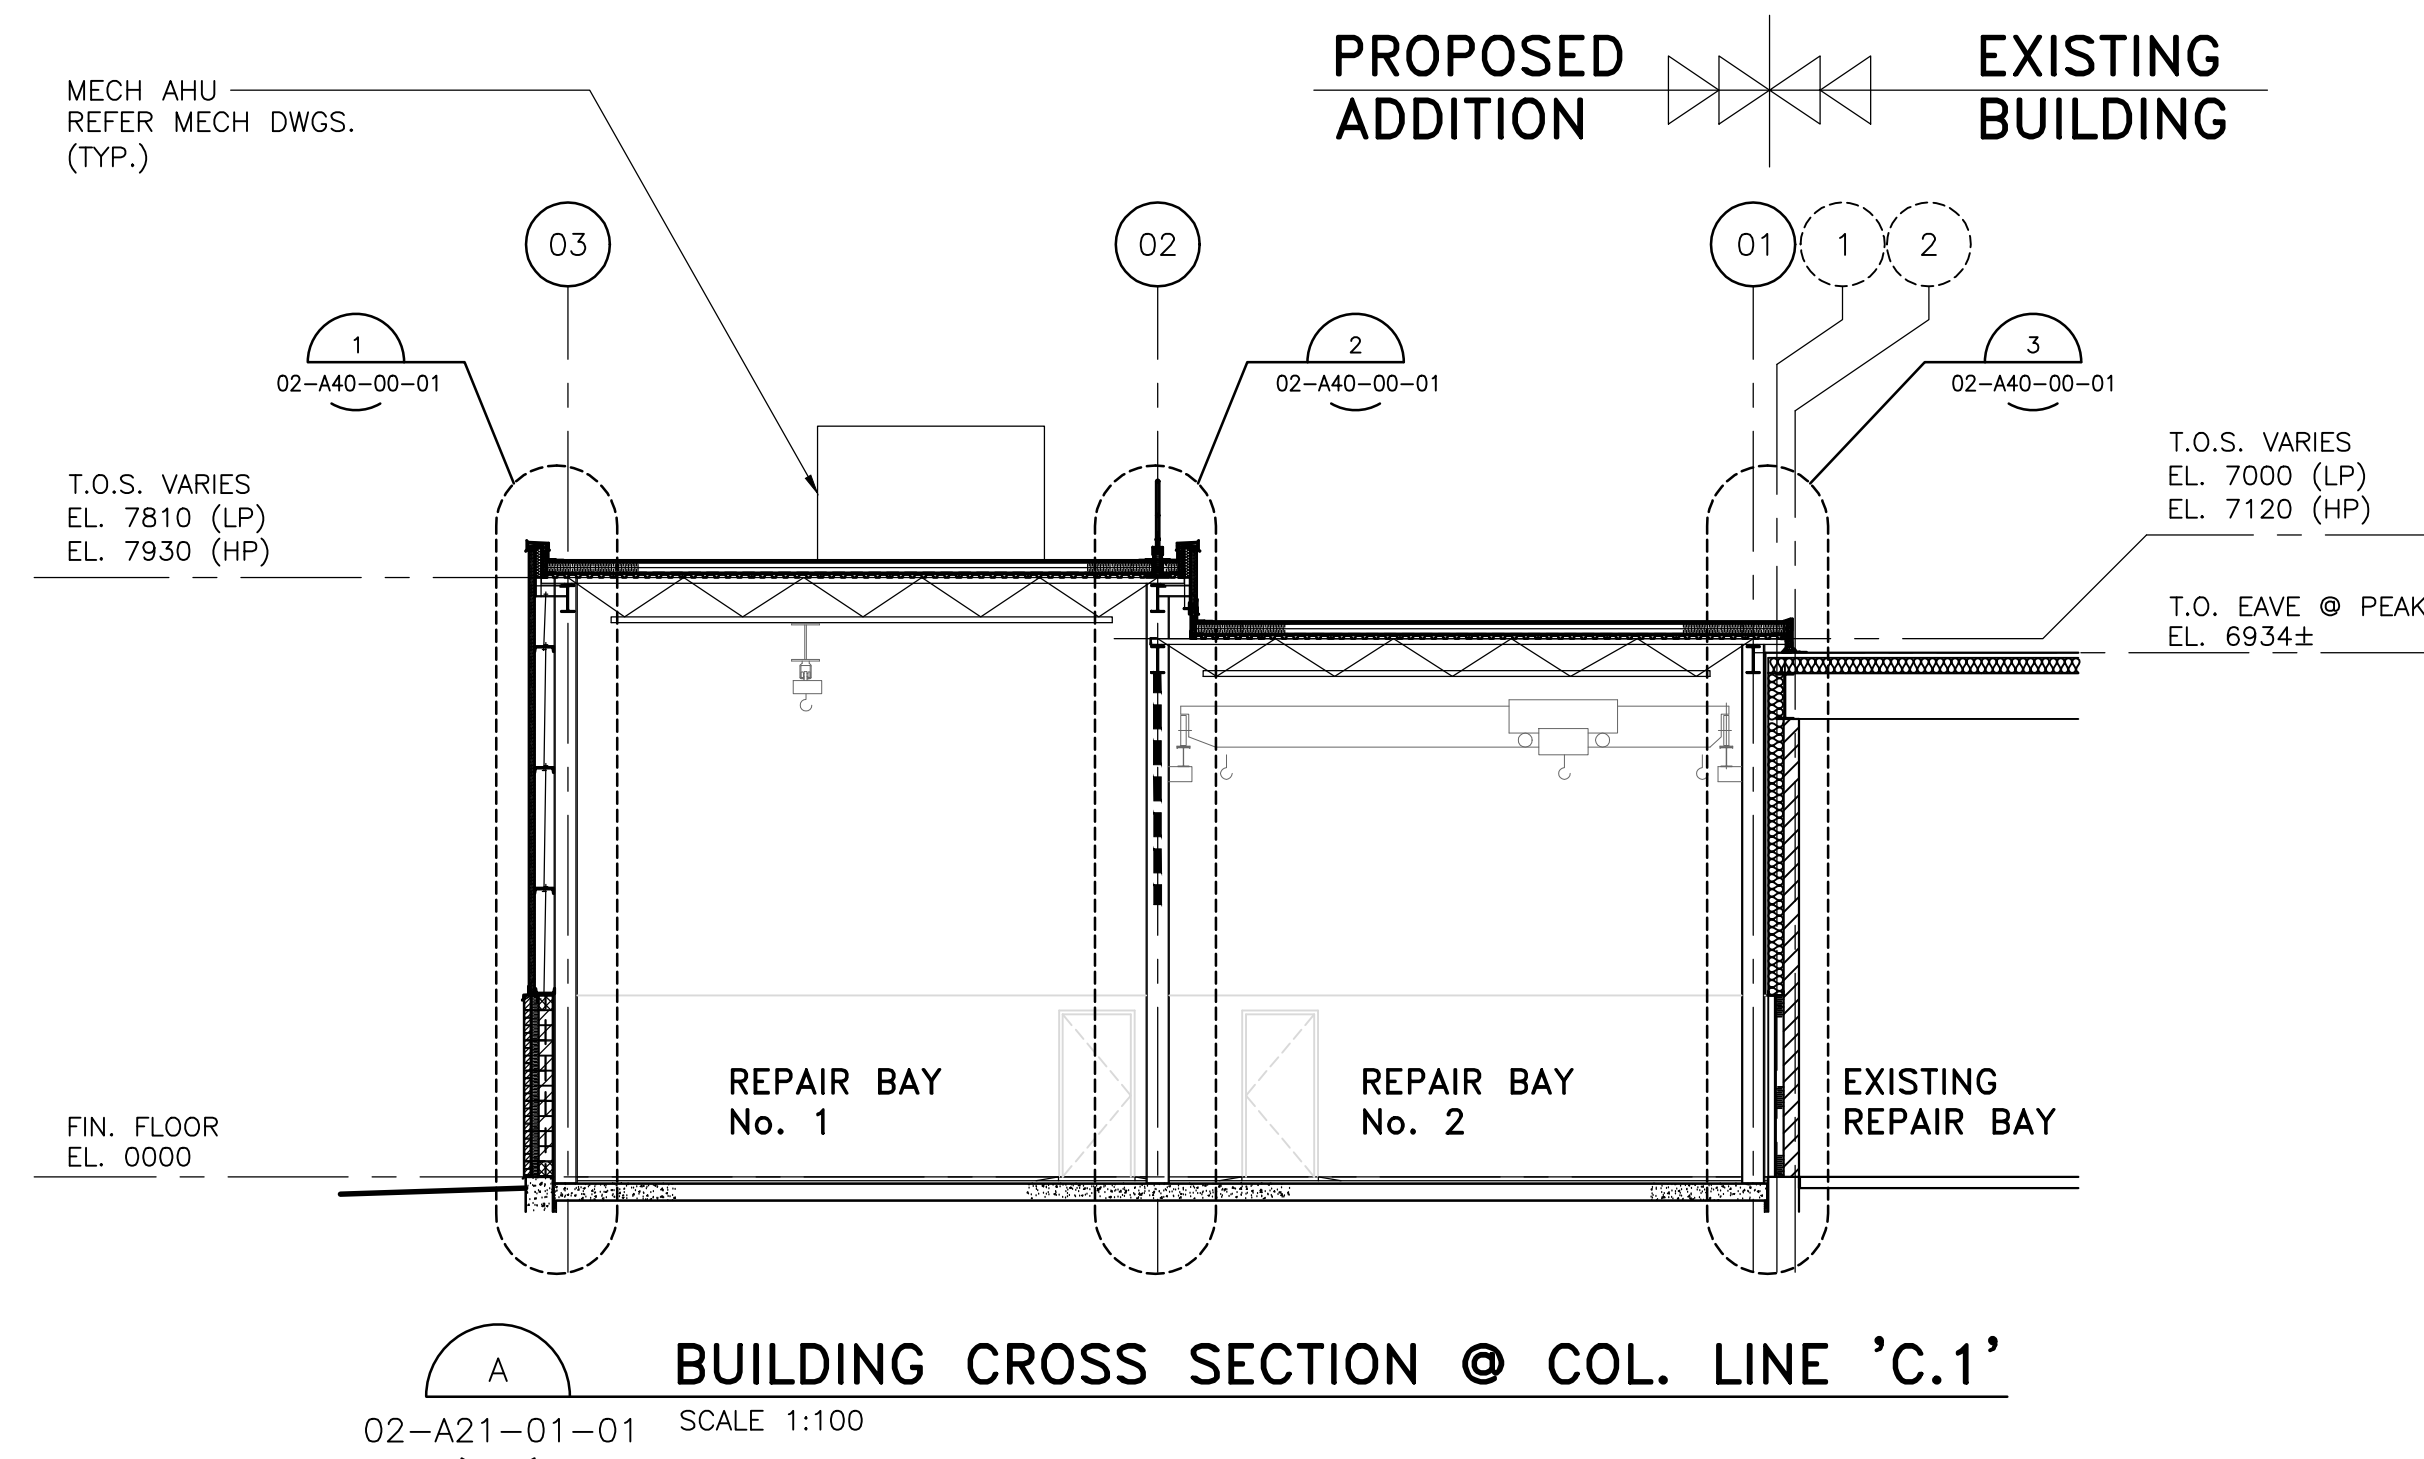

DATE (mm/dd/yyyy)	ISSUED FOR	REV
OCT 01 2018	TENDER	0
KEY PLAN		
CONSULTANTS		

IBI

IBI GROUP
100-175 Galaxy Boulevard
Toronto ON M9W 0C9 Canada
tel 416 679 1930 fax 416 675 4620
ibi@ibi.com

This drawing has been prepared solely for the use of the Regional Municipality of Durham and there are no representations of any kind made by IBI Group to any party with whom IBI Group has not entered into a contract

ONTARIO ASSOCIATION
OF
ARCHITECTS
ANTHONY VAN VEEN
LICENCE
2009
Mon 18/19

North Arrow

Detail Symbol











DETAIL
NUMBER

LOCATION OR
DETAIL SHEET

Project Manager A. VAN VEEN	Architect/Engineer A.V.V. / S.K.
Project Leader R.K. / R.F.	Drawn D.V. / M.F.
Date NOV 2012	Checked L. SANDIERA
Client THE REGIONAL MUNICIPALITY OF DURHAM WHITBY WORKS DEPARTMENT ONTARIO	
Project EXPAND GARAGE SCUGOG DEPOT 10 REGIONAL RD. 21, R.R.#14, PORT PERRY	
Drawing Title BUILDING CROSS SECTIONS	
Check Scale (may be photo-reduced) 0 1 inch 0 10mm	
Project No. 24RX12.0113	Drawing No. 02-A31-00-01

R00 Contract No.
T-1038-2019

User Name: Joseph Patel Plot Date: Time: Monday, March 18, 2013 2:42:54 PM Path and File Name: j:\24rx12.013_durham region orono & scugog depot\5.3_drawing\3\arch\layouts\02-a40-00-01.dwg

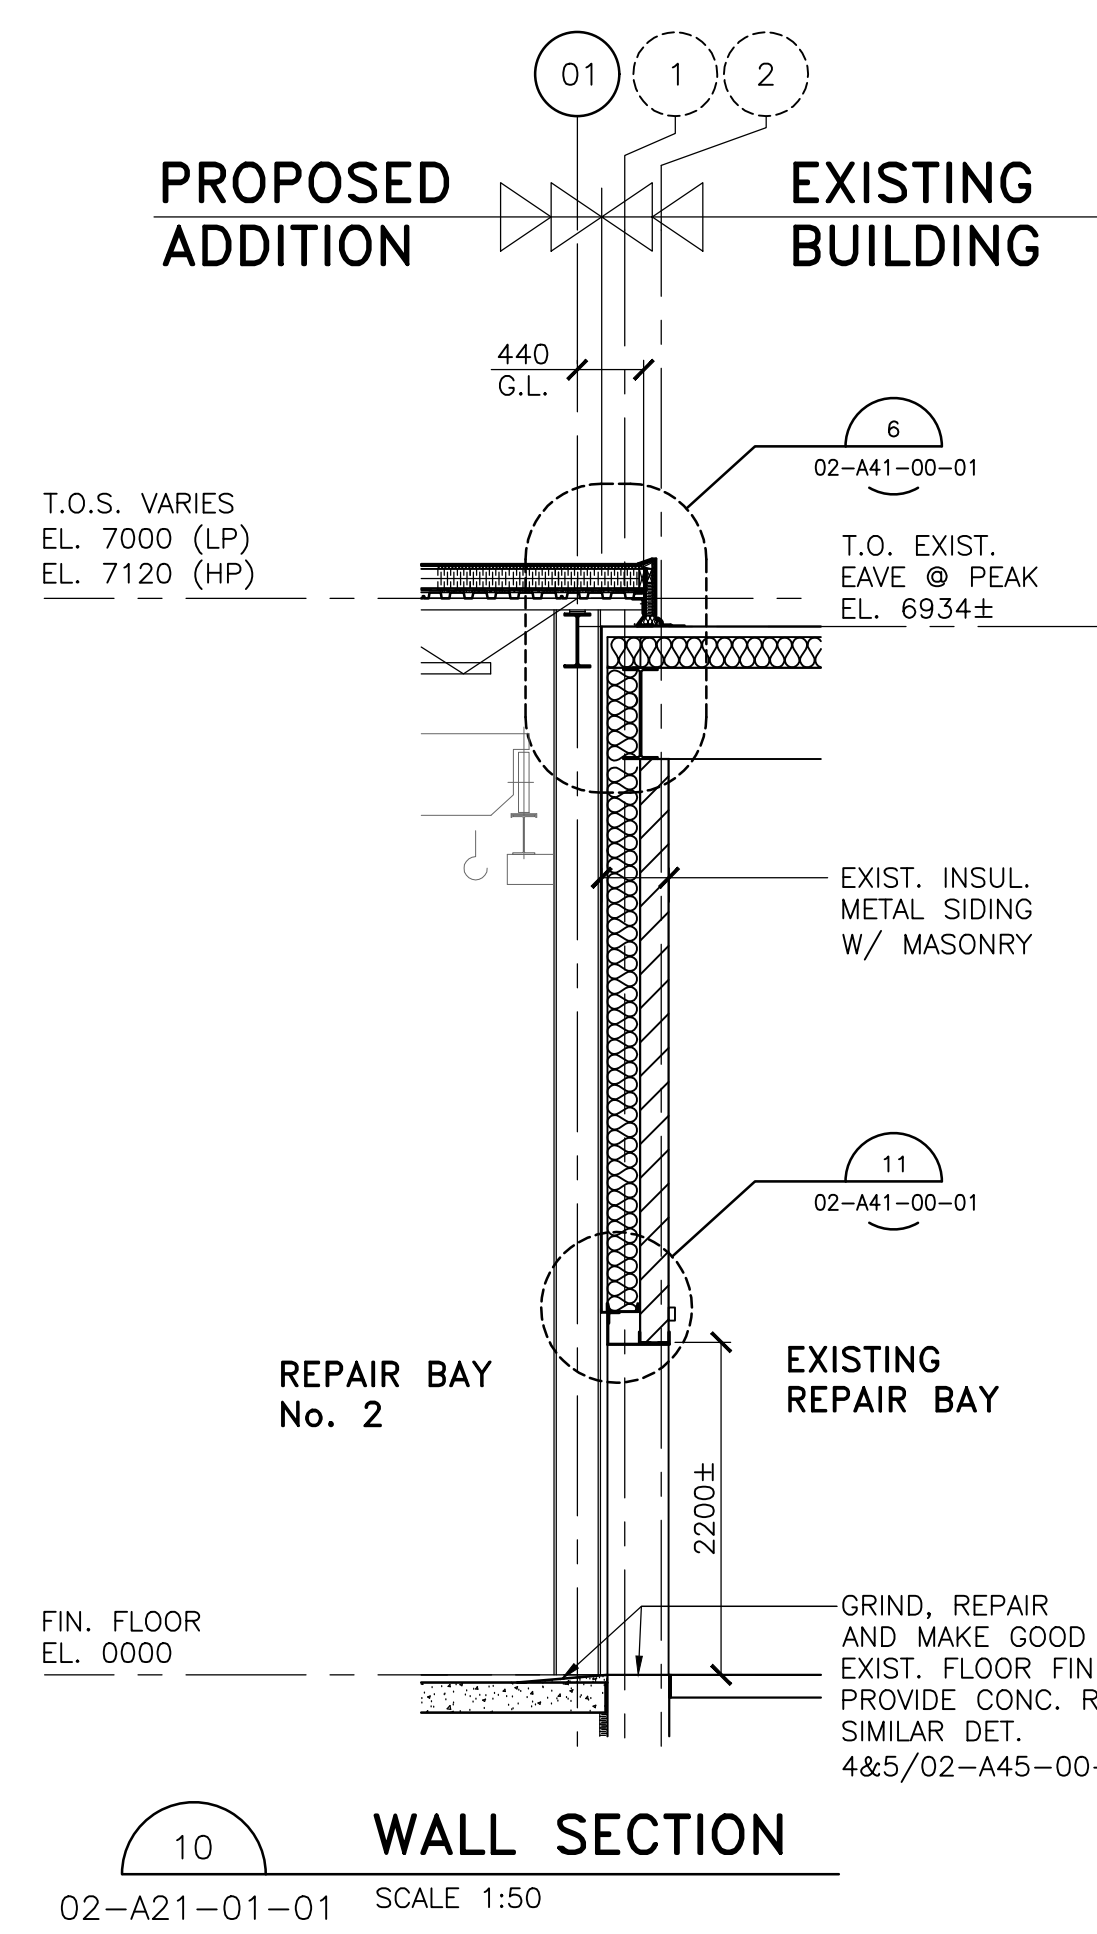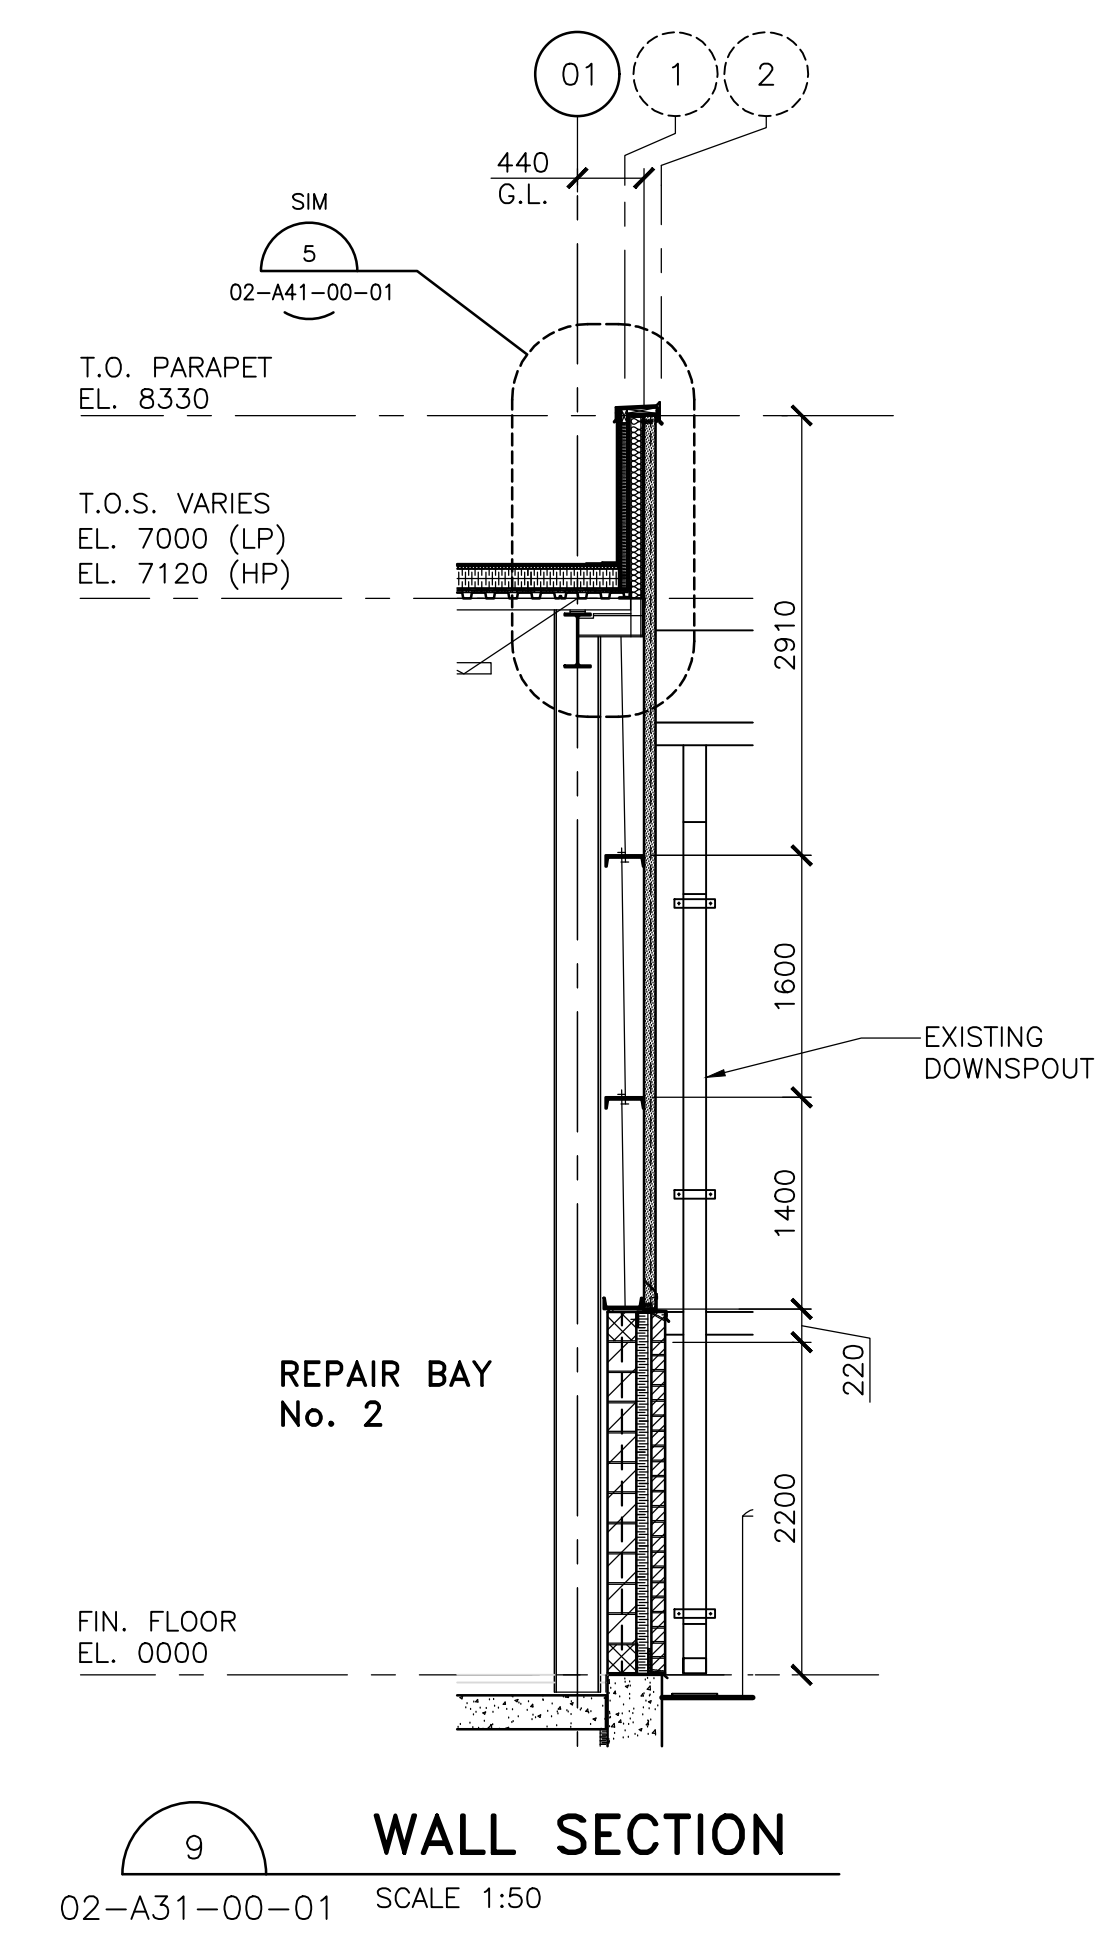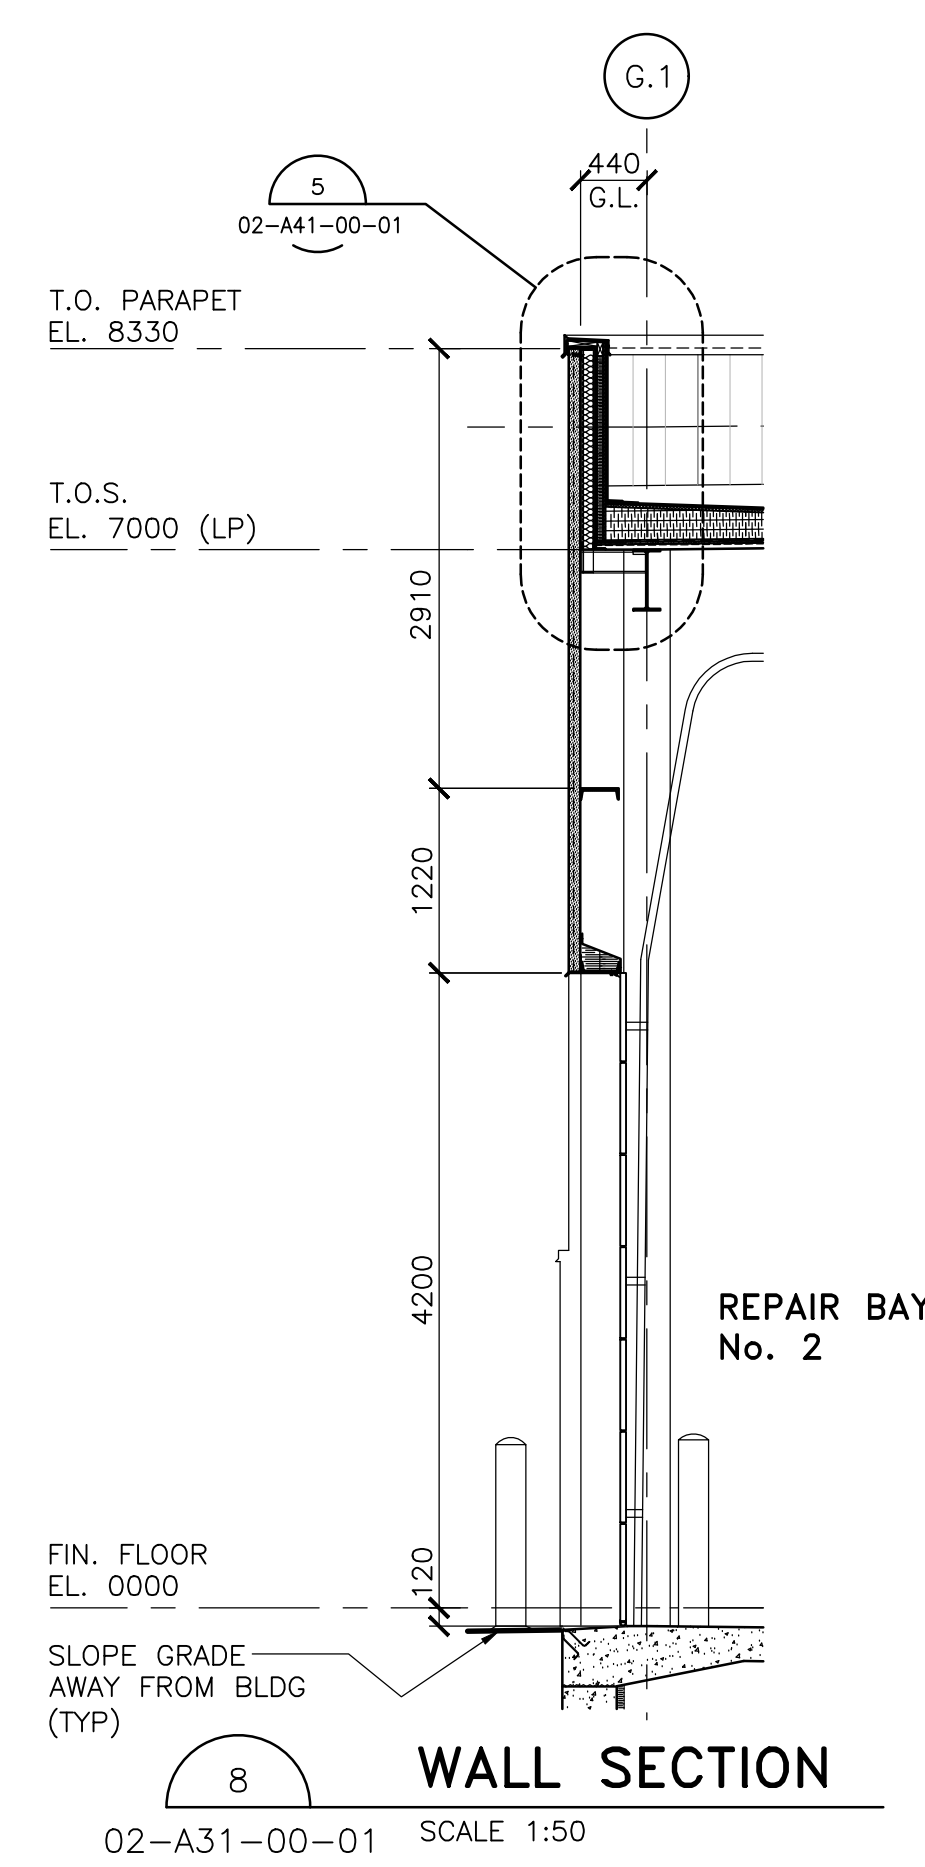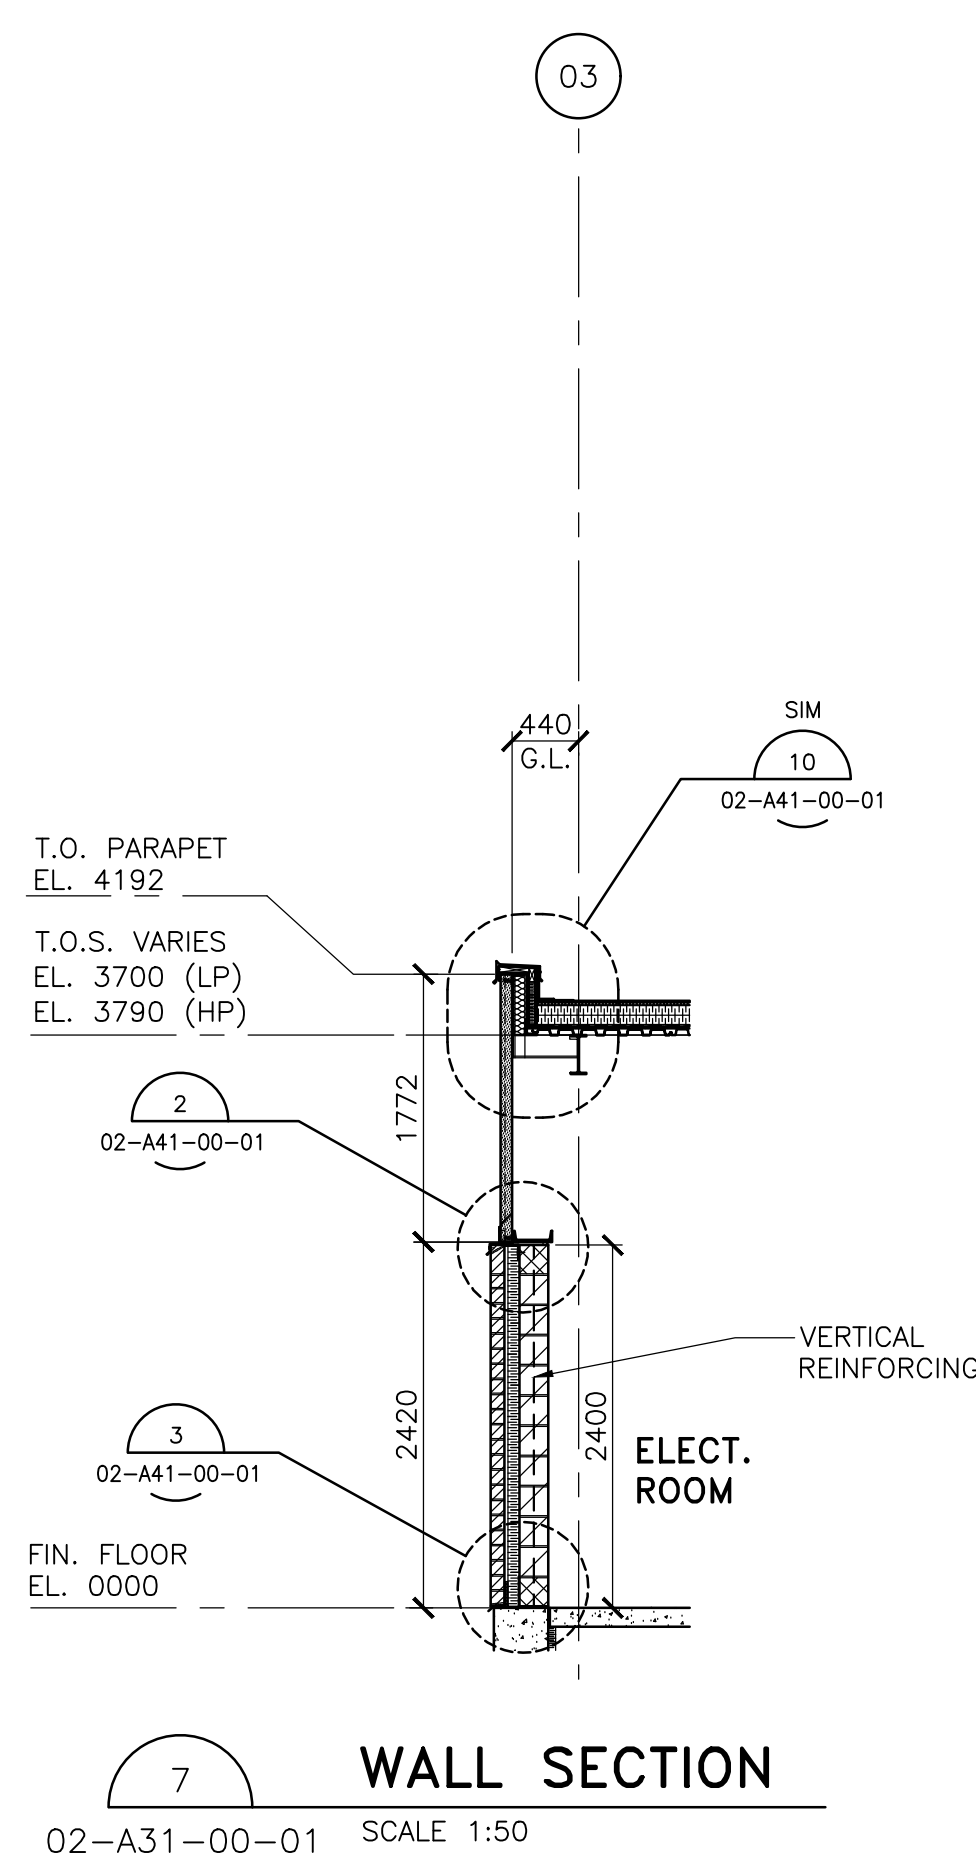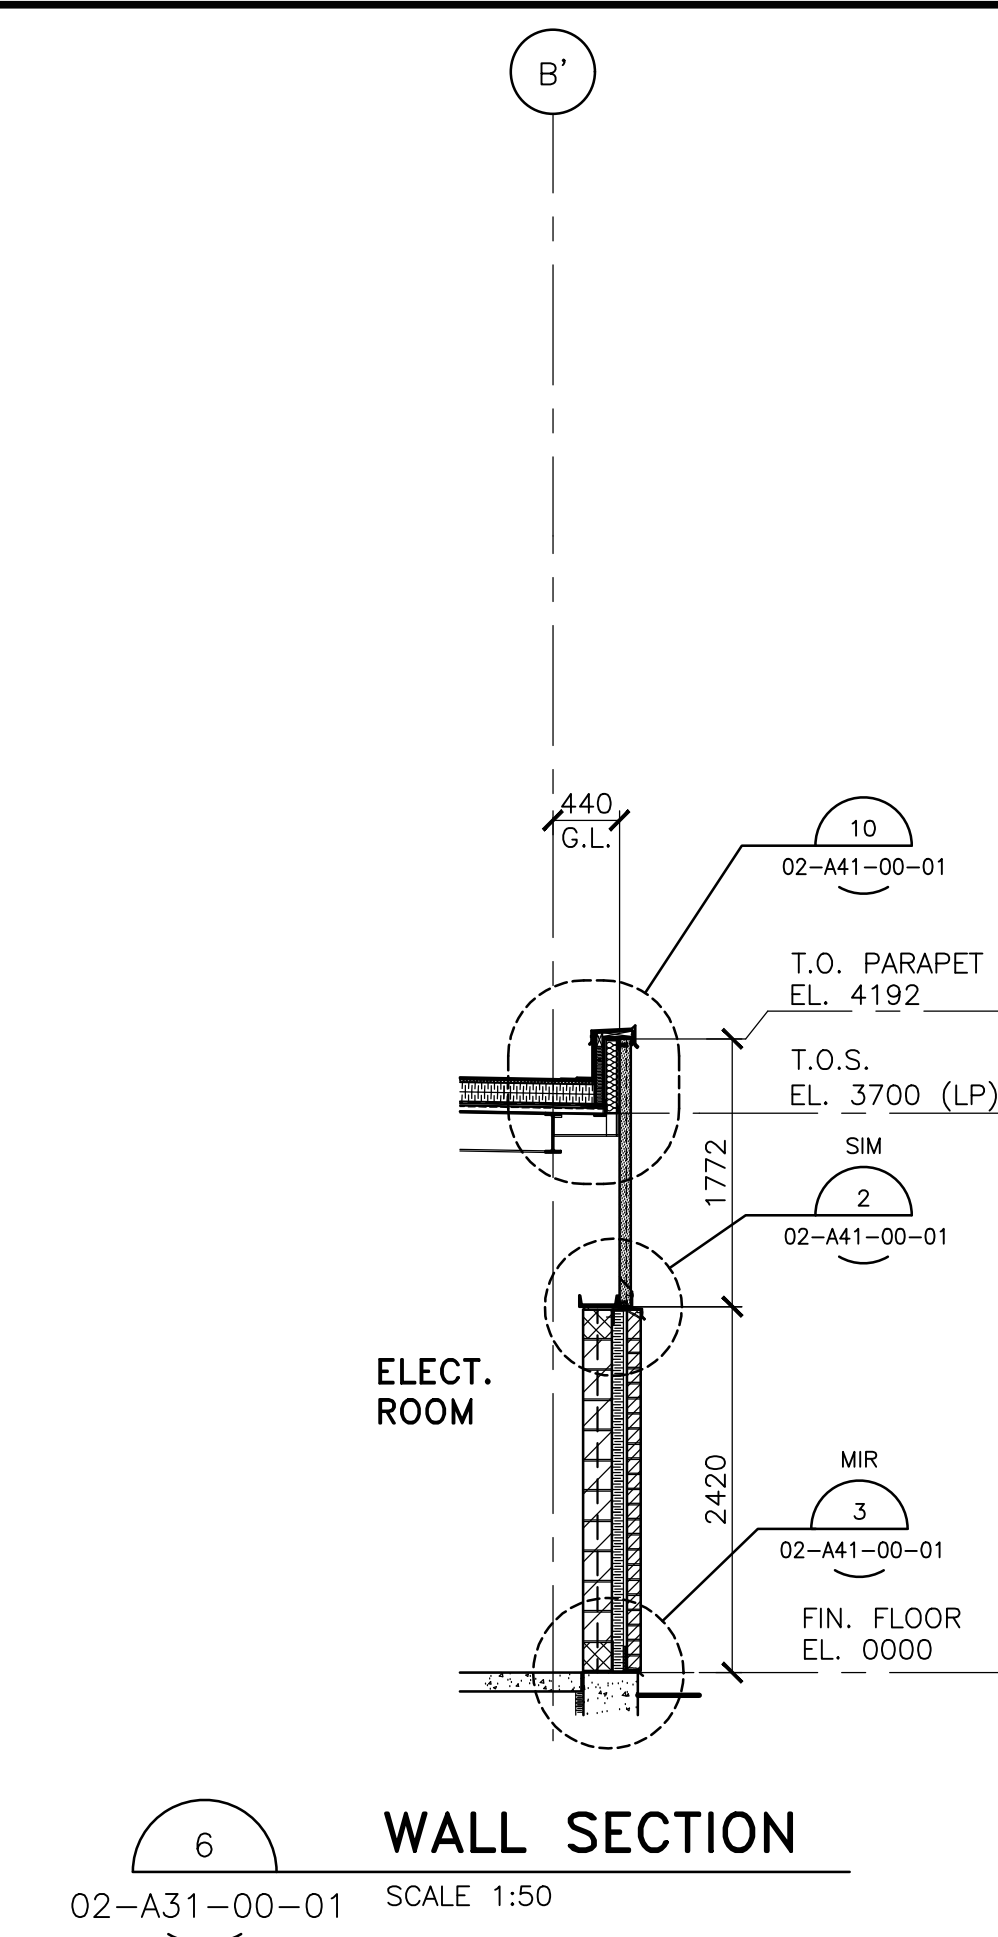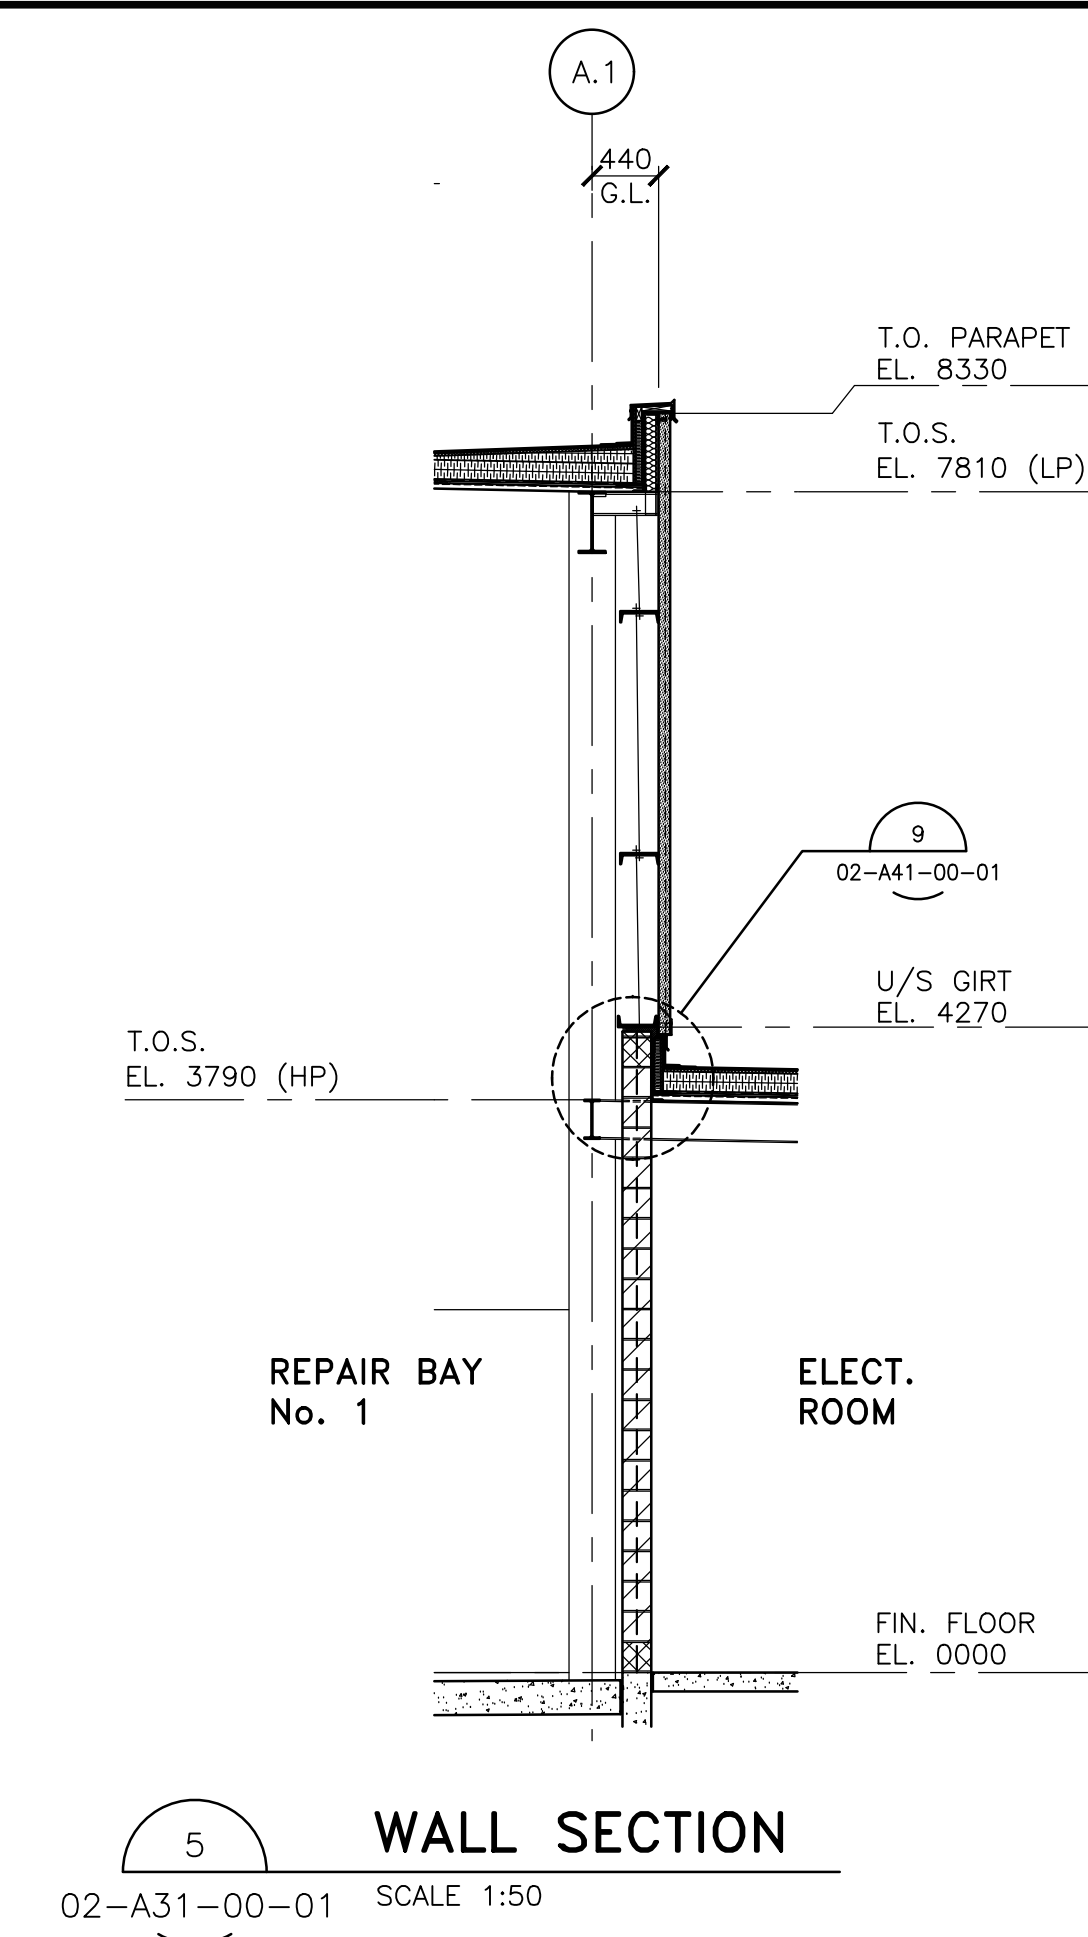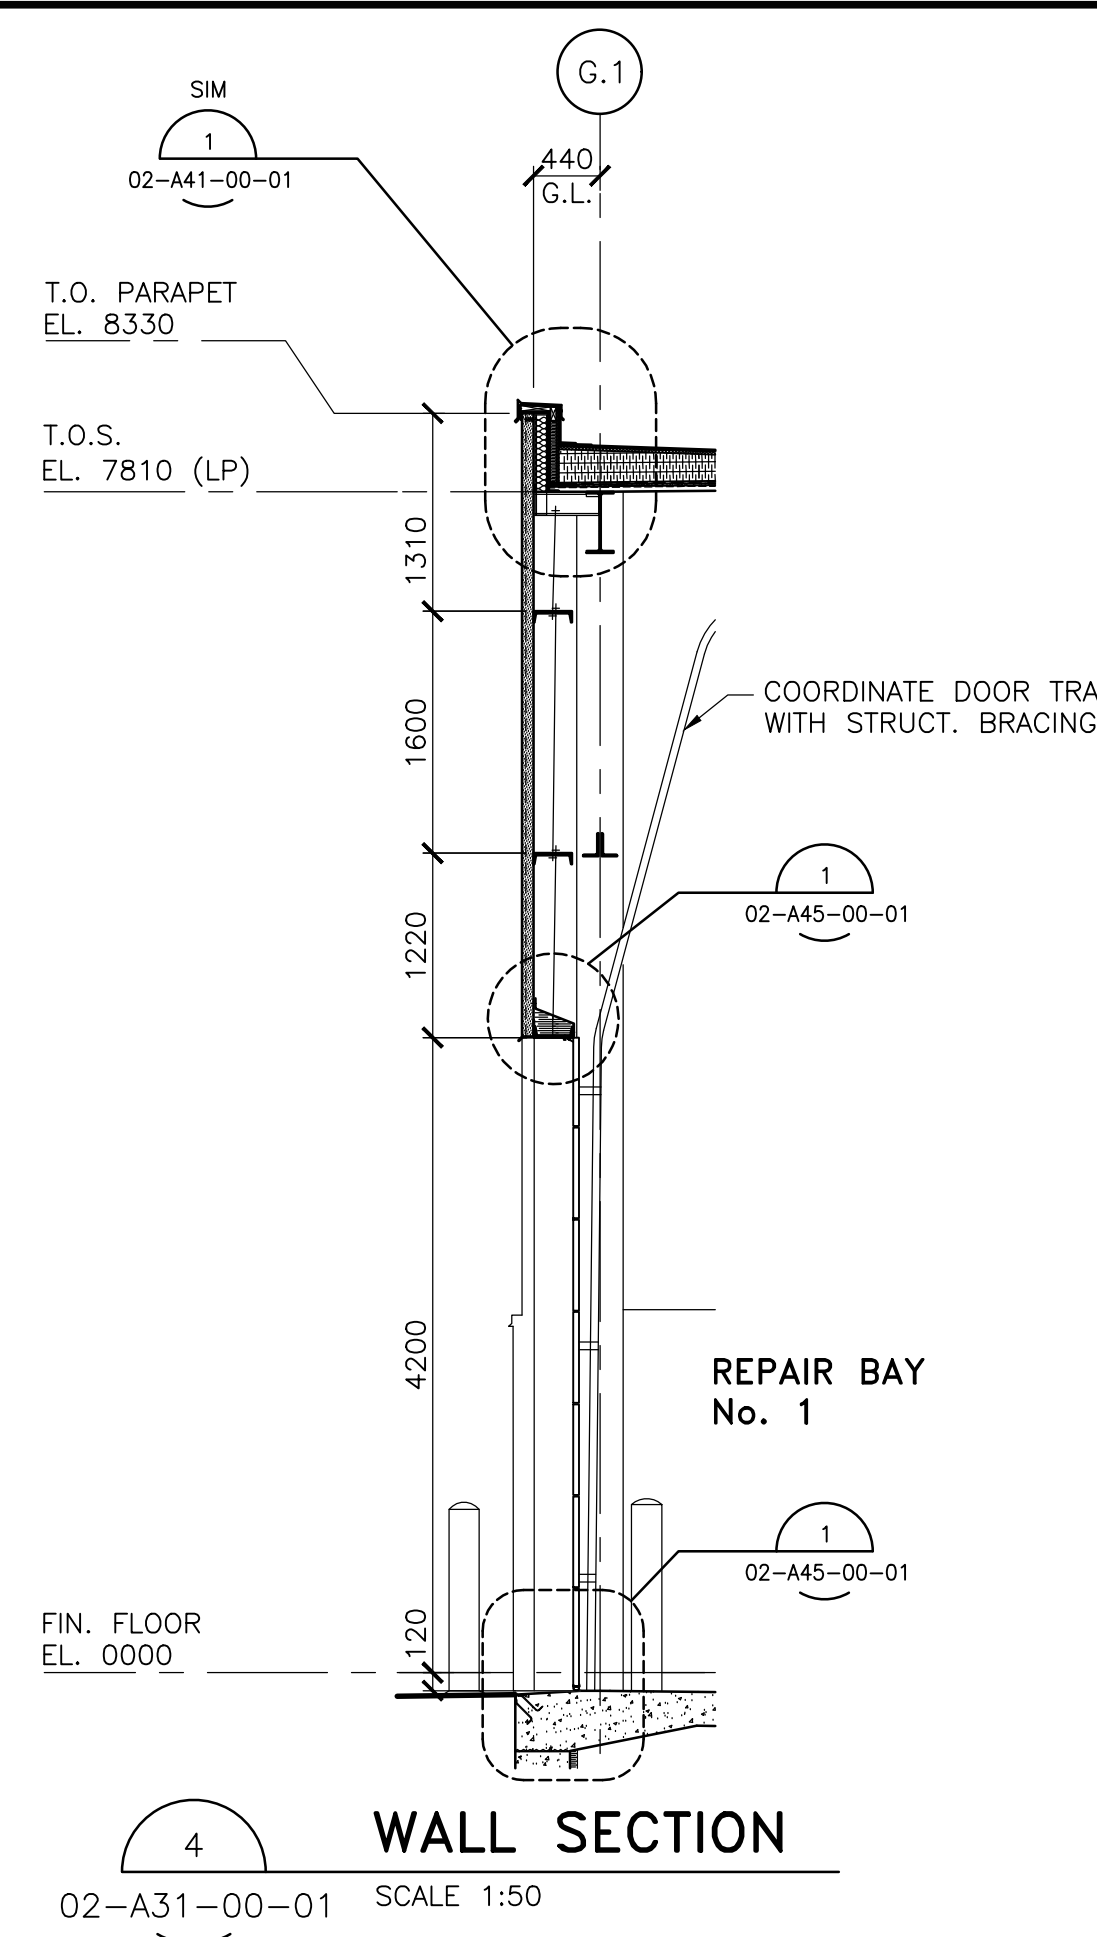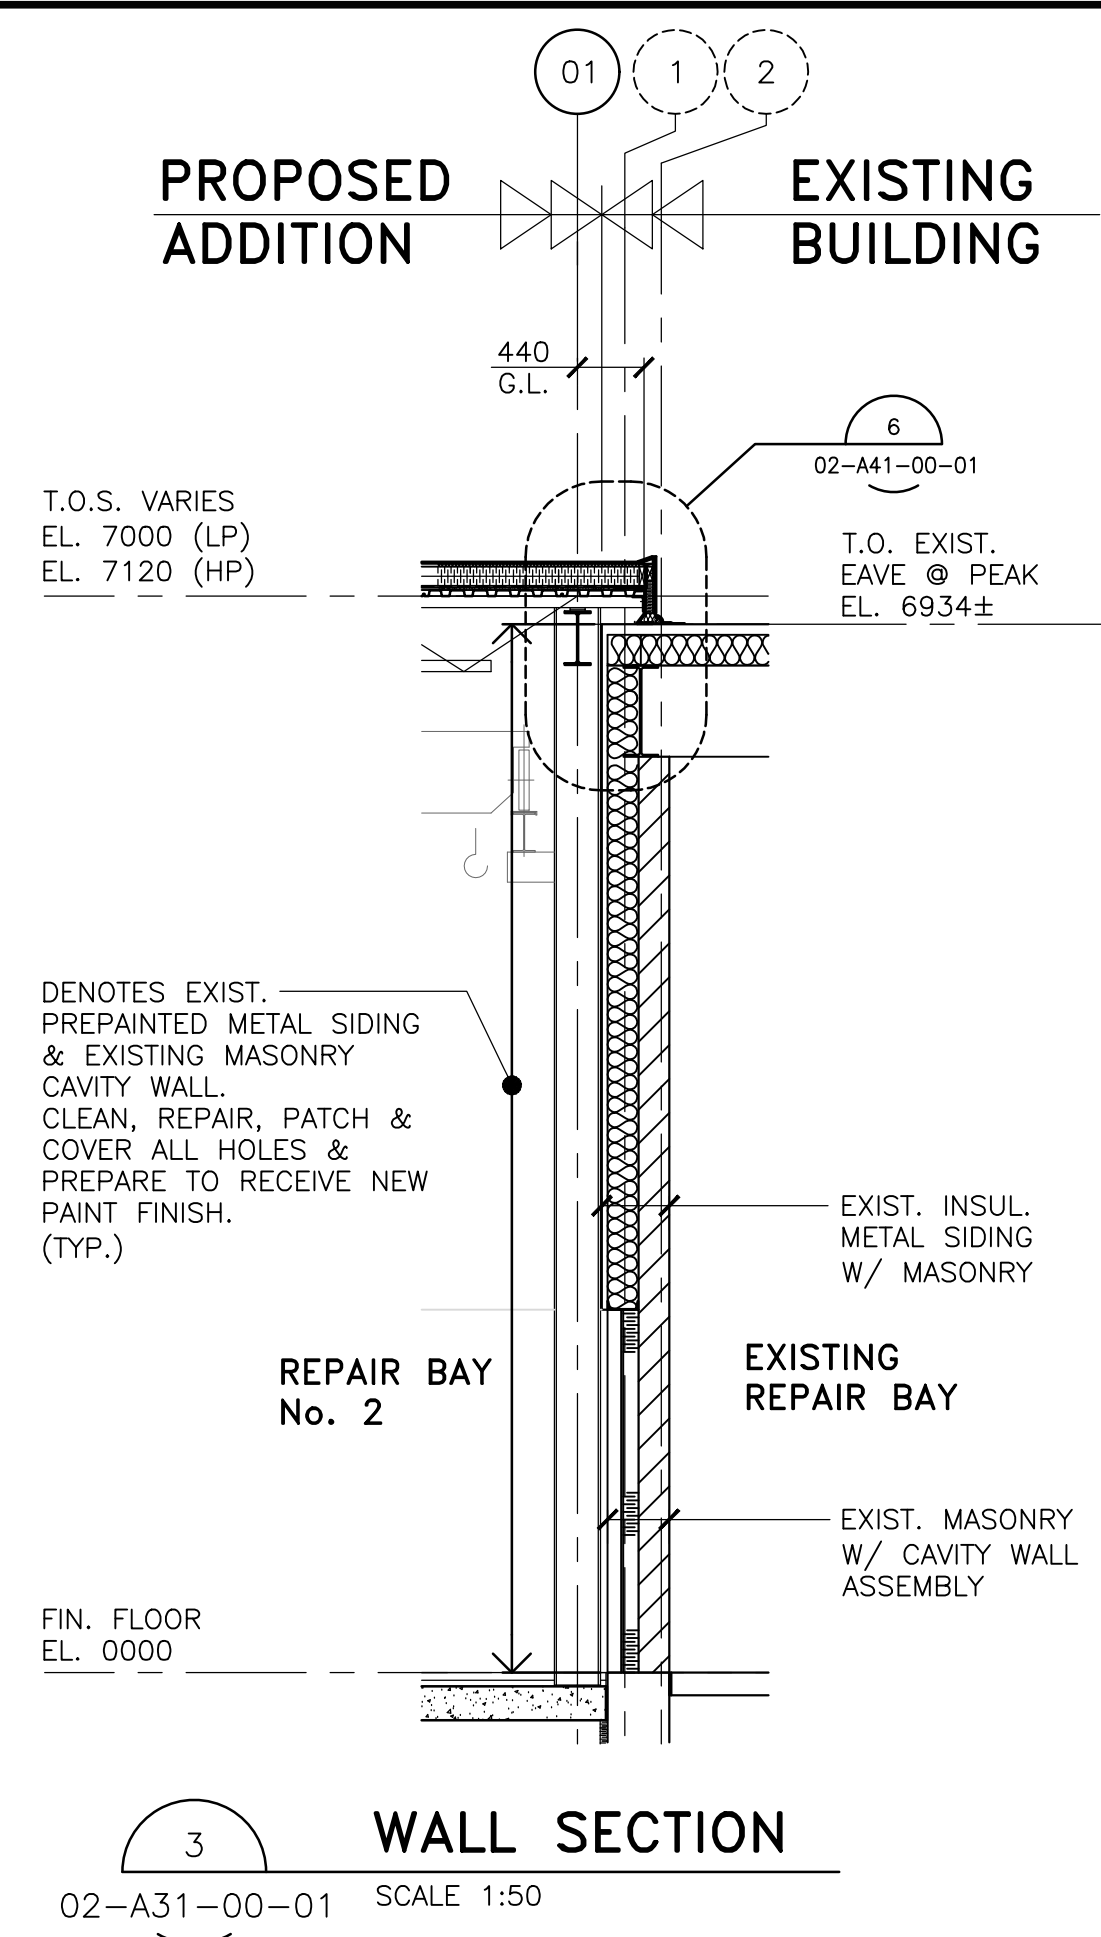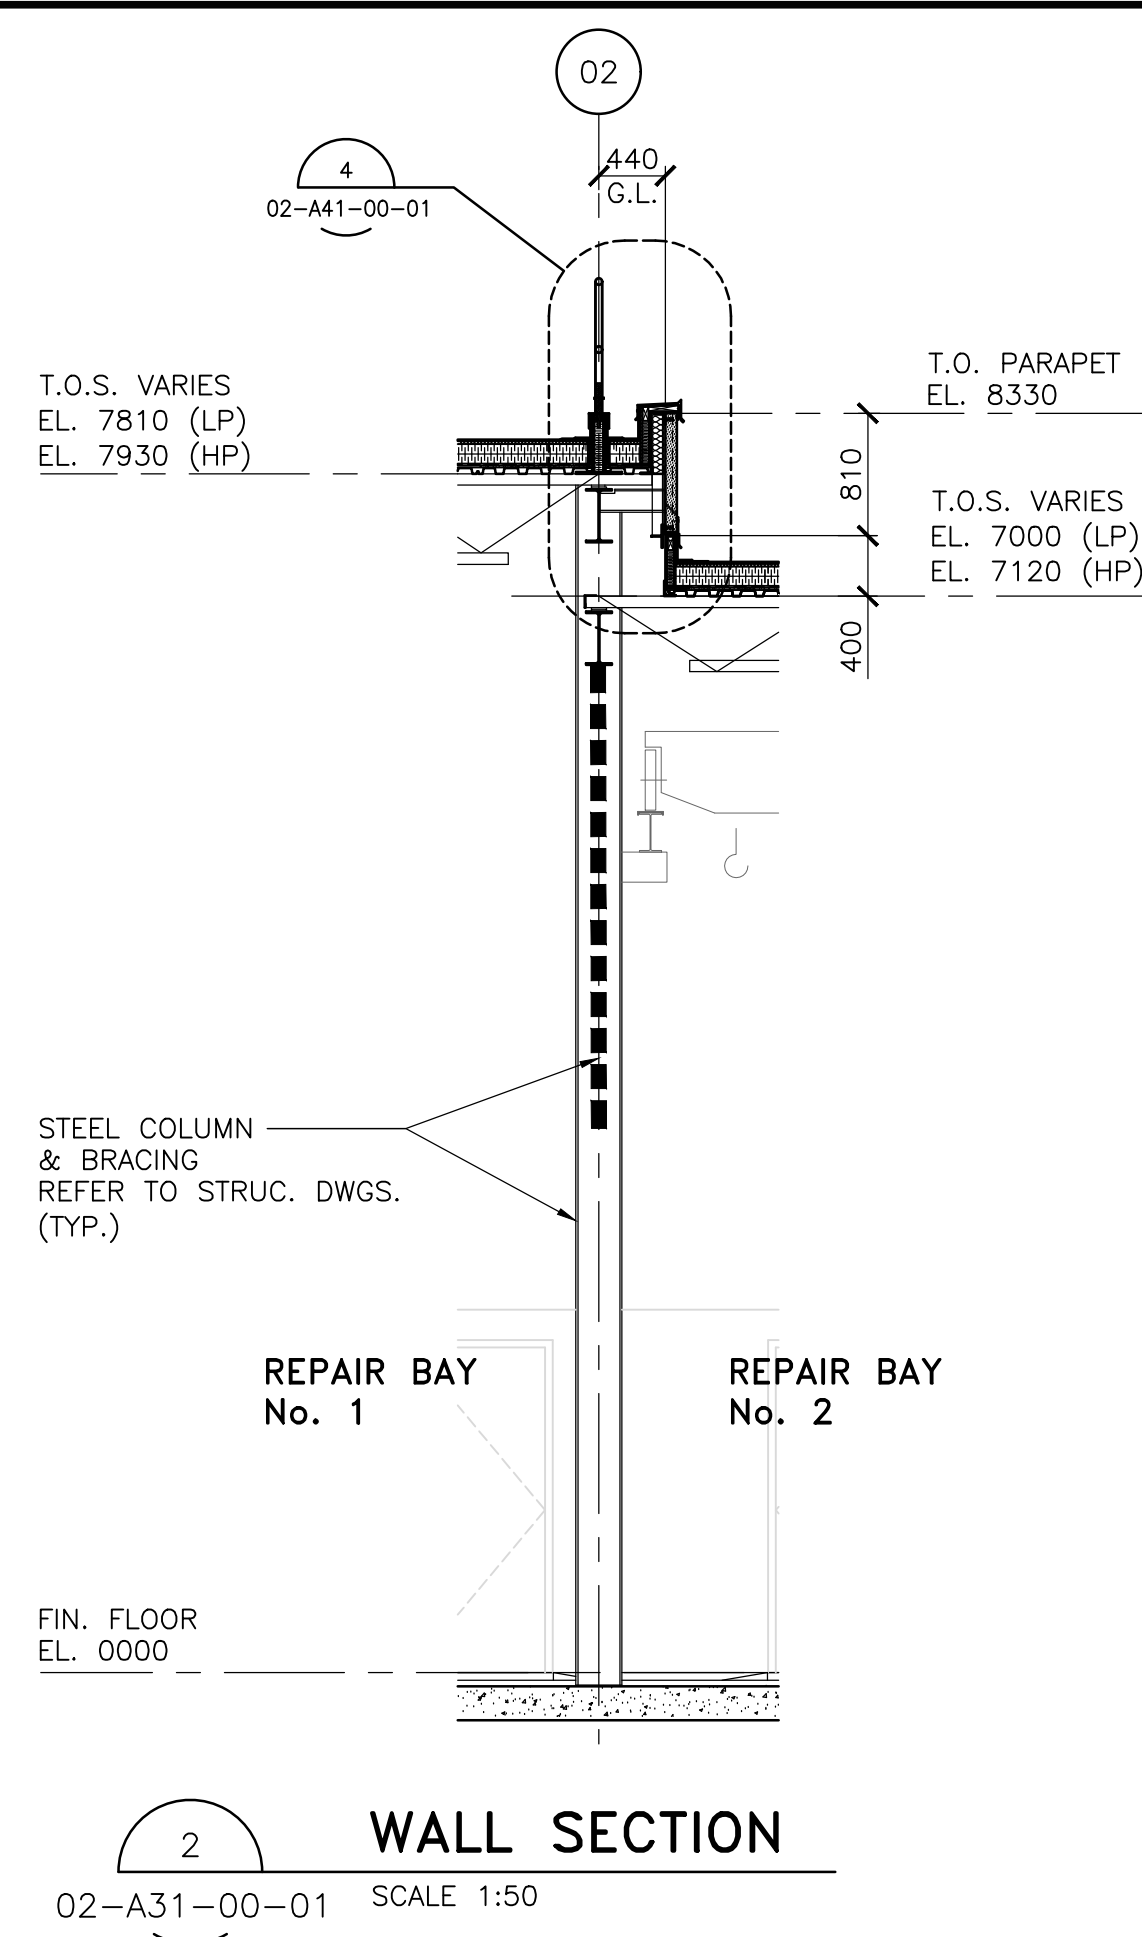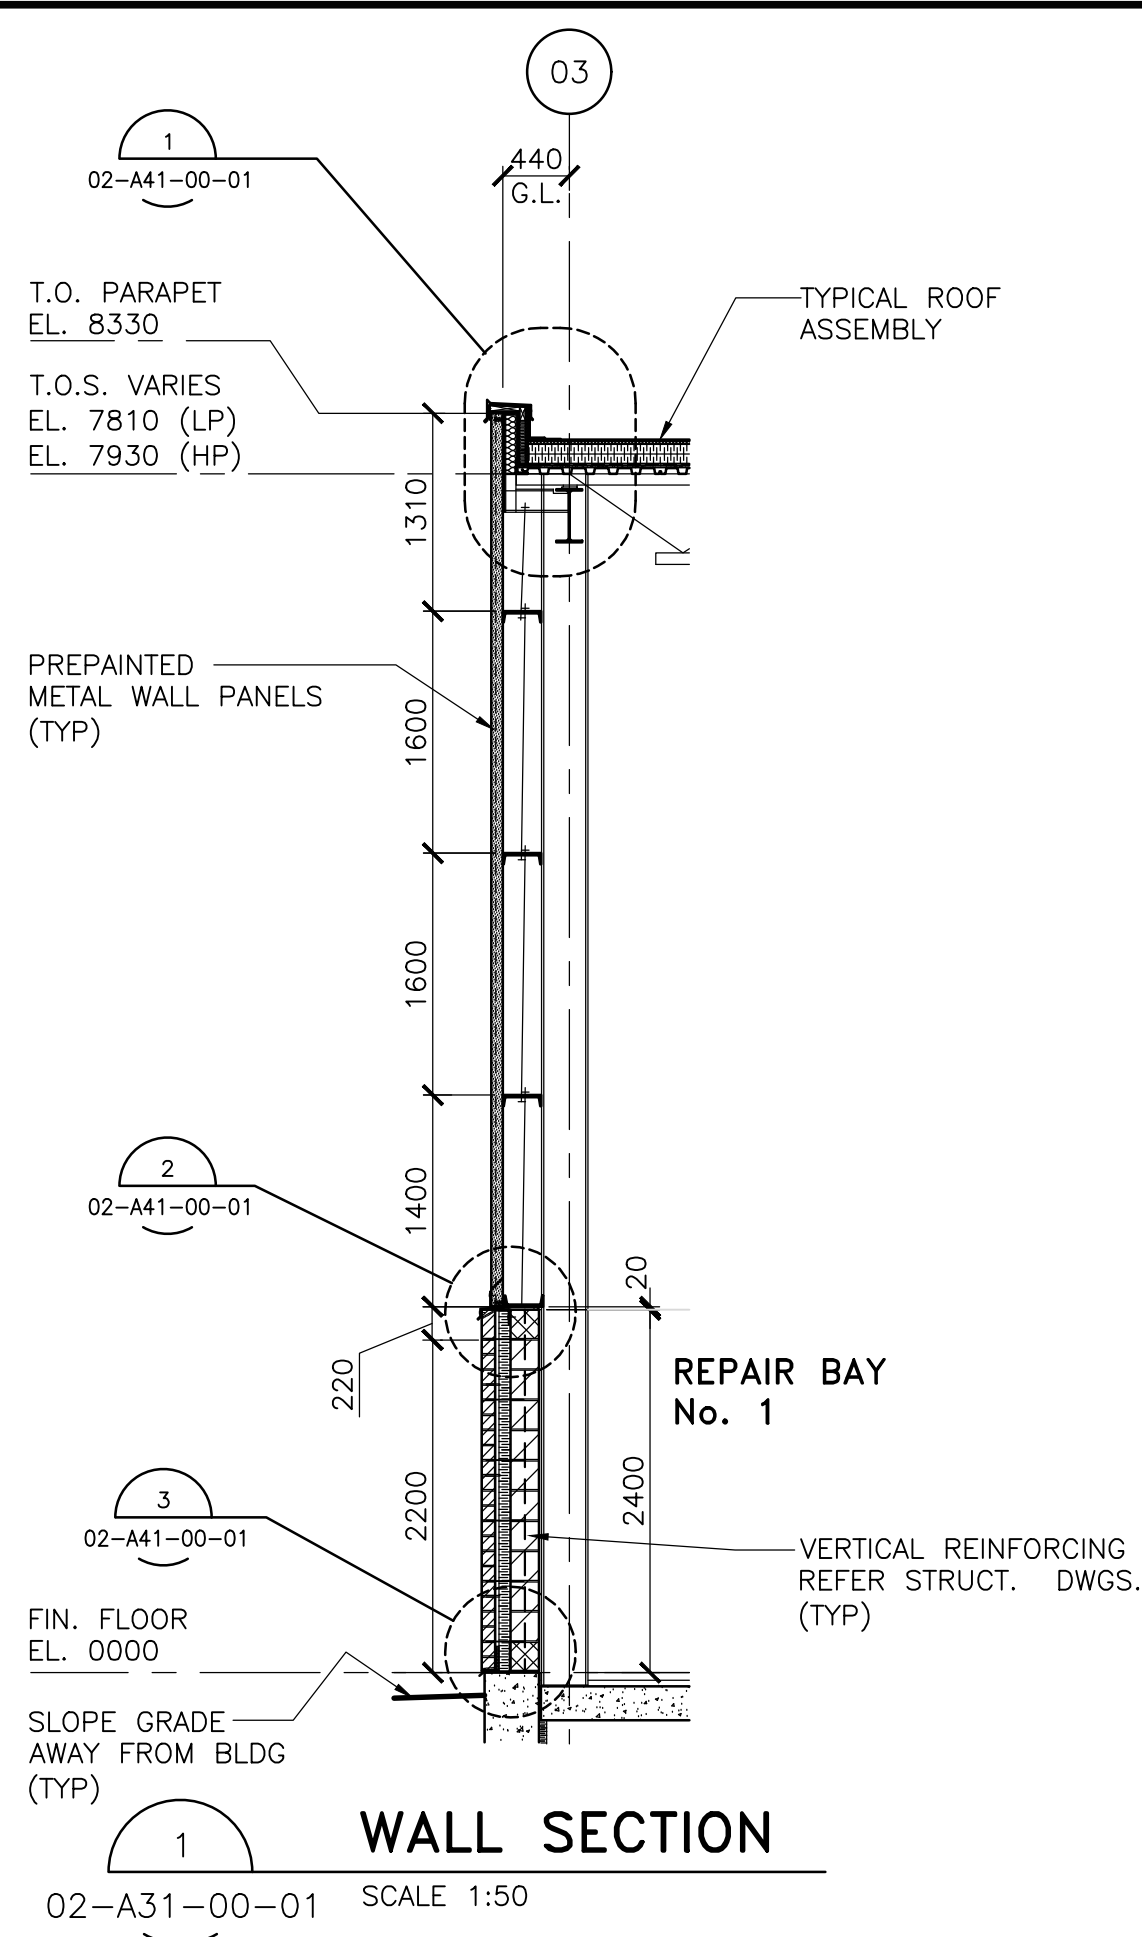

DATE (mm dd yyyy)	ISSUED FOR	REV
OCT 01 2018	TENDER	0

KEY PLAN


CONSULTANTS

IBI GROUP 100-175 Galaxy Boulevard Toronto ON M9W 0C9 Canada tel 416 679 1930 fax 416 675 4620 ibigroup.com	
This drawing has been prepared solely for the use of the Regional Municipality of Durham and there are no representations of any kind made by IBI Group to any party with whom IBI Group has not entered into a contract	
North Arrow	Detail Symbol
DETAIL NUMBER LOCATION OR DETAIL SHEET	


Project Manager A. VAN VEEN	Architect/Engineer A.V.V. / S.K.
Project Leader R.K. / R.F.	Drawn M.F. / D.V.
Date NOV 2012	Checked L. SANDIERA
Client	

THE REGIONAL MUNICIPALITY OF DURHAM WORKS DEPARTMENT ONTARIO	
Project EXPAND GARAGE SCUGOG DEPOT 10 REGIONAL RD. 21, R.R.#14, PORT PERRY	
Drawing Title WALL SECTIONS	
Check Scale (may be photo-reduced) 0 1 inch 0 10mm	
Project No. 24RX12.0113	Drawing No. 02-A40-00-01


ROD Contract No.
T-1038-2019

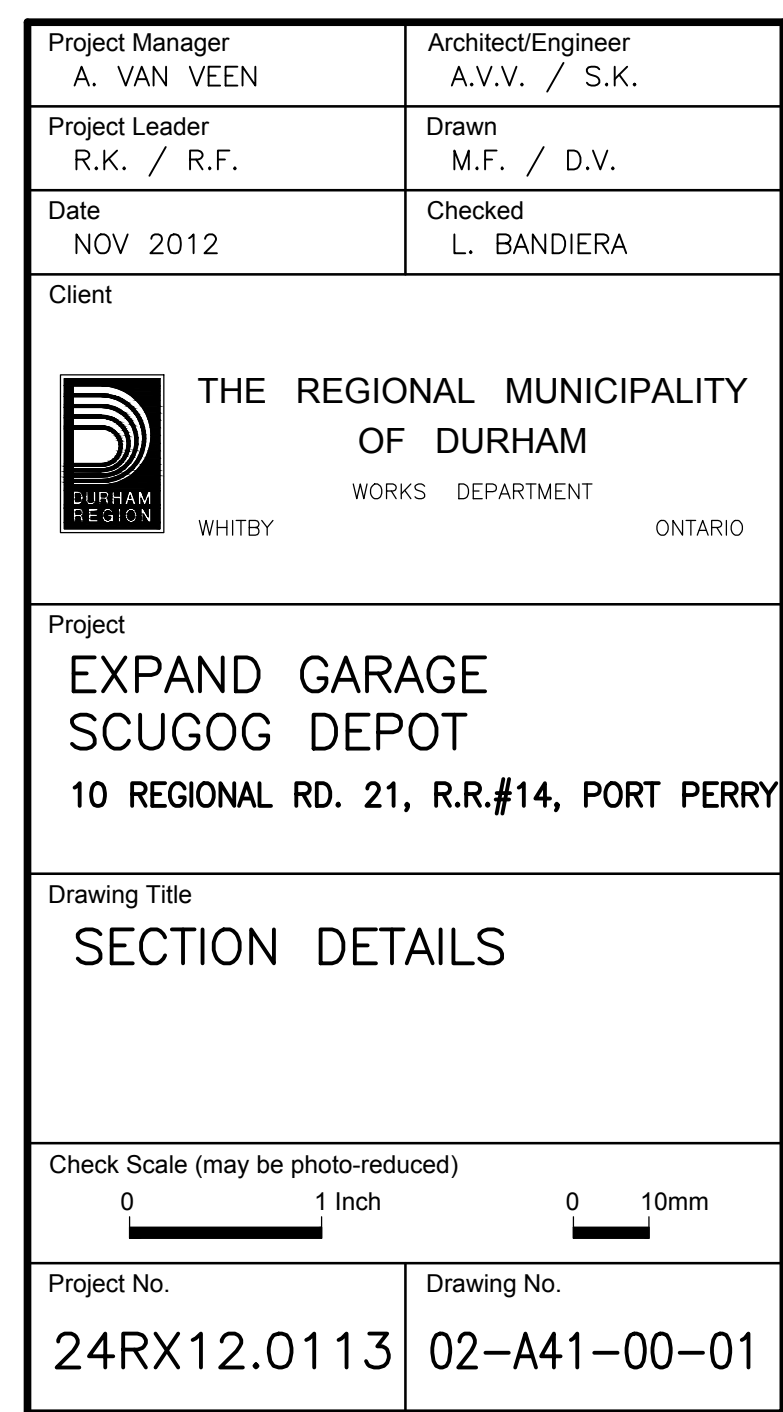


User Name: Joseph Patel Plot Date: Time: Monday, March 18, 2019 2:45:30 PM Path and File Name: J:\24rx12.0113.durham region orono & scugog depot\02-a42-00-01.dwg

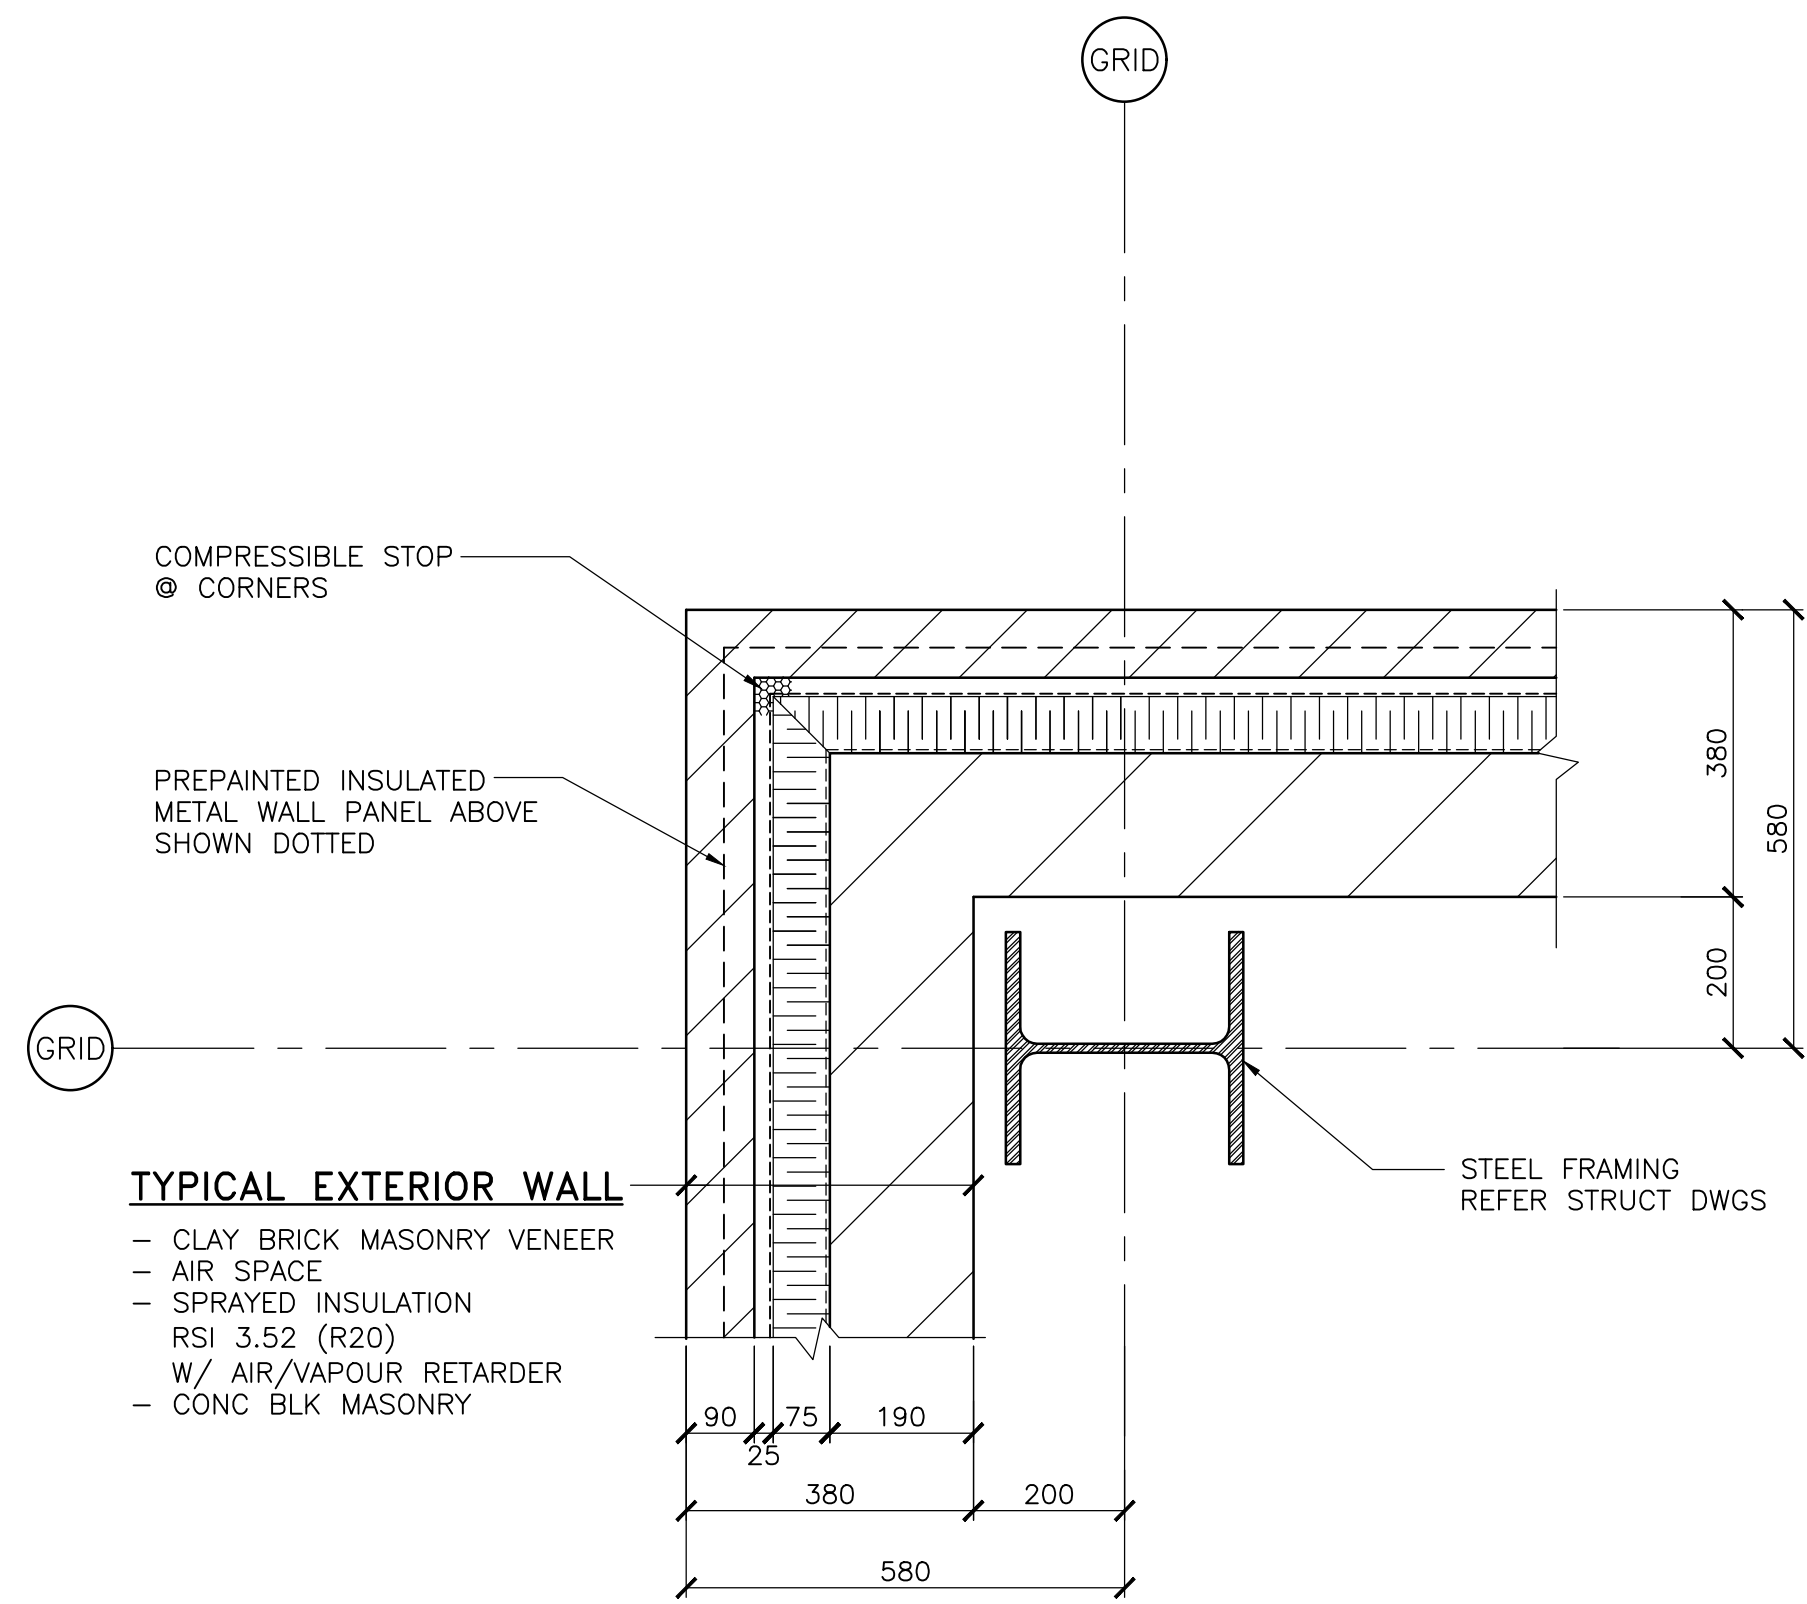

1 PLAN DETAIL
TYPICAL SCALE 1:10

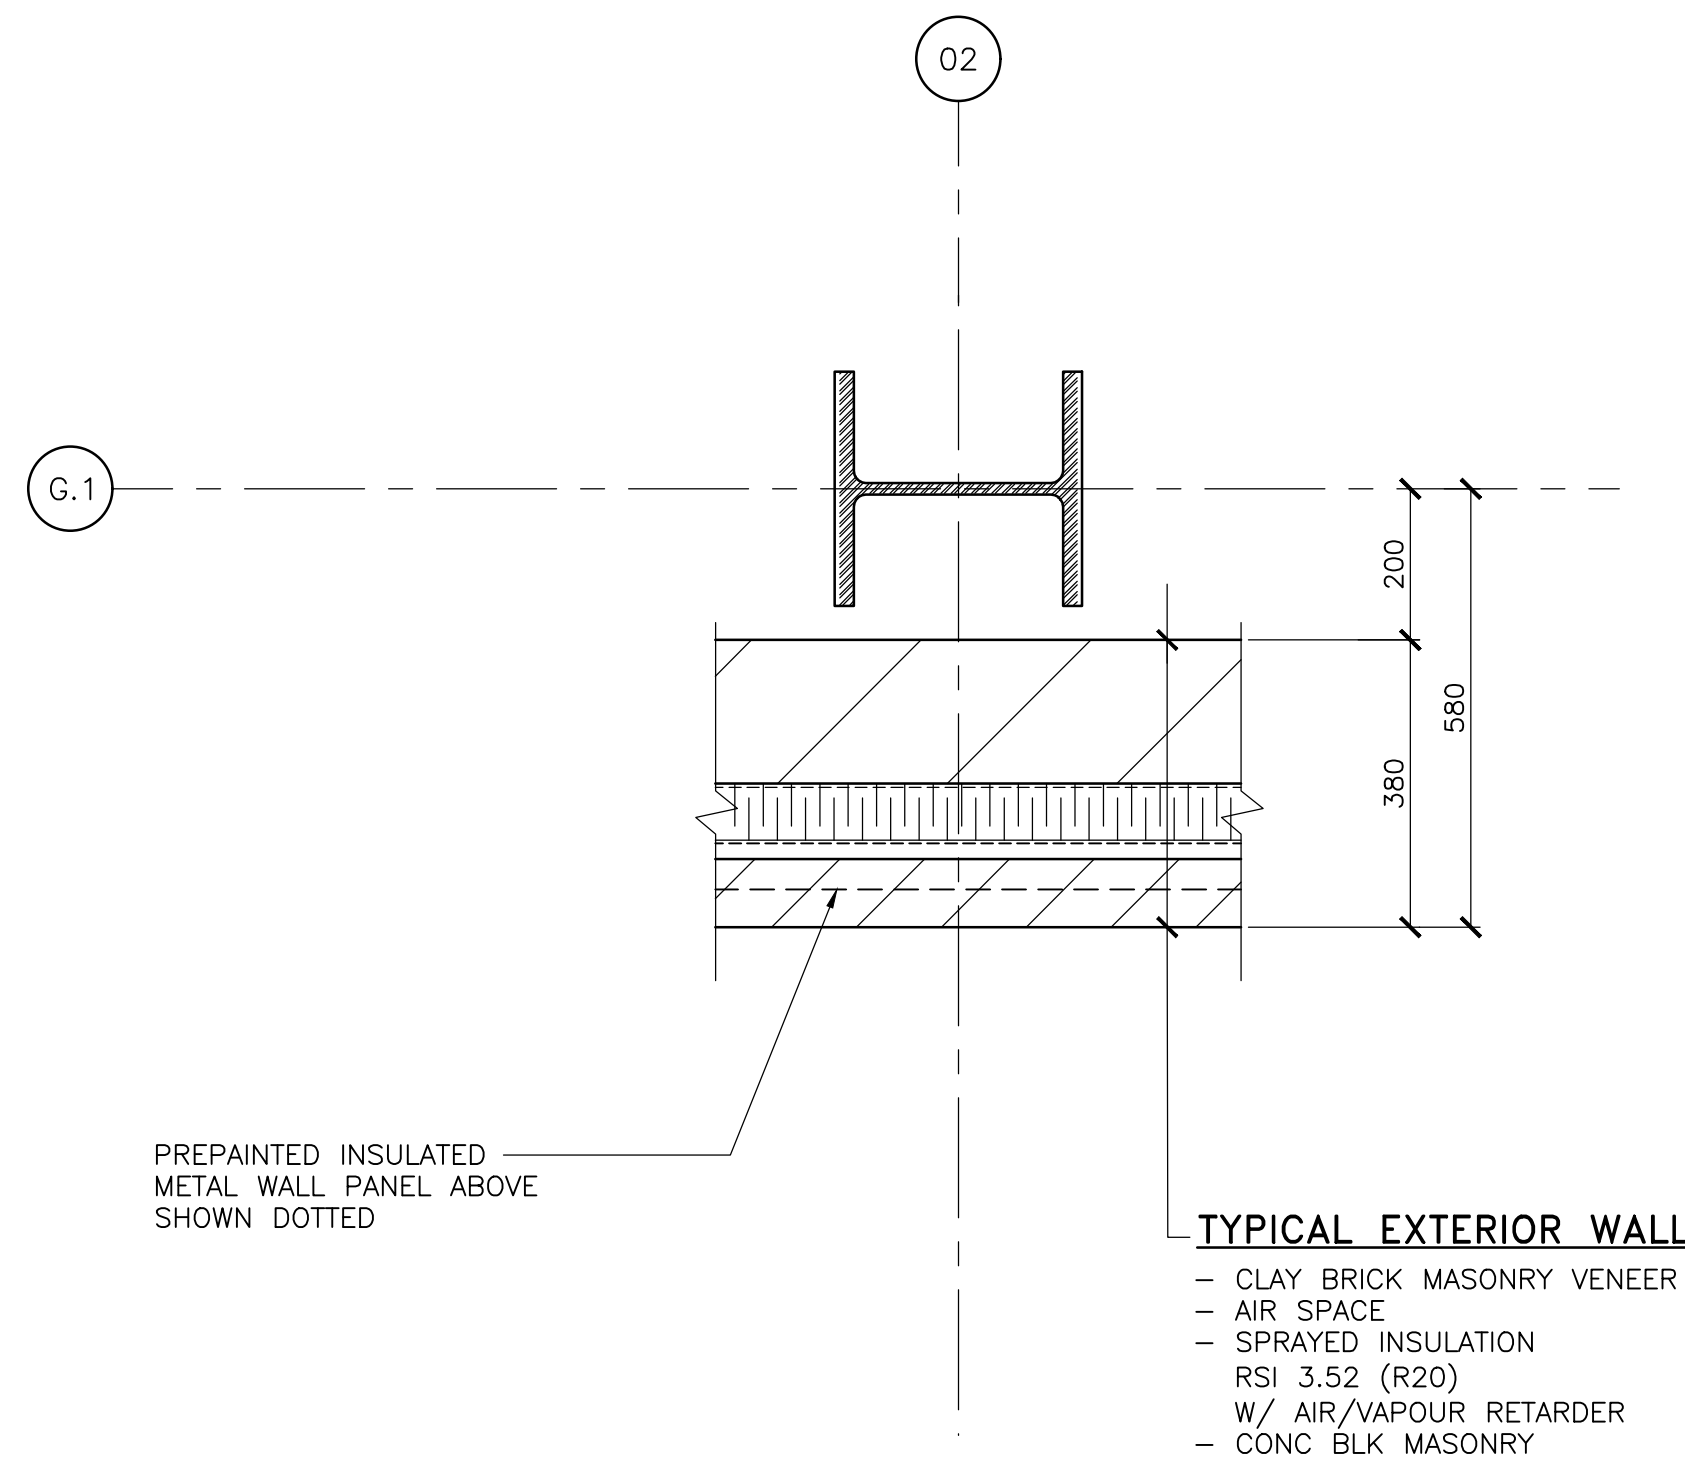


3 PLAN DETAIL
02-A21-01-01 SCALE 1:10

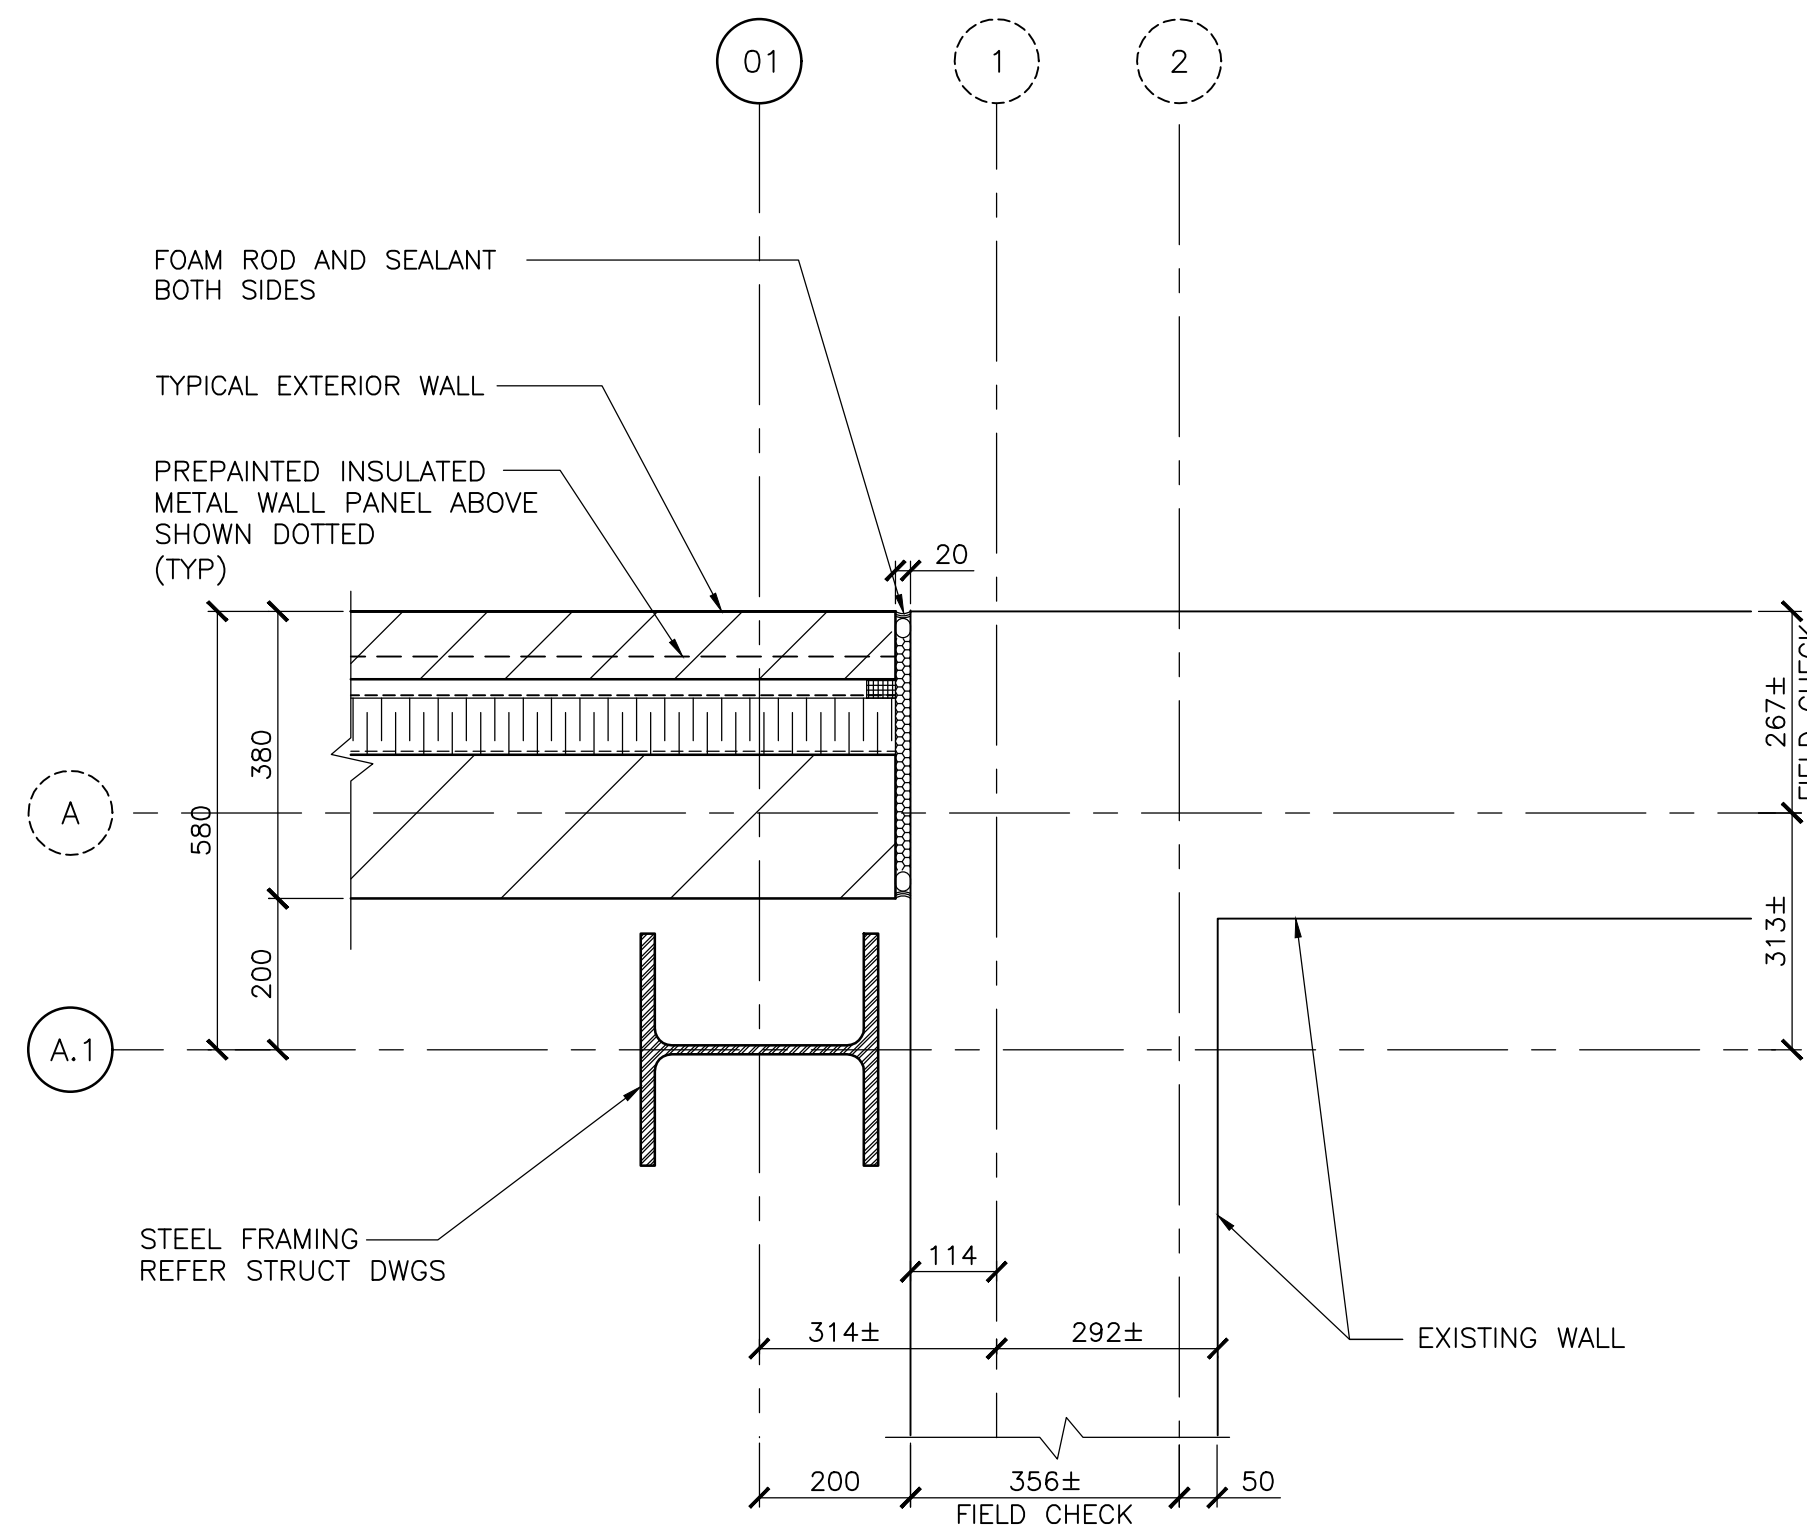


5 PLAN DETAIL
02-A21-01-01 SCALE 1:10


FOR ADDITIONAL NOTES
REFER DET. 7/02-A42-00-01

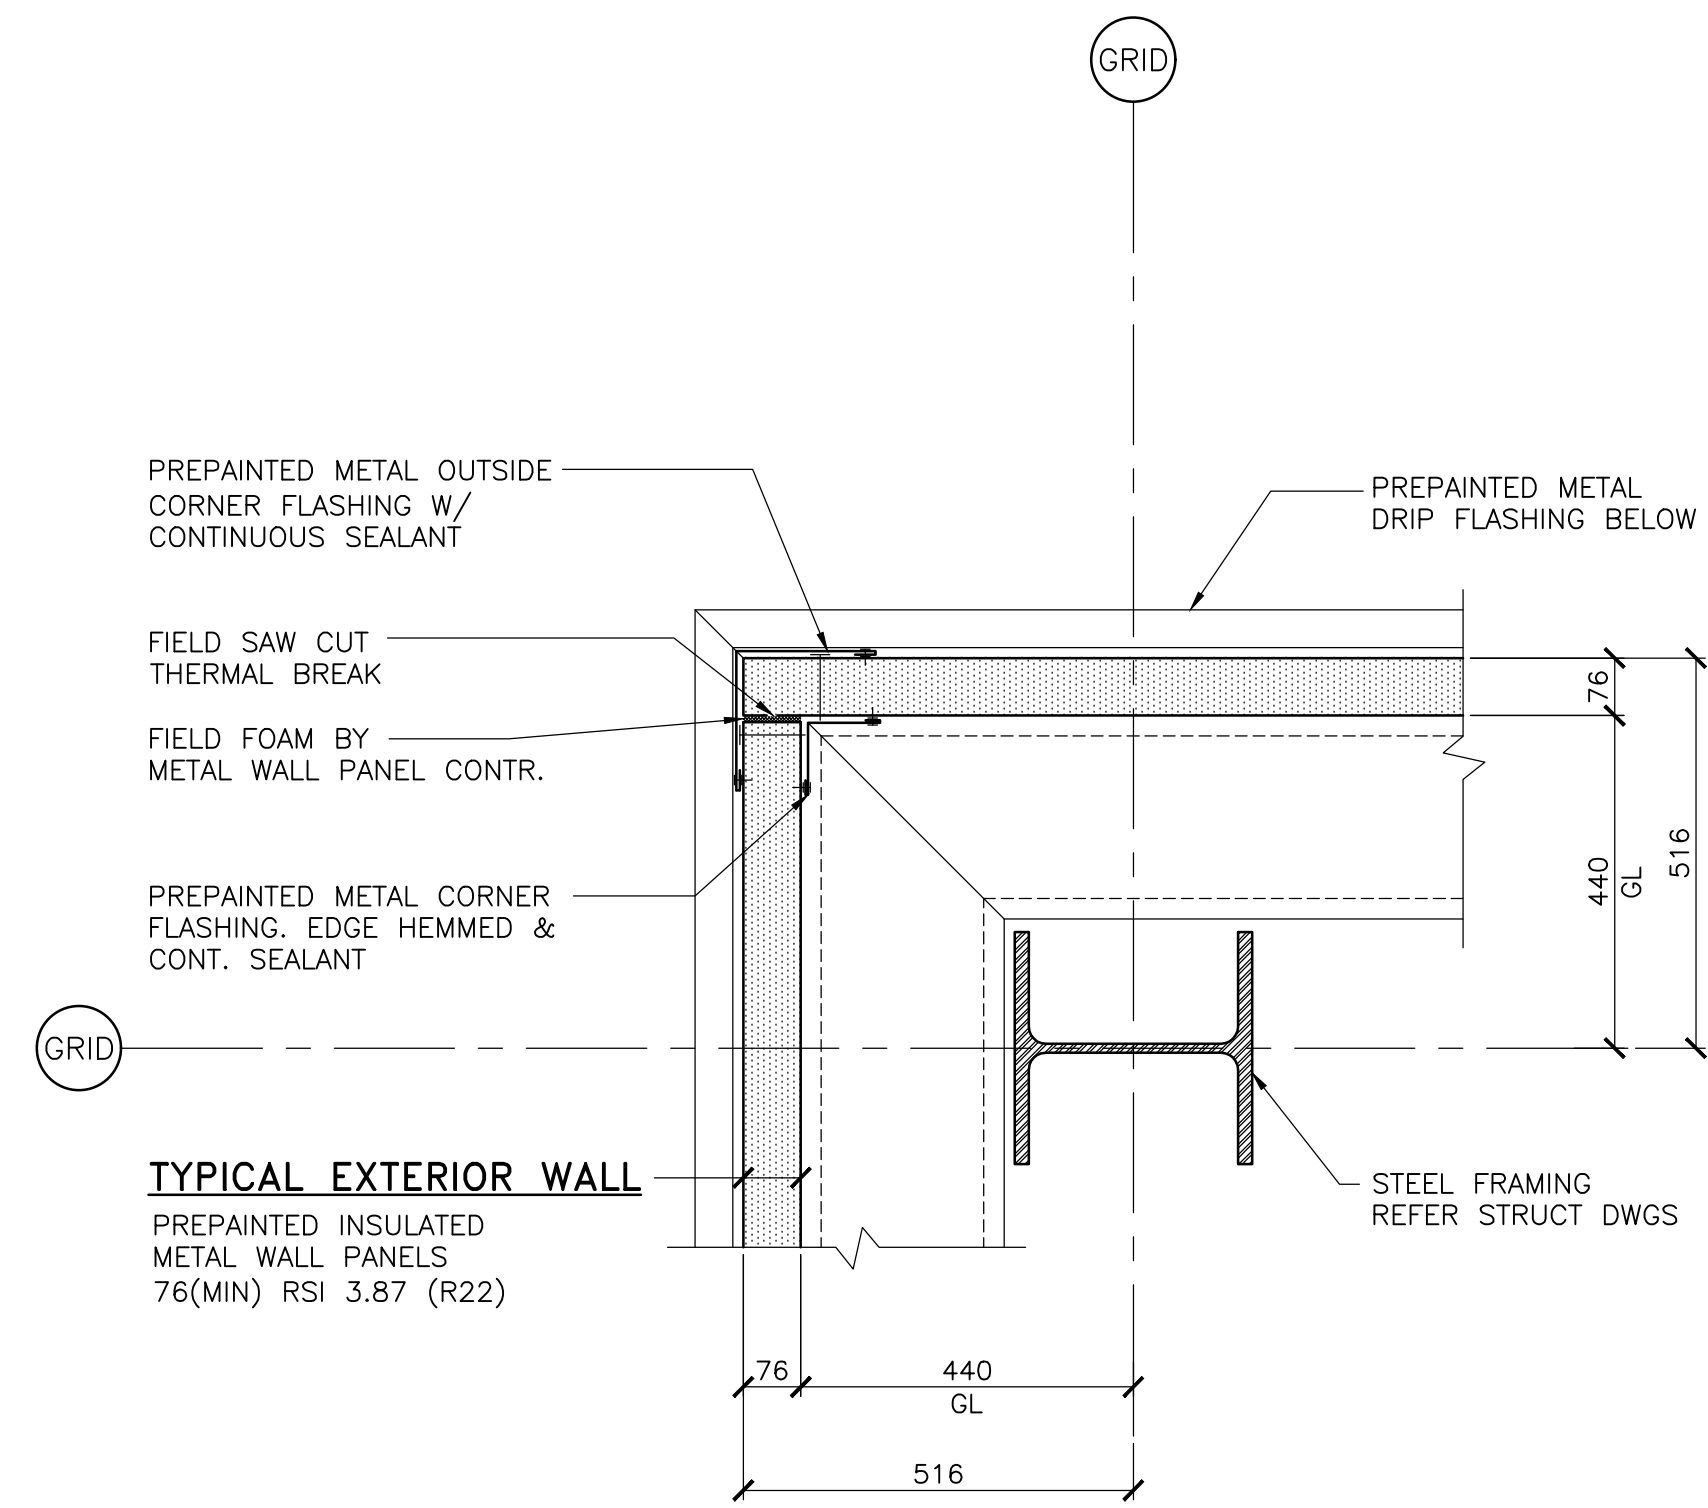

2 PLAN DETAIL
TYPICAL SCALE 1:10

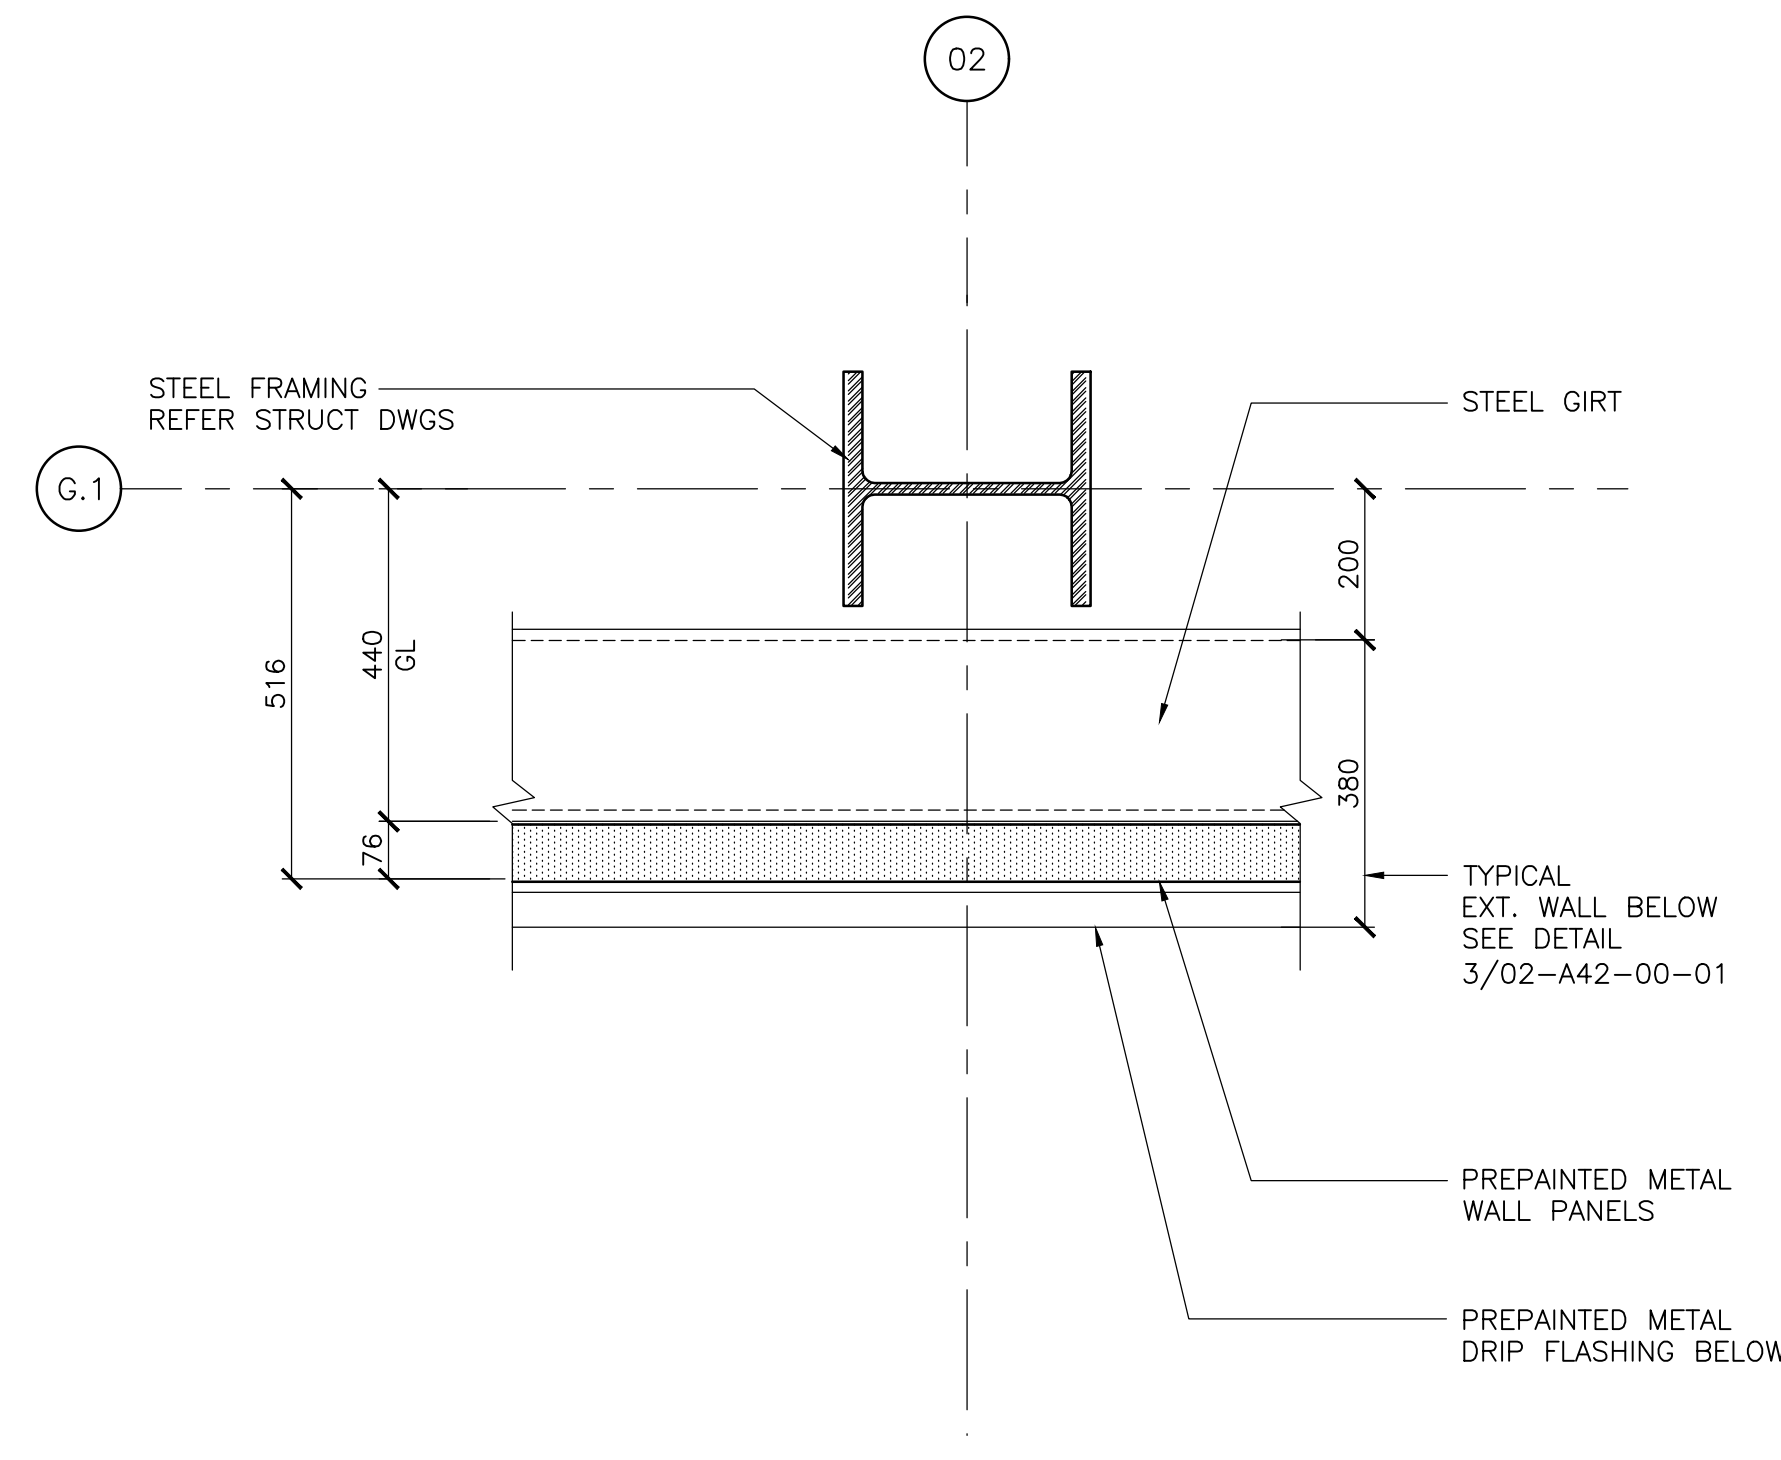


4 PLAN DETAIL
02-A21-01-01 SCALE 1:10

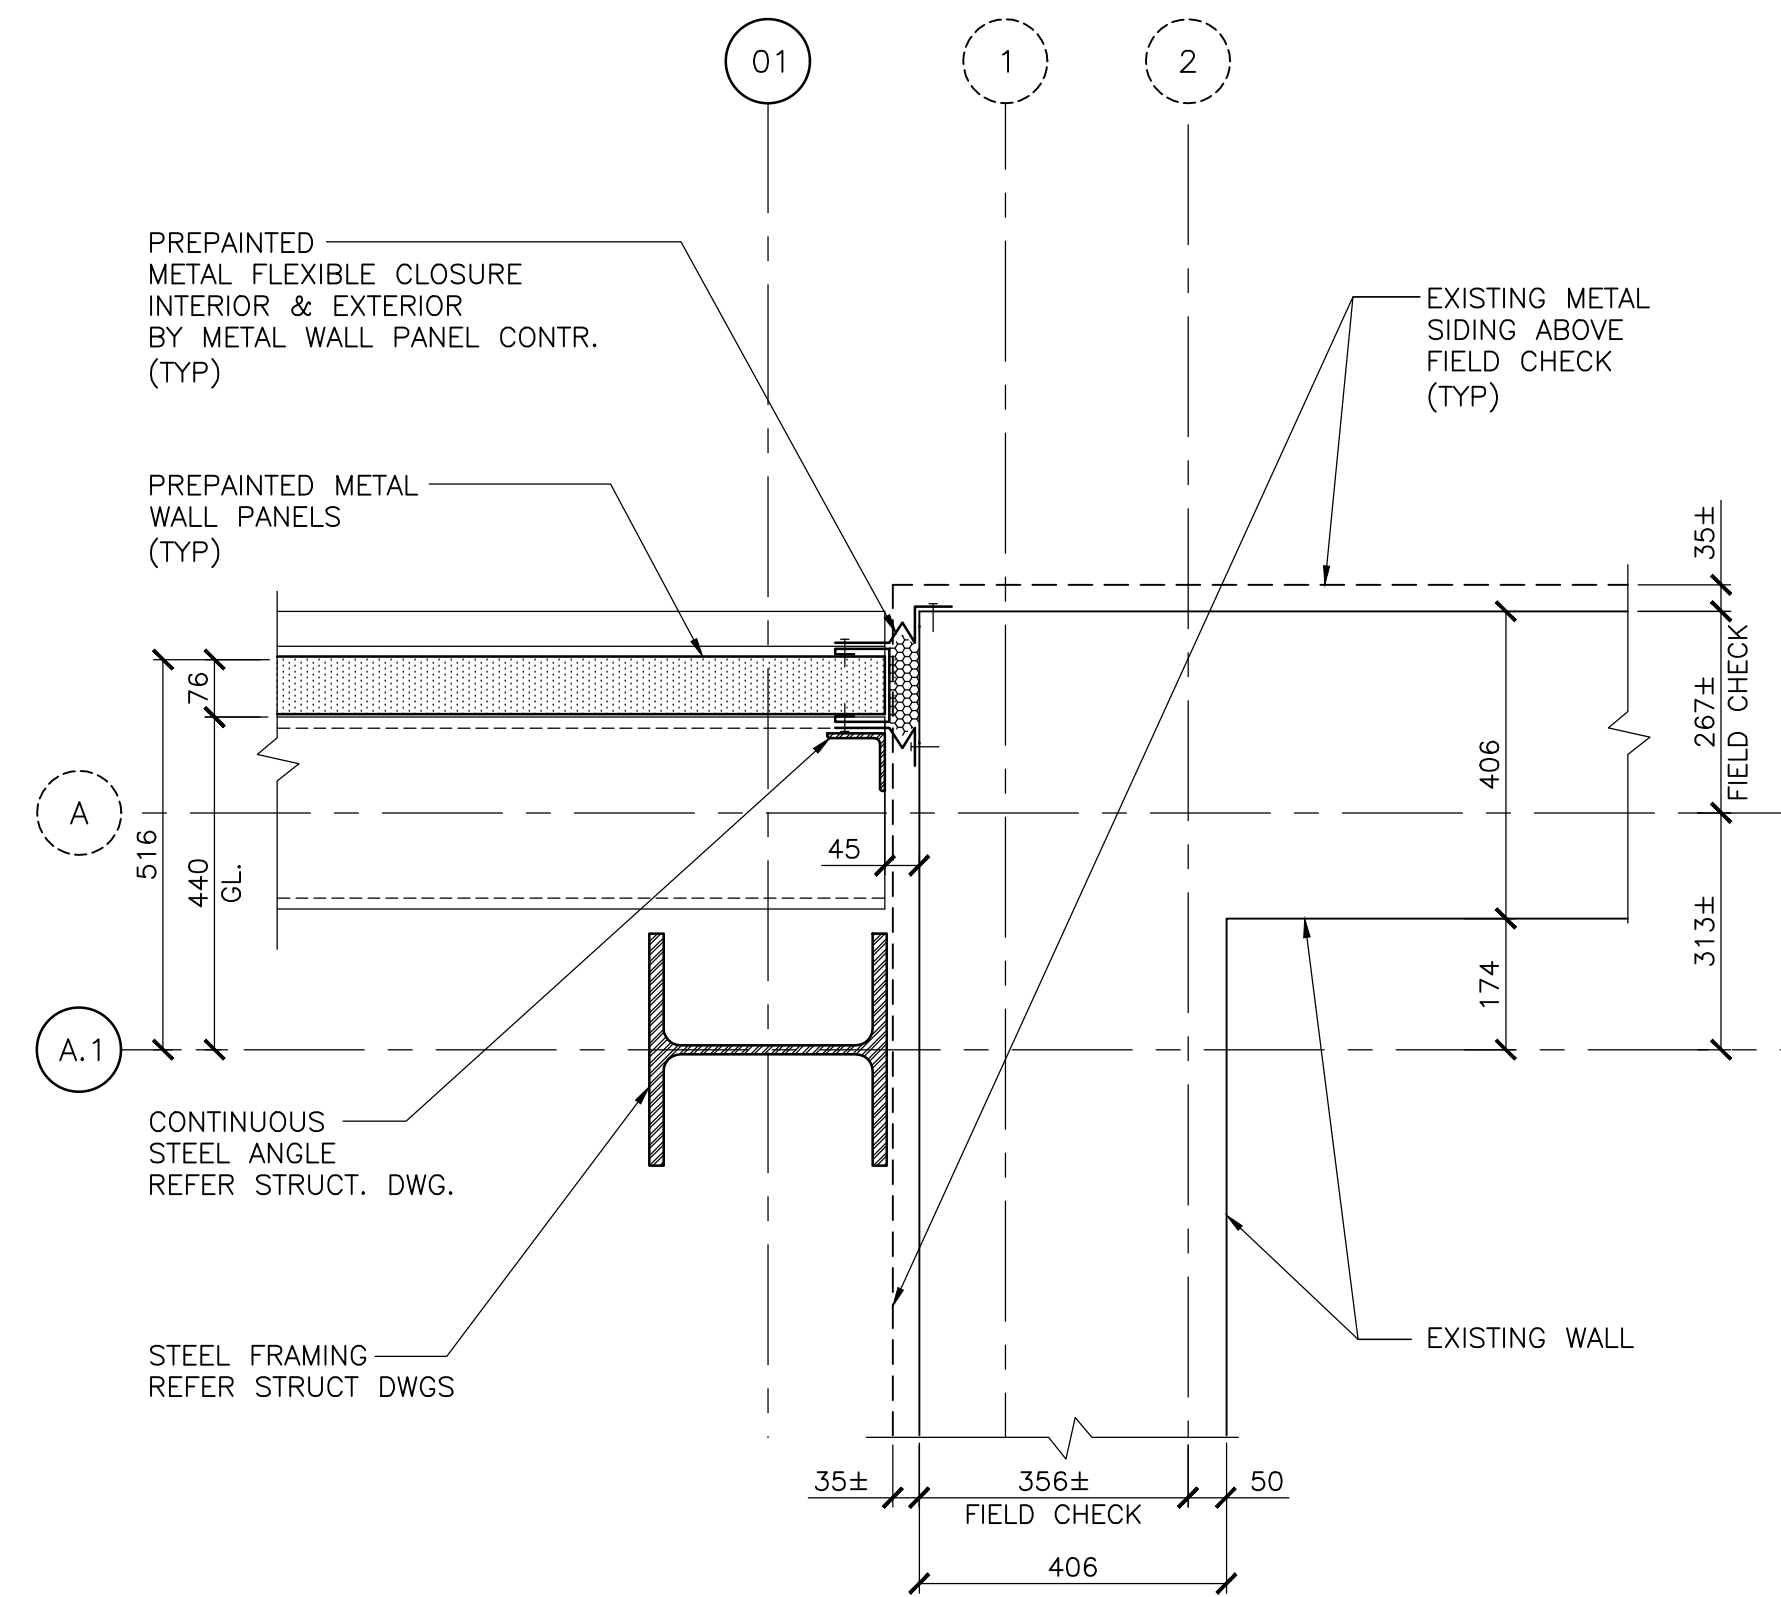


6 PLAN DETAIL
02-A21-01-01 SCALE 1:10


FOR ADDITIONAL NOTES
REFER DET. 8/02-A42-00-01

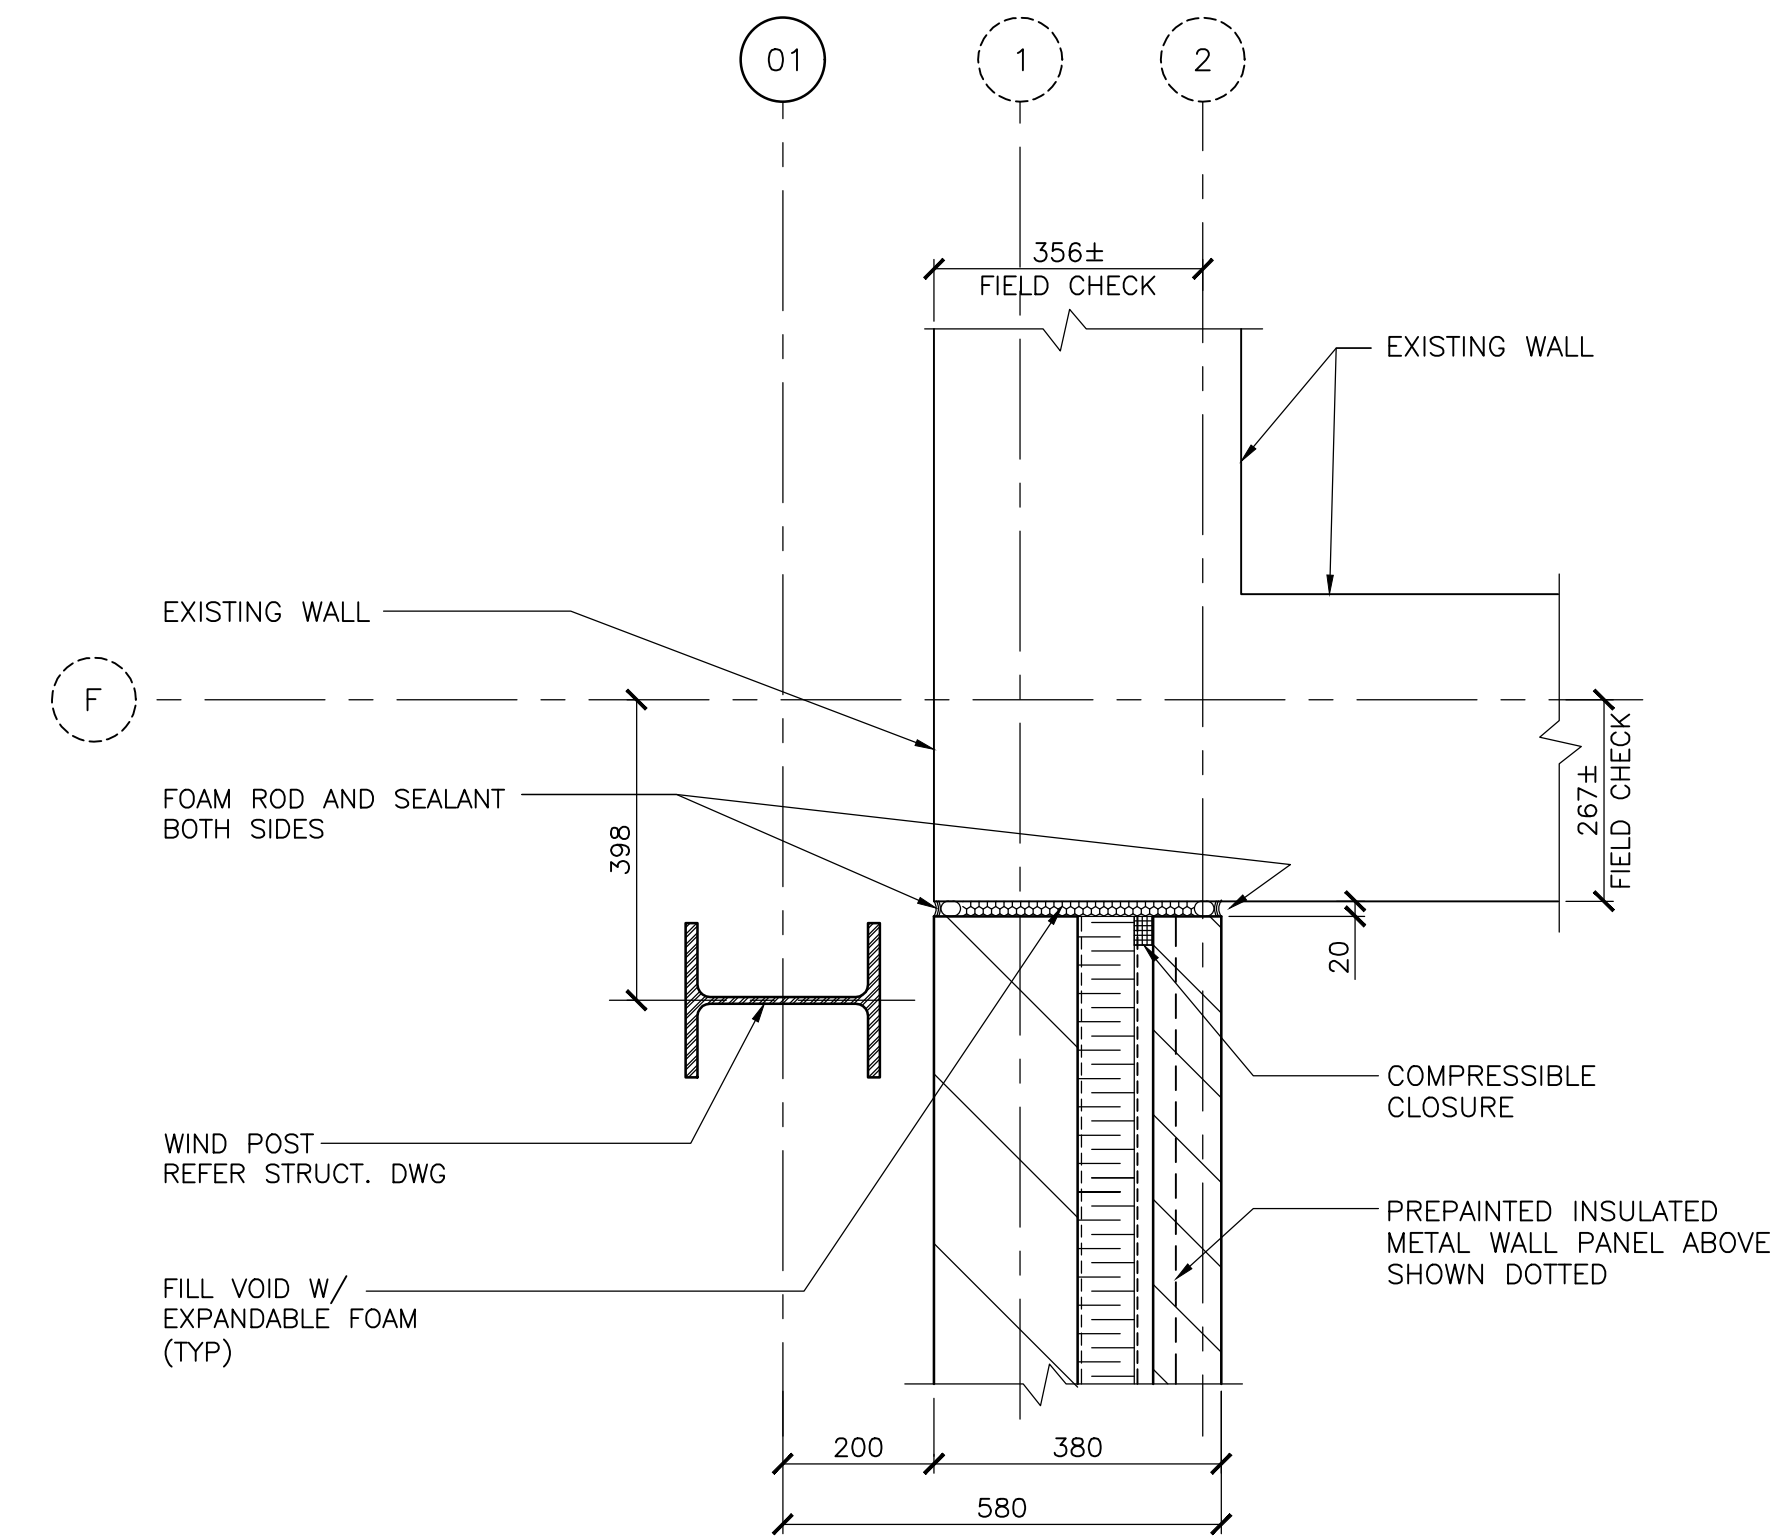


7 PLAN DETAIL
02-A21-01-01 SCALE 1:10

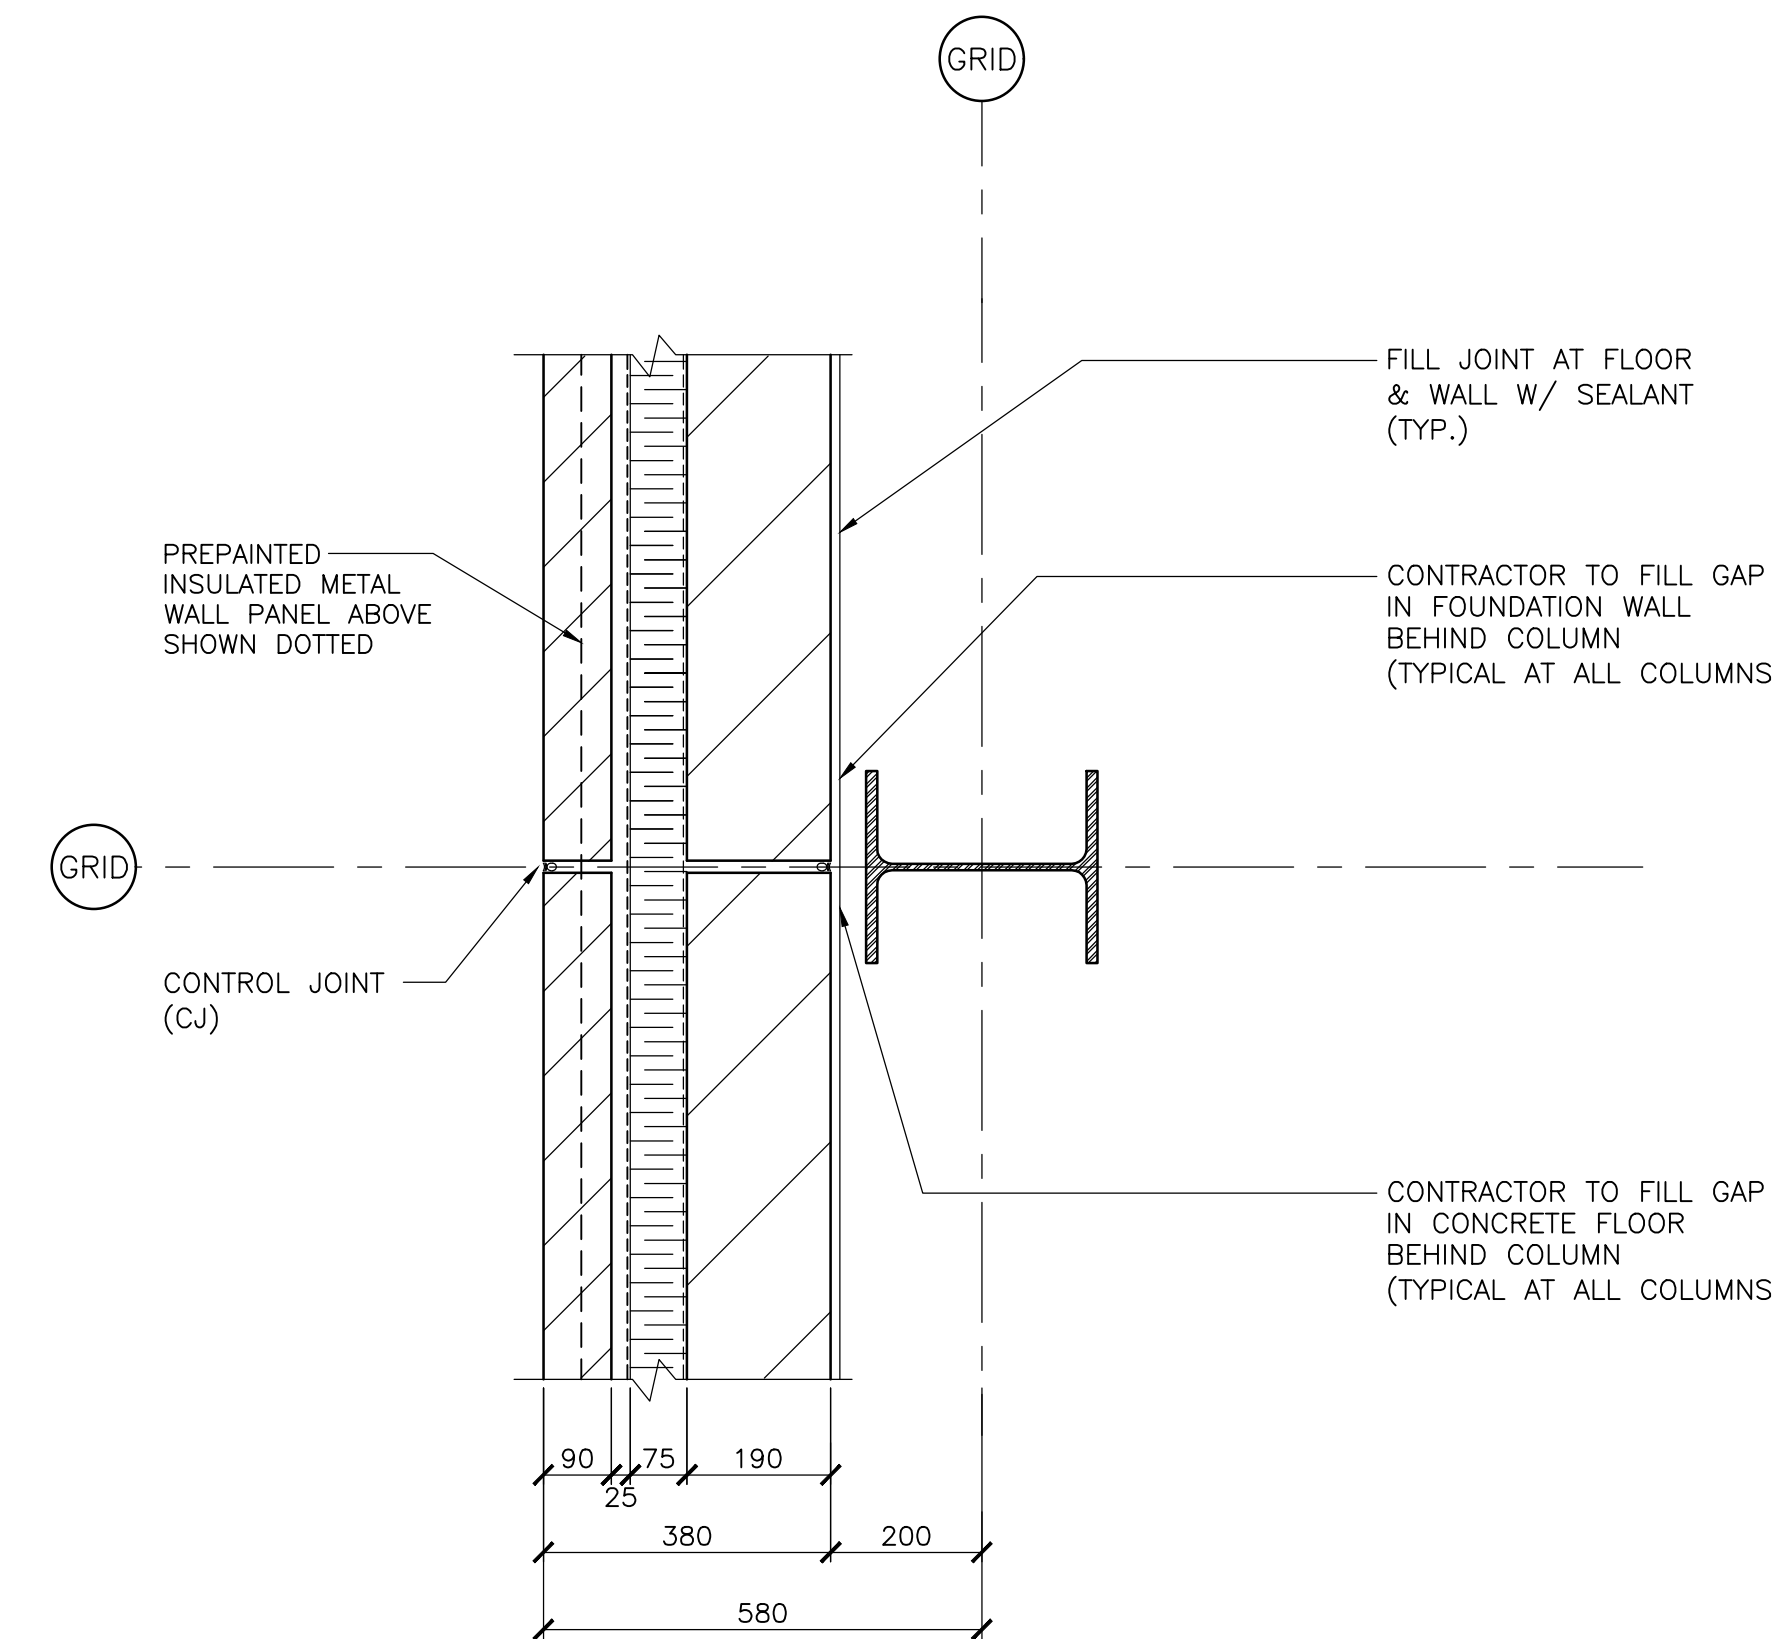


9 PLAN DETAIL
TYPICAL SCALE 1:10

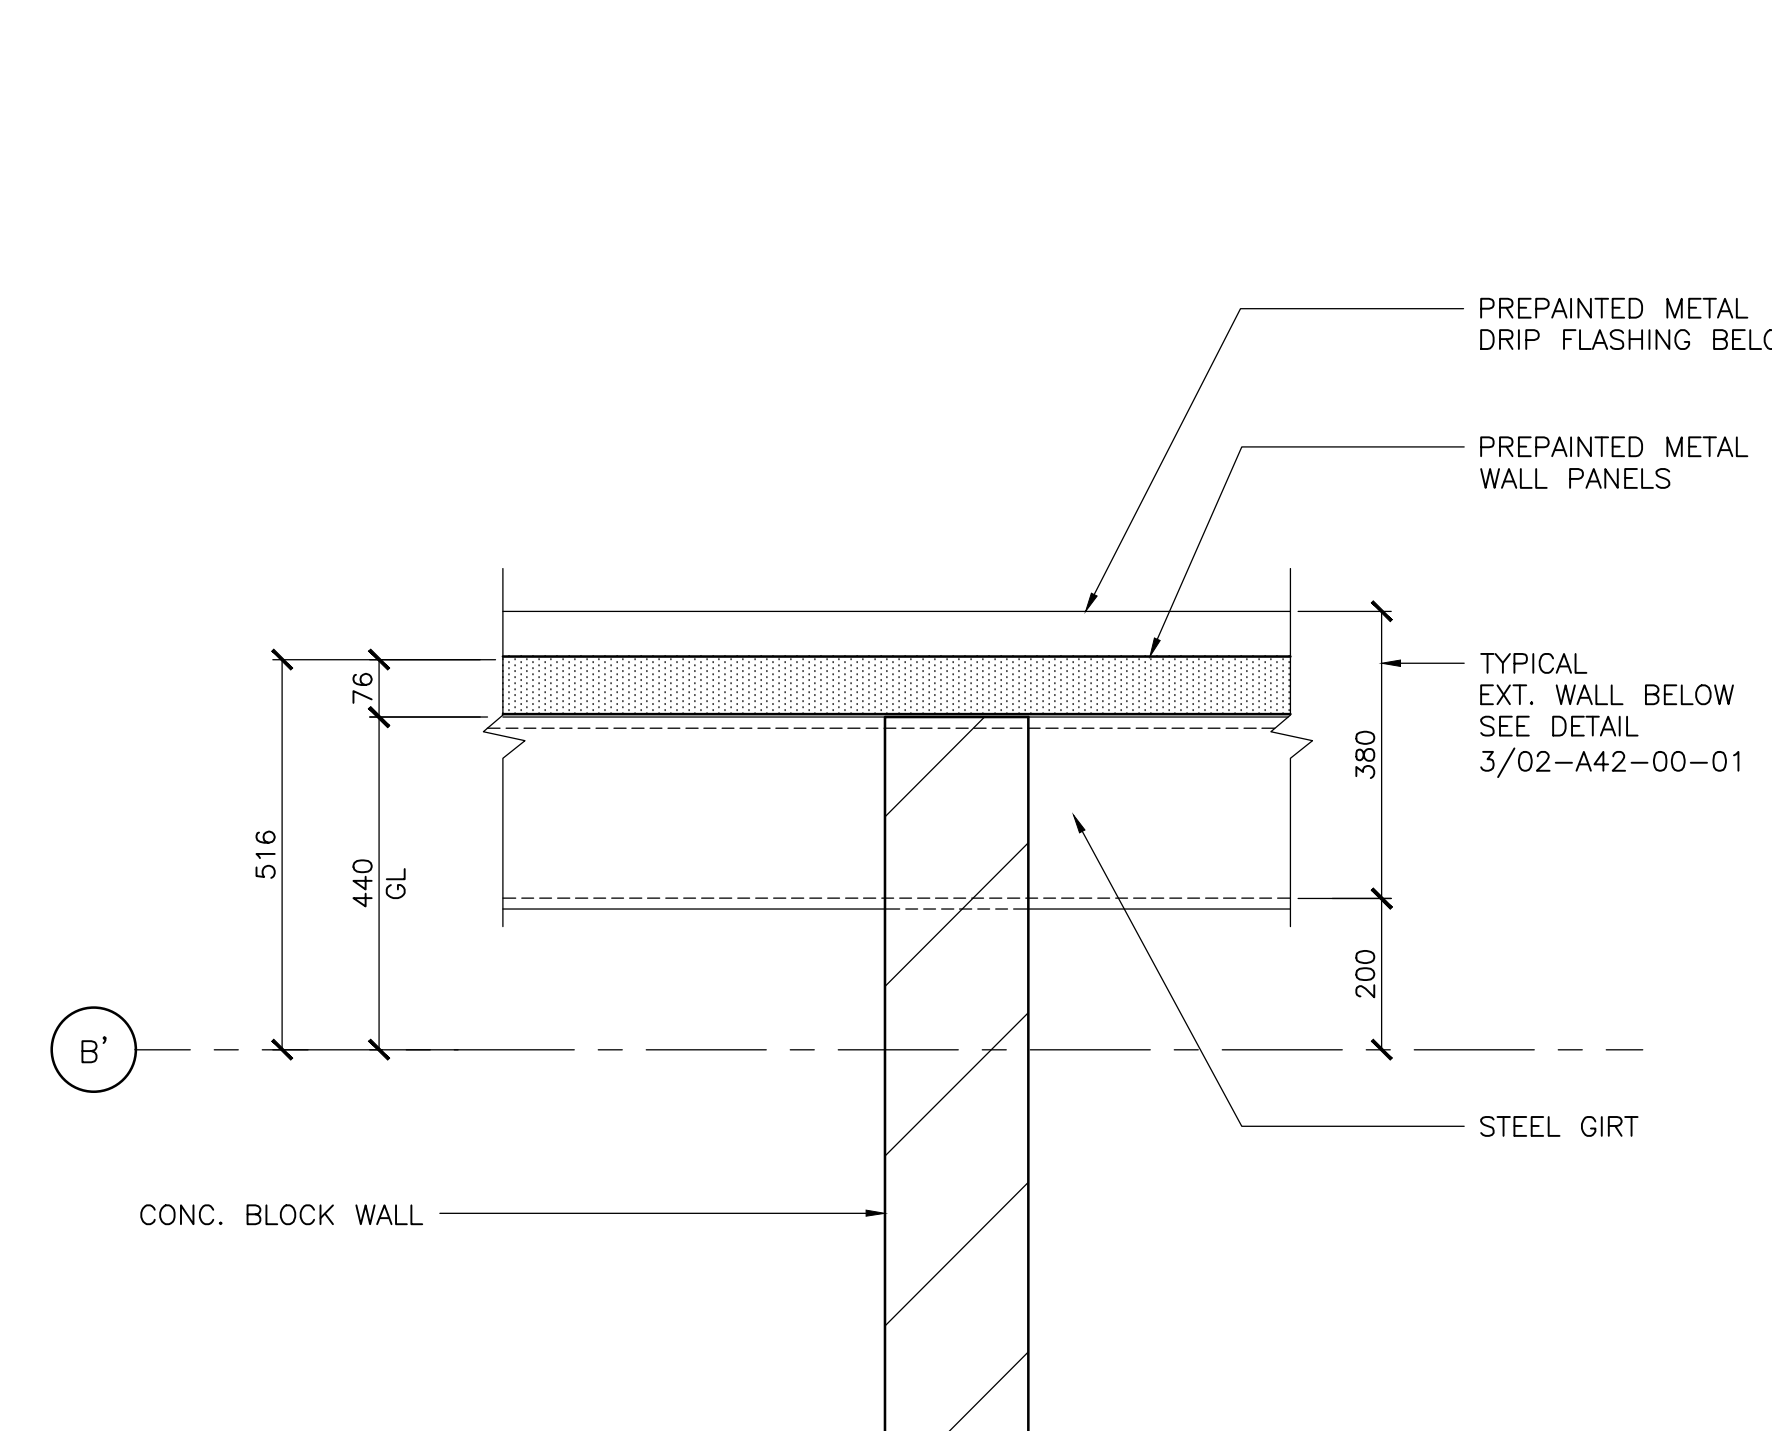

11 PLAN DETAIL @ METAL PANEL
02-A21-01-01 SCALE 1:10

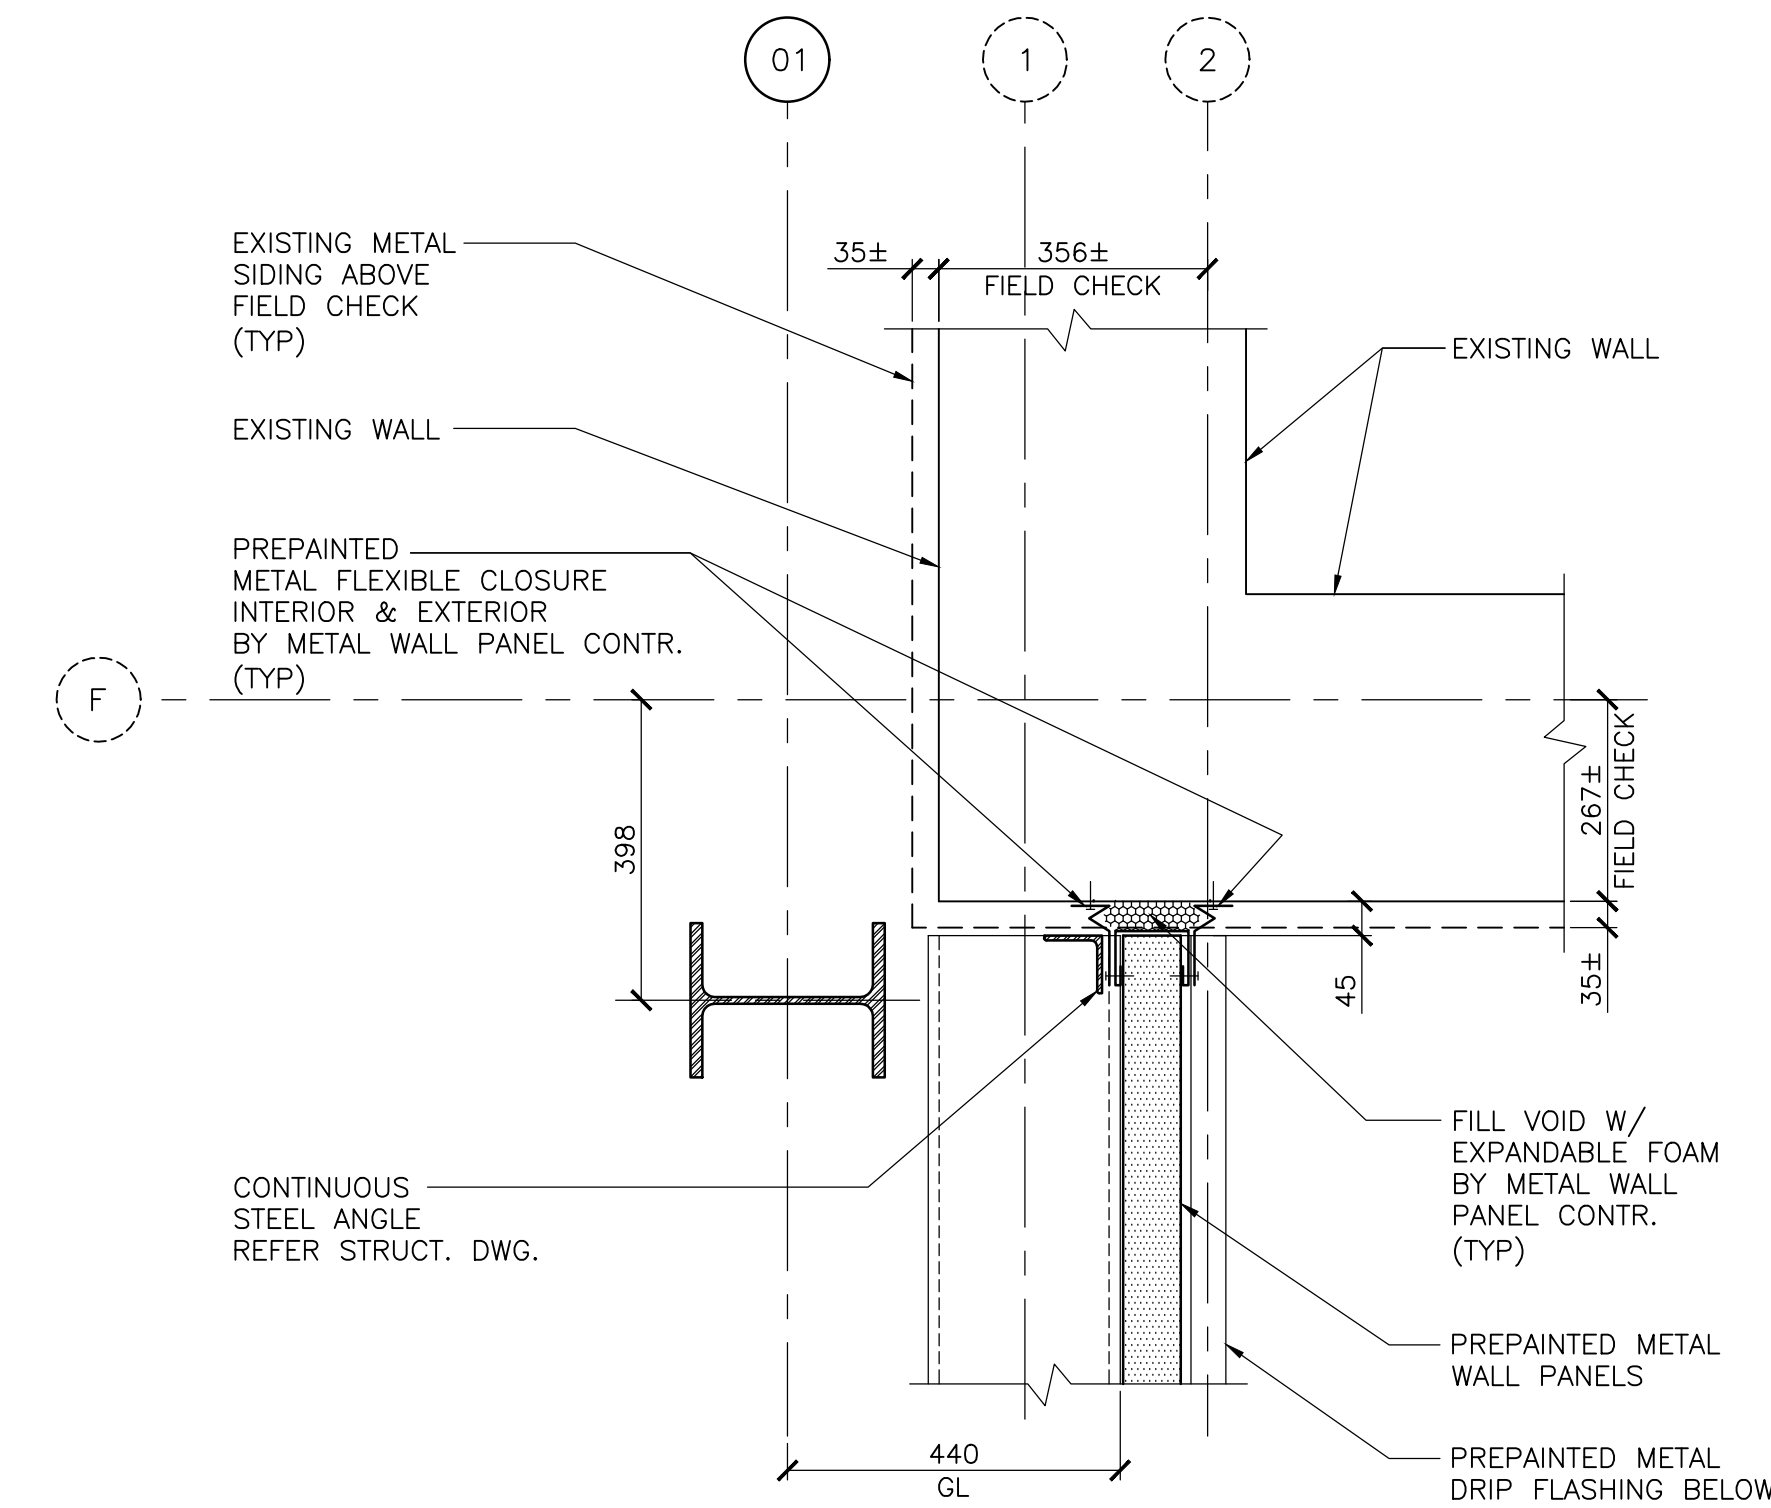

8 PLAN DETAIL
02-A21-01-01 SCALE 1:10

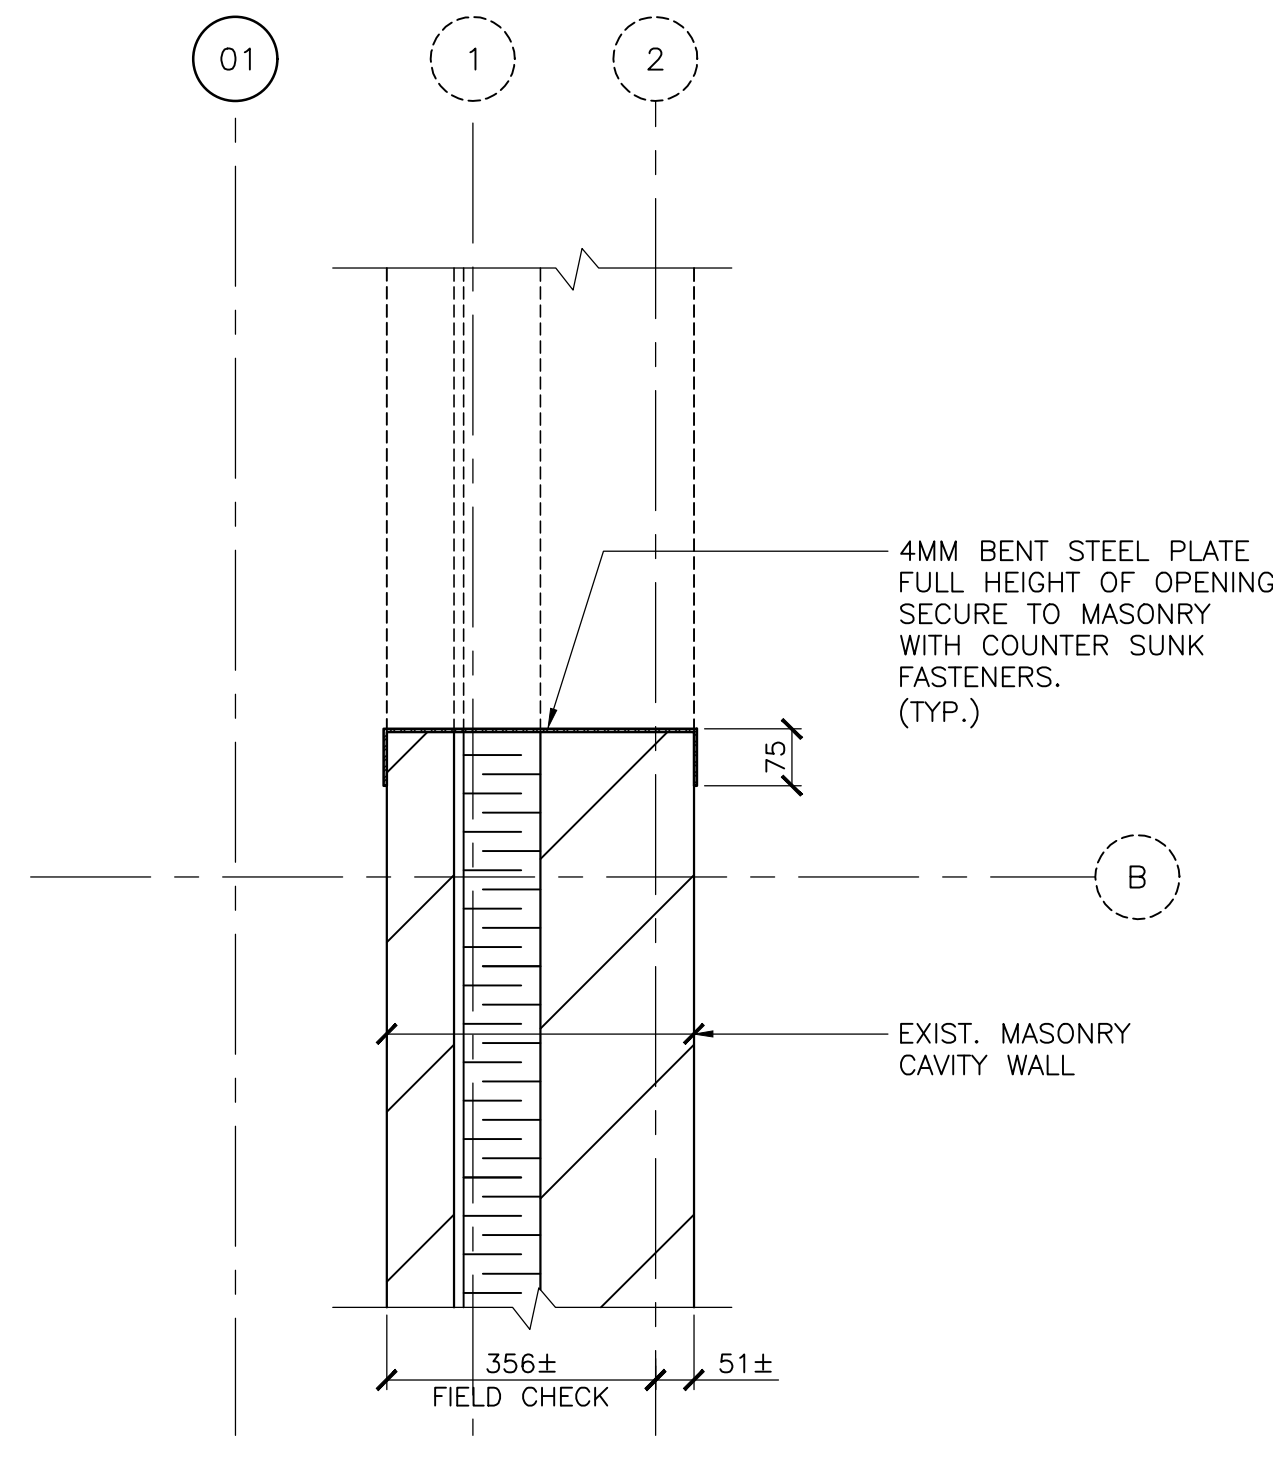

10 PLAN DETAIL
02-A21-01-01 SCALE 1:10

DATE (mm/dd/yyyy)	ISSUED FOR	REV
OCT 01 2018	TENDER	0

KEY PLAN

CONSULTANTS

IBI GROUP
100-175 Galaxy Boulevard Toronto ON M9W 0C9 Canada tel 416 679 1930 fax 416 675 4620 ibigroup.com

This drawing has been prepared solely for the use of the Regional Municipality of Durham and there are no representations of any kind made by IBI Group to any party with whom IBI Group has not entered into a contract

North Arrow	Detail Symbol

Project Manager	Architect/Engineer
A. VAN VEEN	A.V.V. / S.K.
Project Leader	Drawn
R.K. / R.F.	M.F. / D.V.
Date	Checked
DEC 2012	L. BANDIERA
Client	

THE REGIONAL MUNICIPALITY OF DURHAM
WORKS DEPARTMENT ONTARIO

Project
EXPAND GARAGE SCUGOG DEPOT
10 REGIONAL RD. 21, R.R.#14, PORT PERRY


Drawing Title
PLAN DETAILS

Check Scale (may be photo-reduced)
0 1 inch 0 10mm


Project No.	Drawing No.
24RX12.0113	02-A42-00-01

ROD Contract No.
T-1038-2019

User Name: Joseph Patel Plot Date: Time: Monday, March 18, 2019 2:45:50 PM Path and File Name: j:\24rx12.013.durham region enno & scugog depot\5.9 drawing\3\enno\layouts\02-a42-00-02.dwg

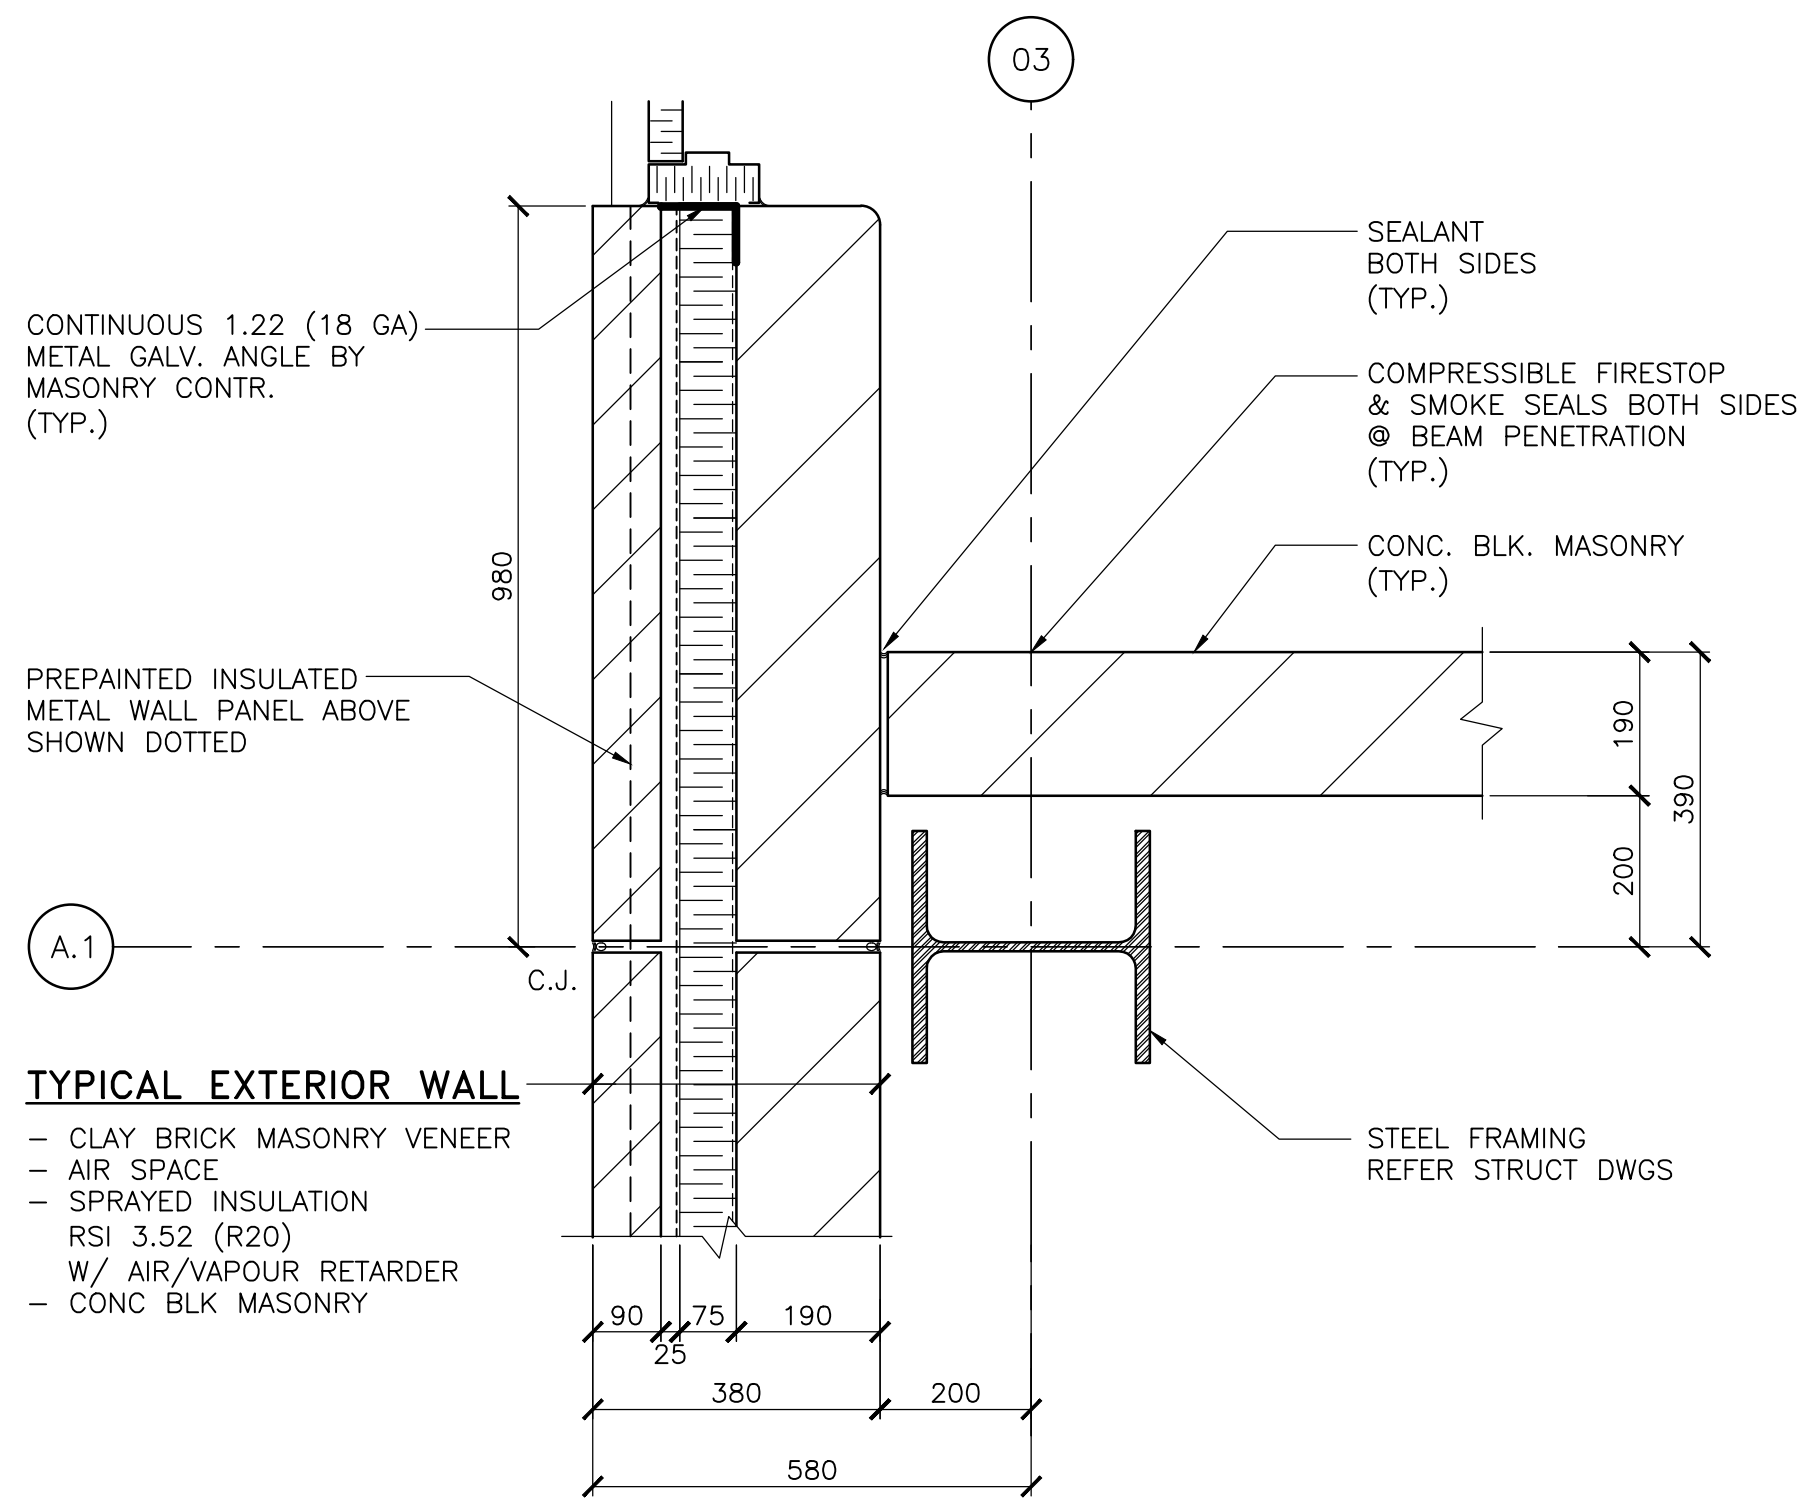


13 PLAN DETAIL
02-A21-01-01 SCALE 1:10

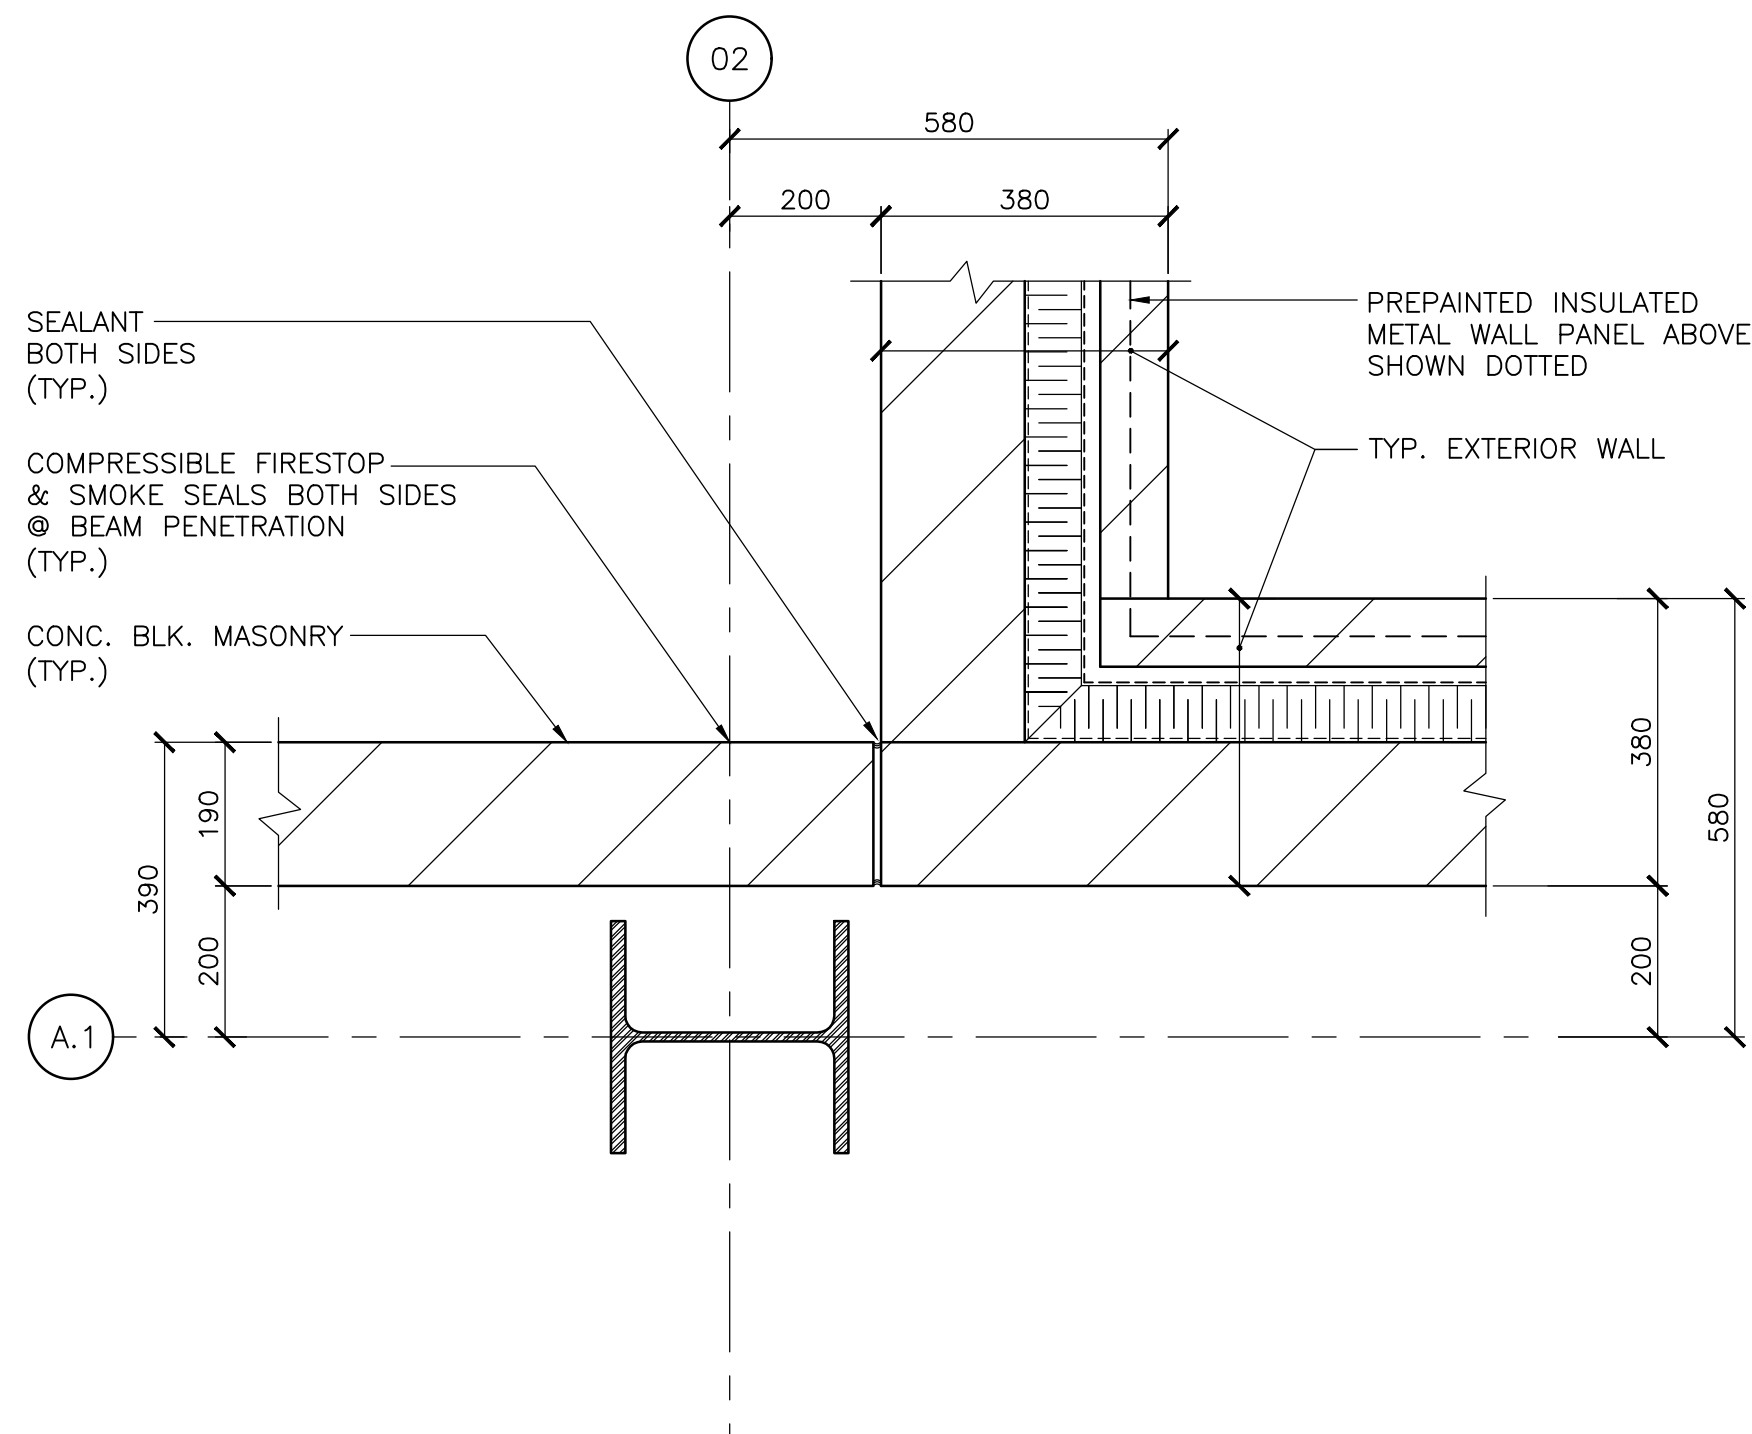


15 PLAN DETAIL
02-A21-01-01 SCALE 1:10

FOR ADDITIONAL NOTES
REFER DET. 13/02-A42-00-02

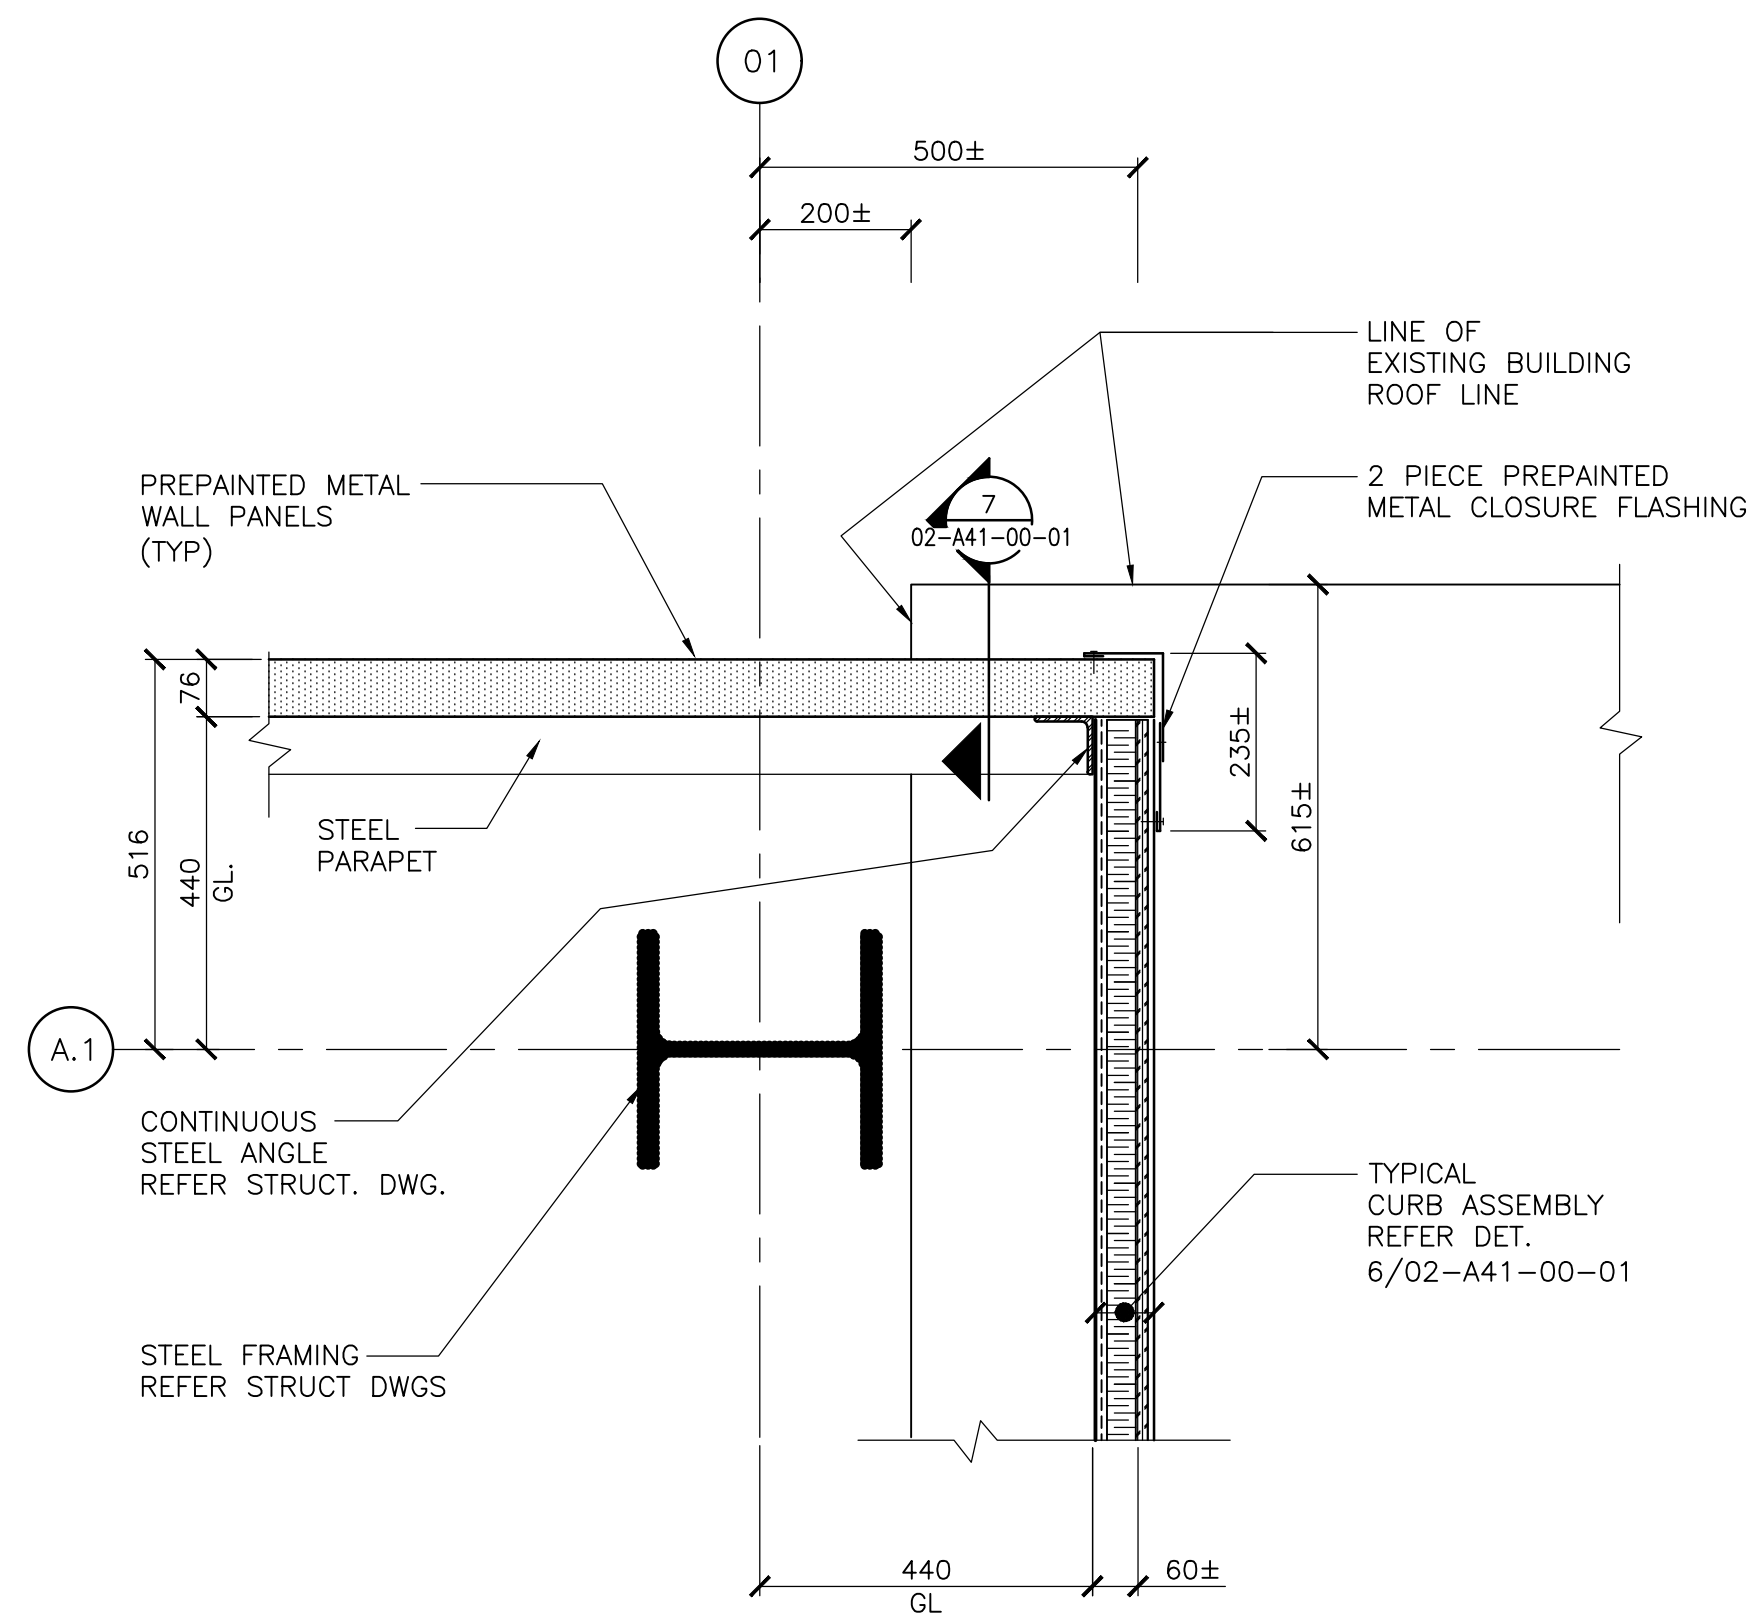


17 PLAN DETAIL
02-A23-00-01 SCALE 1:10

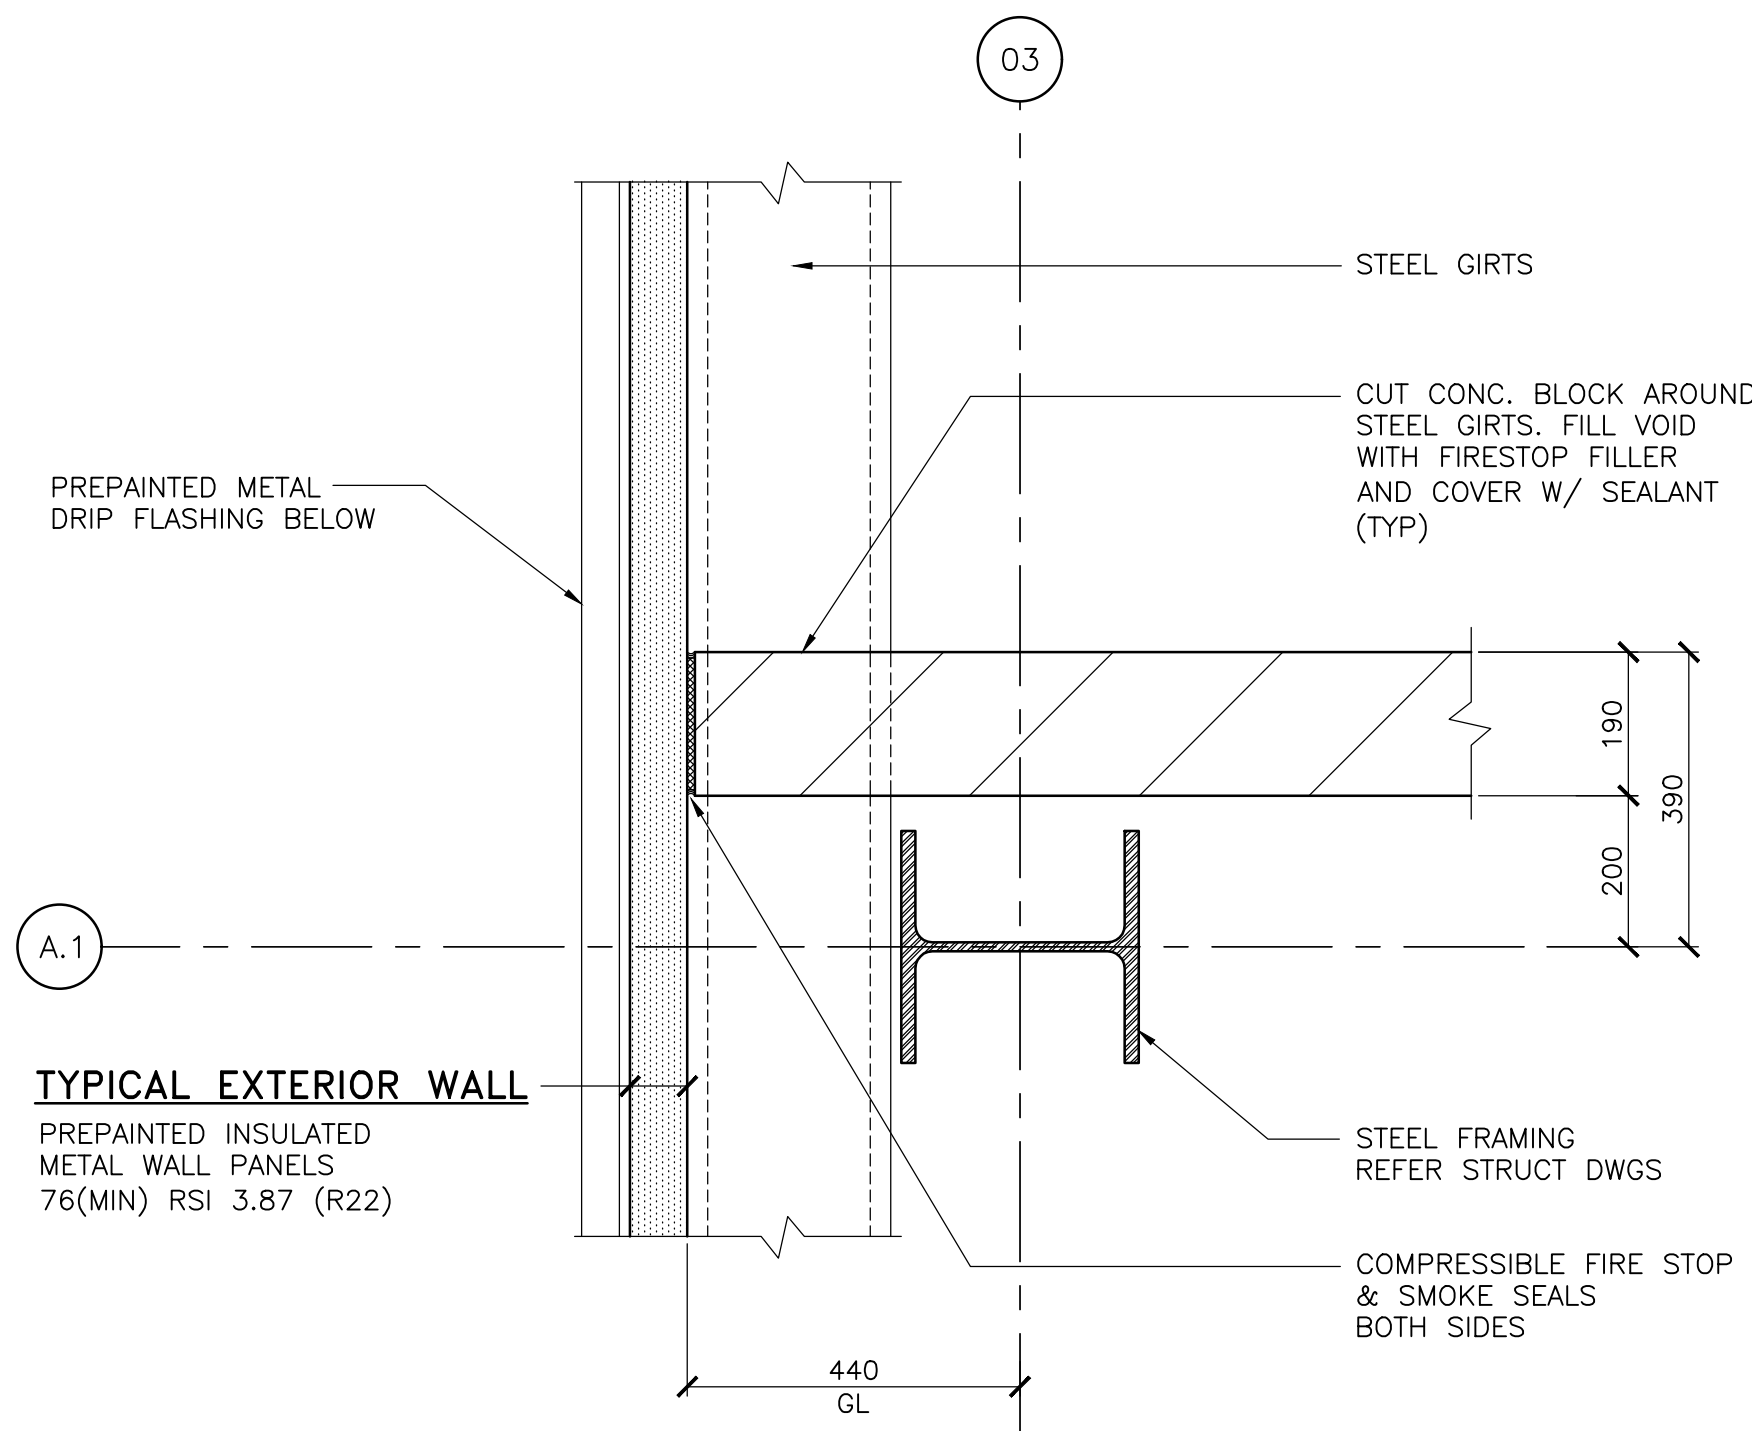


14 PLAN DETAIL
02-A21-01-01 SCALE 1:10

FOR ADDITIONAL NOTES
REFER DET. 13/02-A42-00-02

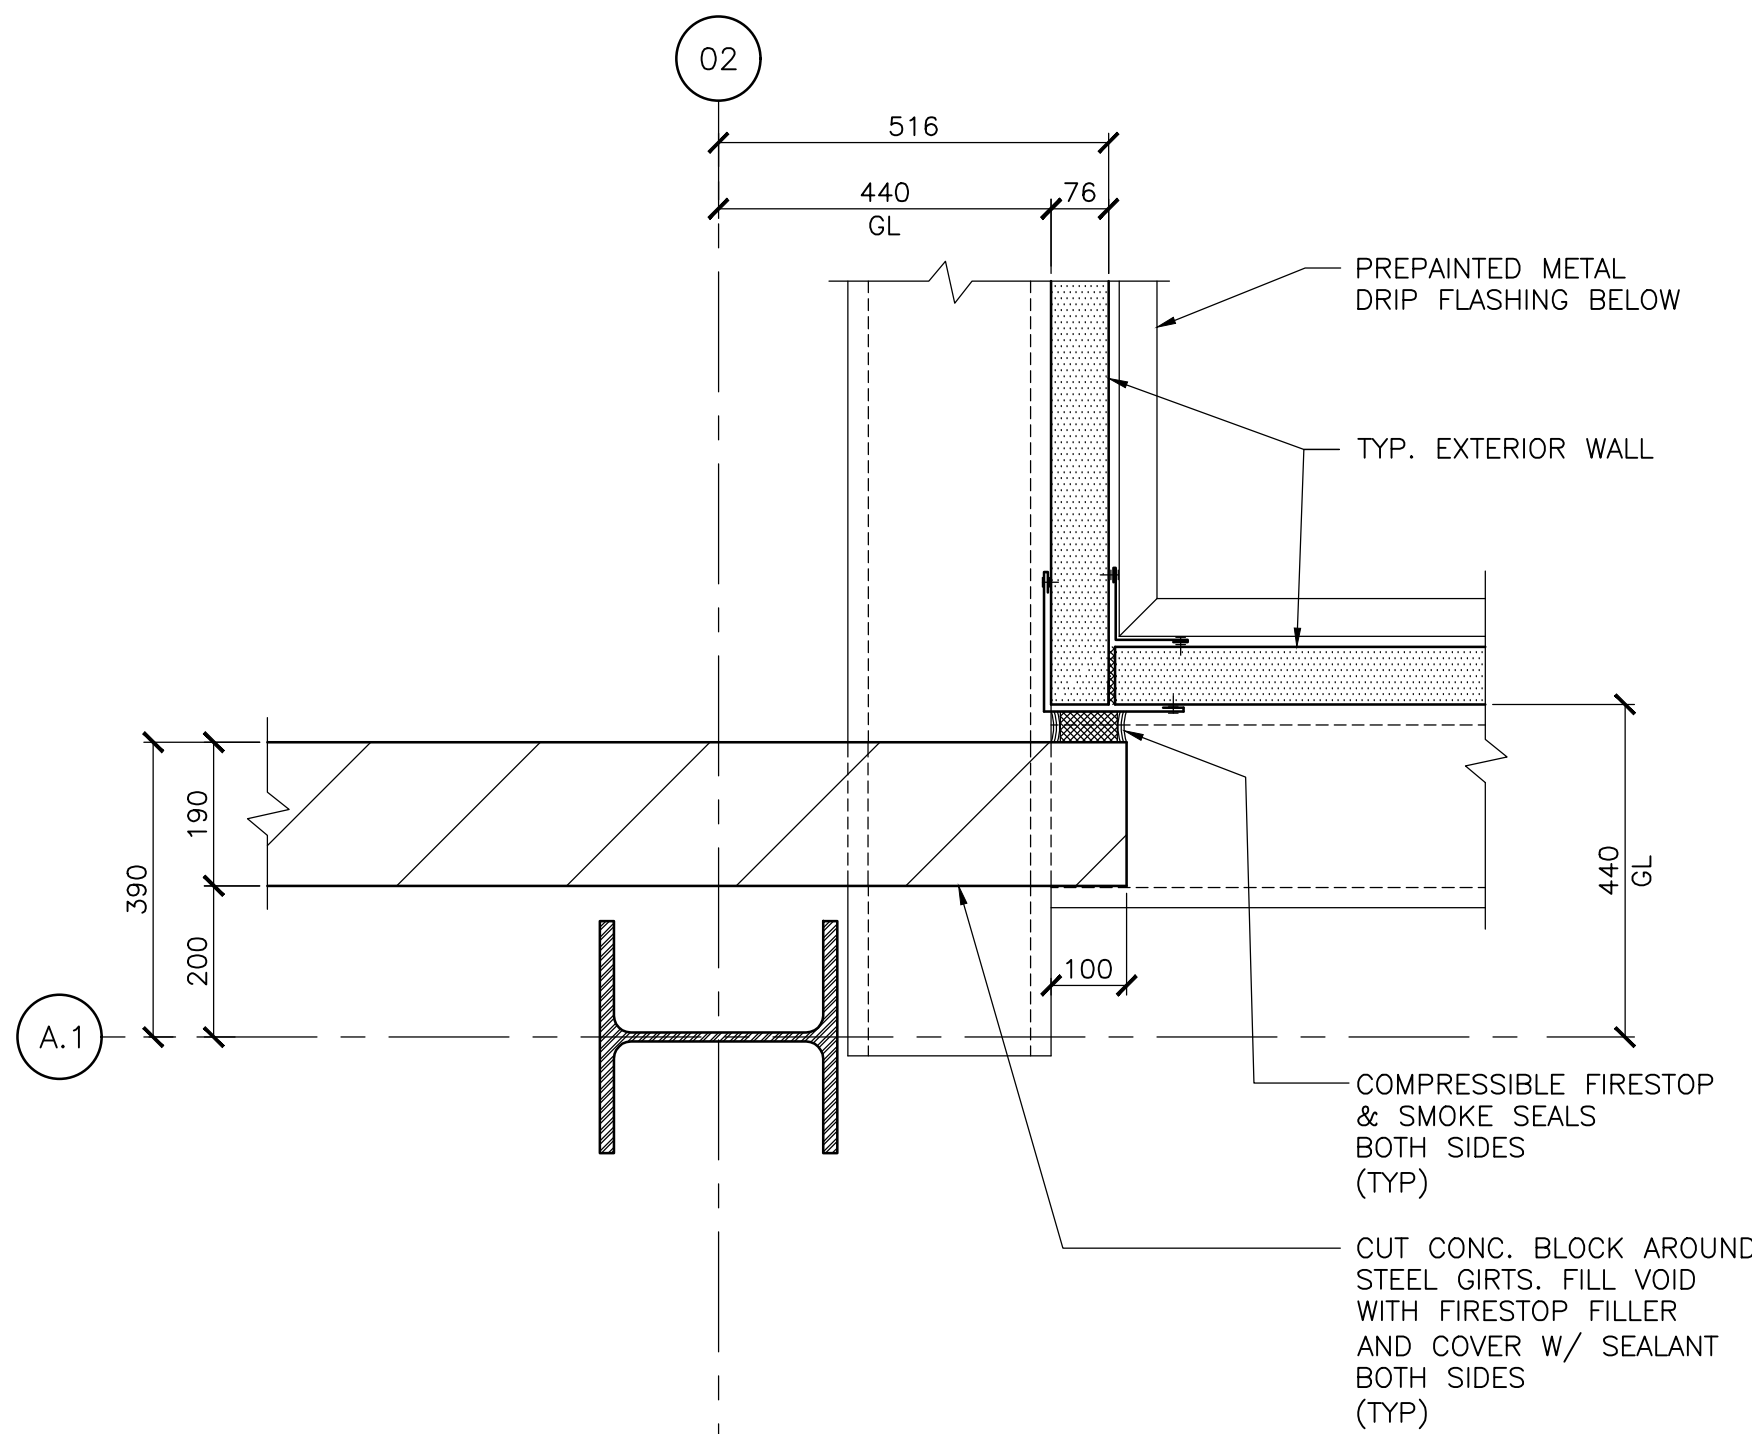


16 PLAN DETAIL
02-A21-01-01 SCALE 1:10

FOR ADDITIONAL NOTES
REFER DET. 14&15/02-A42-00-02

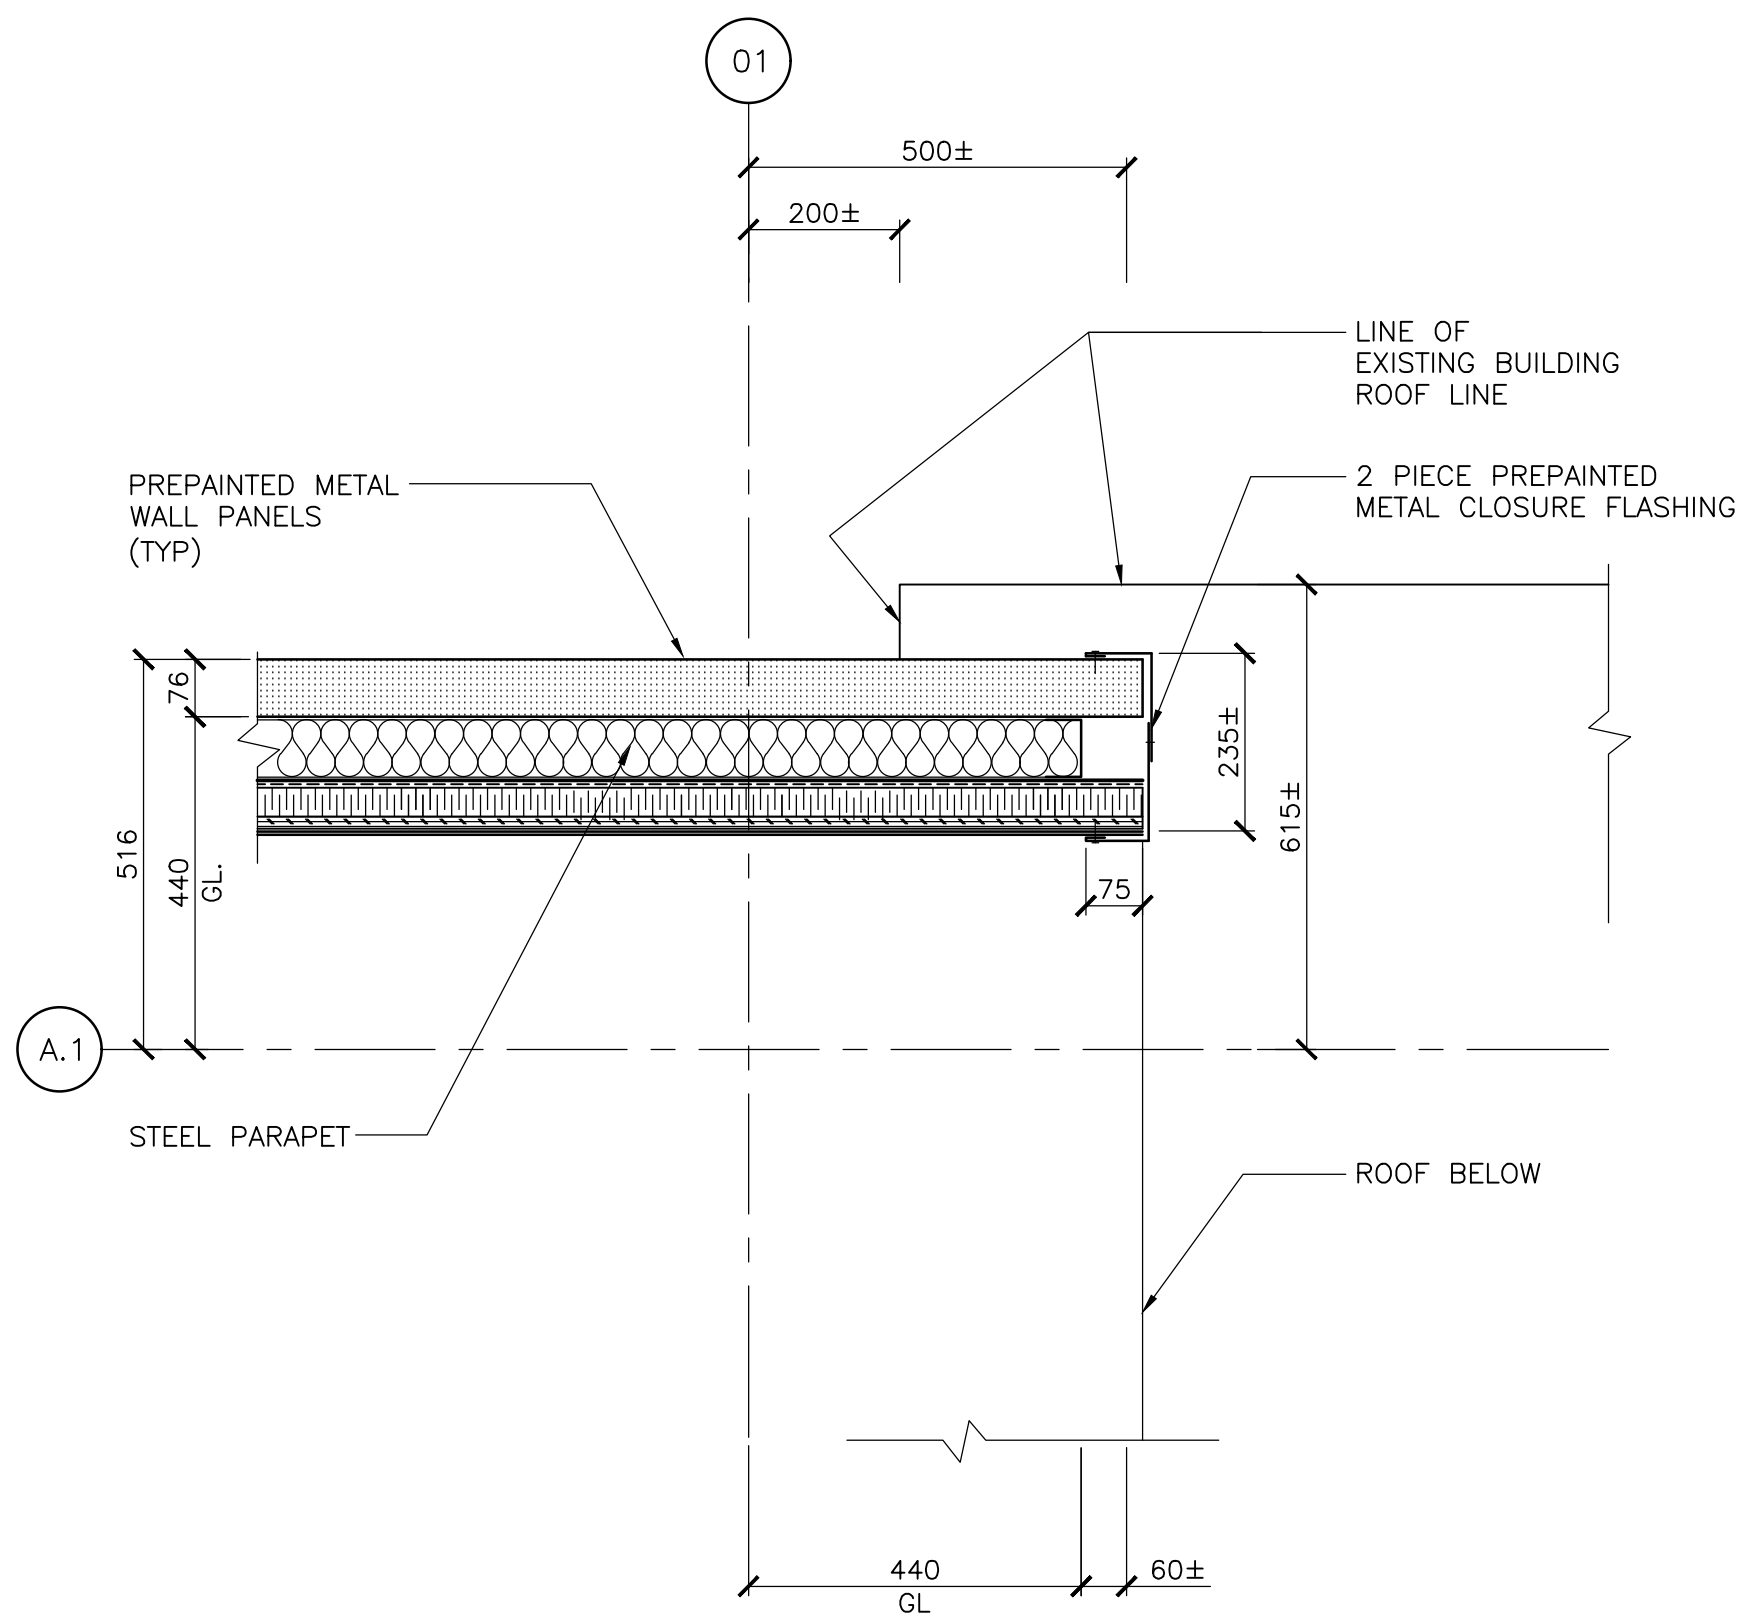

18 PLAN DETAIL
02-A23-00-01 SCALE 1:10

FOR ADDITIONAL NOTES
REFER DET. 17/02-A42-00-02

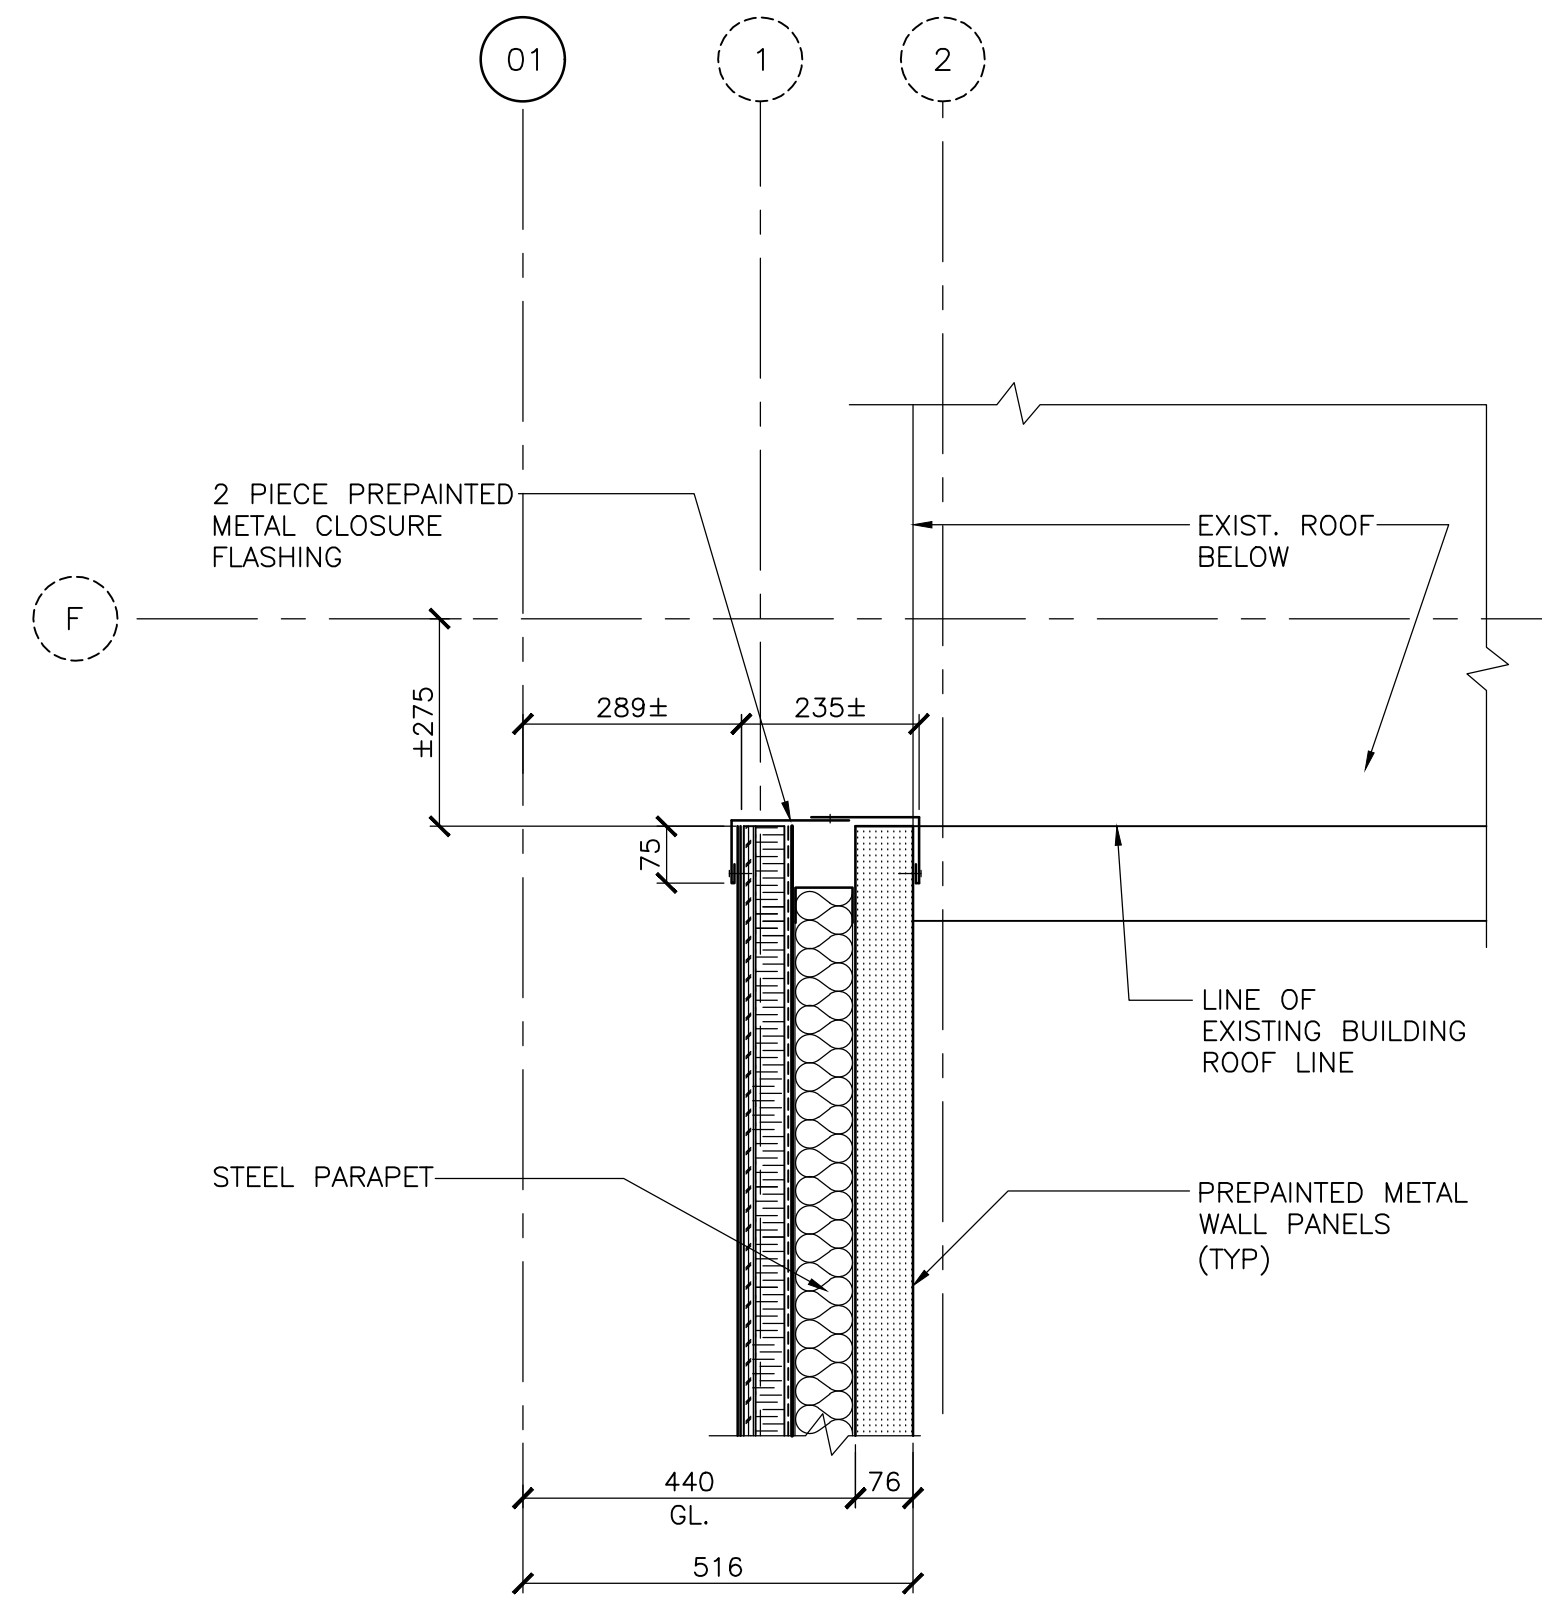

19 PLAN DETAIL
02-A23-00-01 SCALE 1:10

FOR ADDITIONAL NOTES
REFER DET. 18/02-A42-00-02

DATE (mm dd yyyy)	ISSUED FOR	REV
OCT 01 2018	TENDER	0

KEY PLAN

CONSULTANTS


IBI GROUP	
100-175 Galaxy Boulevard Toronto ON M9W 0C9 Canada tel 416 679 1930 fax 416 675 4620 ibi@ibi.com	

This drawing has been prepared solely for the use of the Regional Municipality of Durham and there are no representations of any kind made by IBI Group to any party with whom IBI Group has not entered into a contract	

North Arrow	Detail Symbol

Project Manager	Architect/Engineer
A. VAN VEEN	A.V.V. / S.K.
Project Leader	Drawn
R.K. / R.F.	D.V.
Date	Checked
AUG 2017	L. BANDIERA
Client	
 THE REGIONAL MUNICIPALITY OF DURHAM WORKS DEPARTMENT ONTARIO	
Project	
EXPAND GARAGE SCUGOG DEPOT 10 REGIONAL RD. 21, R.R.#14, PORT PERRY	
Drawing Title	
PLAN DETAILS	
Check Scale (may be photo-reduced)	
Project No.	Drawing No.
24RX12.0113	02-A42-00-02

ROD Contract No. **T-1038-2019**

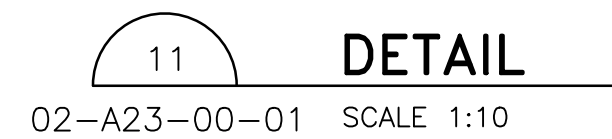

Project No.	Drawing No.
24RX12.0113	02-A43-00-01

ROD Contract No.
T-1038-2019



1
TYPICAL

SECTIONAL OVERHEAD DOOR
SCALE 1:10



02-A45-00-01  PERSONNEL DOOR SCALE 1:10





PERSONNEL DOOR
 TYPICAL SCALE 1:10



02-A45-00-01



02-A45-00-01 PERSONNEL DOOR SCALE 1:10

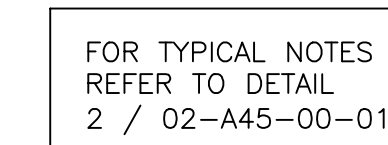

Project Manager K. VAN VEEN	Architect/Engineer A.V.V. / S.R.
Project Leader R.K. / R.F.	Drawn M.F. / D.V.
Date NOV 2012	Checked L. BANDIERA

Client

THE REGIONAL MUNICIPALITY
OF DURHAM

WORKS DEPARTMENT

WHITBY ONTARIO

Project

EXPAND GARAGE
SCUGOG DEPOT

10 REGIONAL RD. 21, R.R.#14, PORT PERRY

Drawing Title

DOOR DETAILS

Check Scale (may be photo-reduced)

0 in 4

0 mm 100mm









Project No.	Drawing No.
24RX12.0113	02-A45-00-01



Project No.	Drawing No.
24RX12.0113	02-A46-00-01

ROD Contract No.
T-1038-2019

User Name: Joseph Patel Plot Date: Time: Monday, March 18, 2019 2:45:01 PM Path and File Name: J:\24x12.0113_durham region enro & scugog depot\5.9 drawing\3\enro\layouts\02-a83-00-01.dwg

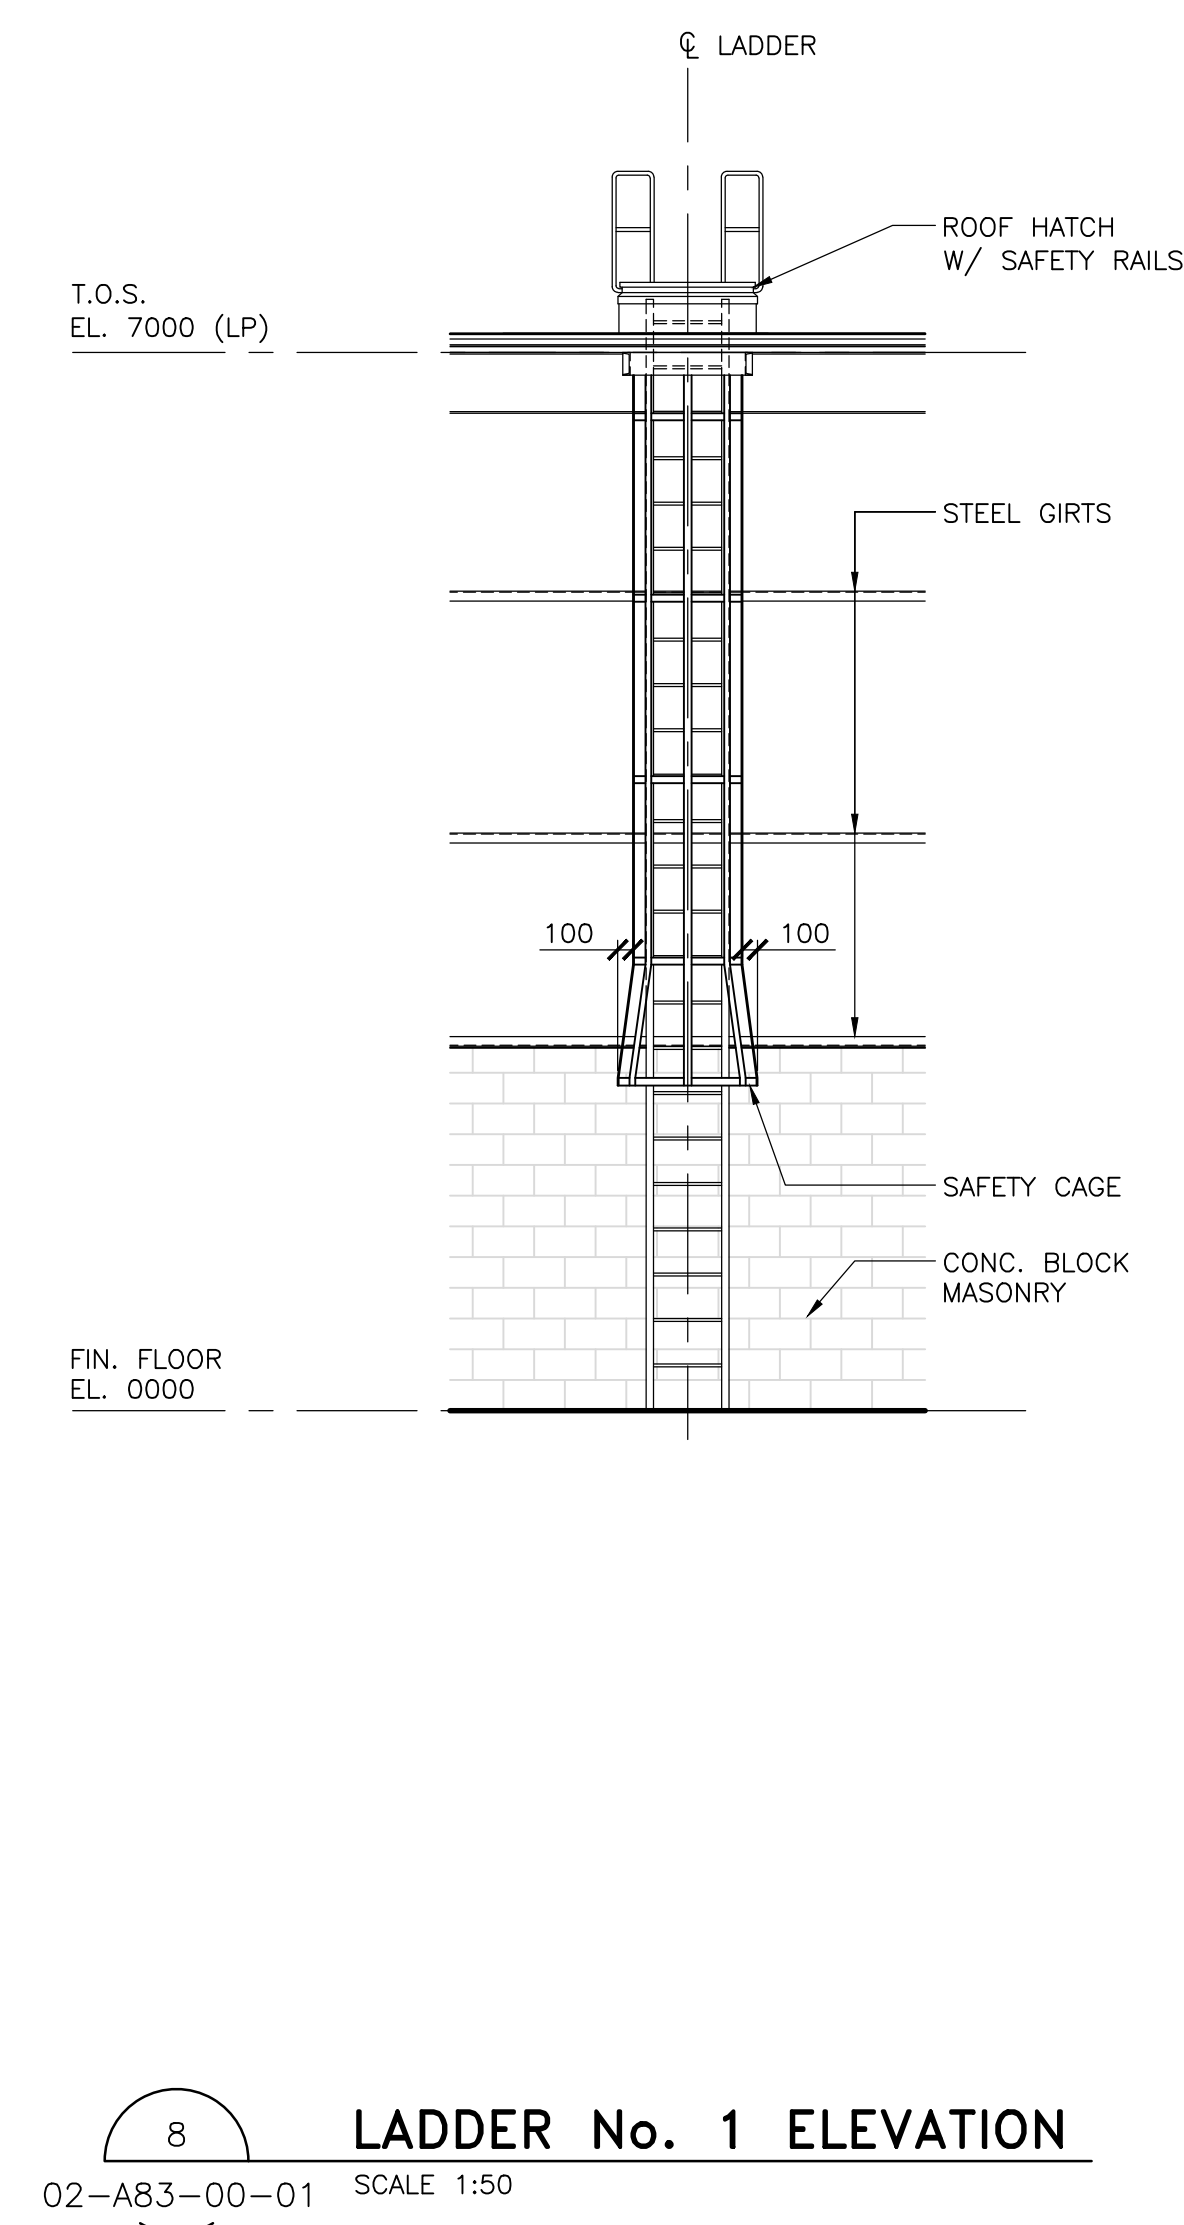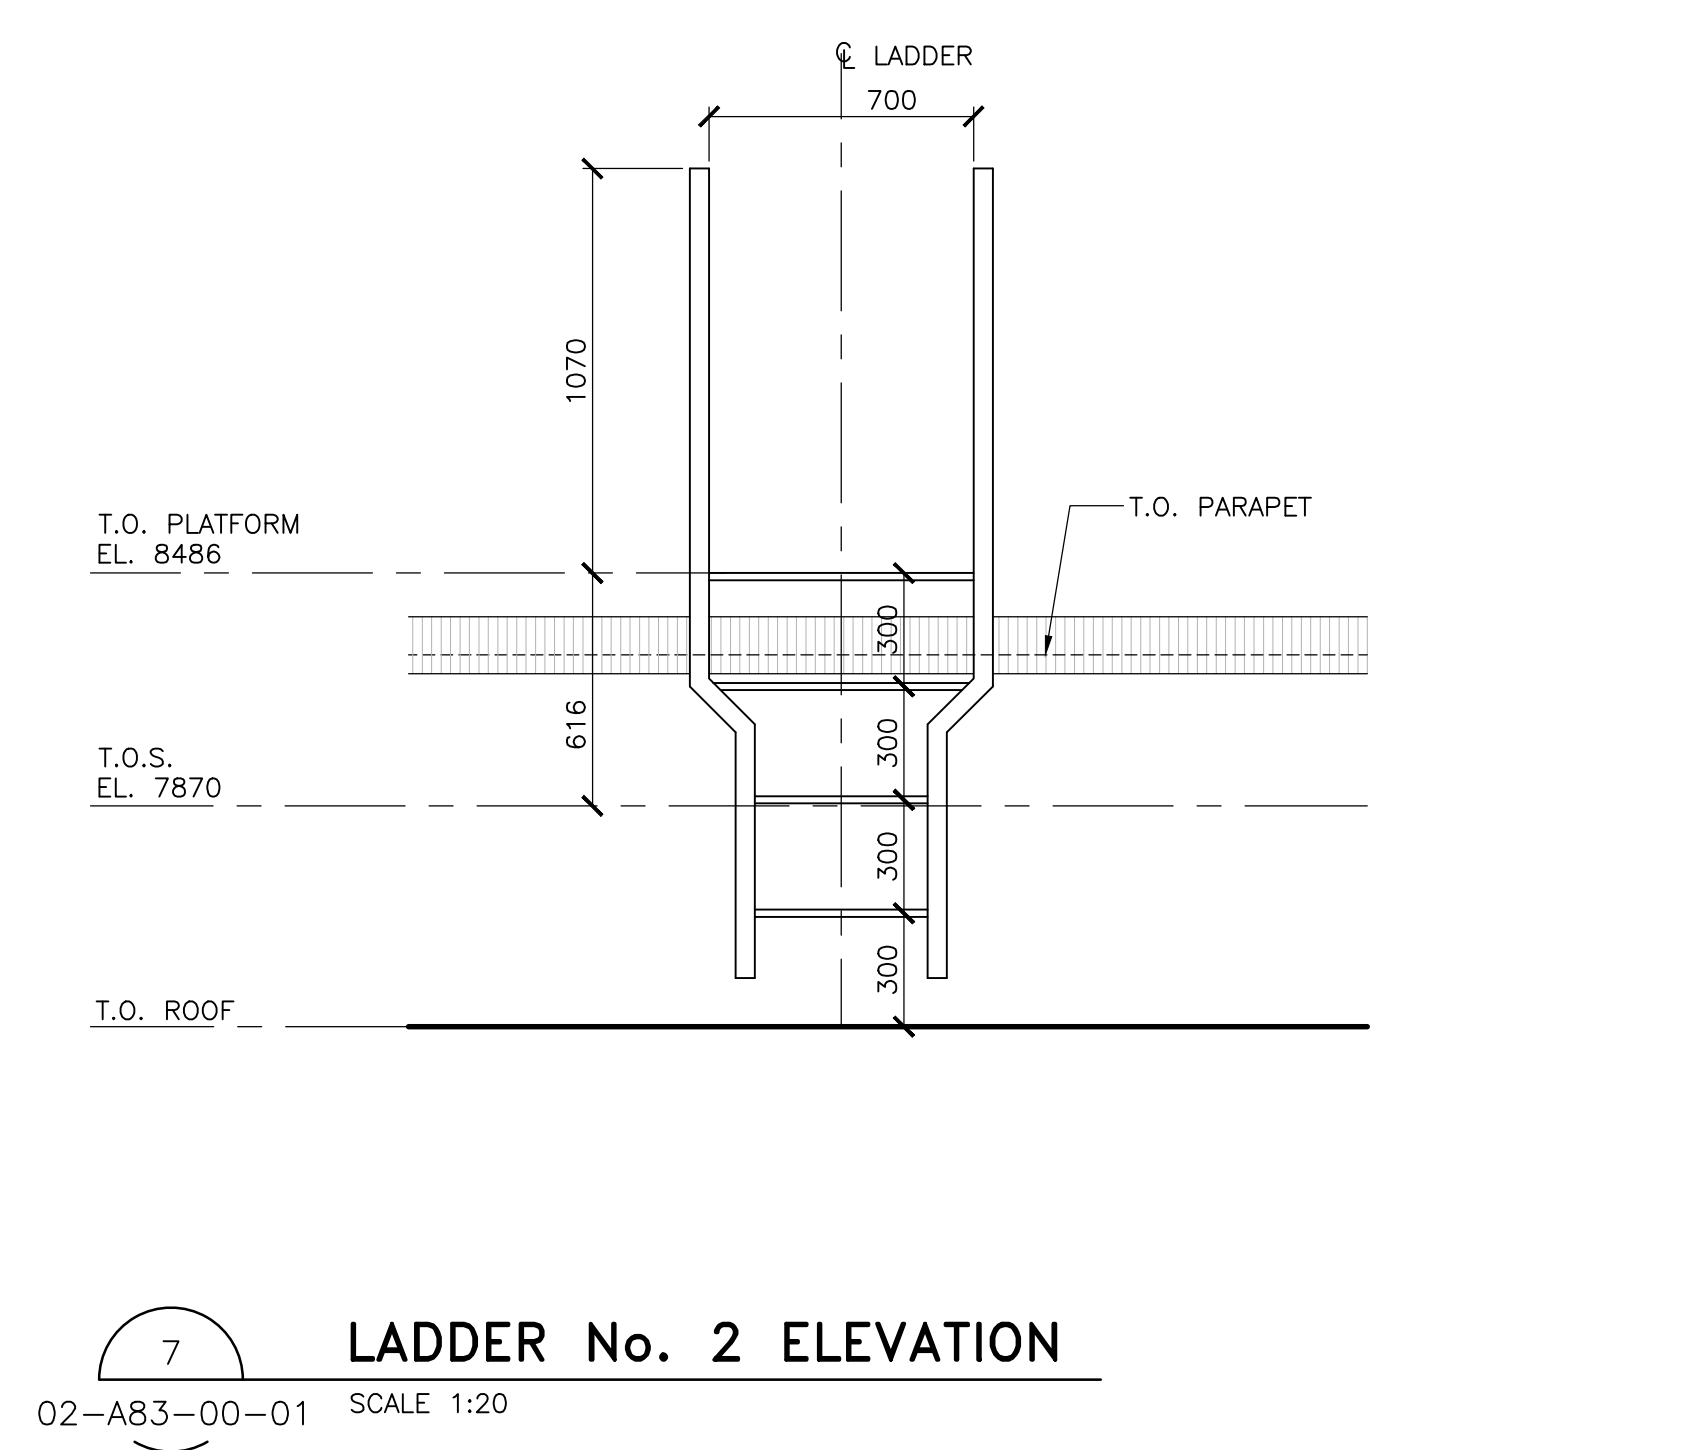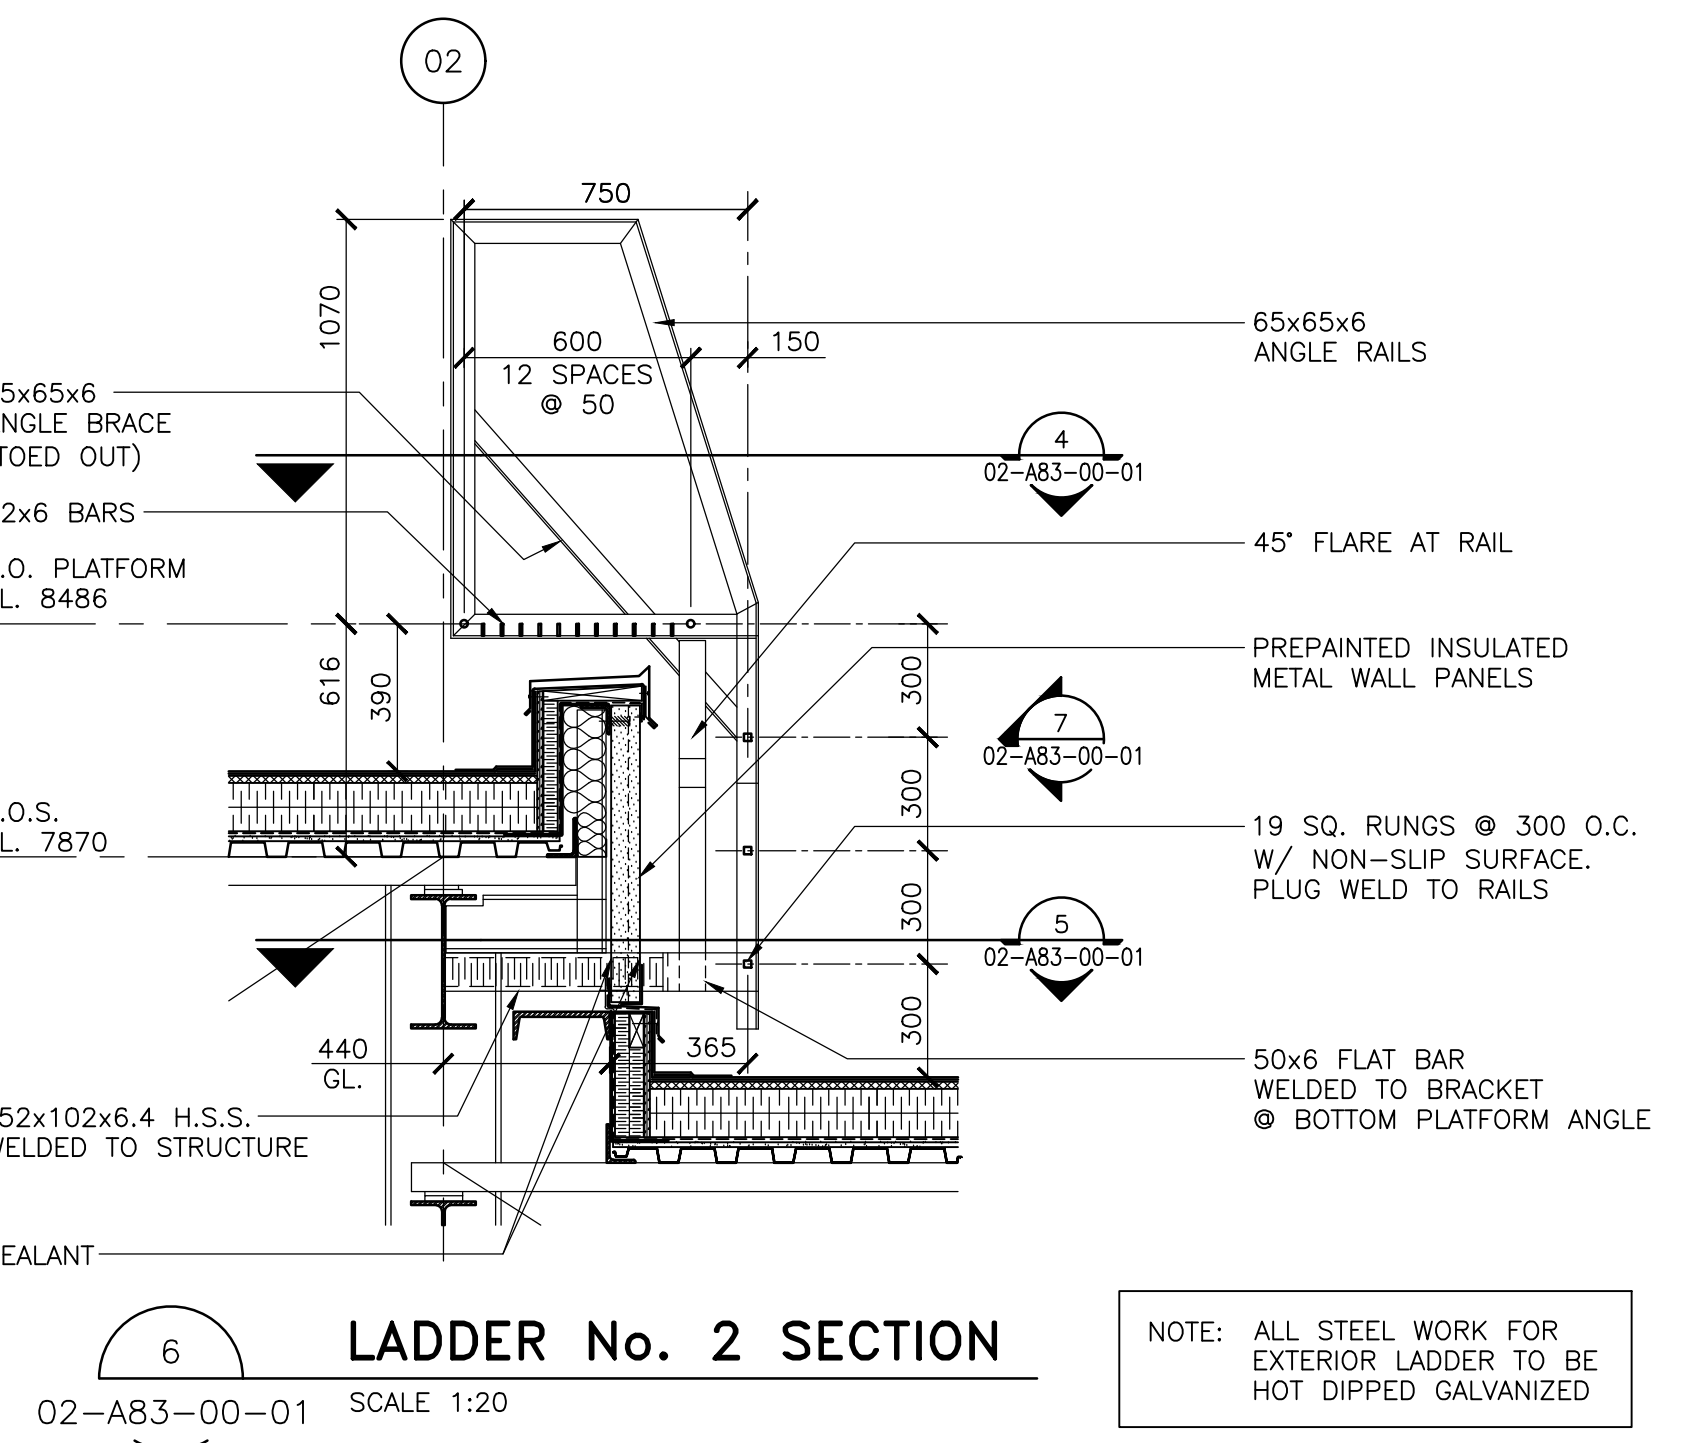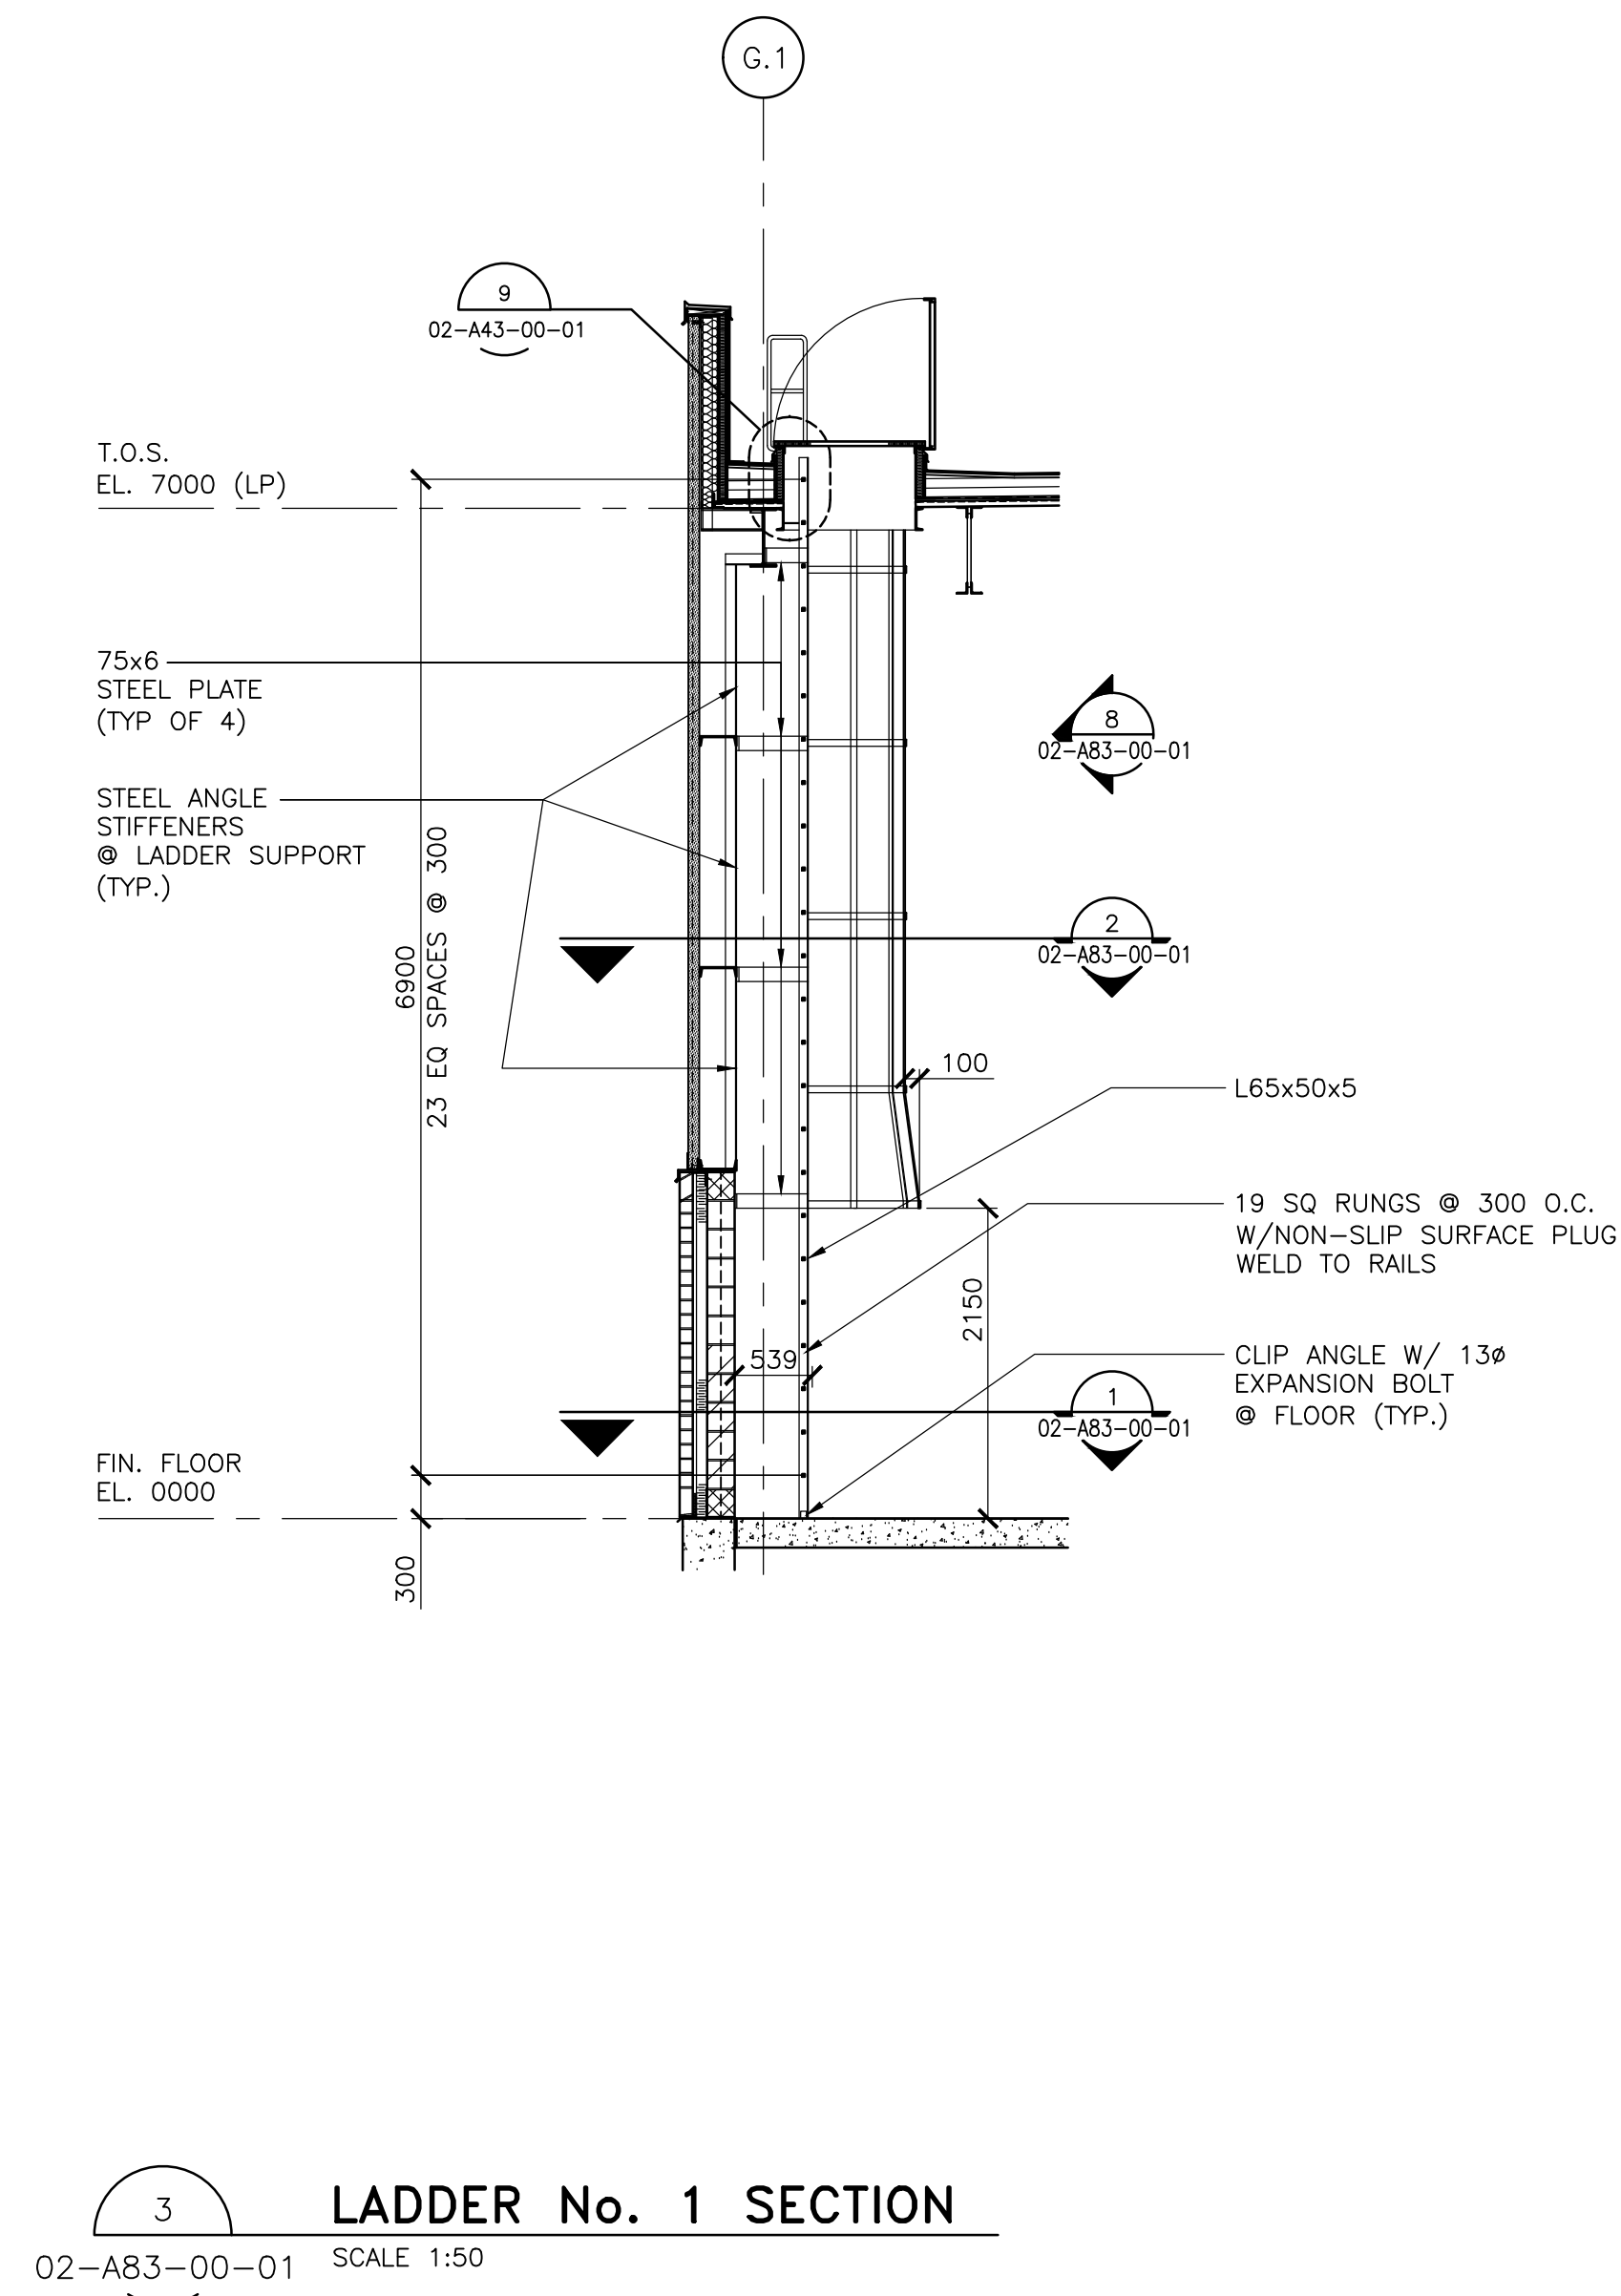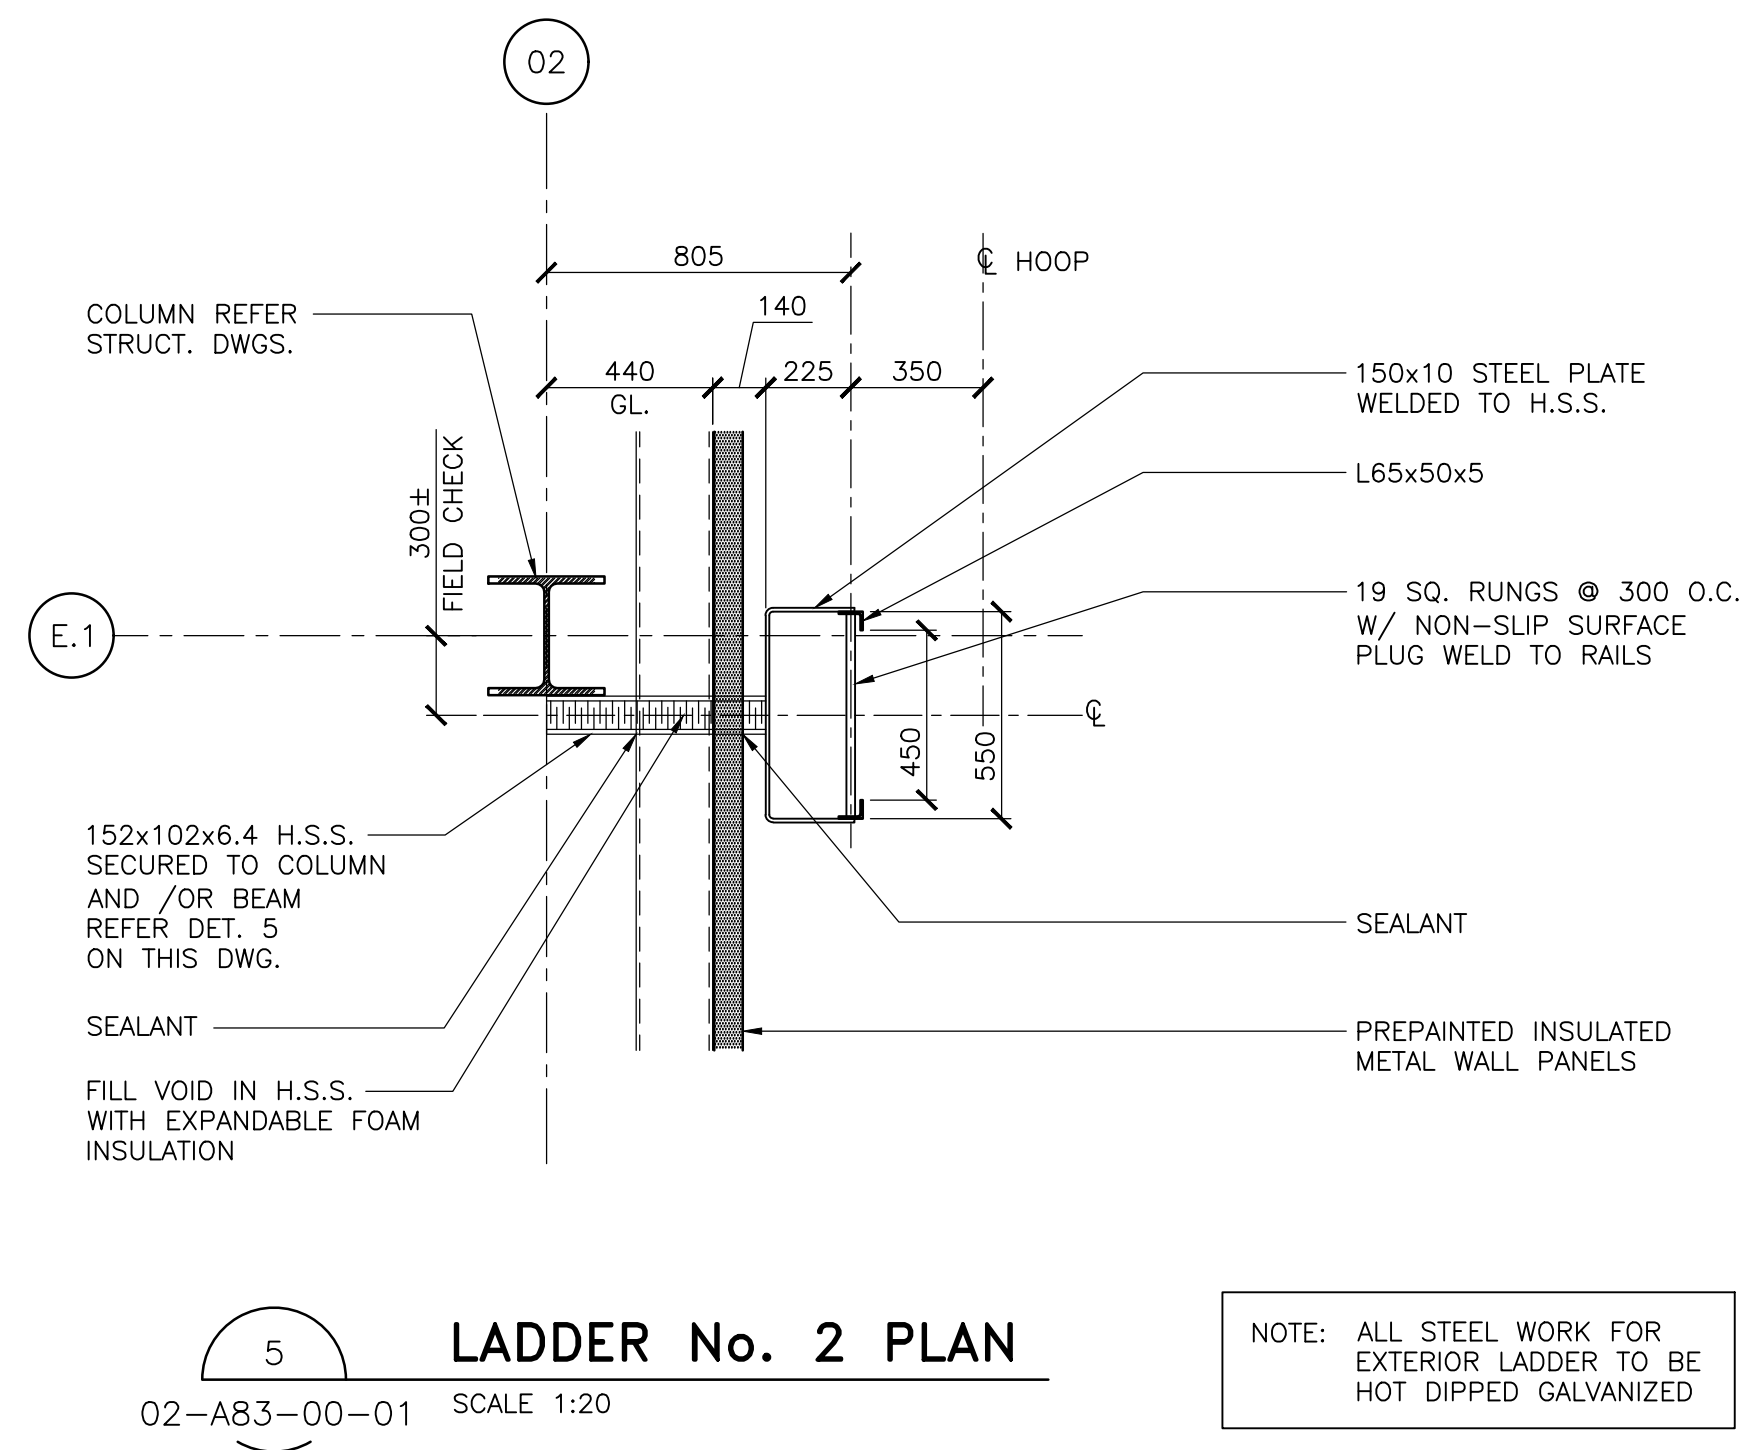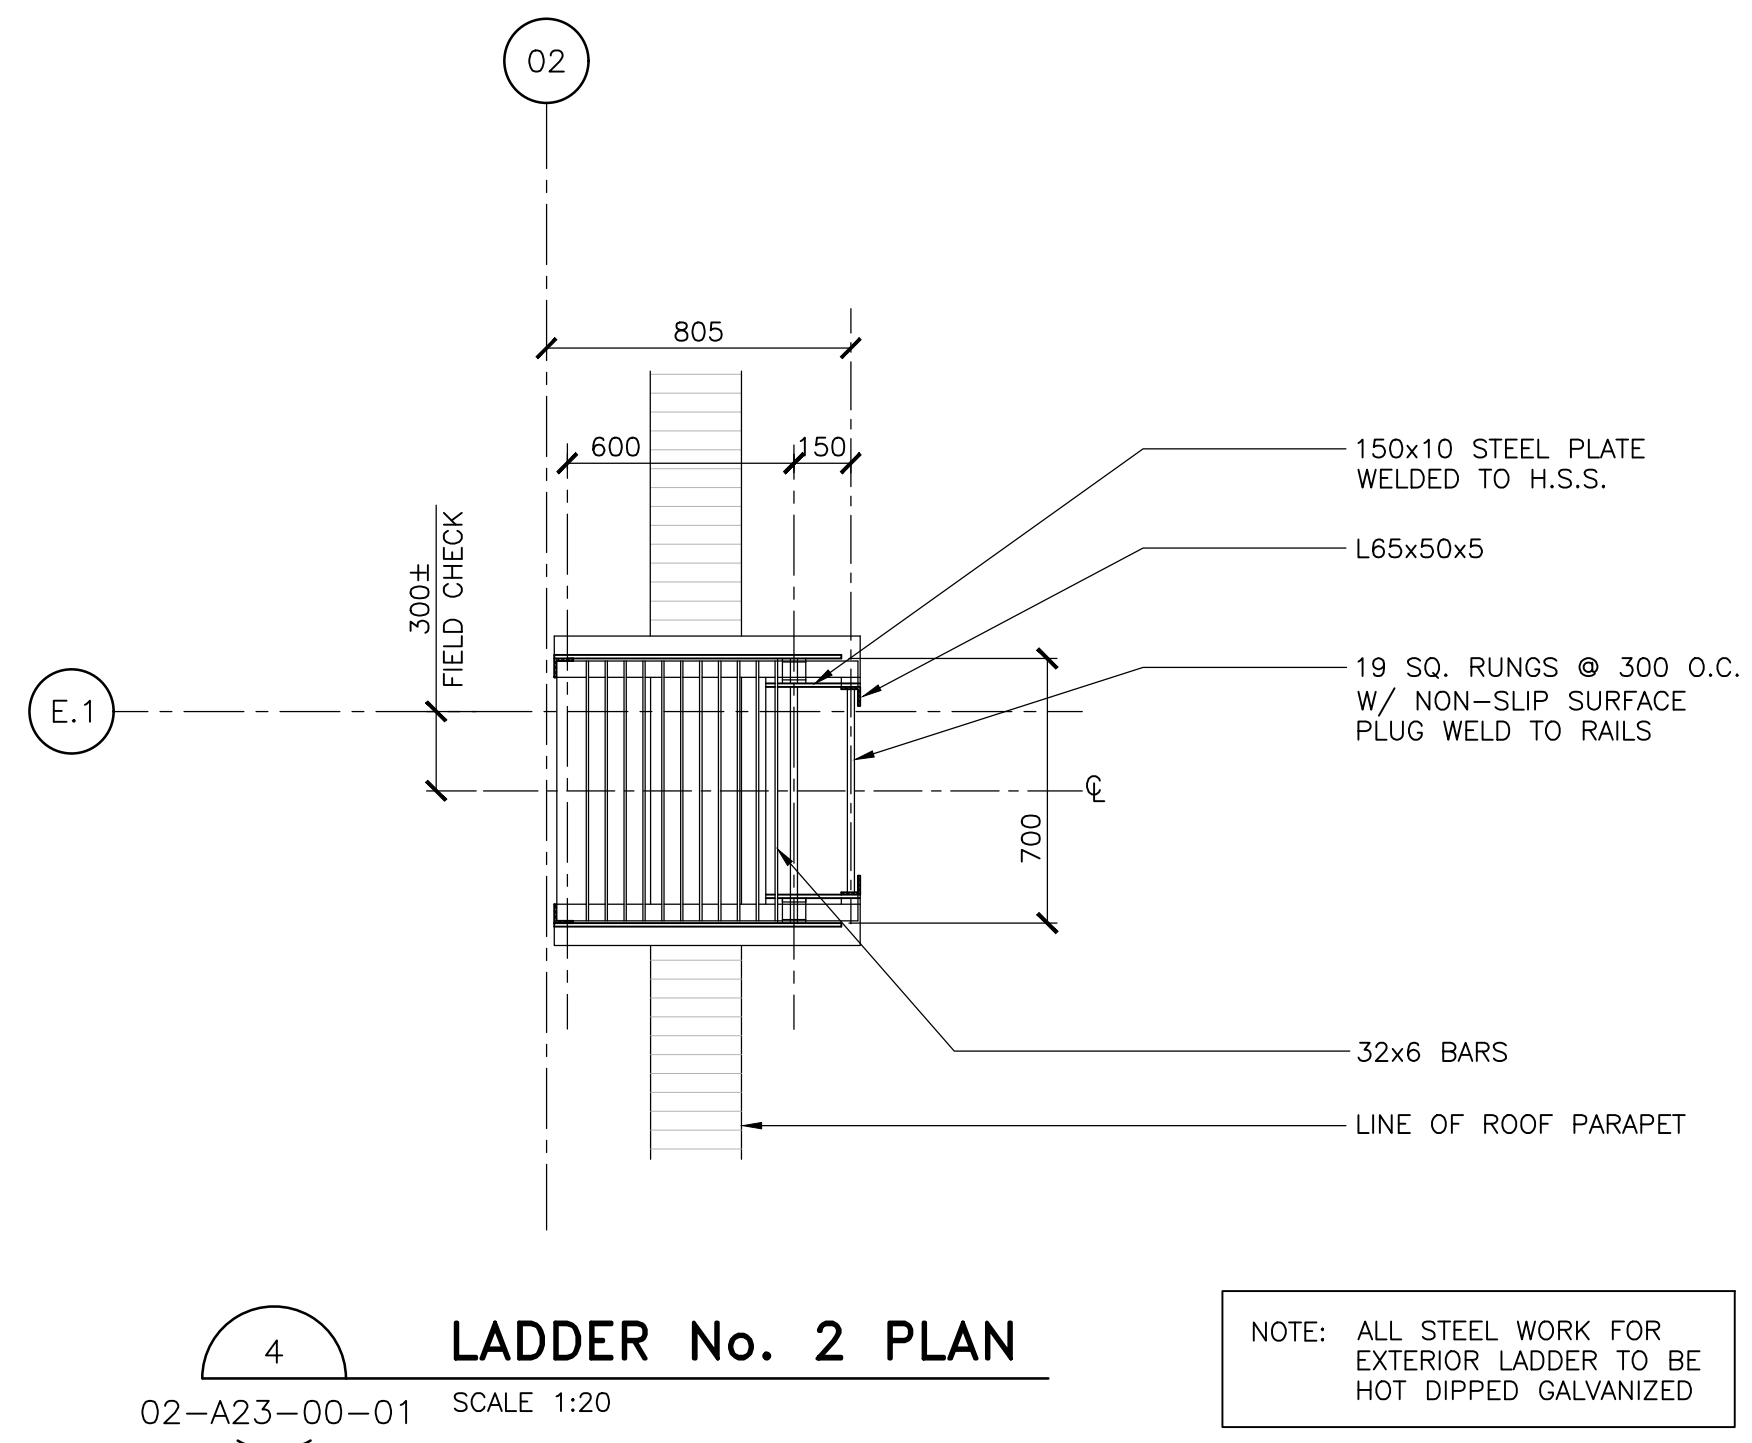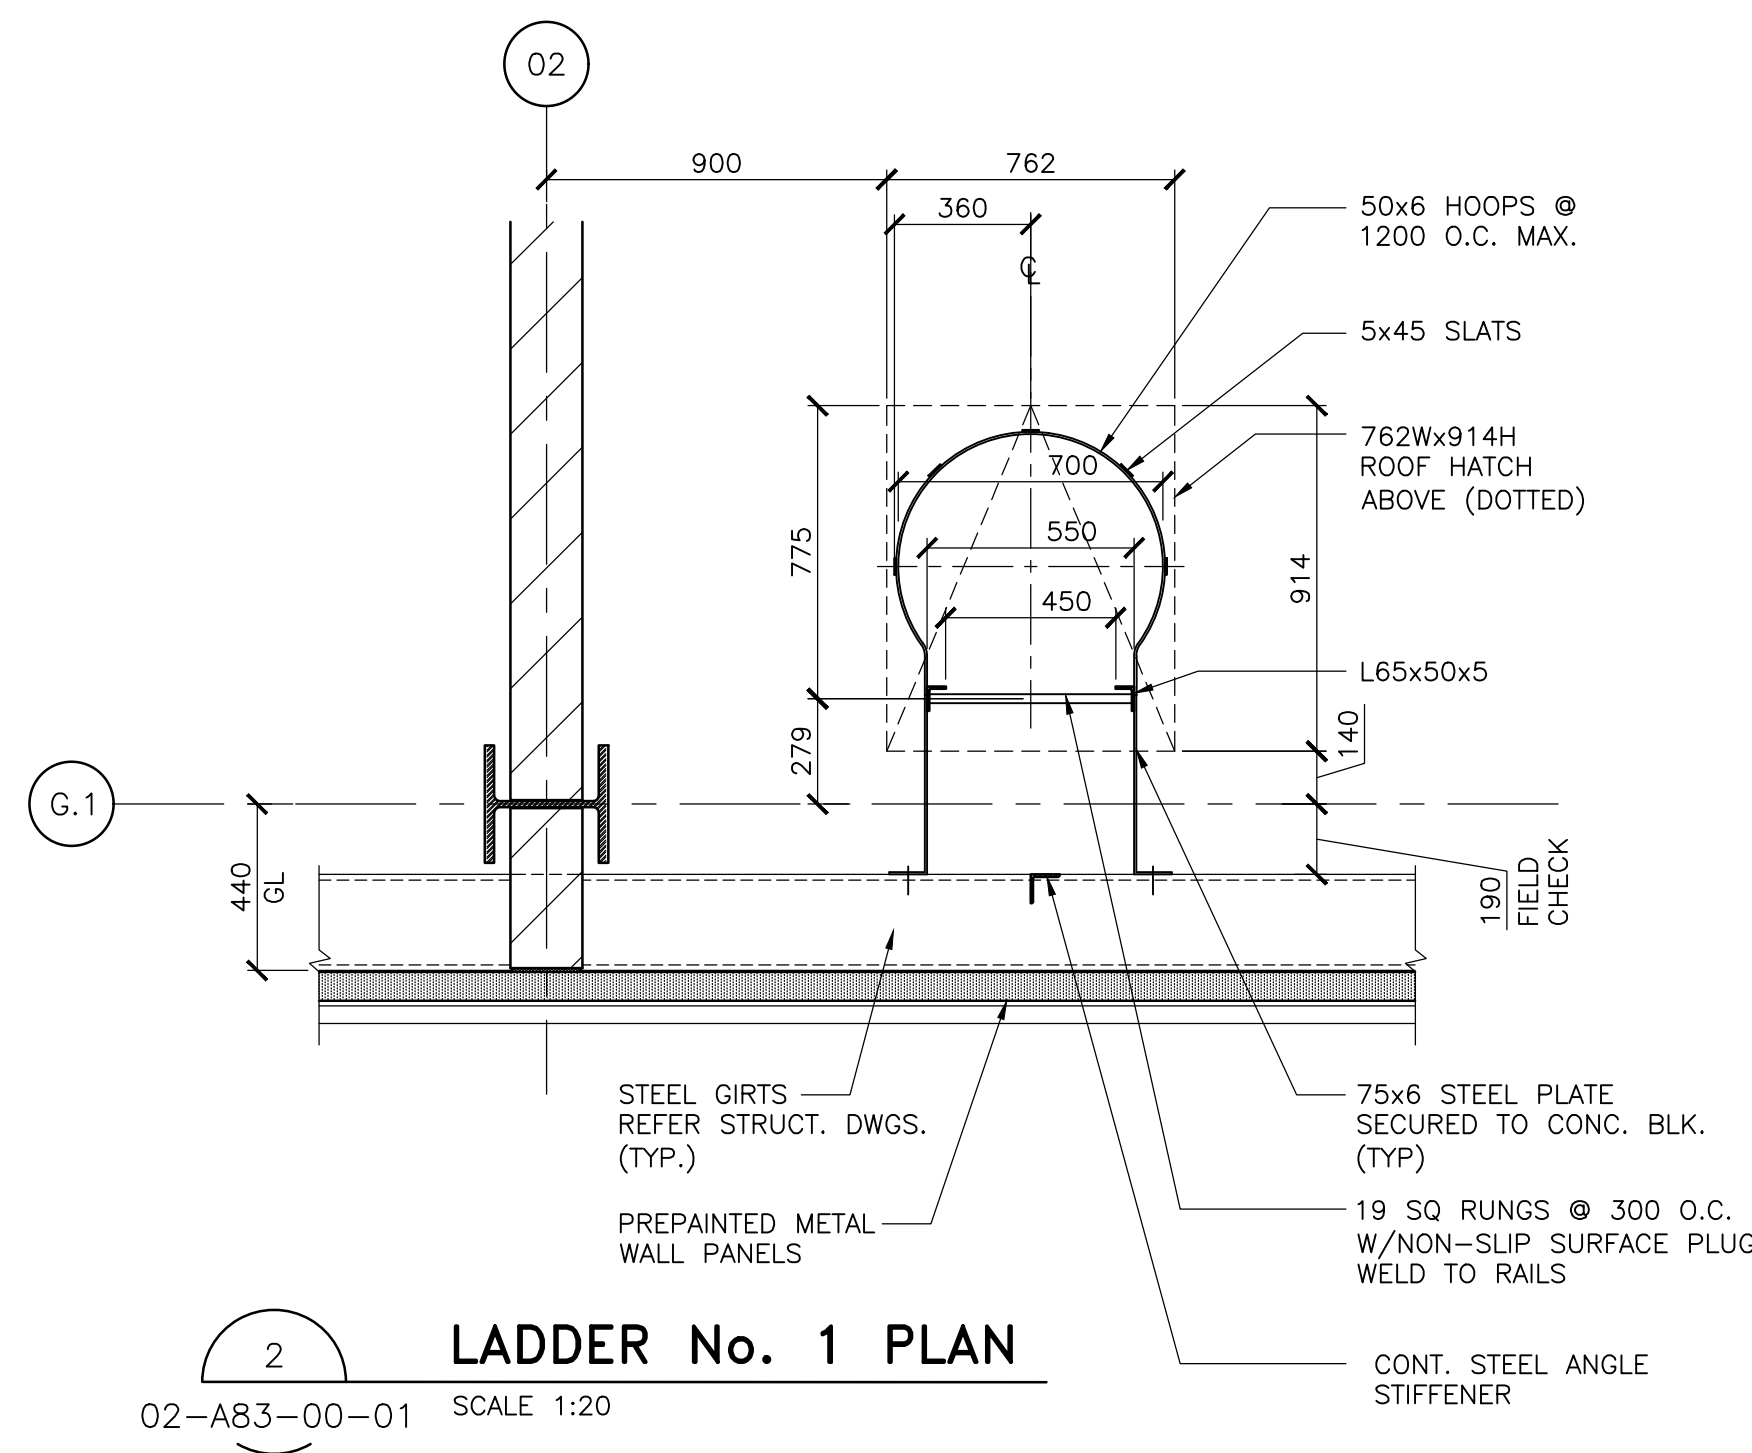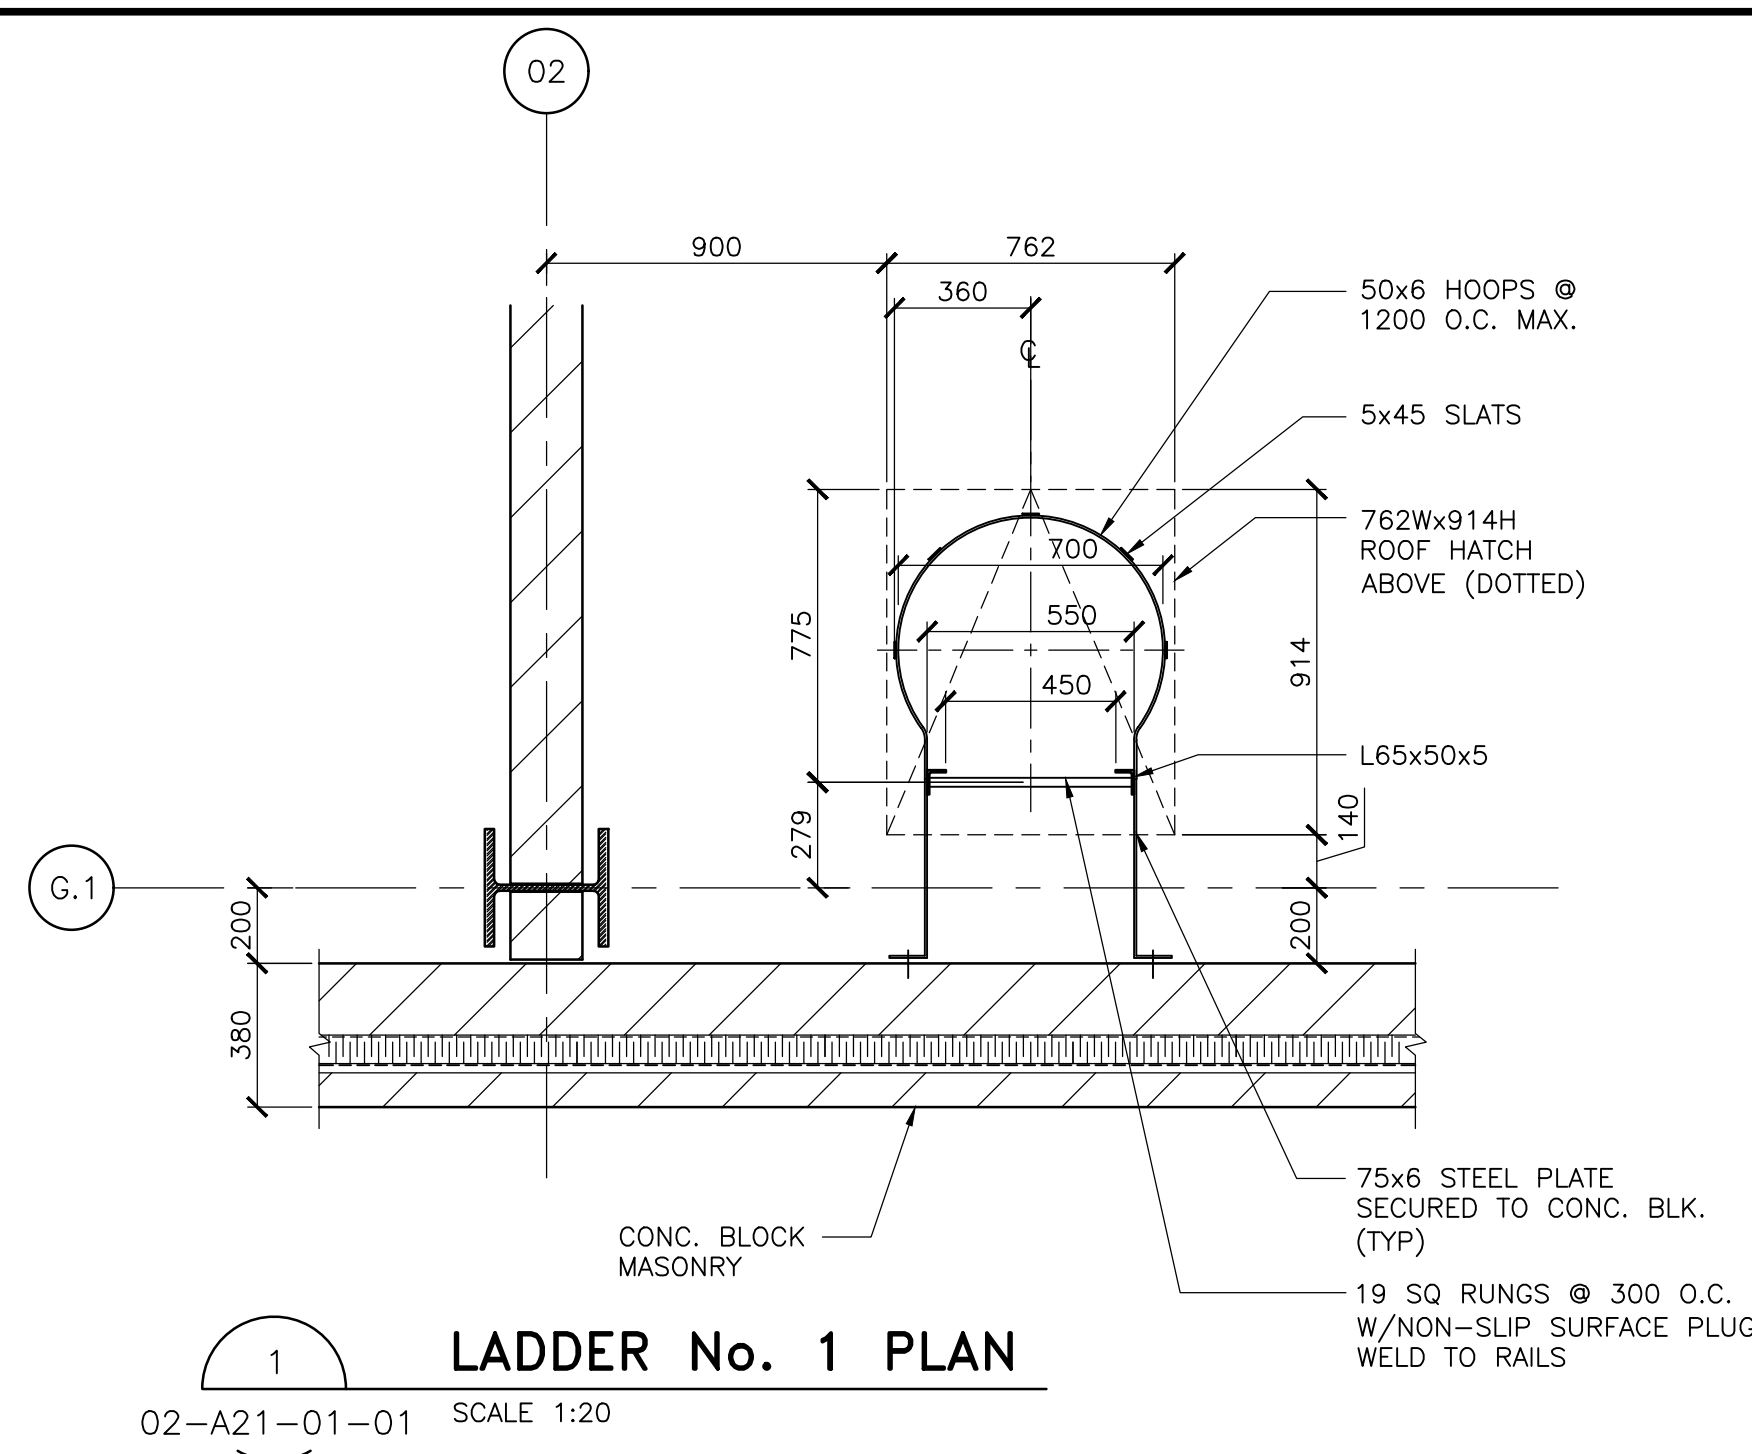

DATE (mm dd yyyy)	ISSUED FOR	REV
OCT 01 2018	TENDER	0

KEY PLAN

CONSULTANTS

IBI GROUP
100-175 Galaxy Boulevard Toronto ON M9W 0C9 Canada tel 416 679 1930 fax 416 675 4620 ibi@ibi.com

North Arrow	Detail Symbol

Project Manager	Architect/Engineer
A. VAN VEEN	A.V.V. / S.K.
Project Leader	Drawn
R.K. / R.F.	D.V.
Date	Checked
JUL 2012	L. BANDIERA
Client	

THE REGIONAL MUNICIPALITY OF DURHAM
WORKS DEPARTMENT ONTARIO

Project
EXPAND GARAGE SCUGOG DEPOT 10 REGIONAL RD. 21, R.R.#14, PORT PERRY

Drawing Title
LADDER DETAILS

Check Scale (may be photo-reduced)
0 1 inch 10mm

Project No.	Drawing No.
24RX12.0113	02-A83-00-01

ROD Contract No.
T-1038-2019

[illegible][illegible]

Technical drawings of three door types:

- TYPE 'A'**: A side elevation of a door with a louvre. A dashed line indicates the louvre's position. A label points to the louvre with the text "LOUVRE SEE SCHEDULE".
- TYPE 'B'**: A side elevation of a door with a louvre. Dimensions are provided: 150 for the top section, 150 for the louvre height, 200 for the distance from the top to the louvre, 1050 for the door height, and 900 for the distance from the bottom to the door. A dashed line indicates the louvre's position.
- TYPE 'E'**: A full view of a double-glazed vision panel. It shows a grid of 12 rectangular panels arranged in 2 rows and 6 columns. A label points to the grid with the text "FULL VIEW DOUBLE-GLAZED VISION PANEL". Above the grid, a label points to the top section with the text "INSULATED METAL SECTIONAL OVERHEAD DOOR".

1. PAINT ALL EXPOSED STEEL WORK INCLUDING GIRTS, SAG RODS AND CROSS BRACING.
2. PAINT ALL EXPOSED CONCRETE BLOCK PARTITIONS.
3. PAINT ALL EXPOSED GYPSUM BOARD PARTITIONS.
4. WHERE NO BASE IS APPLIED PAINT ALL WALLS DOWN TO FLOOR LINE & CUT STRAIGHT LINE @ TRANSITION.
5. ROOF LADDER TO BE PAINTED.
6. PAINT EXTERIOR ROOF HATCH.
7. REFER CONC. FLOOR SLAB DWGS AND CONC. SPECIFICATIONS FOR ADDITIONAL FLOOR FINISHES.
8. OUTSIDE FACE OF EXIST. WEST WALL, COLUMN LINE 1, TO RECEIVE NEW PAINT FINISH. CLEAN, REPAIR, PATCH & COVER ALL HOLES AND MAKE GOOD TO MEET PAINT COORDINATORS RECOMMENDATIONS. REFER SPECIFICATIONS FOR ADDITIONAL NOTES.
9. PAINT ALL EXPOSED METAL DECK, AND SUPPORTING STRUCTURE.

ALL DETAILS ARE LOCATED ON
DRAWING 02-A45-00-01
UNLESS NOTED OTHERWISE.

GENERAL DOOR NOTES:

1. CONTROL PANEL W/ PUSH BUTTON CONTROL INTERIOR SIDE ONLY.
2. ACTIVATED BY CARD READER.
3. EDS DENOTES ELECTRIC DOOR STRIKE.
4. HARDWARE GROUP REFER SPECIFICATIONS
5. EXISTING SECTIONAL DOORS MANUAL OPERATION. PROVIDE MOTOR CONTROL WITH PUSH BUTTON INTERIOR & SENSORS. FIELD CHECK MOTOR & PUSH BUTTON LOCATION
6. HM FRAME HEAD SHALL BE 100MM FIELD CHECK BEFORE FABRICATION. RE: SLOPE IN FINISH FLOOR