




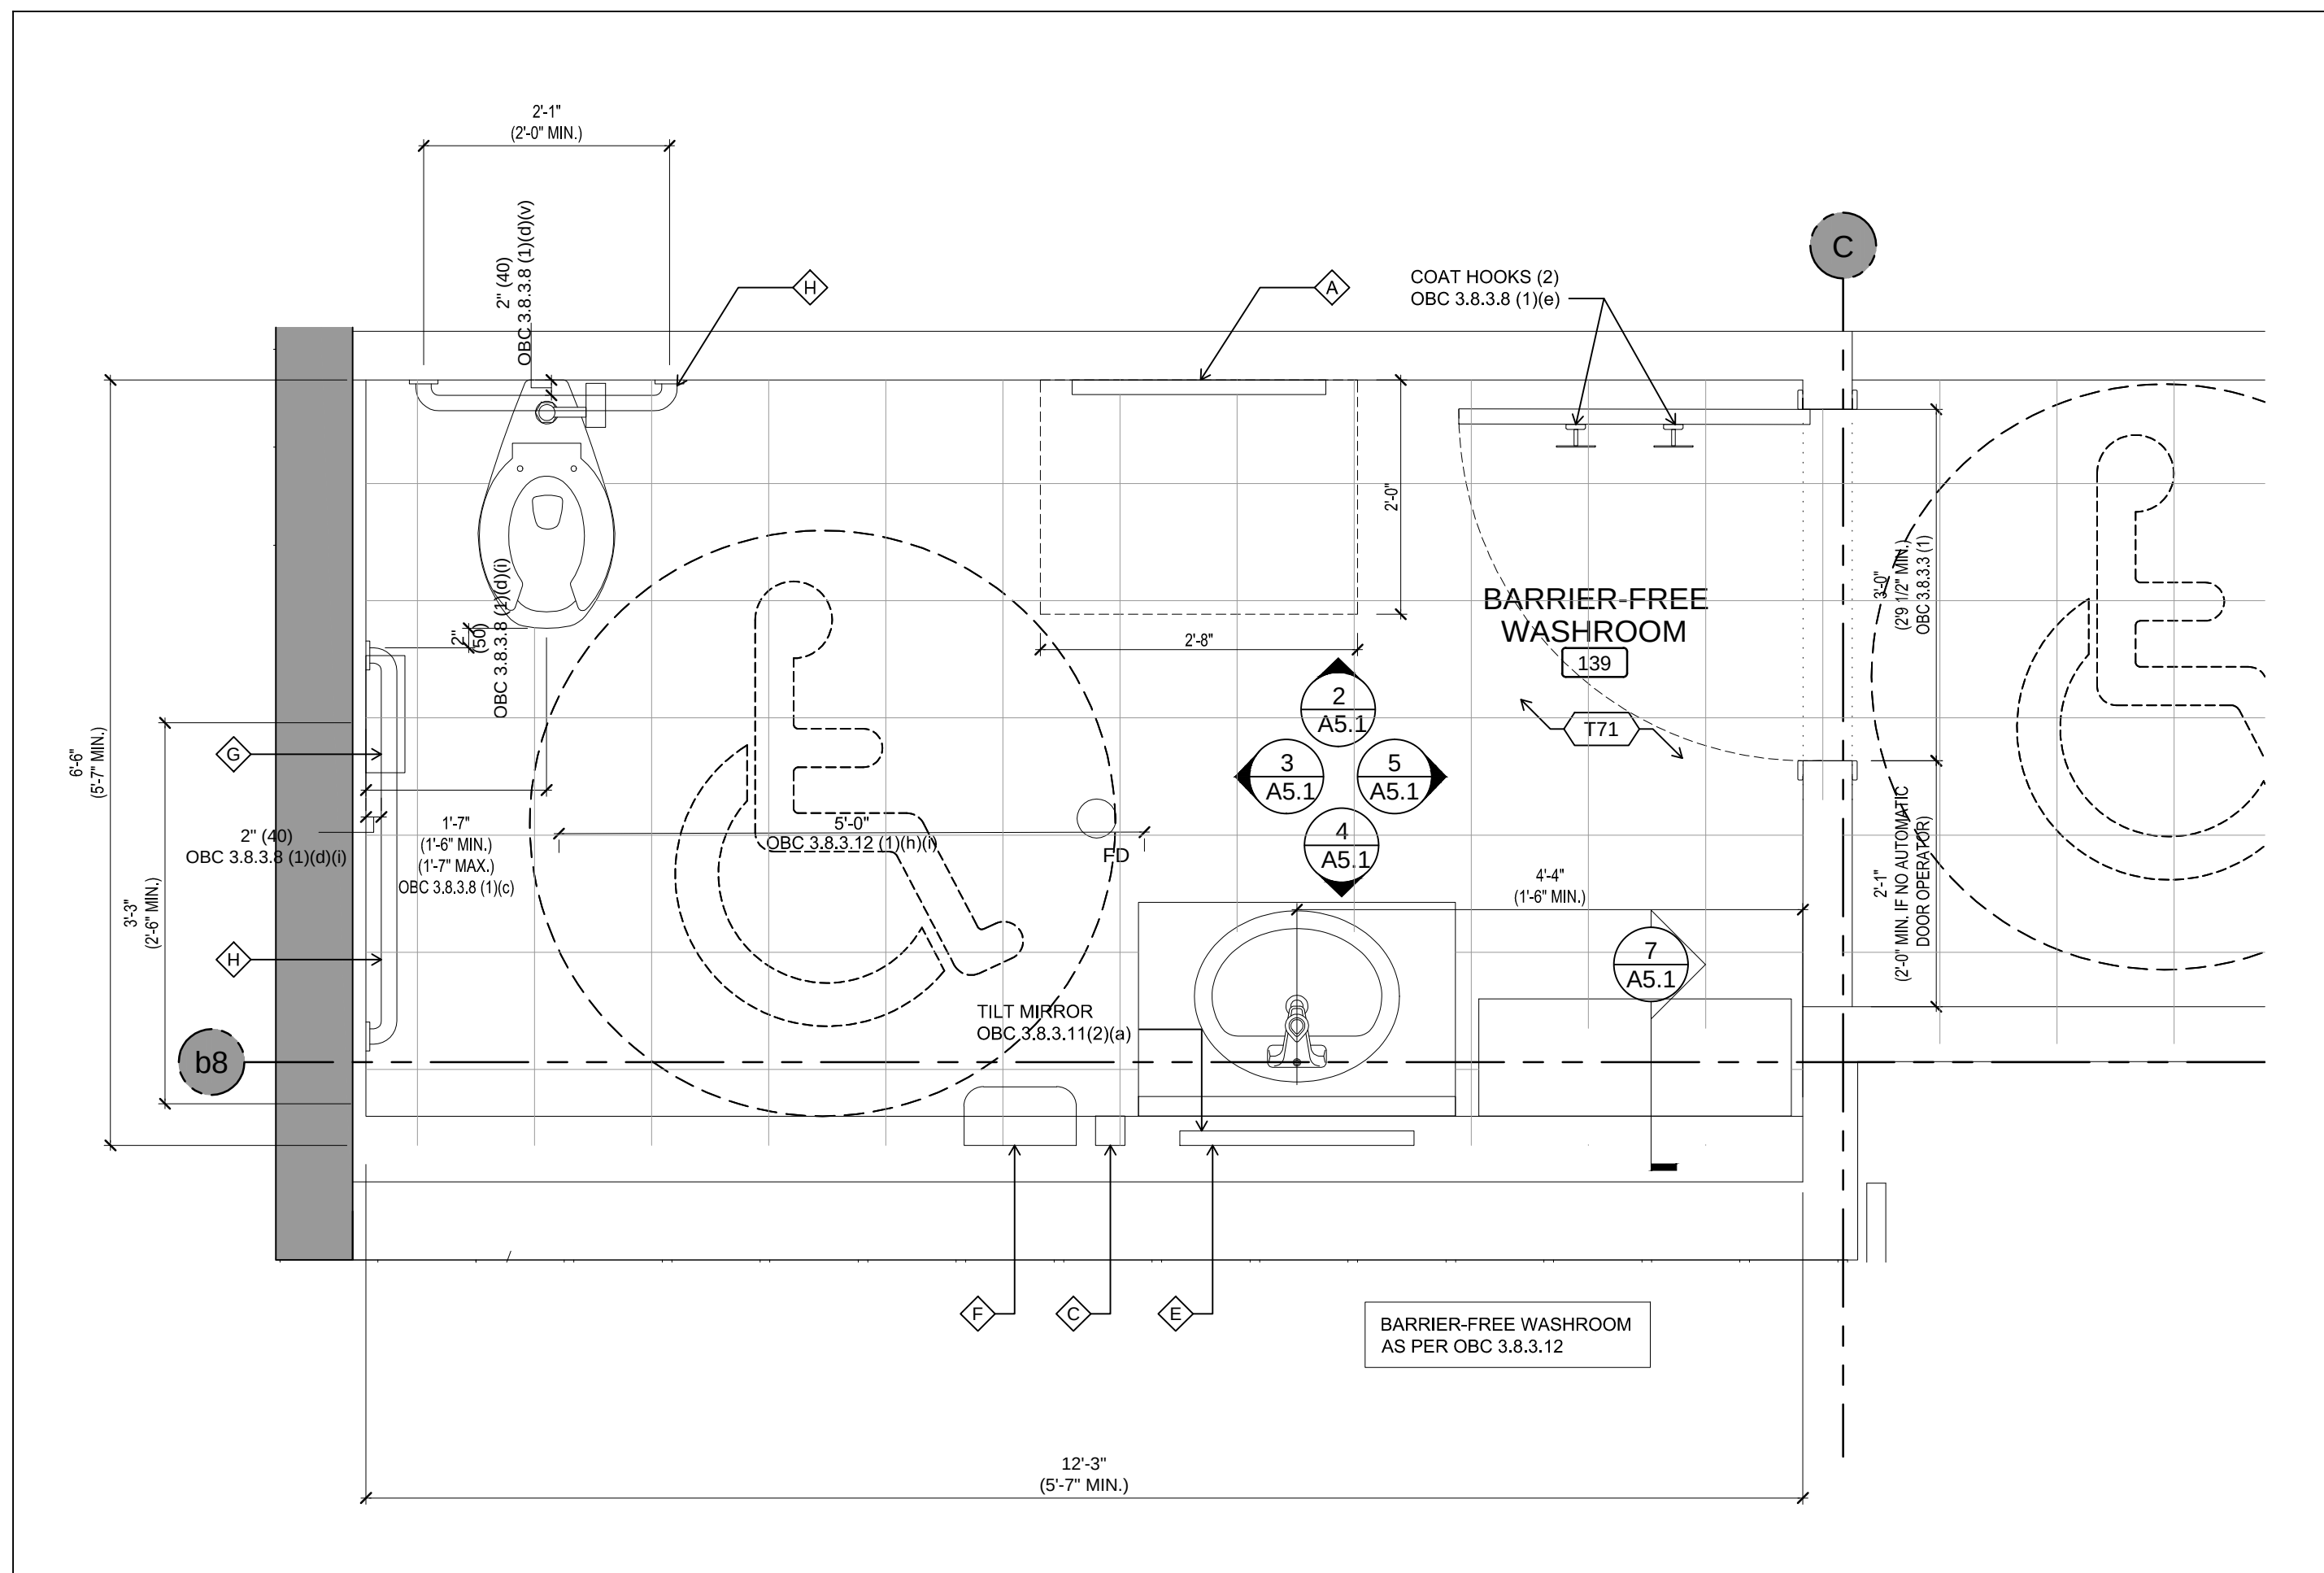


1 BARRIER-FREE WASHROOM
SCALE: 3/4"=1'-0"

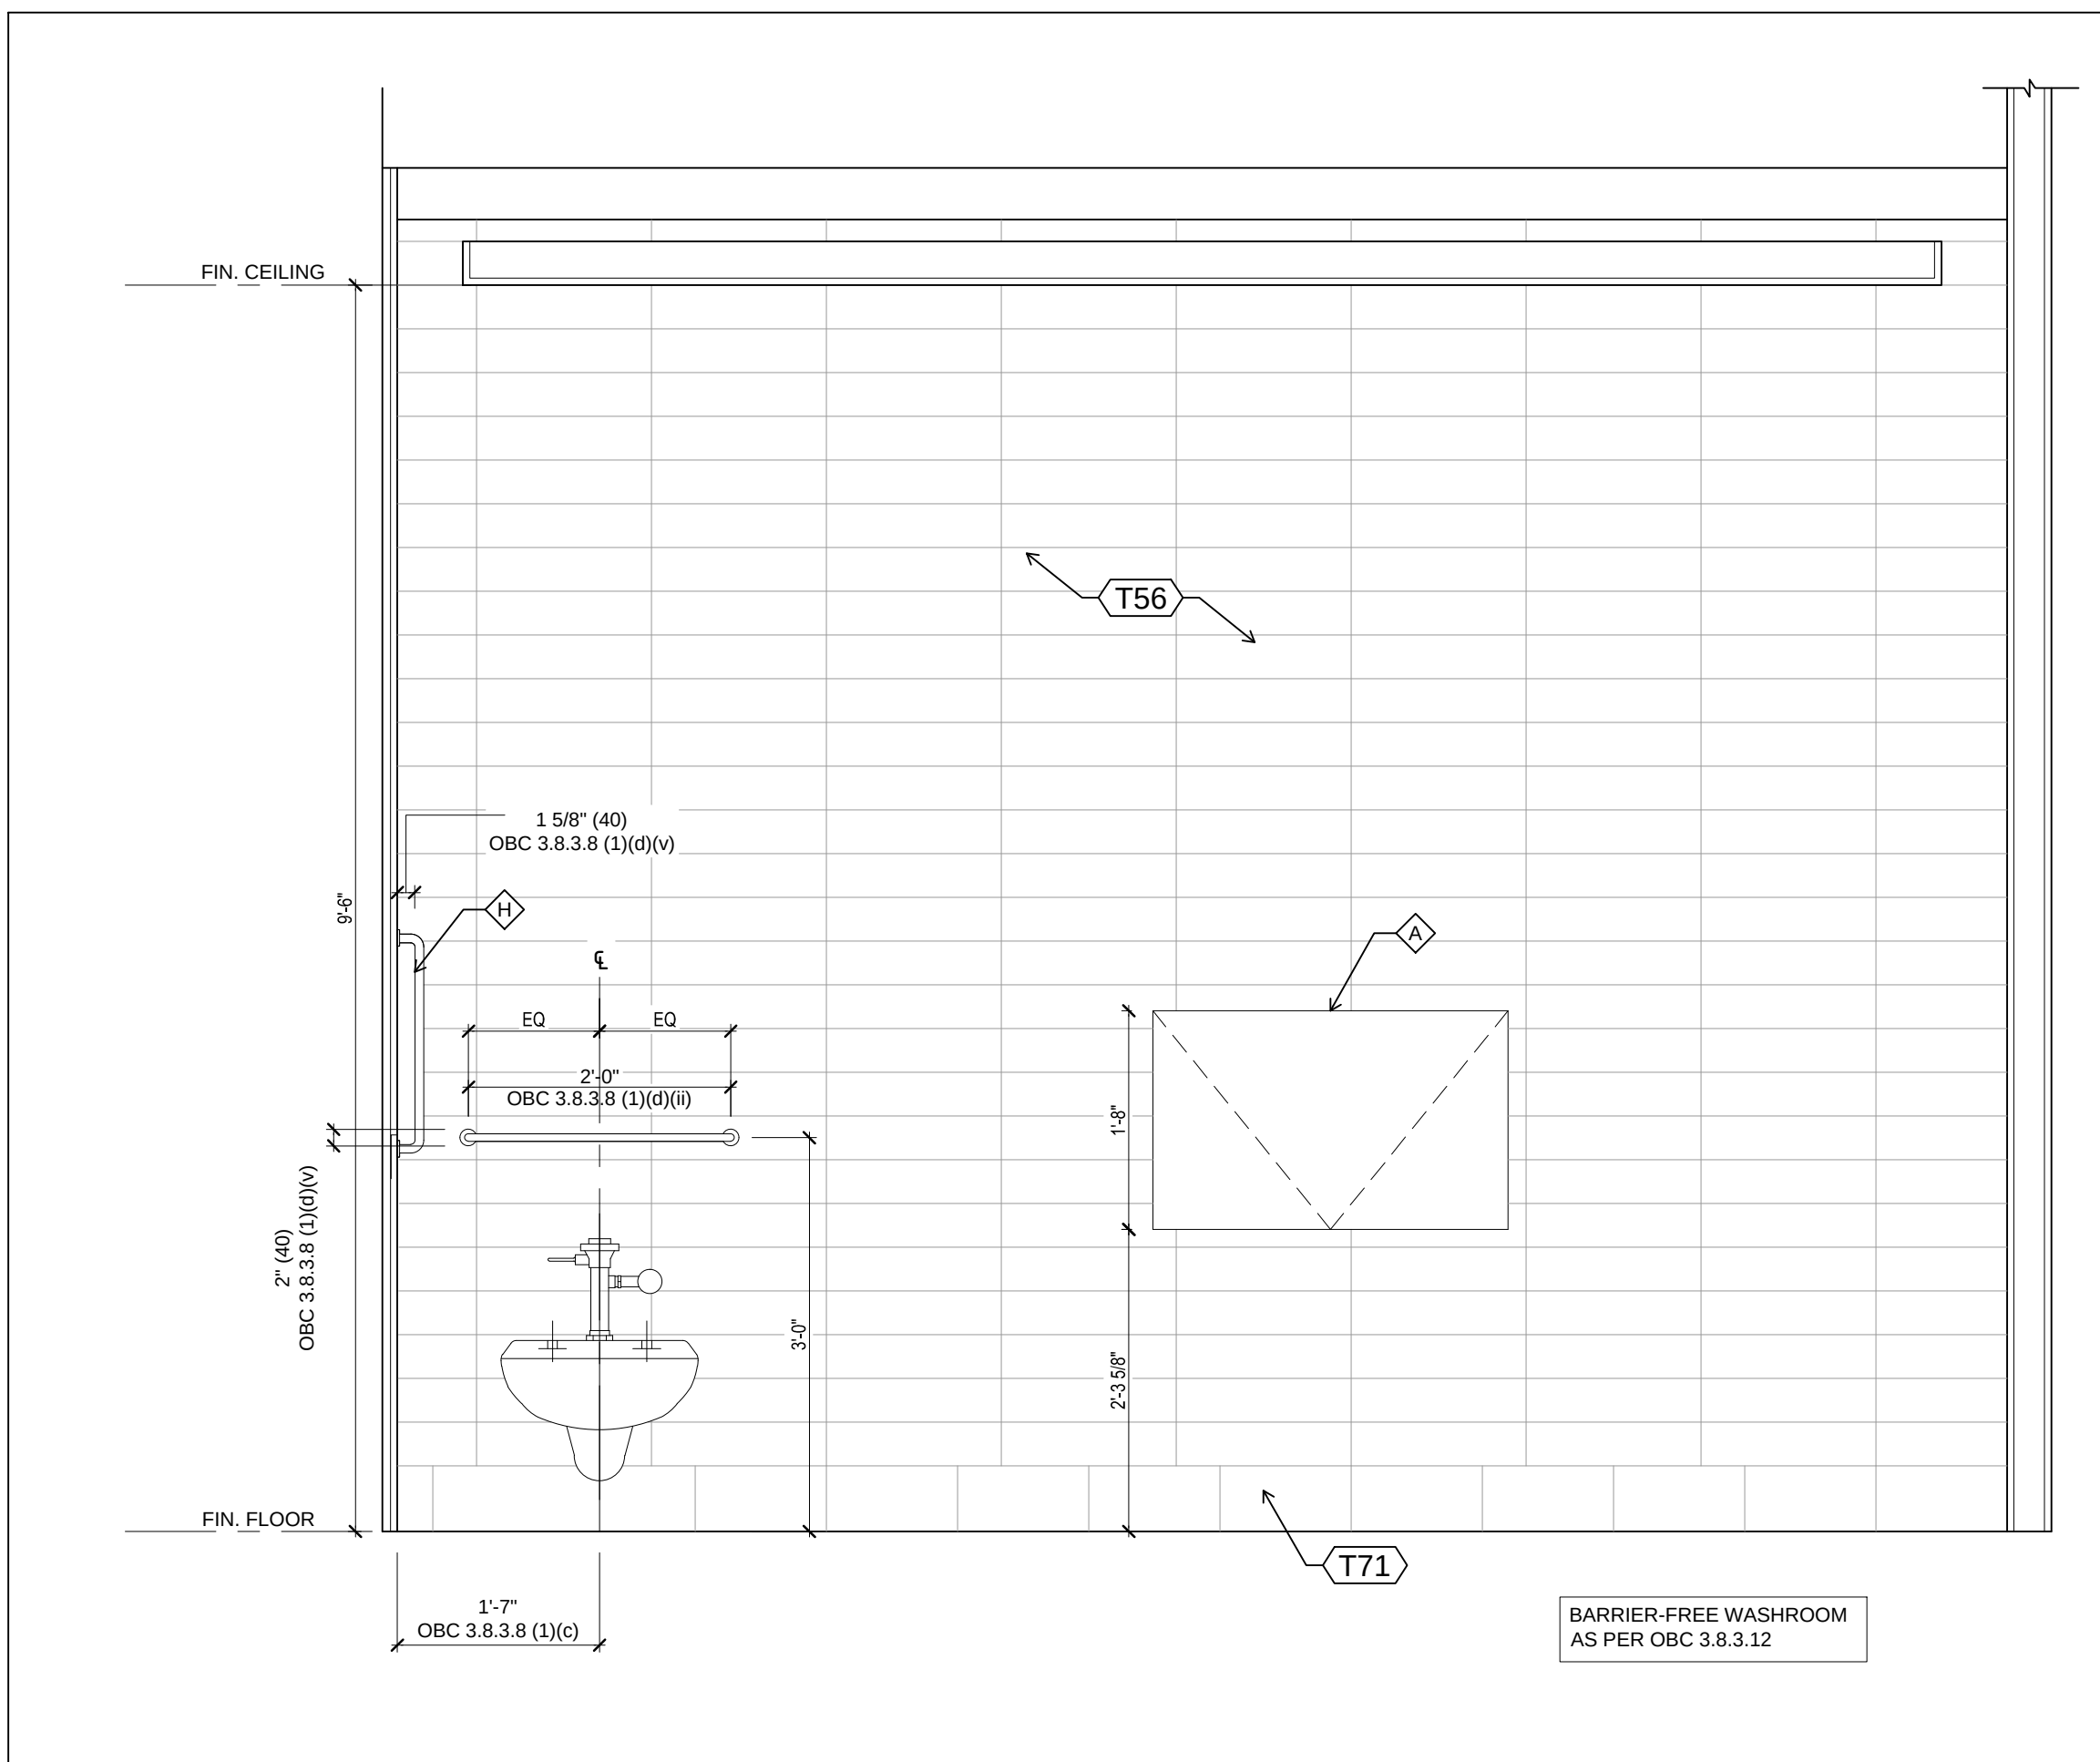


2 BARRIER-FREE WASHROOM - NORTH ELEVATION
SCALE: 3/4"=1'-0"

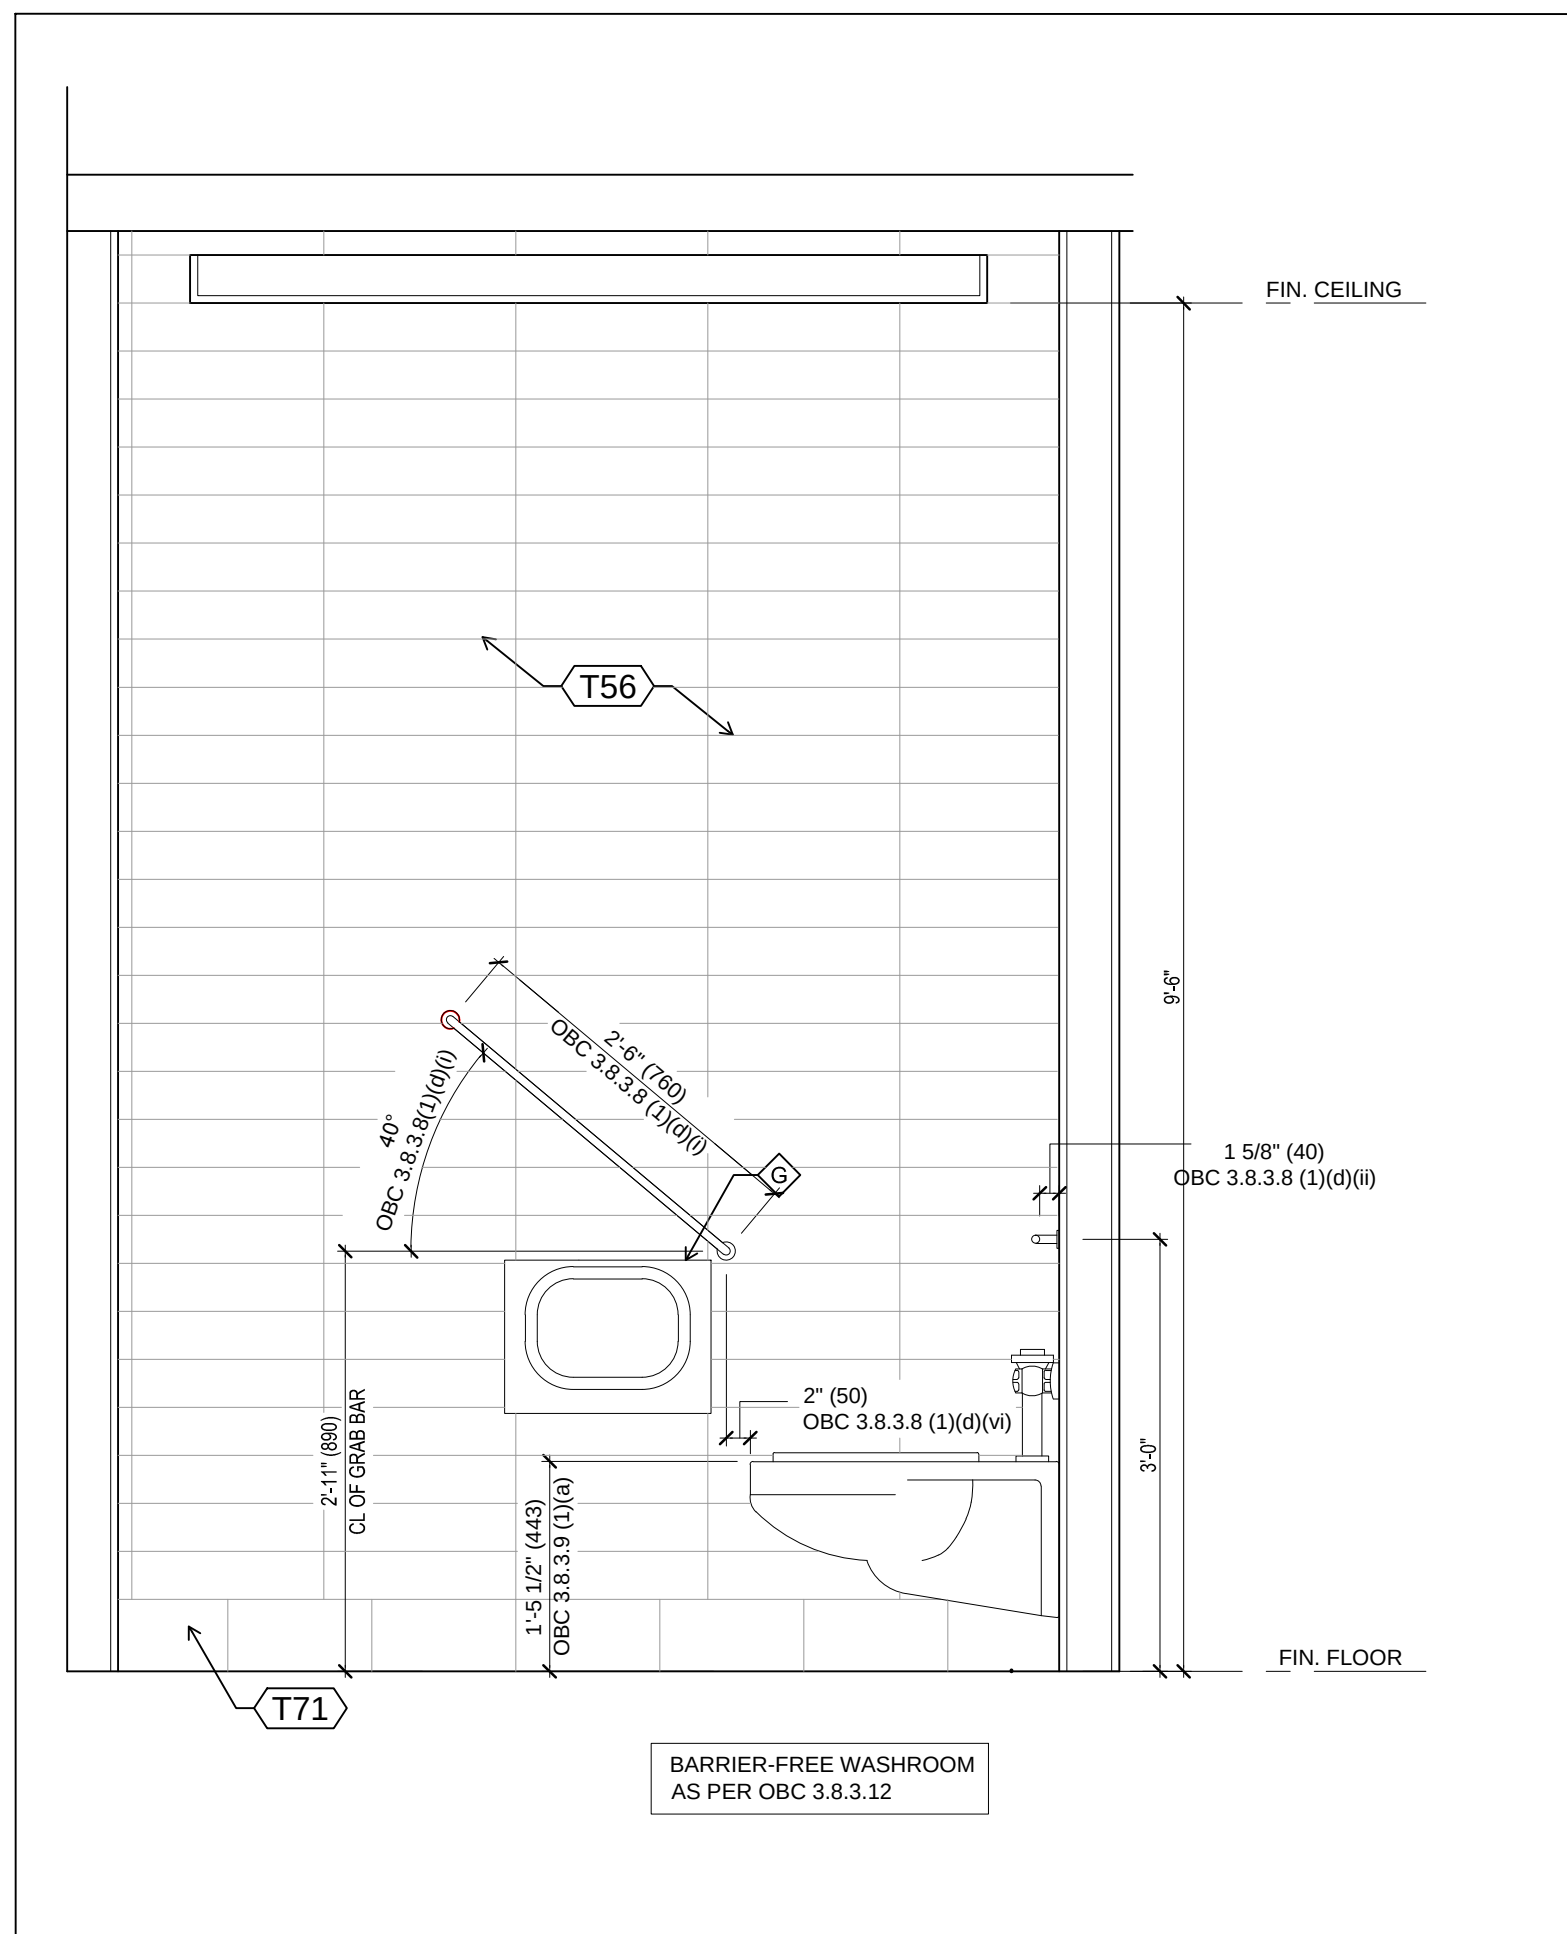


3 BARRIER-FREE WASHROOM - WEST ELEVATION
SCALE: 3/4"=1'-0"

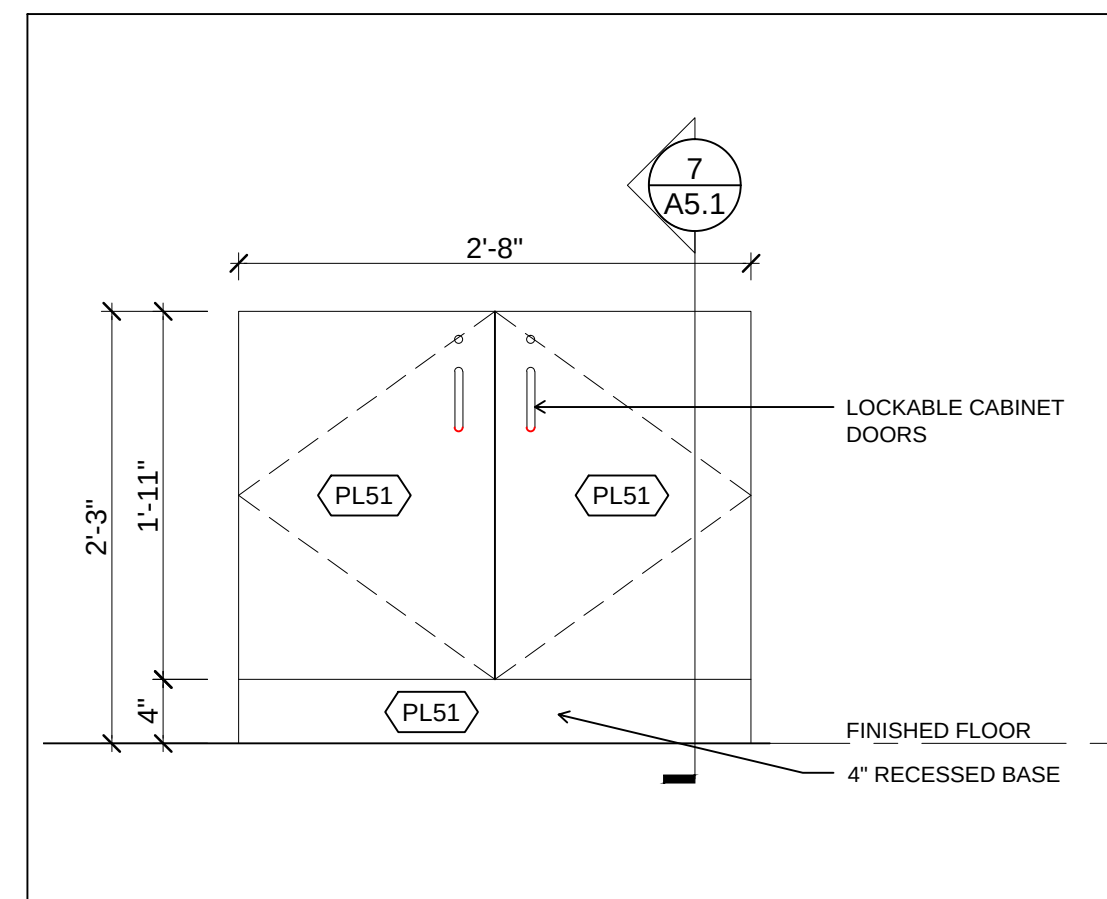


6 WASHROOM CABINET ELEVATION
SCALE: 1/2"=1'-0"

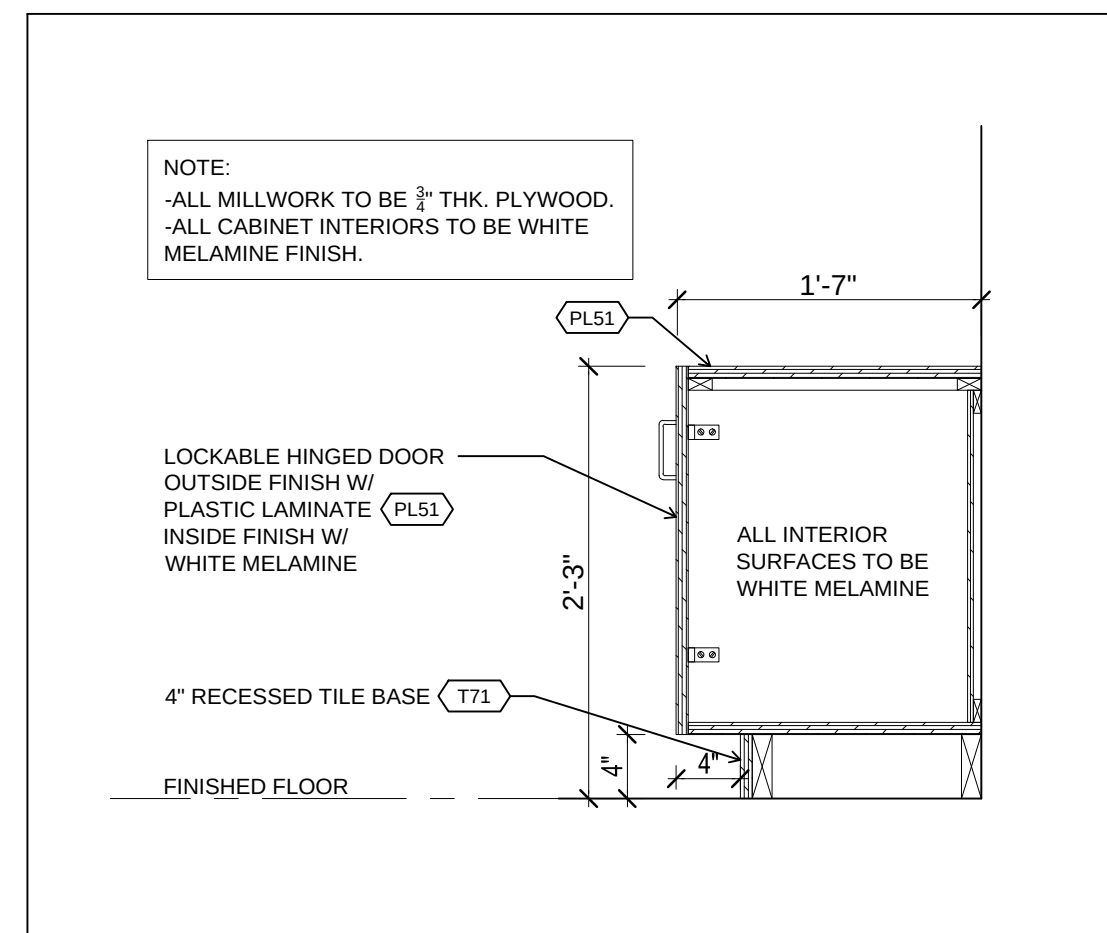


7 WASHROOM CABINET SECTION
SCALE: 1/2"=1'-0"

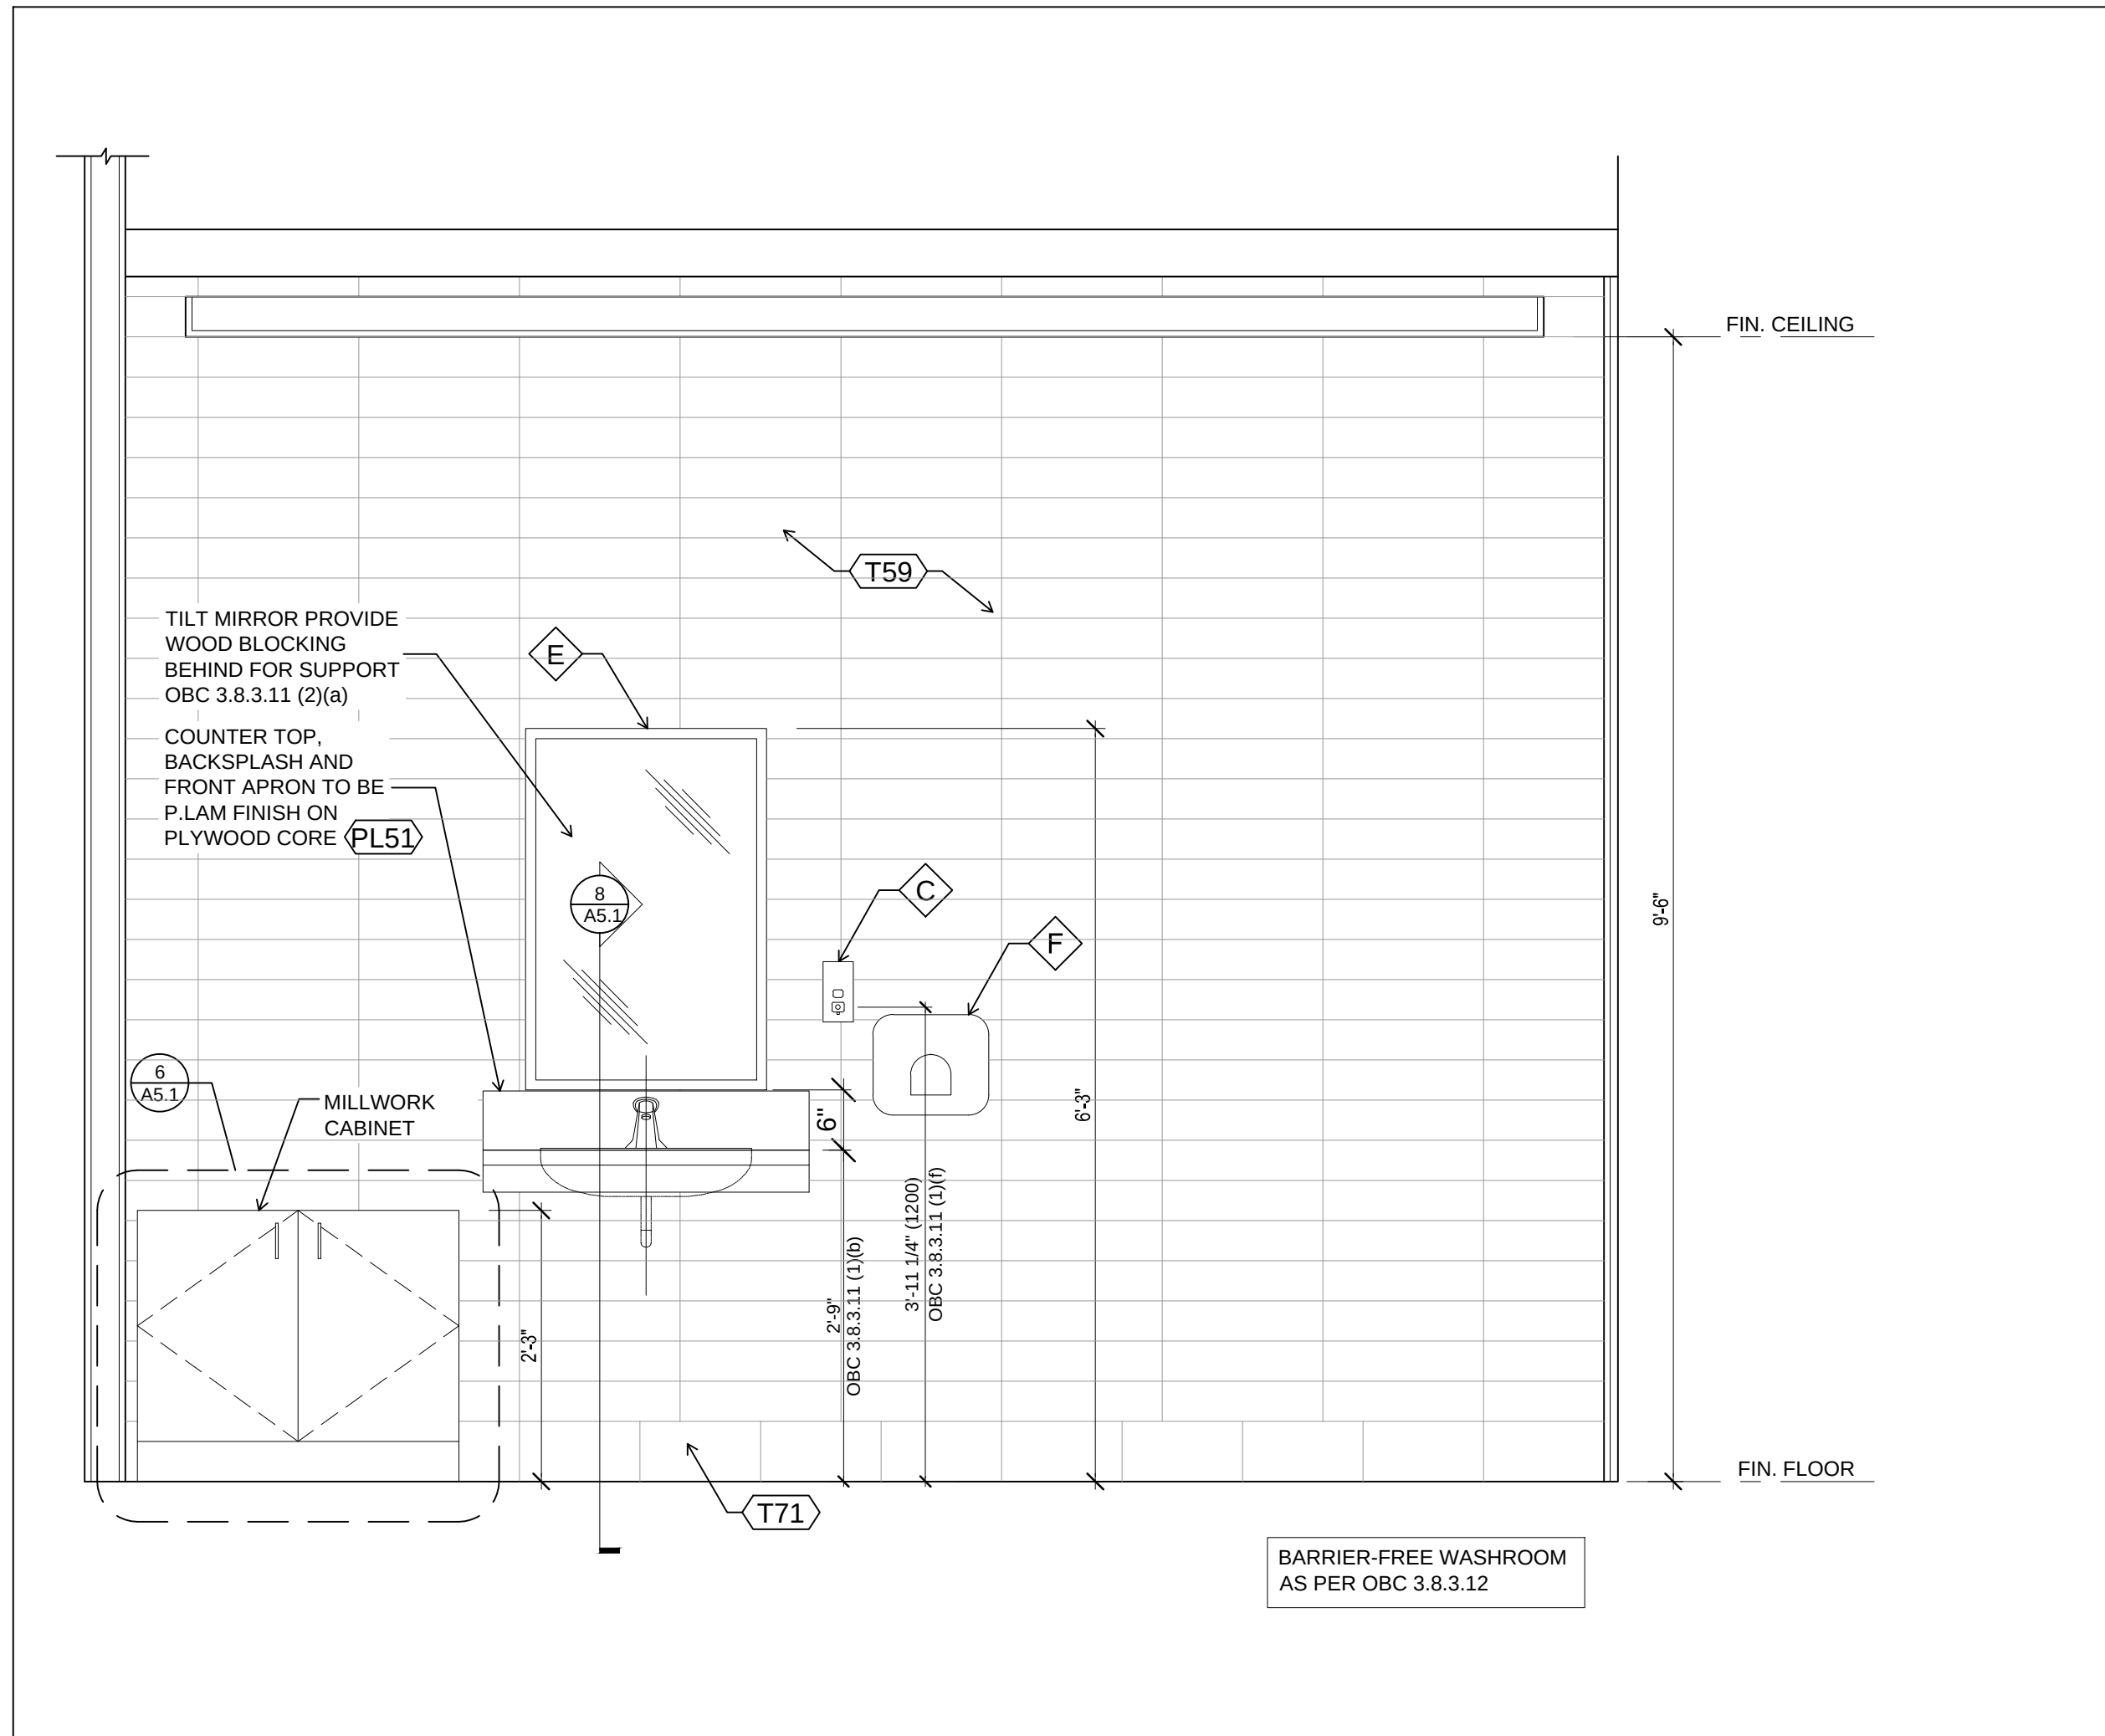

4 BARRIER-FREE WASHROOM - SOUTH ELEVATION
SCALE: 3/4"=1'-0"

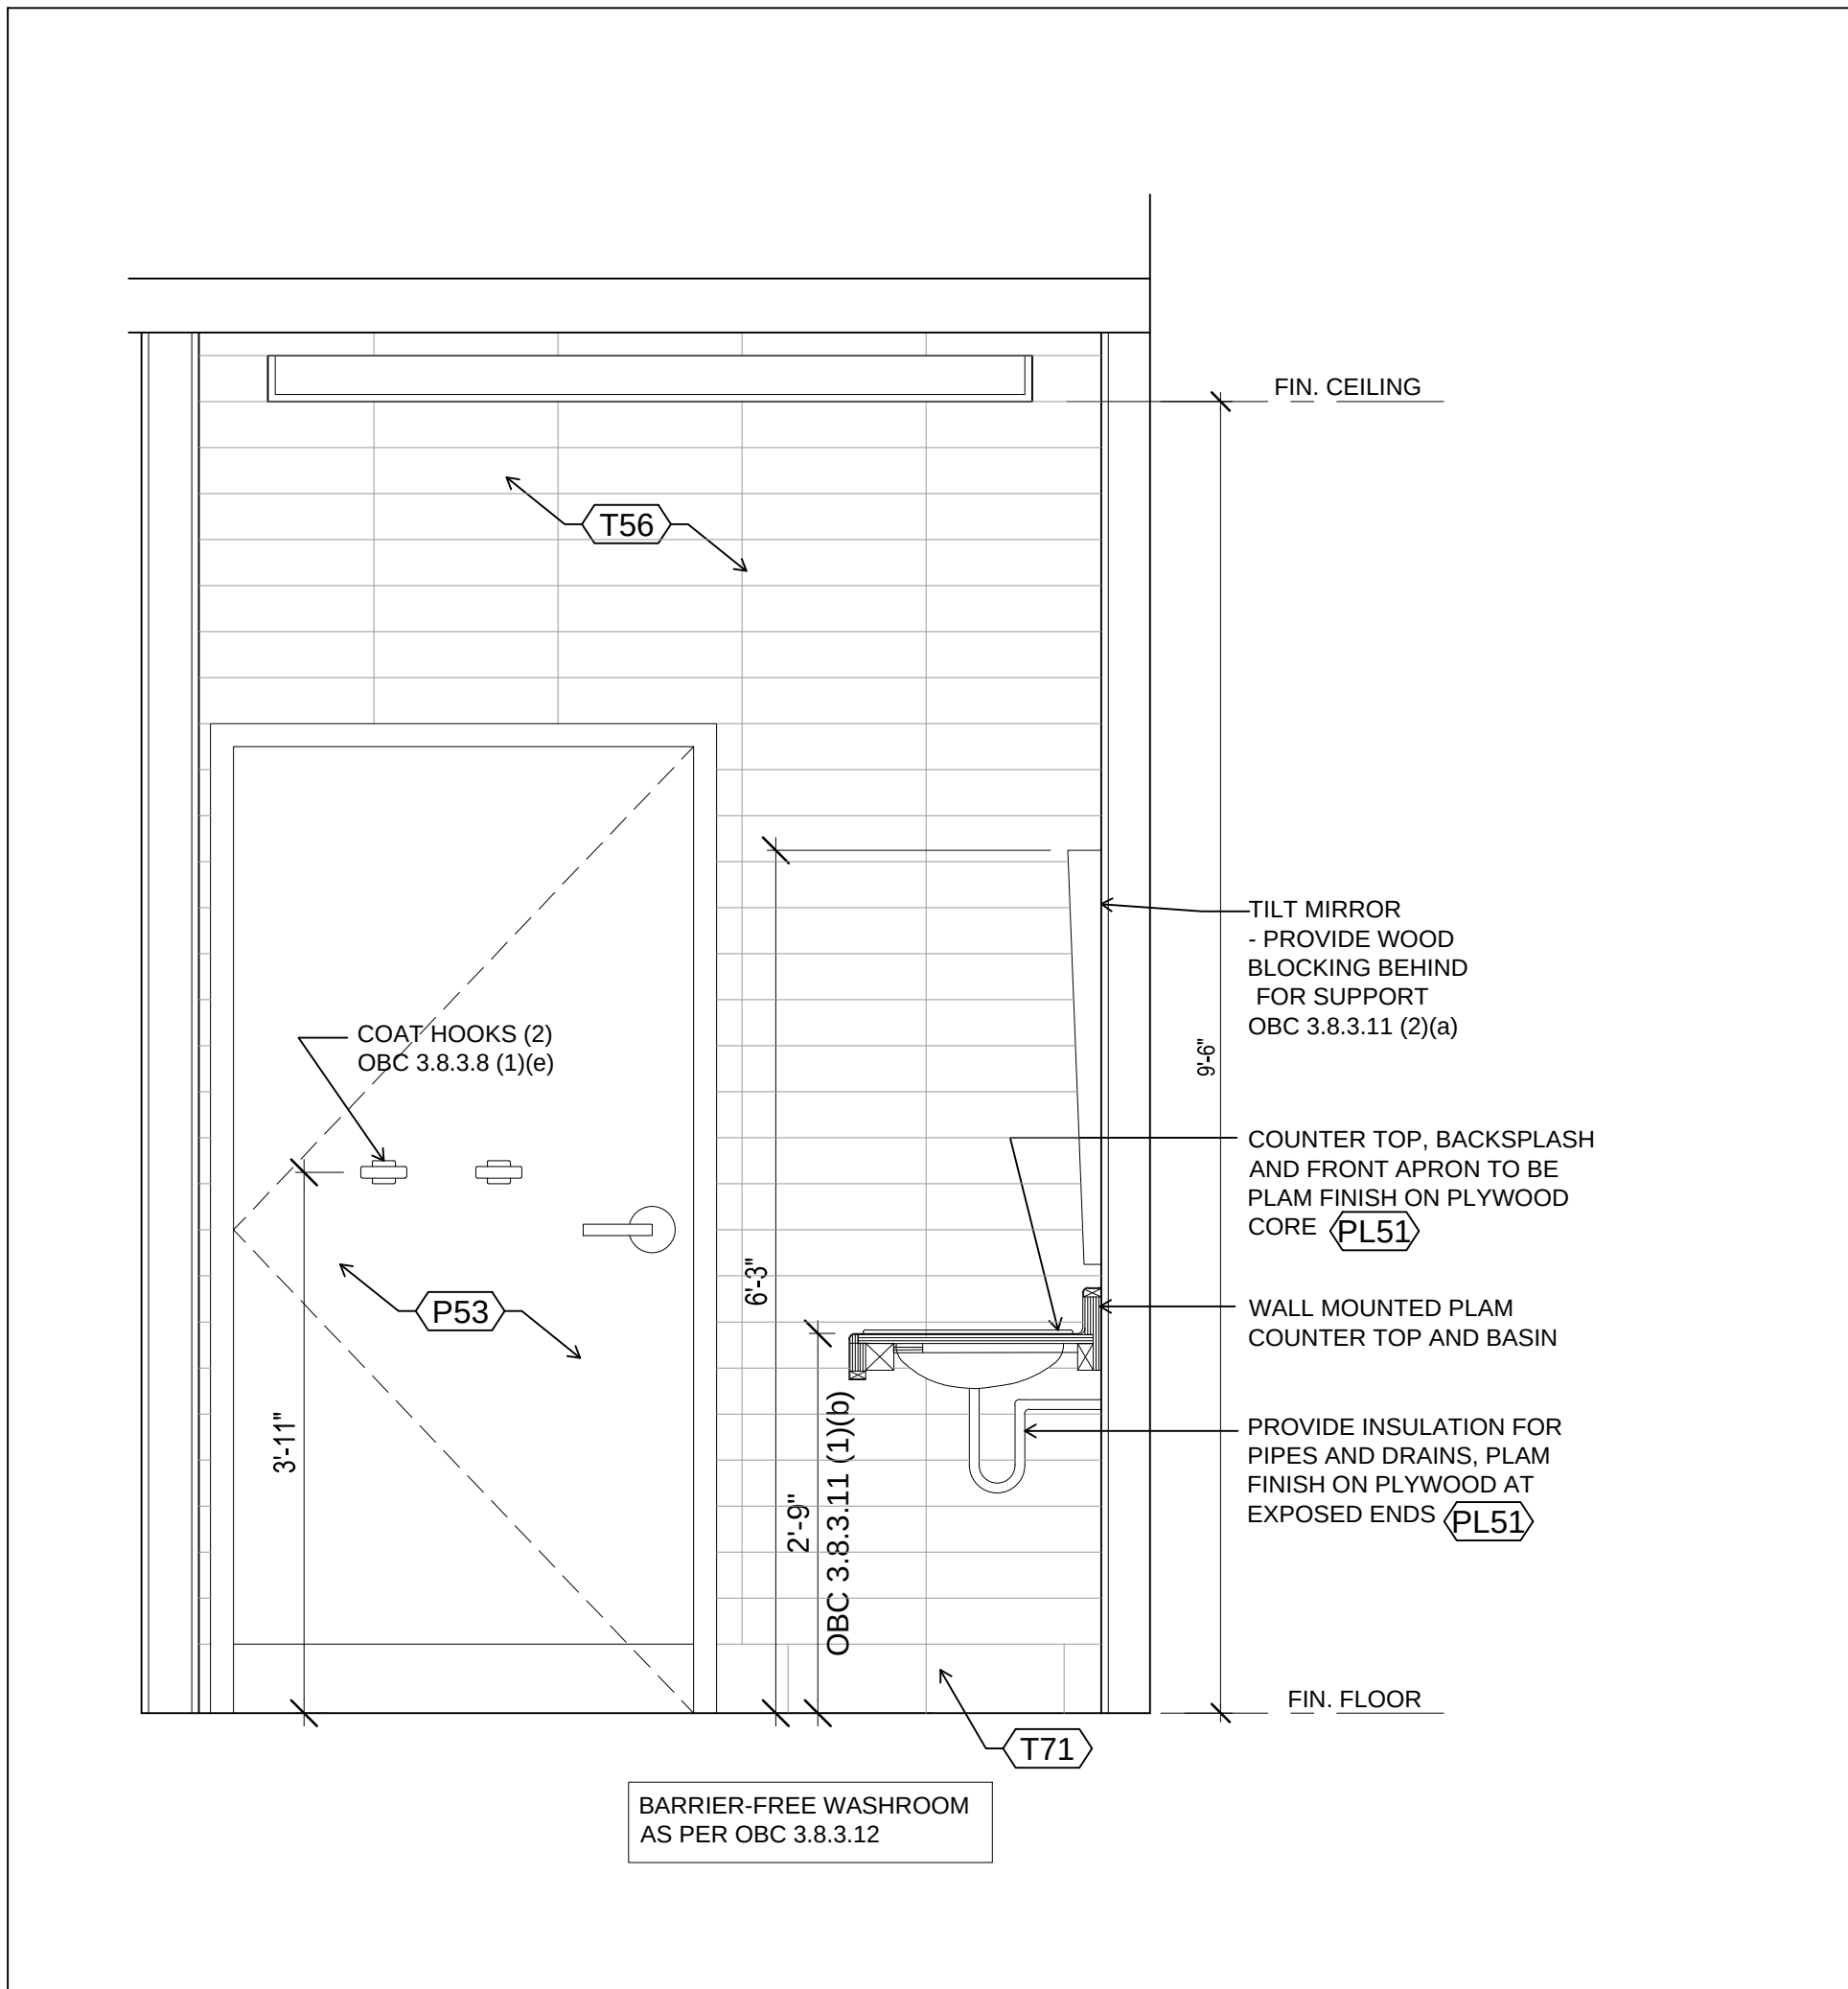

5 BARRIER-FREE WASHROOM - EAST ELEVATION
SCALE: 3/4"=1'-0"

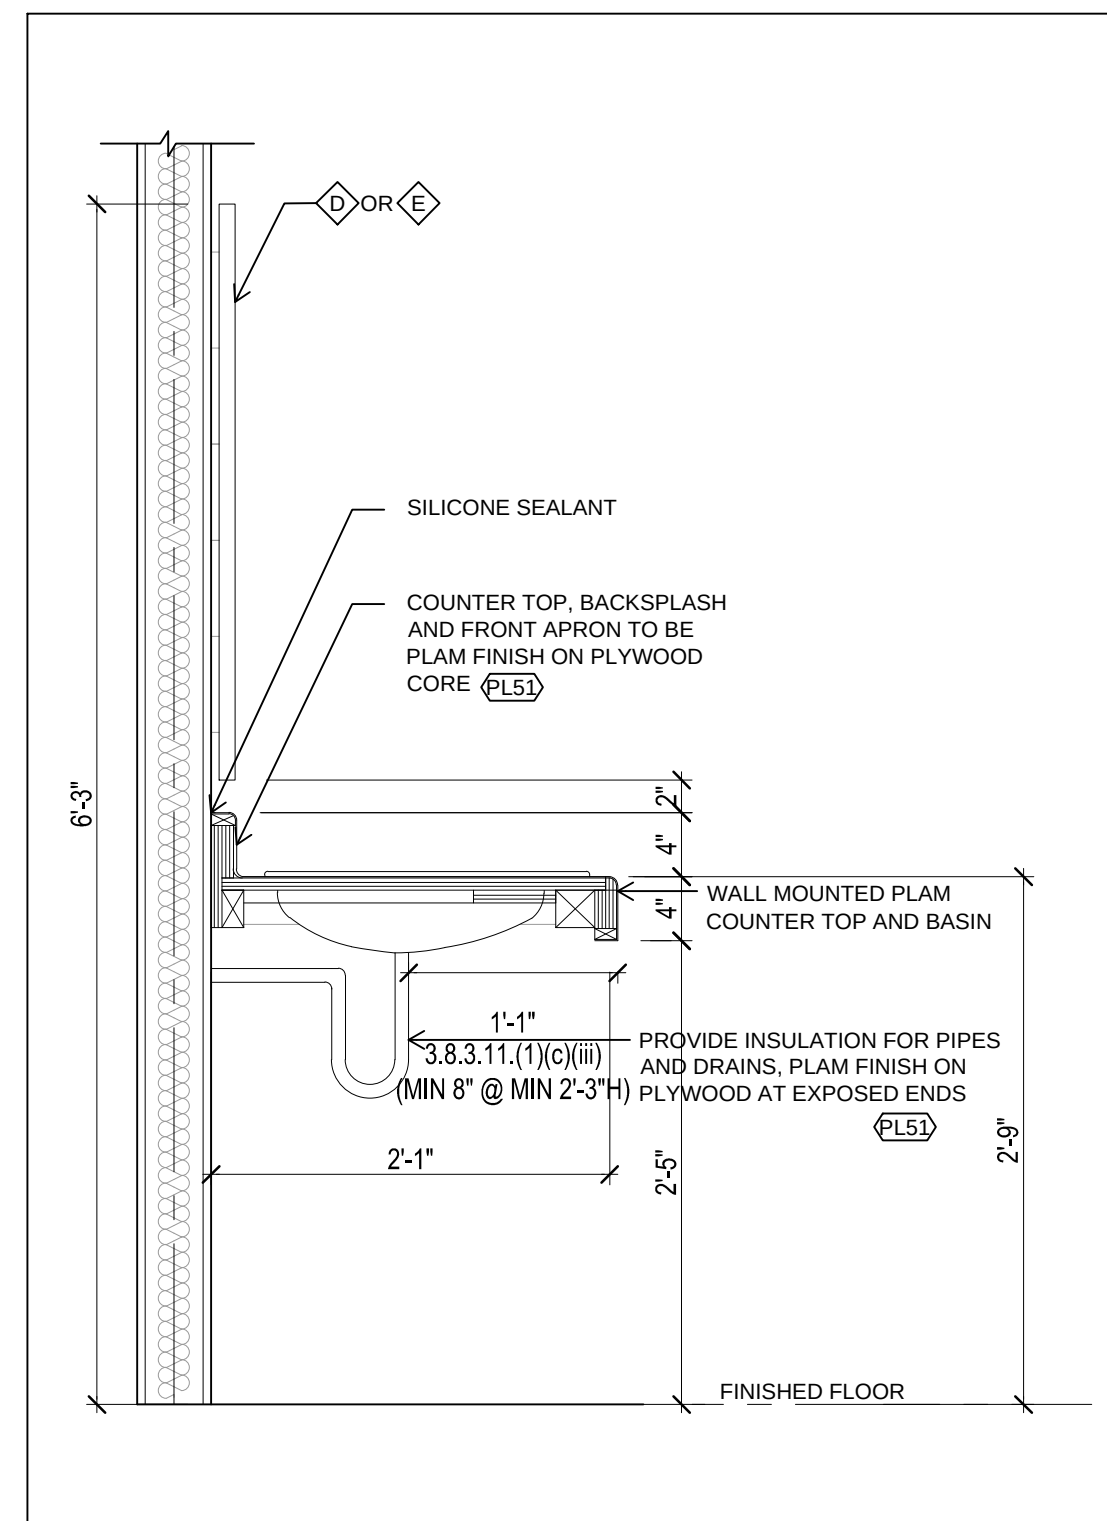


8 STAFF WASHROOM SINK DETAIL
SCALE: 1/2"=1'-0"

1. ALL WASHROOM ACCESSORIES SHALL BE MOUNTED AT HEIGHTS RECOMMENDED BY THE MANUFACTURERS AND TO MEET O.B.C. SECTION 3.8.
2. BARRIER FREE WASHROOMS SHALL CONFORM TO THE APPLICABLE ARTICLES OF O.B.C. SECTION 3.8.
3. REFER TO FLOOR FINISH PLAN FOR FLOORING LEGEND AND NOTES.
4. REFER TO MECHANICAL SPECIFICATIONS FOR PLUMBING FIXTURE SCHEDULE AND FIXTURE SPECIFICATIONS.
5. WASHROOM MILLWORK AND ACCESSORIES ARE INCLUDED IN CONTRACT.


9 GENERAL NOTES
SCALE: 1/2"=1'-0"

- A SURFACE MOUNTED DIAPER CHANGING STATION SUPPLIED BY METRO AND INSTALLED BY GENERAL CONTRACTOR
- B RESERVED
- C SOAP DISPENSER SUPPLIED BY METRO AND INSTALLED BY GENERAL CONTRACTOR
- D 24" x 36" MIRROR BY BOBRICK
- E 24" x 36" TILT MIRROR BY BOBRICK #B293 2436 (AT B/F WASHROOM)
- F HAND DRYER BY EXCEL DRYER XCELERATOR MODEL #XL-W (AT B/F WASHROOM)
- G TOILET TISSUE DISPENSER BY CASCADES MODEL #212 SUPPLIED BY METRO AND INSTALLED BY CONTRACTOR.
- H STAINLESS STEEL GRAB BARS WITH SNAP FLANGE 24" AND 30" 1-1/2" DIAMETER BY BOBRICK MODEL #B-6806.
- I SURFACE MOUNTED DOUBLE ROBE HOOK BY BOBRICK MODEL #B-672
- J RESERVED
- K PAPER TOWEL DISPENSER / DISPOSAL BY METRO INSTALLED BY G.C.
- L INSTALLED AS PER OBC 3.8.3.11 (1)(i)(p)
- M METAL WASHROOM PARTITIONS COLOUR 124 PEARL GREY BY GSS, REFER TO DECOR DRAWINGS


10 WASHROOM ACCESSORIES
SCALE: 1/2"=1'-0"

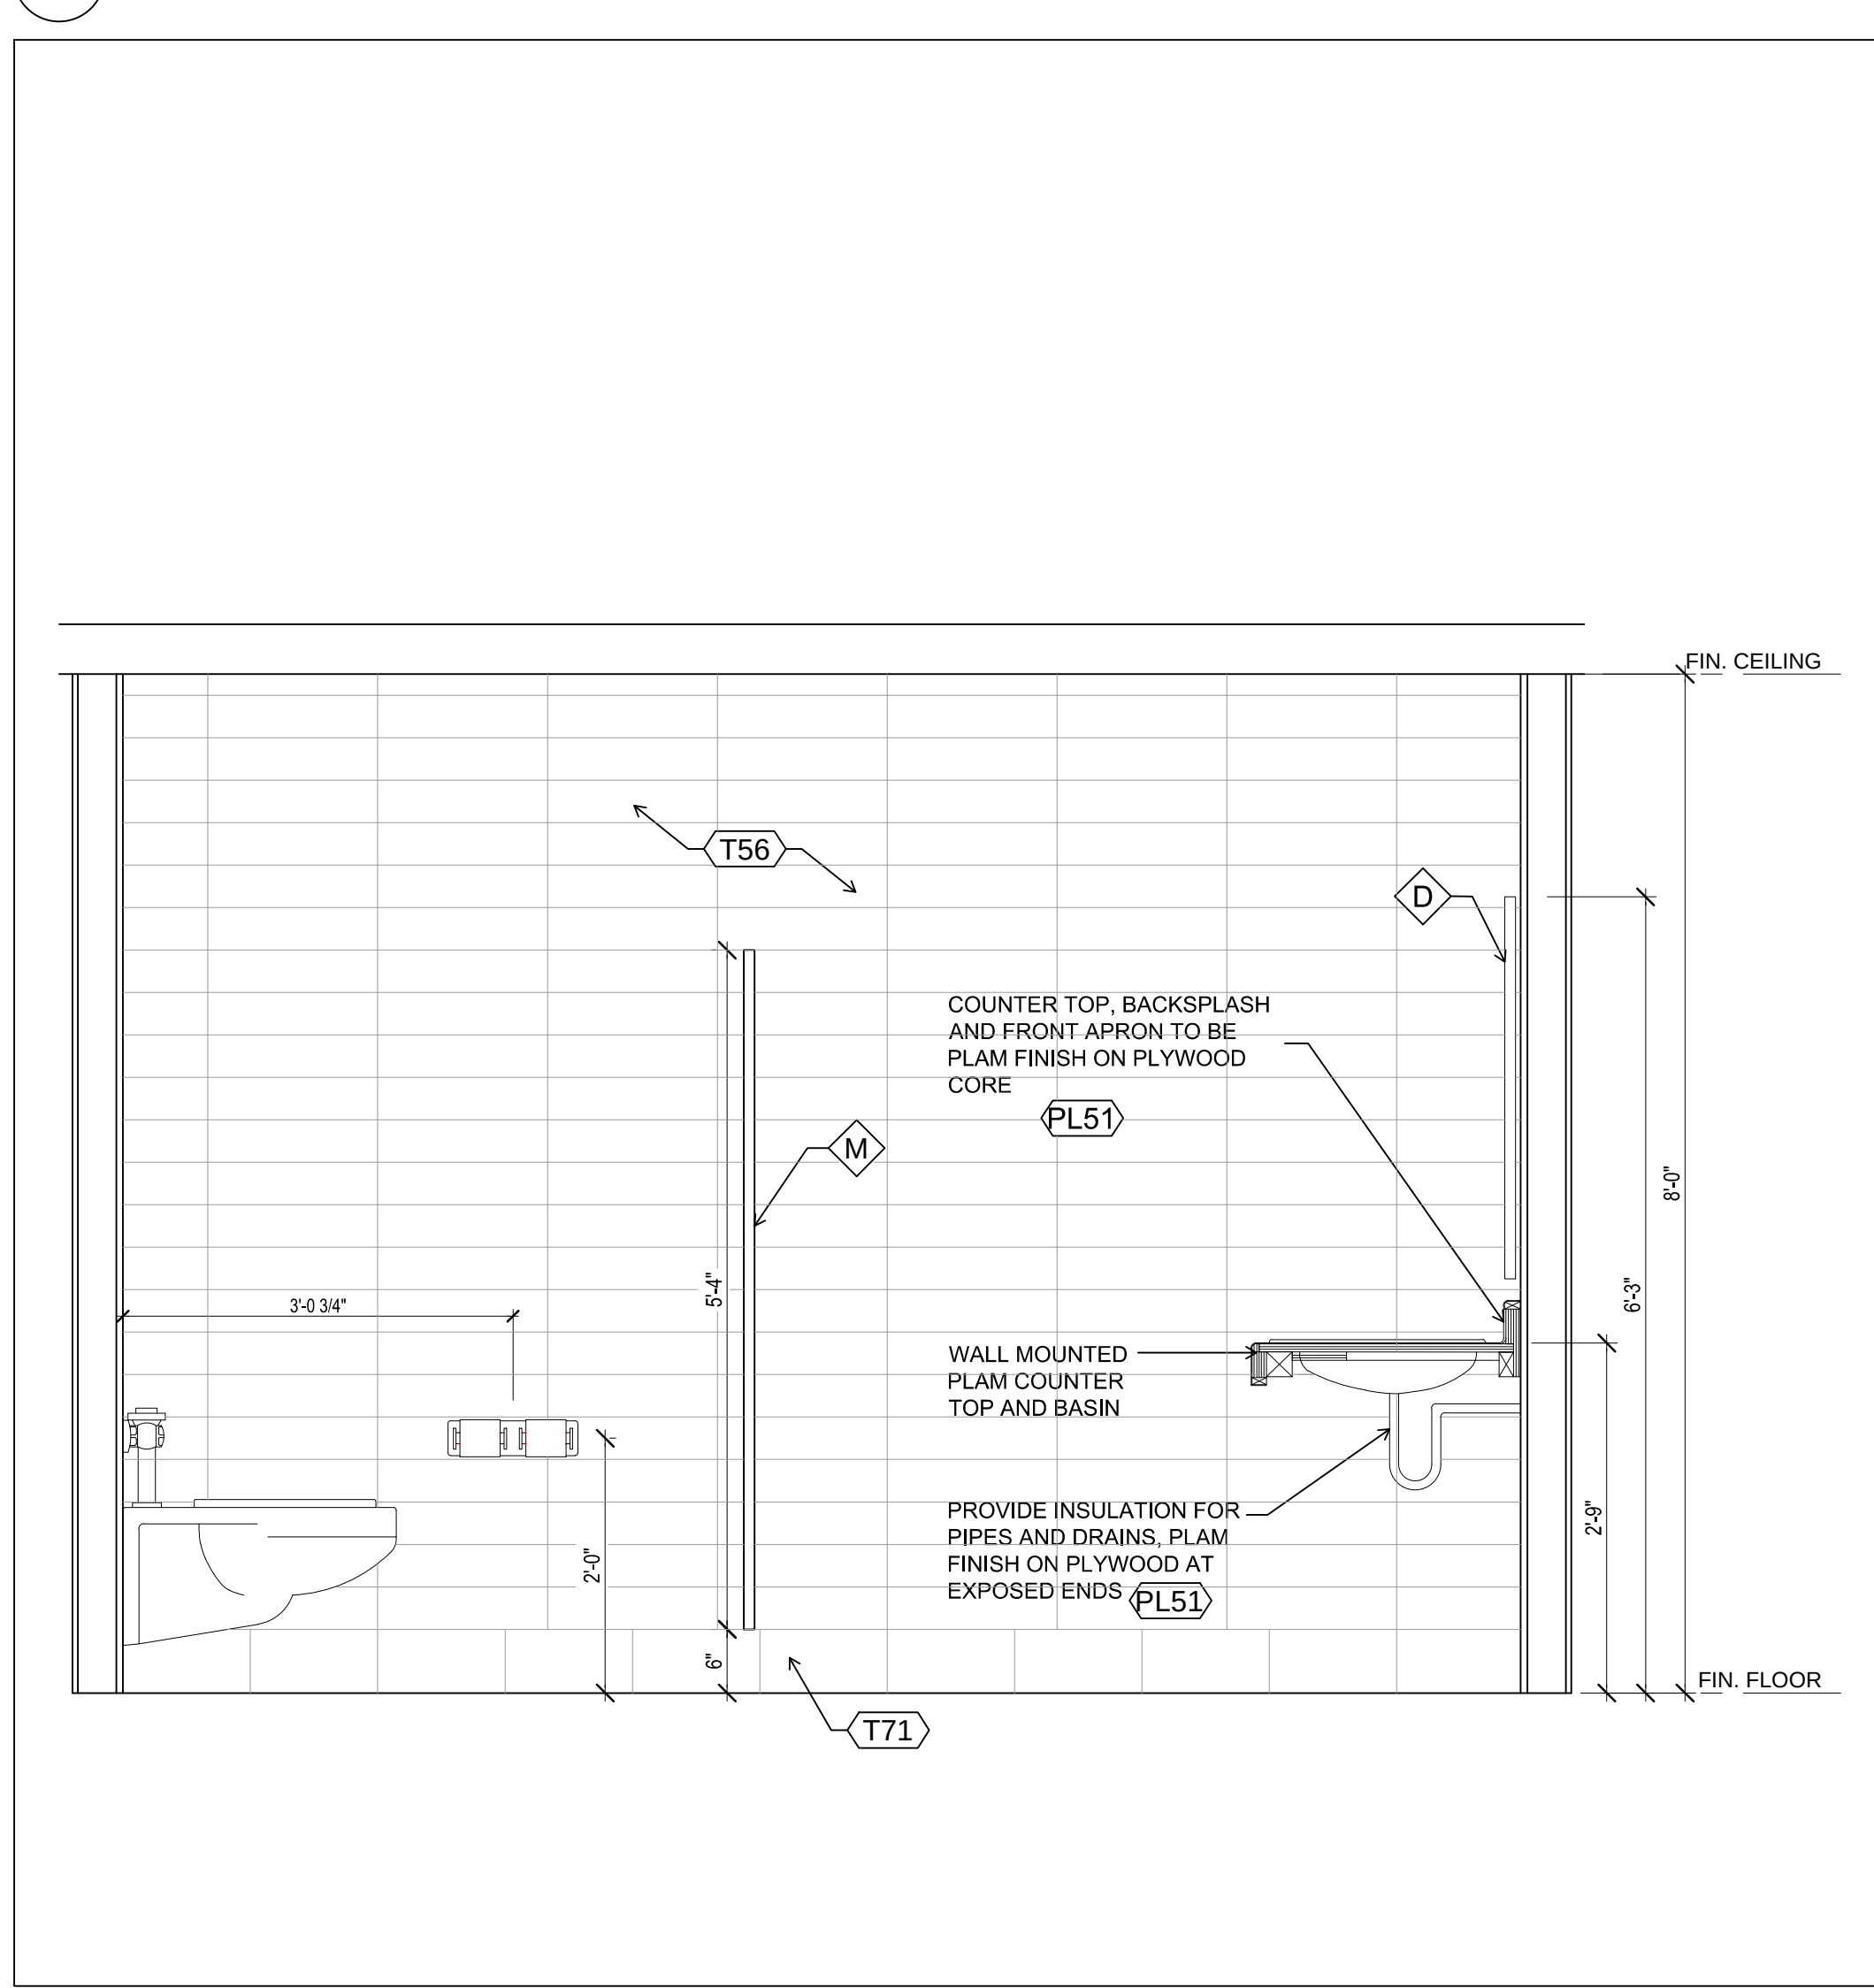

12 WOMENS WASHROOM - NORTH ELEVATION
SCALE: 3/4"=1'-0"

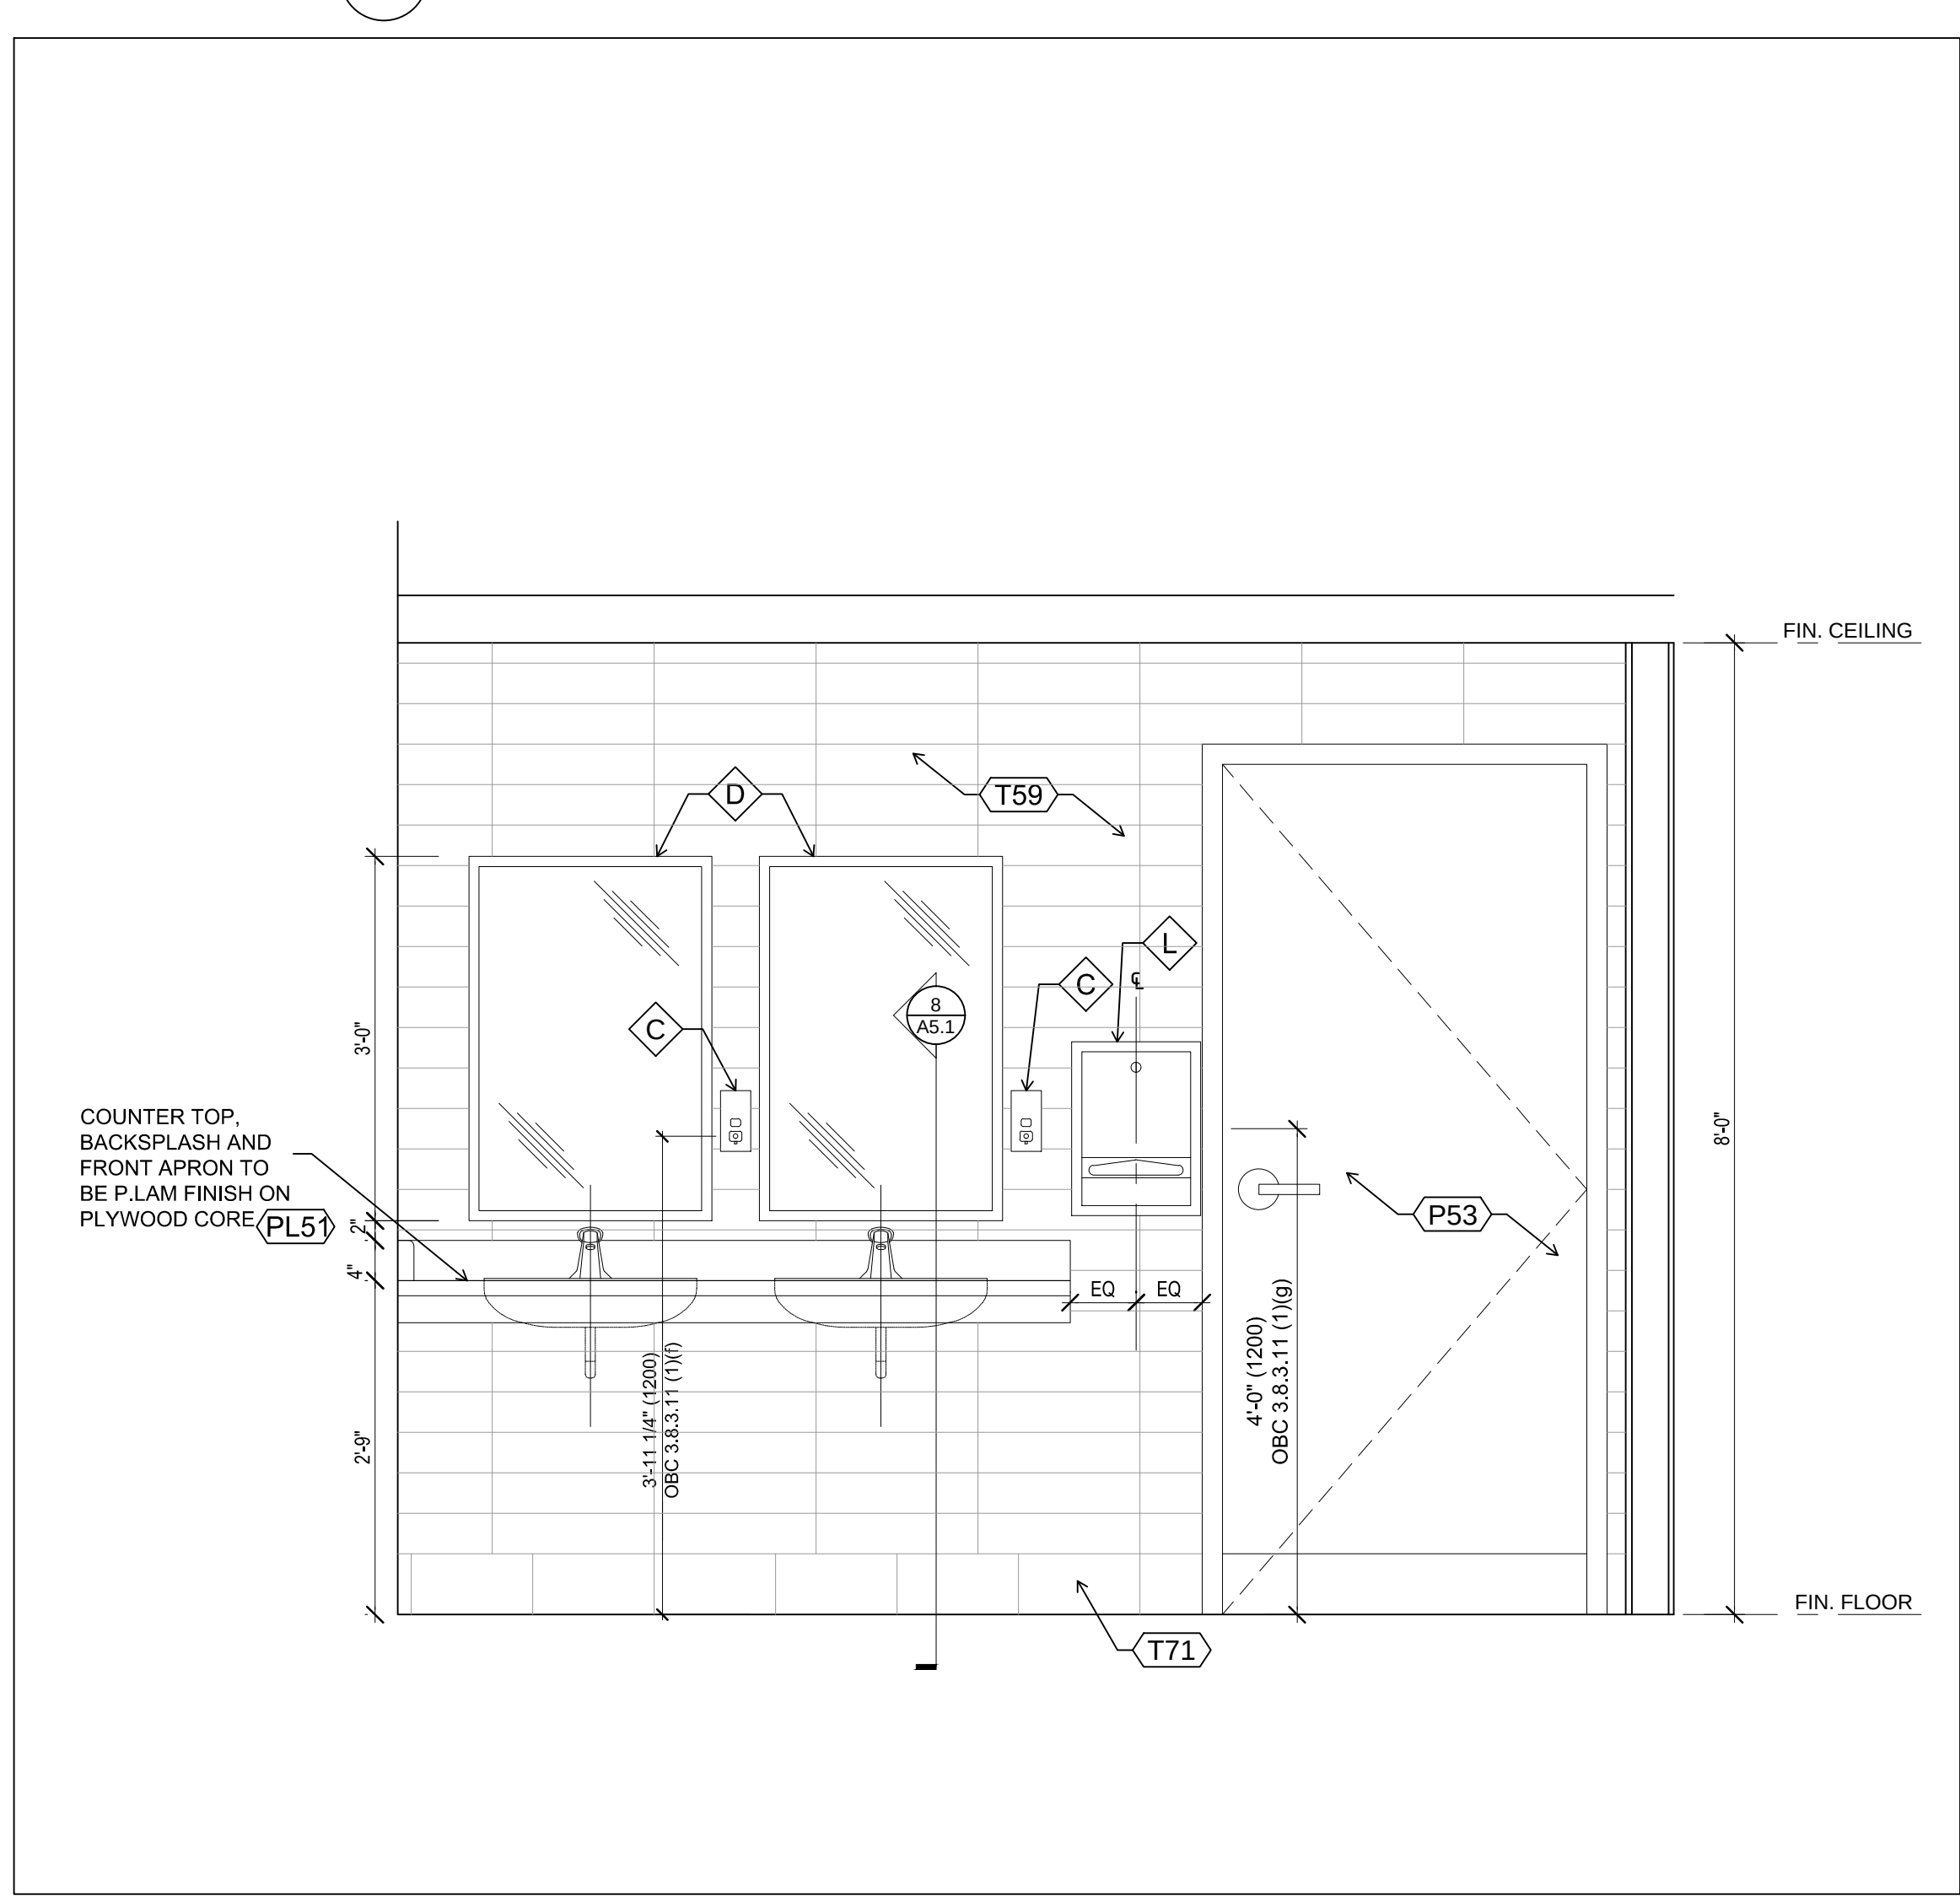

13 WOMENS WASHROOM - EAST ELEVATION
SCALE: 3/4"=1'-0"

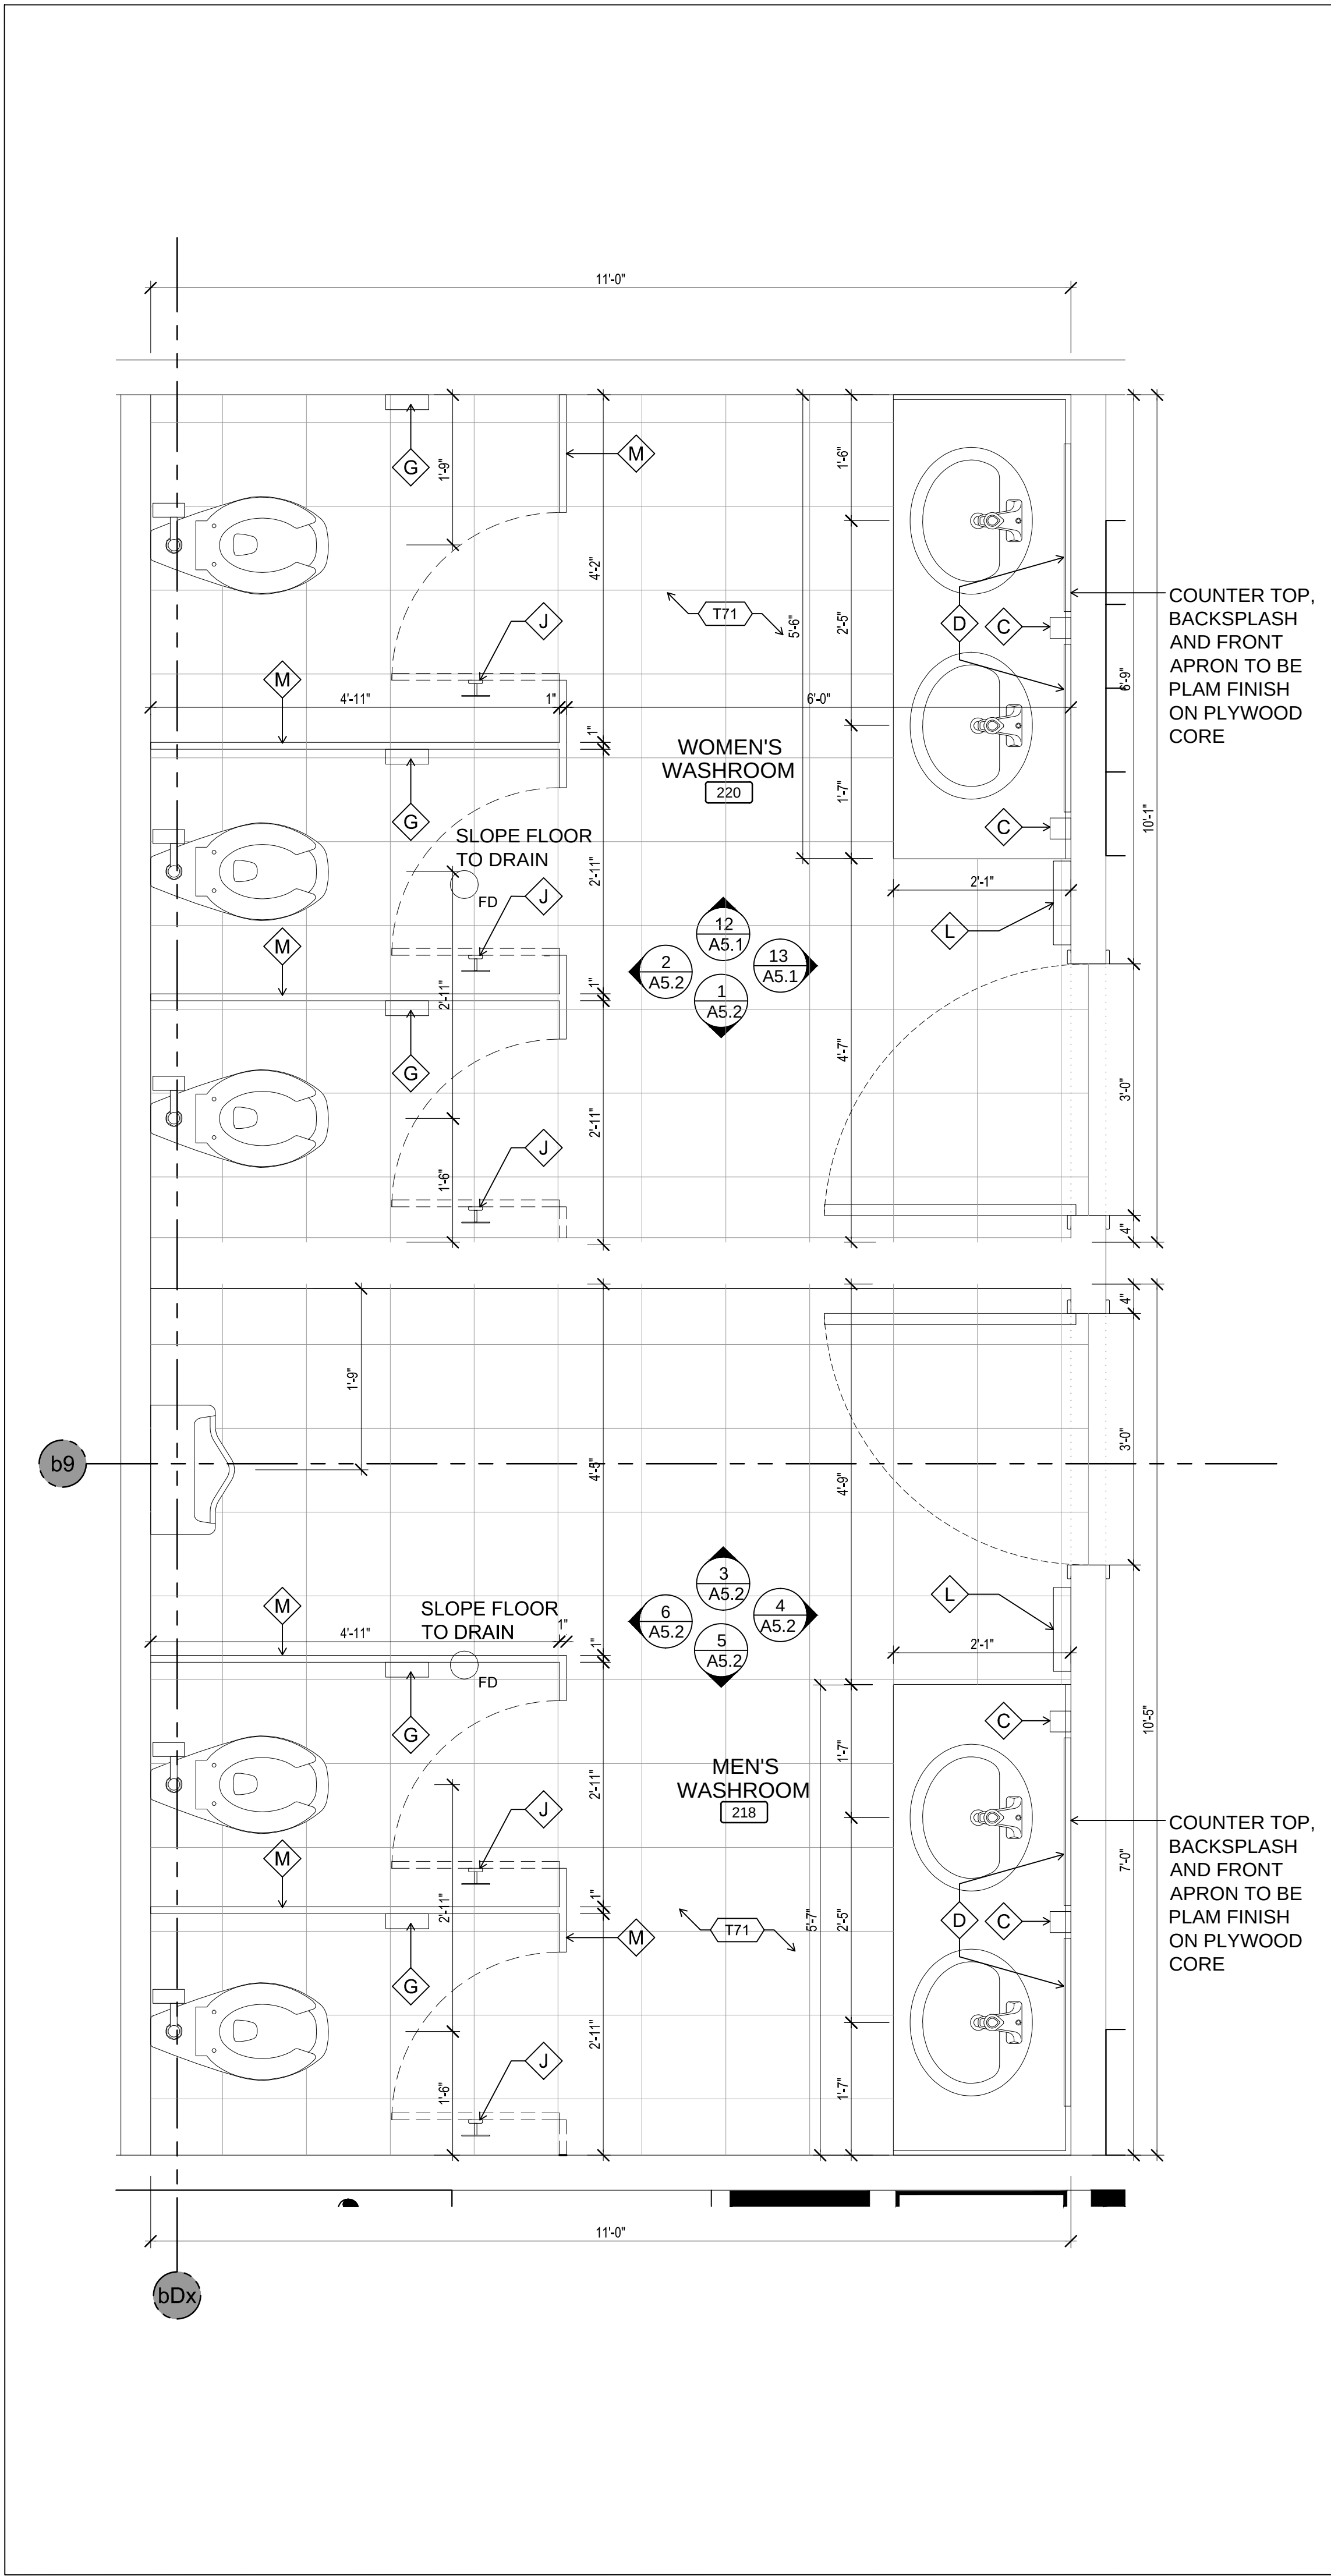

11 MENS AND WOMENS WASHROOM 204 & 205
SCALE: 3/4"=1'-0"

KEY PLAN:


ISSUED

No.	DATE	DESCRIPTION
01	01/24/14	ISSUED FOR 40% REVIEW
02	02/14/14	ISSUED FOR 60% REVIEW
03	03/05/14	ISSUED FOR 100% REVIEW
04	04/14/14	ISSUED FOR PERMIT
05	04/28/14	ISSUED FOR TENDER
06	05/13/14	RE-ISSUED FOR TENDER
07	07/10/14	ISSUED FOR CONSTRUCTION
08		

REVISION

No.	DATE	DESCRIPTION
01	05/20/14	ADDENDUM 1
02	06/20/14	POST TENDER ADDENDUM 01

NOTES

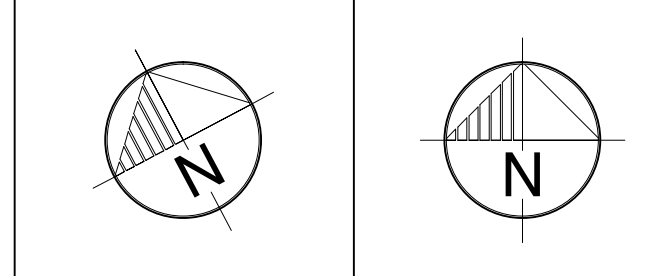

TRUE NORTH CONSTRUCTION NORTH

DIMENSIONS AND CONDITIONS TO BE VERIFIED ON THE SITE

DO NOT SCALE THE DRAWINGS

THE CONTRACTOR WILL CHECK AND VERIFY DIMENSIONS AND REPORT ERRORS AND OMISSIONS TO THE CONSULTANT

THIS DRAWING WILL NOT BE USED FOR CONSTRUCTION PURPOSES UNTIL ISSUED FOR CONSTRUCTION BY THE CONSULTANT. WHOSE SIGNATURE IS BELOW.

ISSUED FOR CONSTRUCTION DATE

SEAL

PAUL ARCHITECT INC.

TORONTO • VANCOUVER

2660 Sherwood Heights Dr. Suite 200, Oakville, Ontario, L3J 7Y9

www.paularchitect.com

(905) 337-9800 fax (905) 337-1986

CLIENT

metro

PROJECT TITLE

ENLARGED WASHROOM PLANS & INTERIOR ELEVATIONS

DRAWN BY: ML

CHECKED BY: ML

DRAWING NO: A5.1

SCALE: AS NOTED DATE: JAN 2014

PROJECT NO: 1401137