
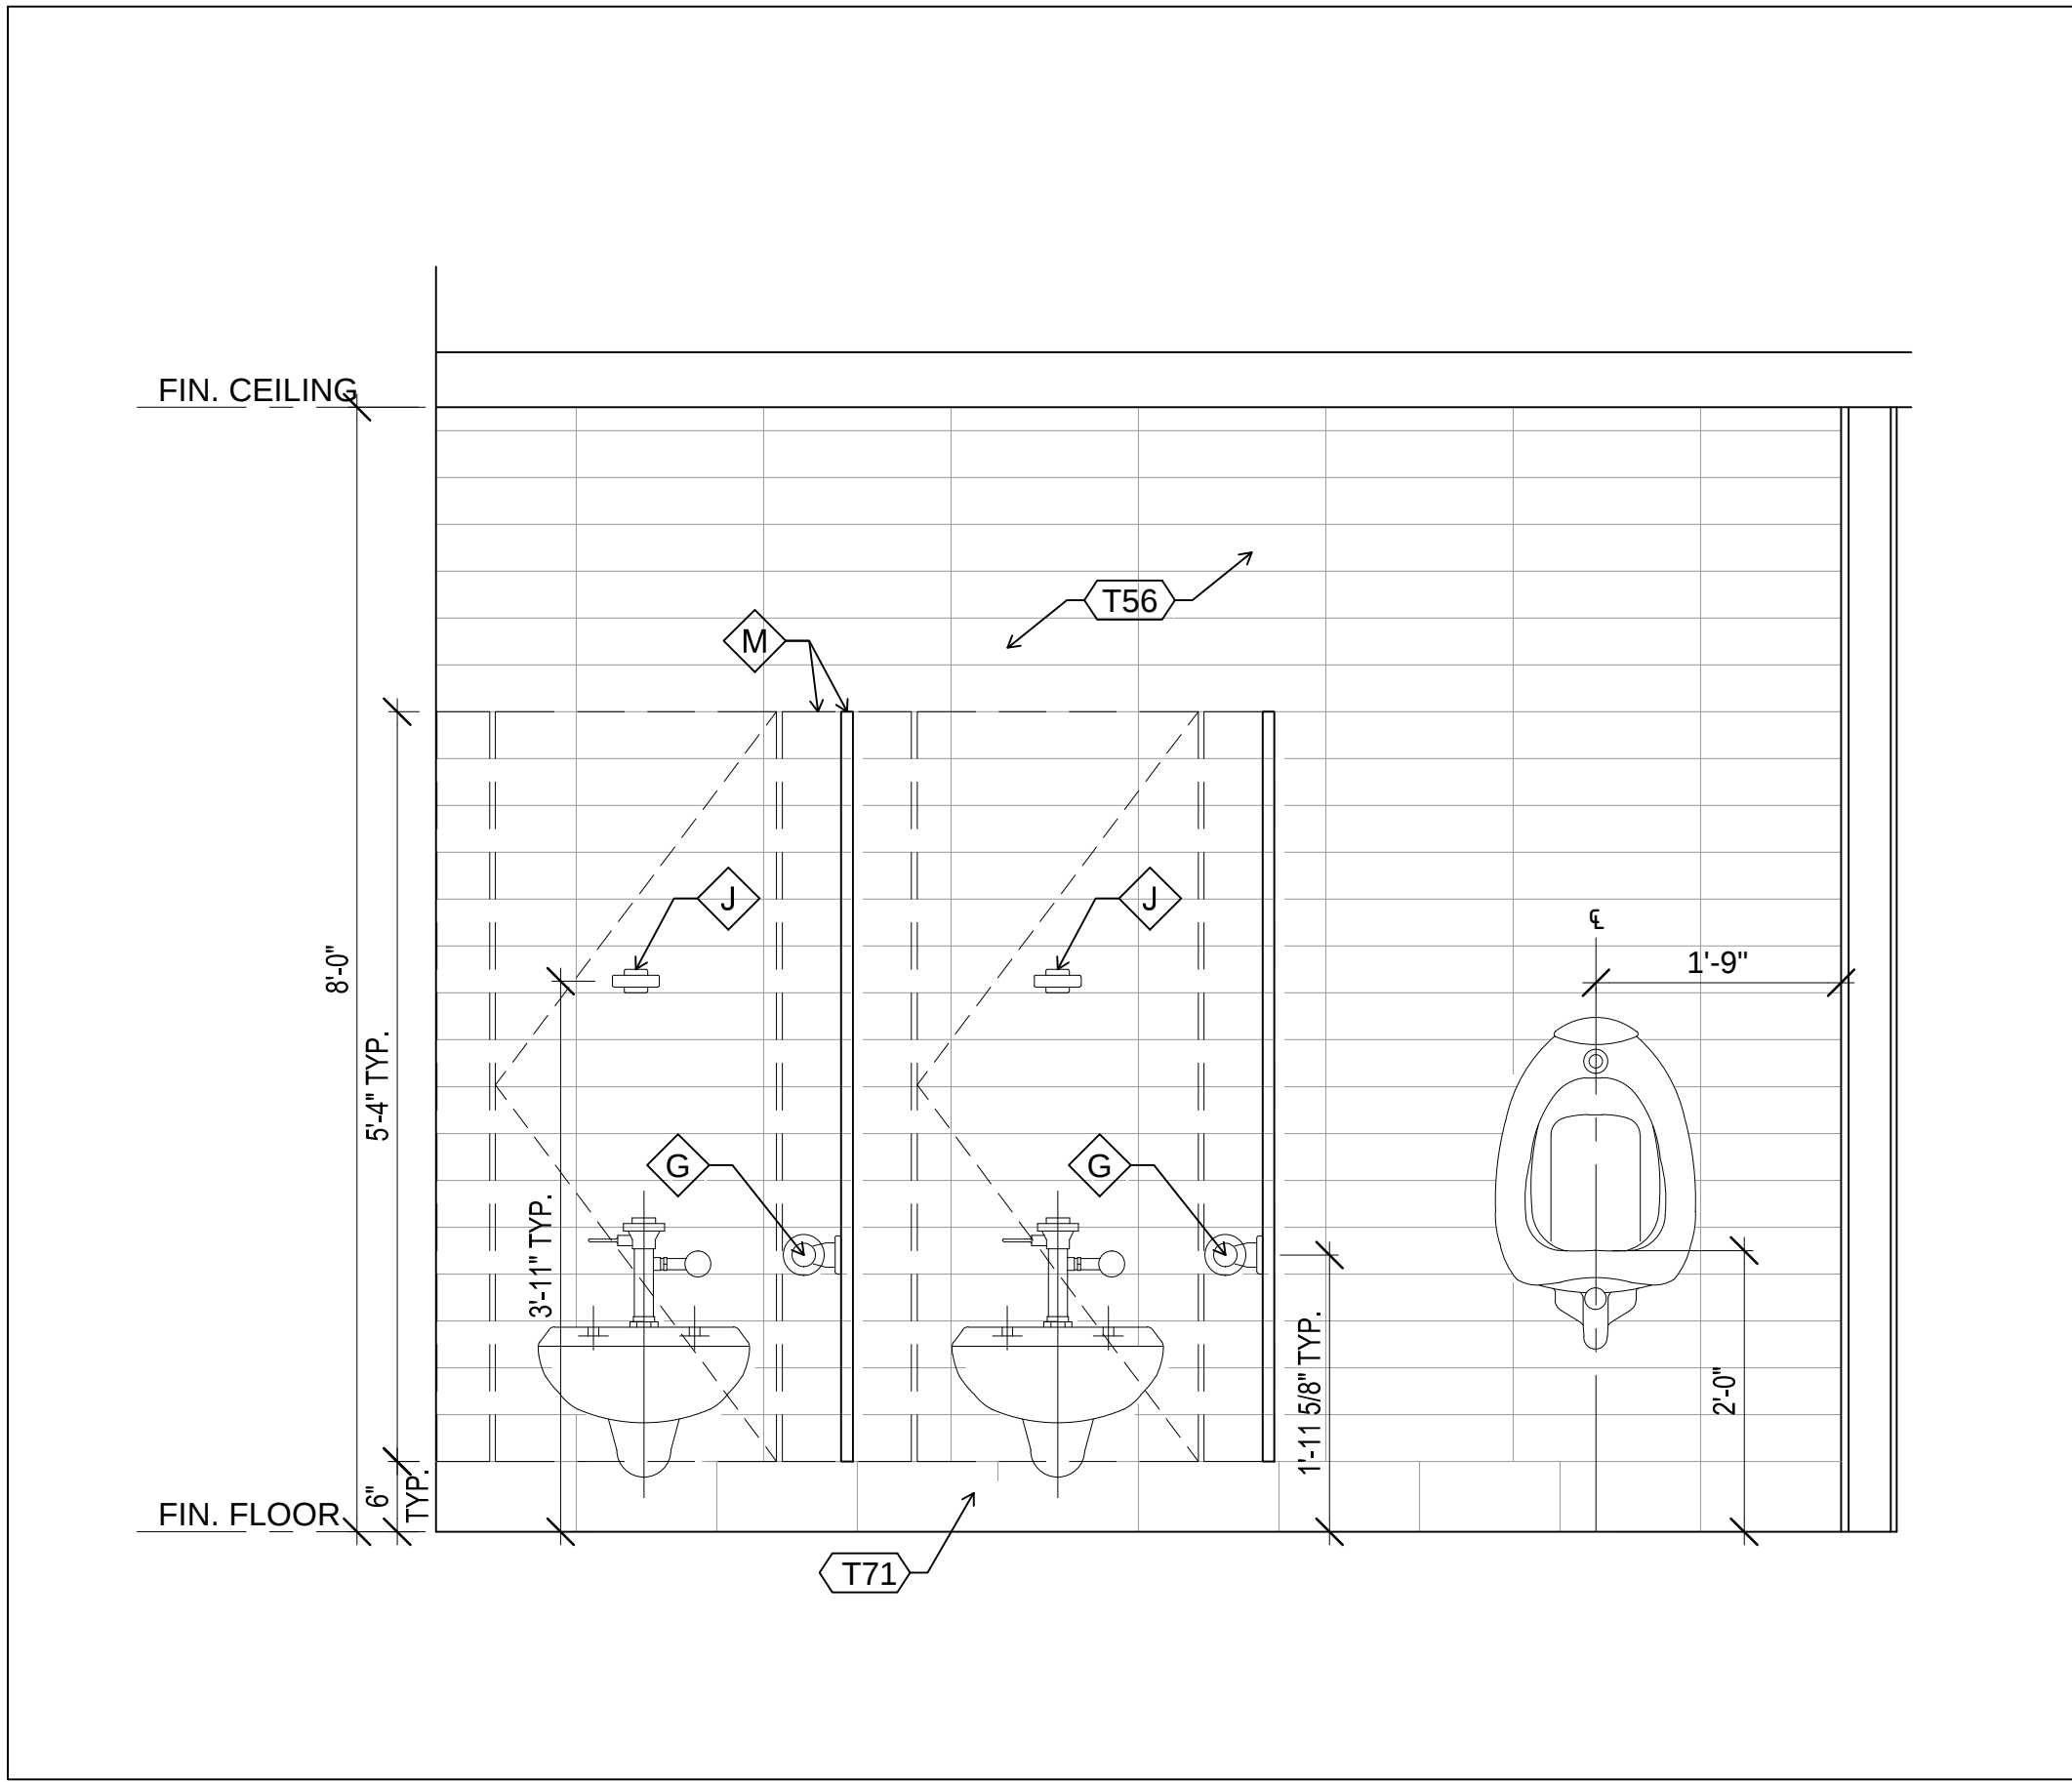
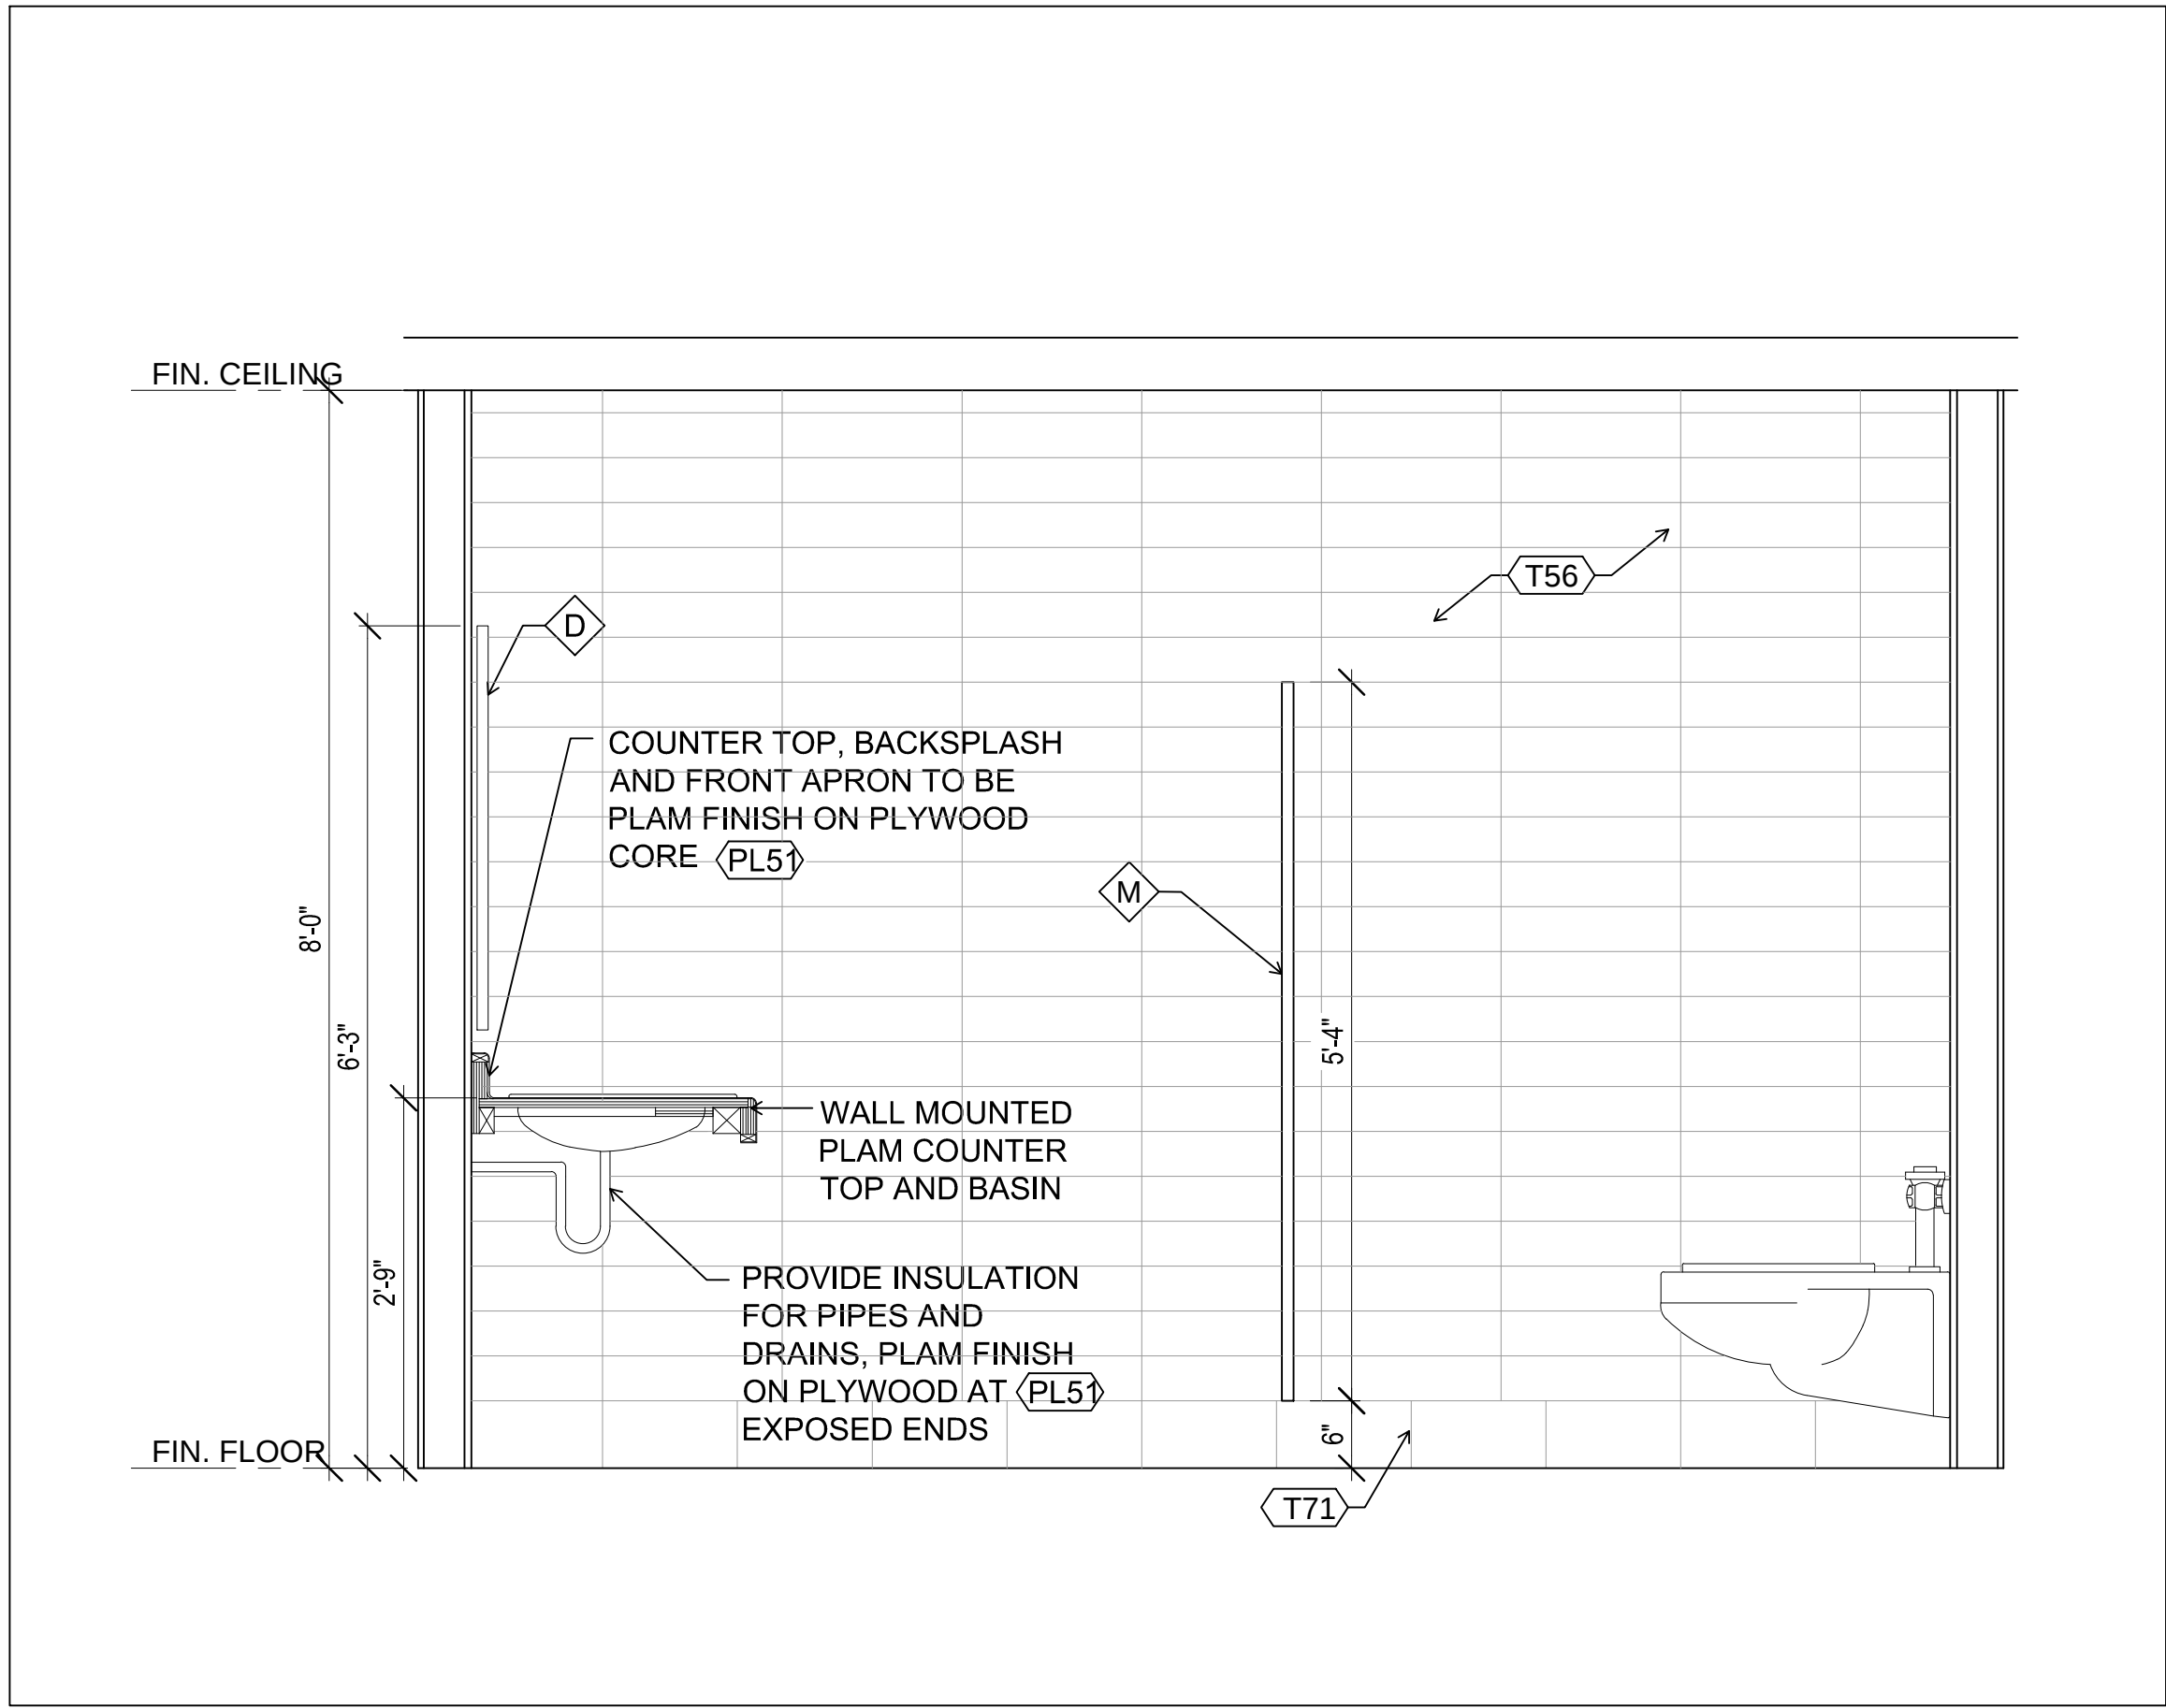
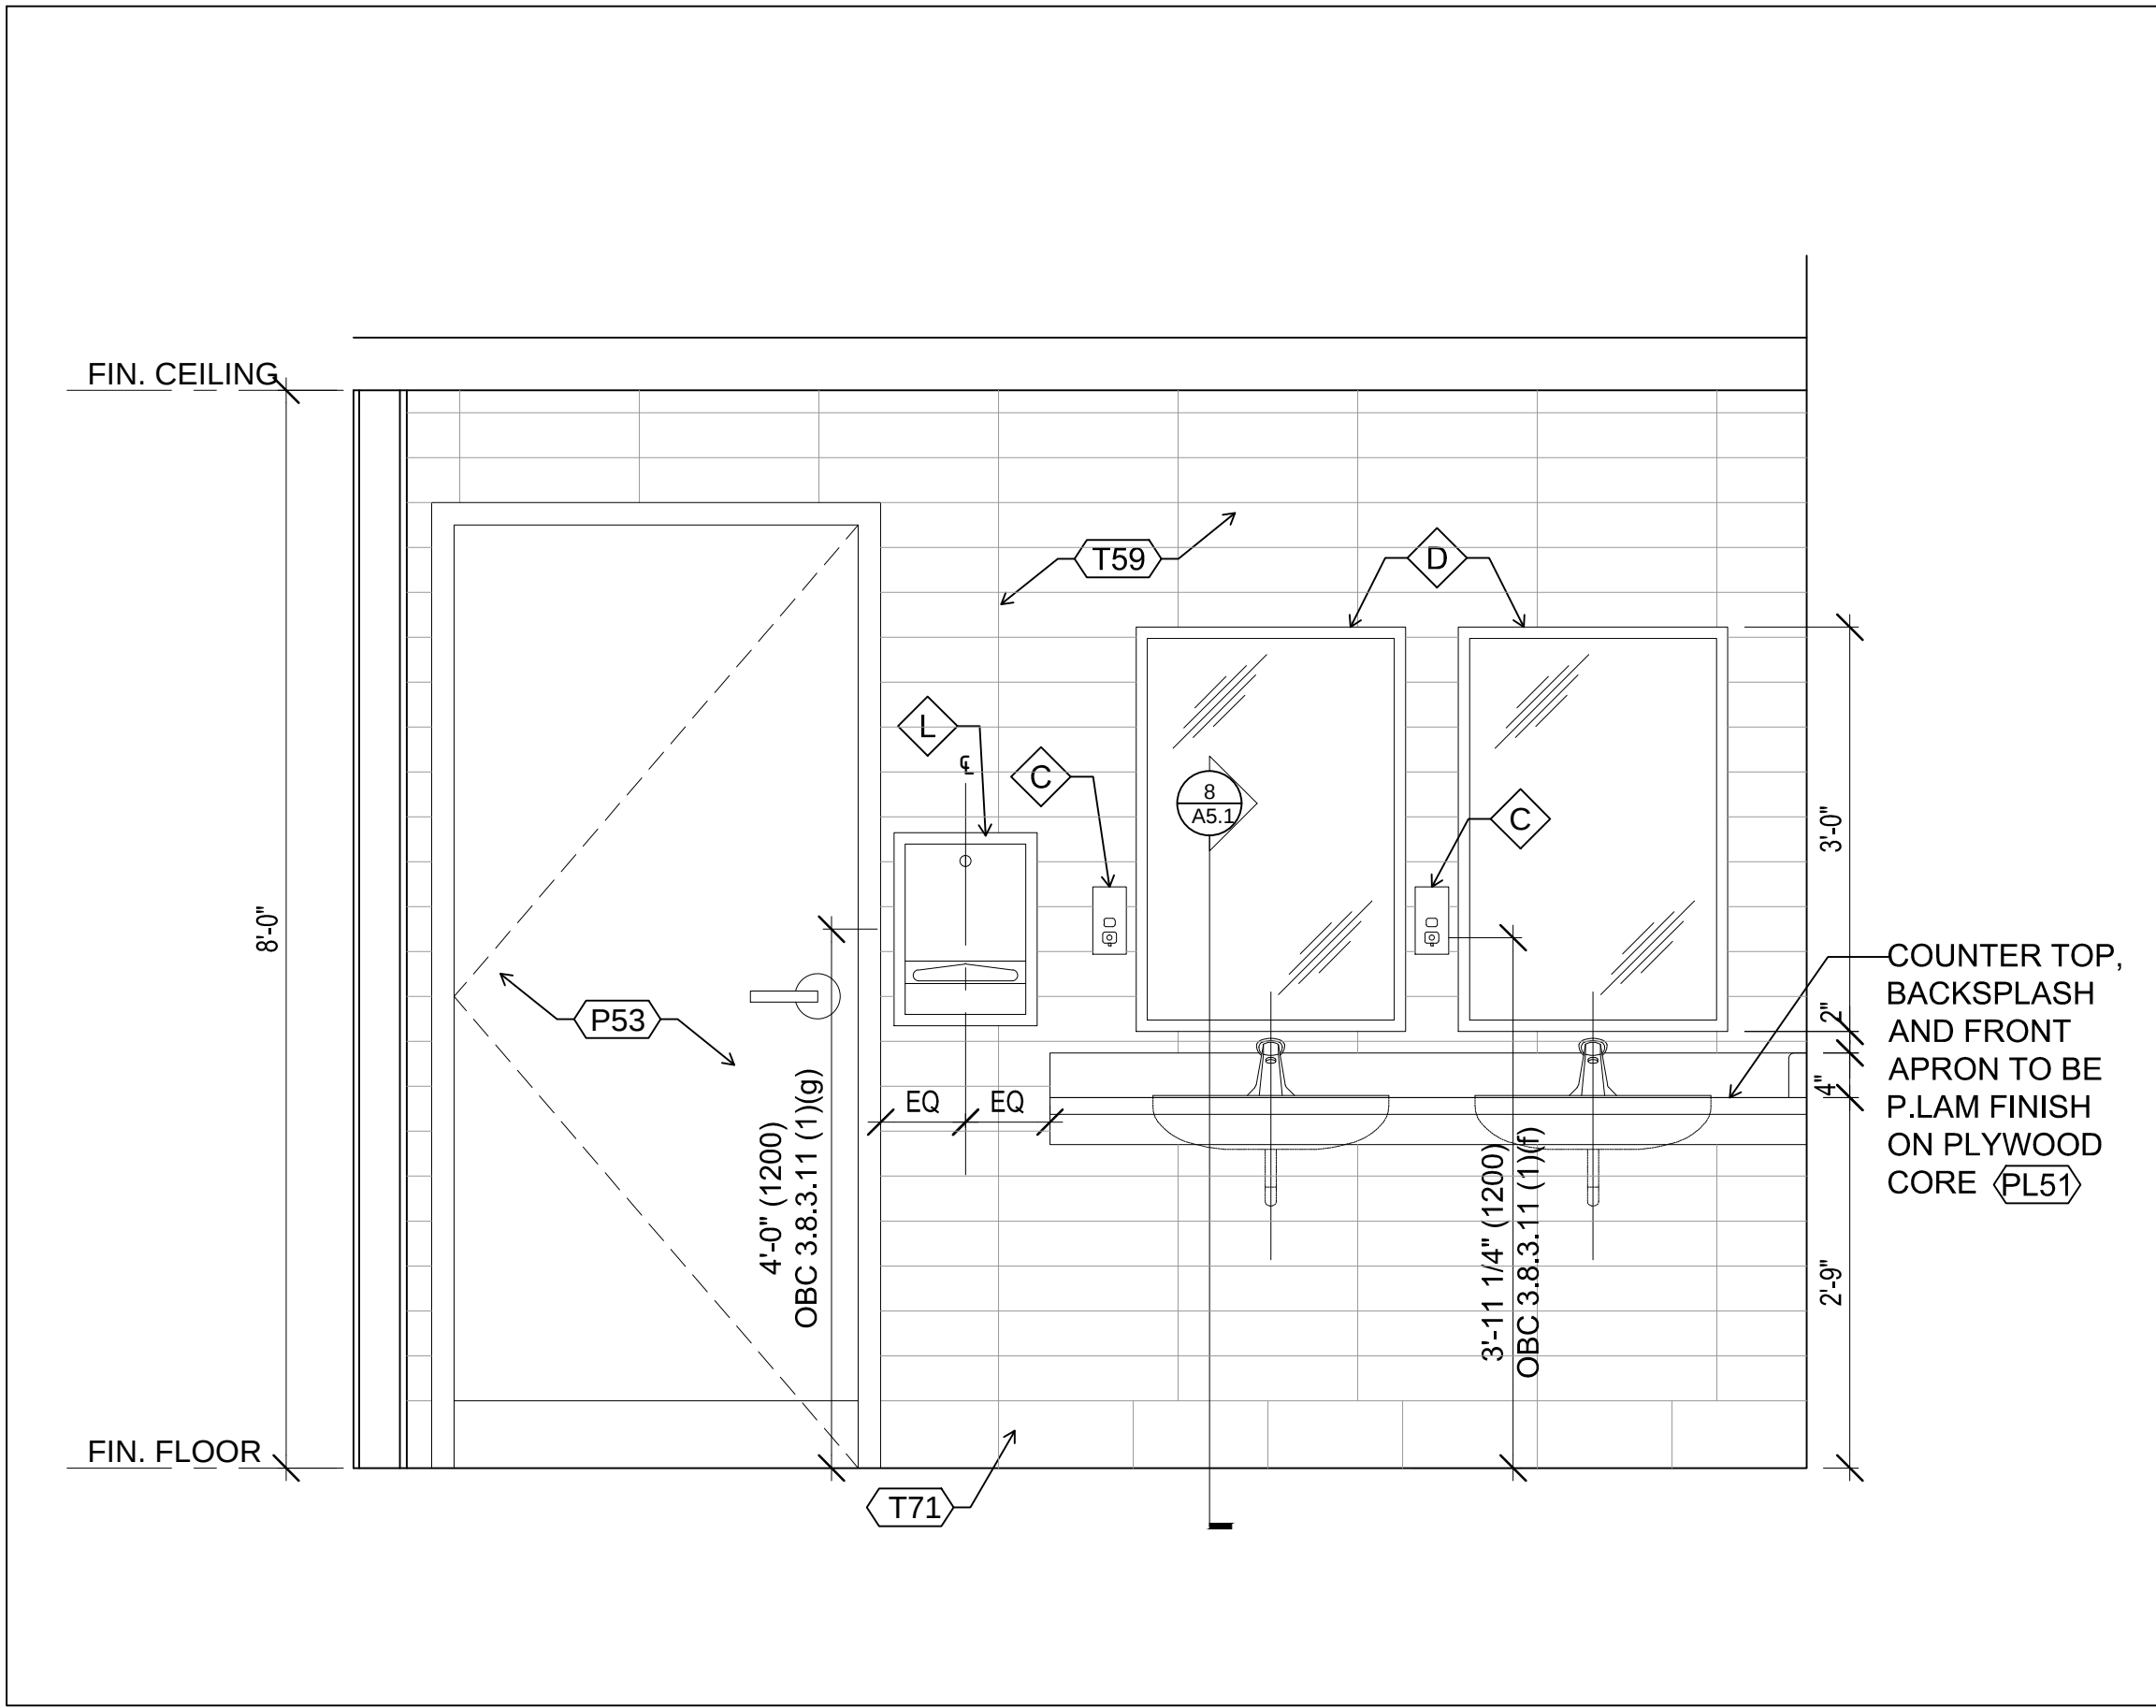
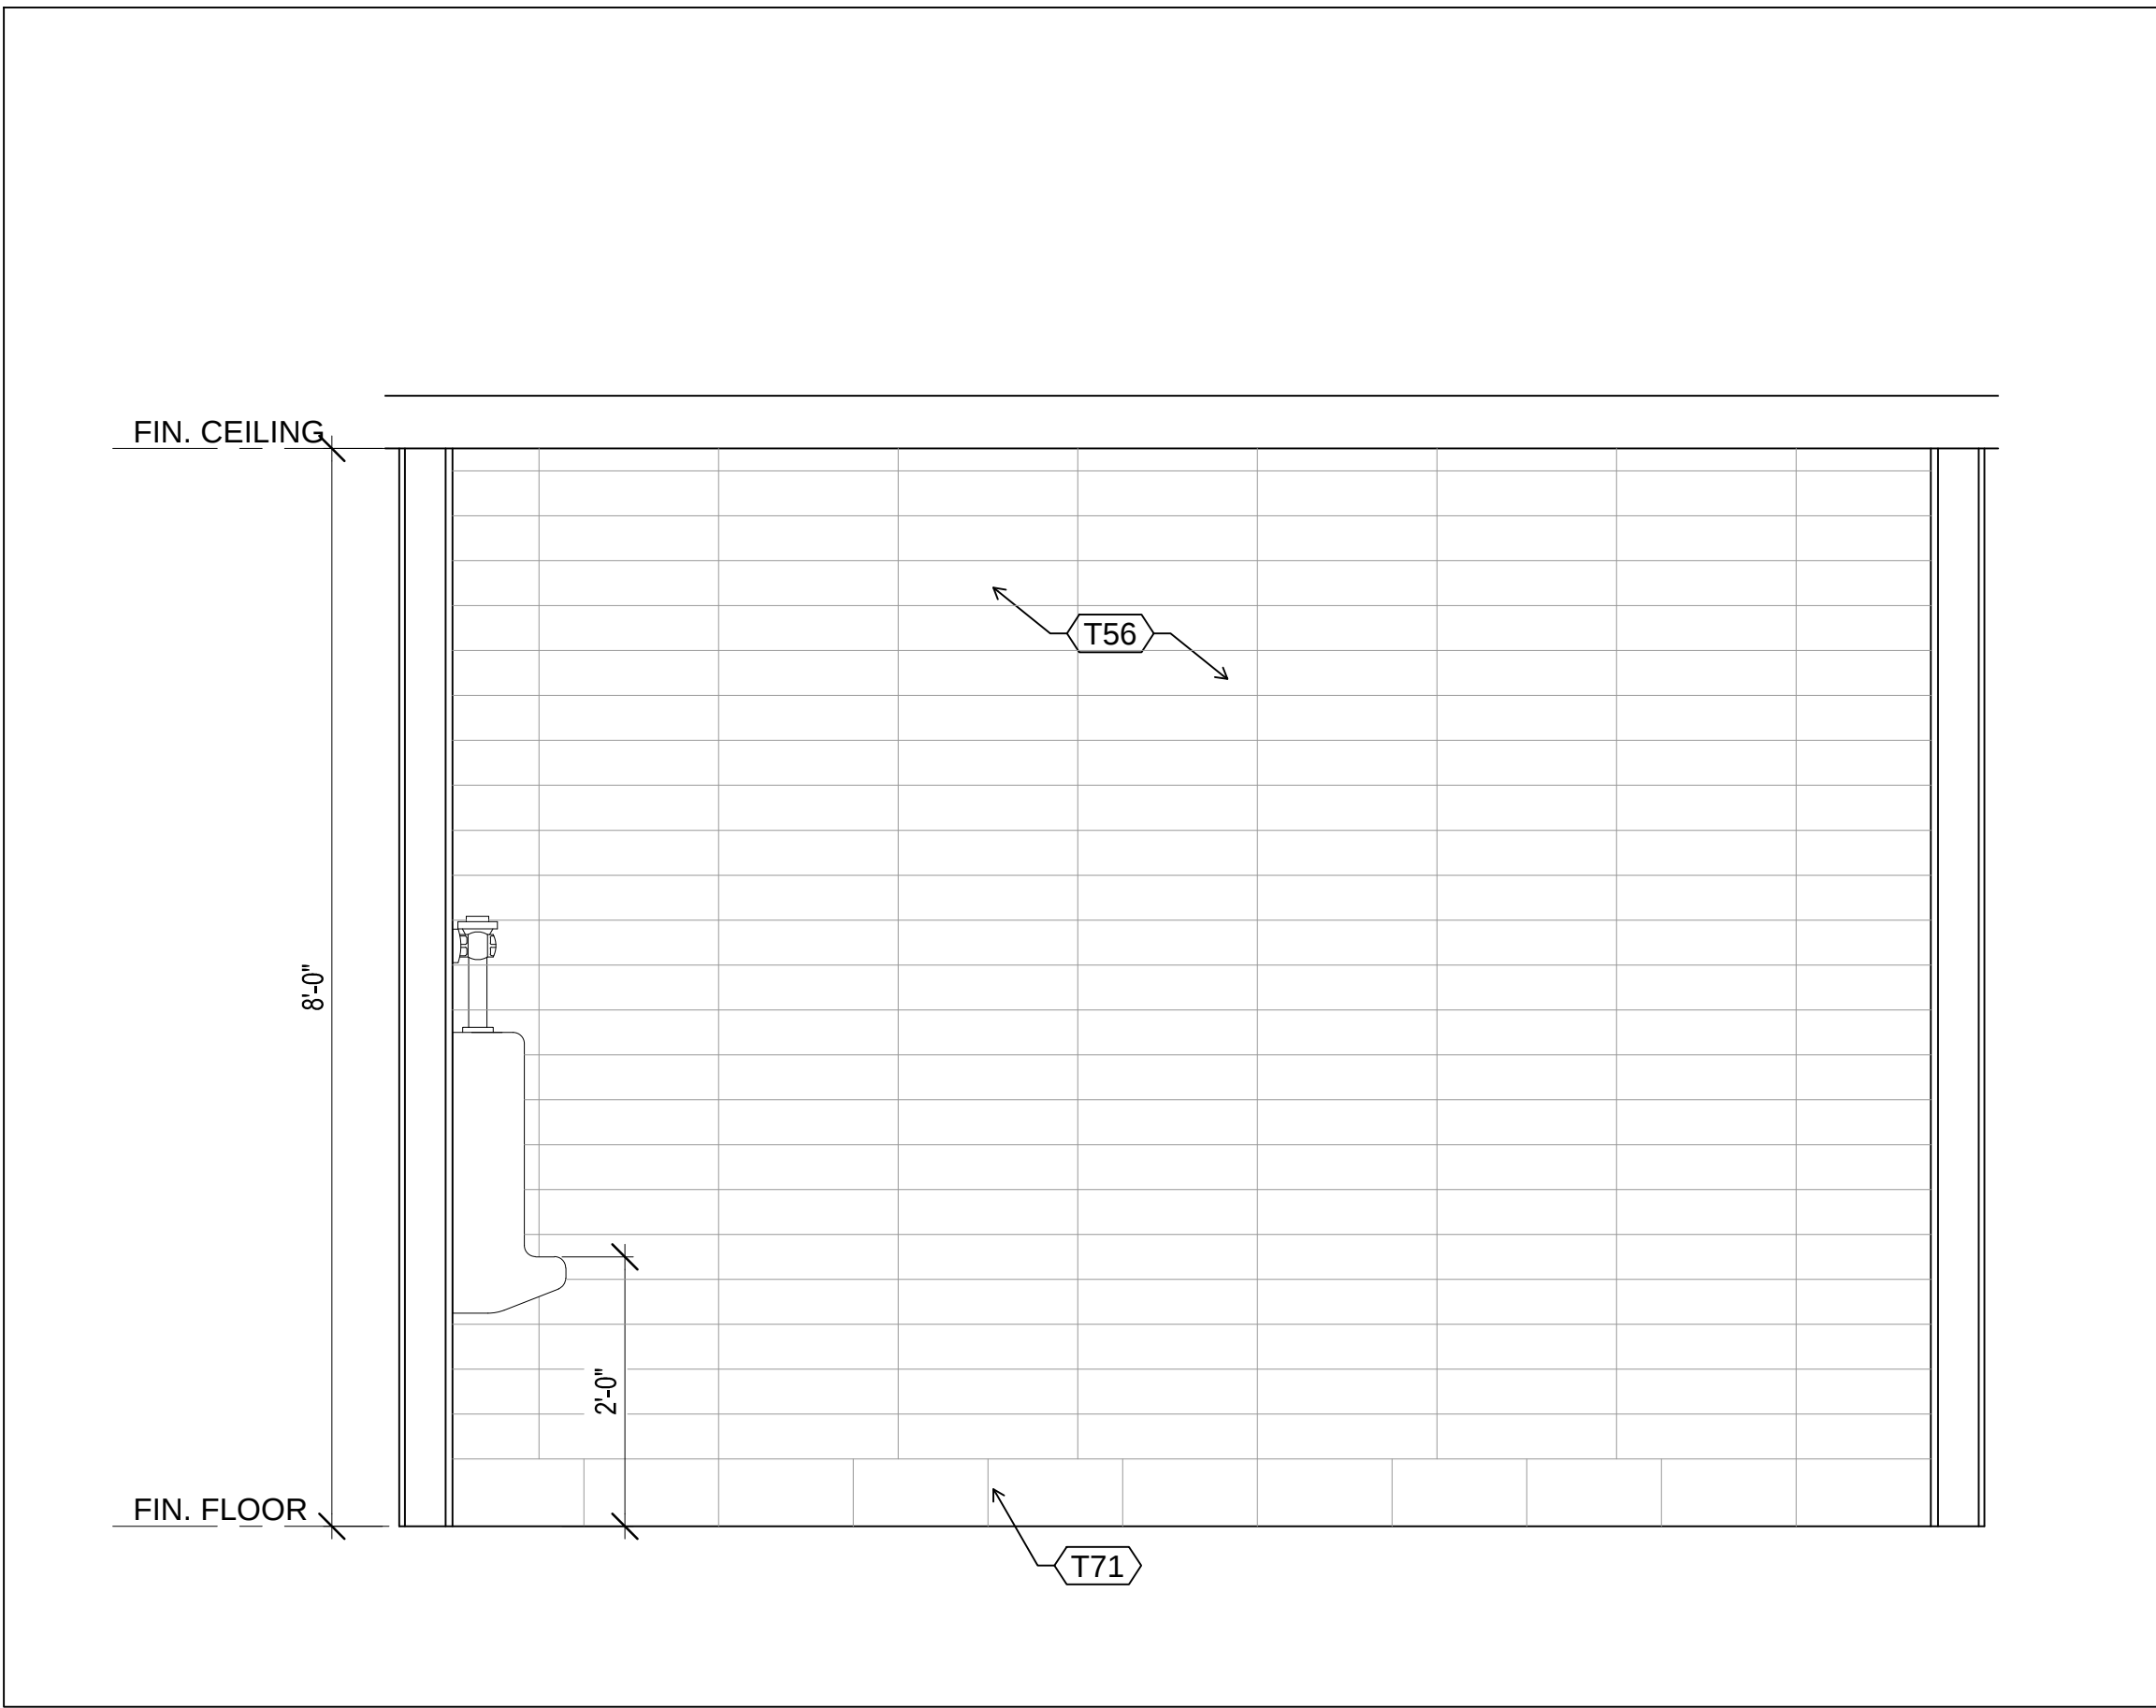
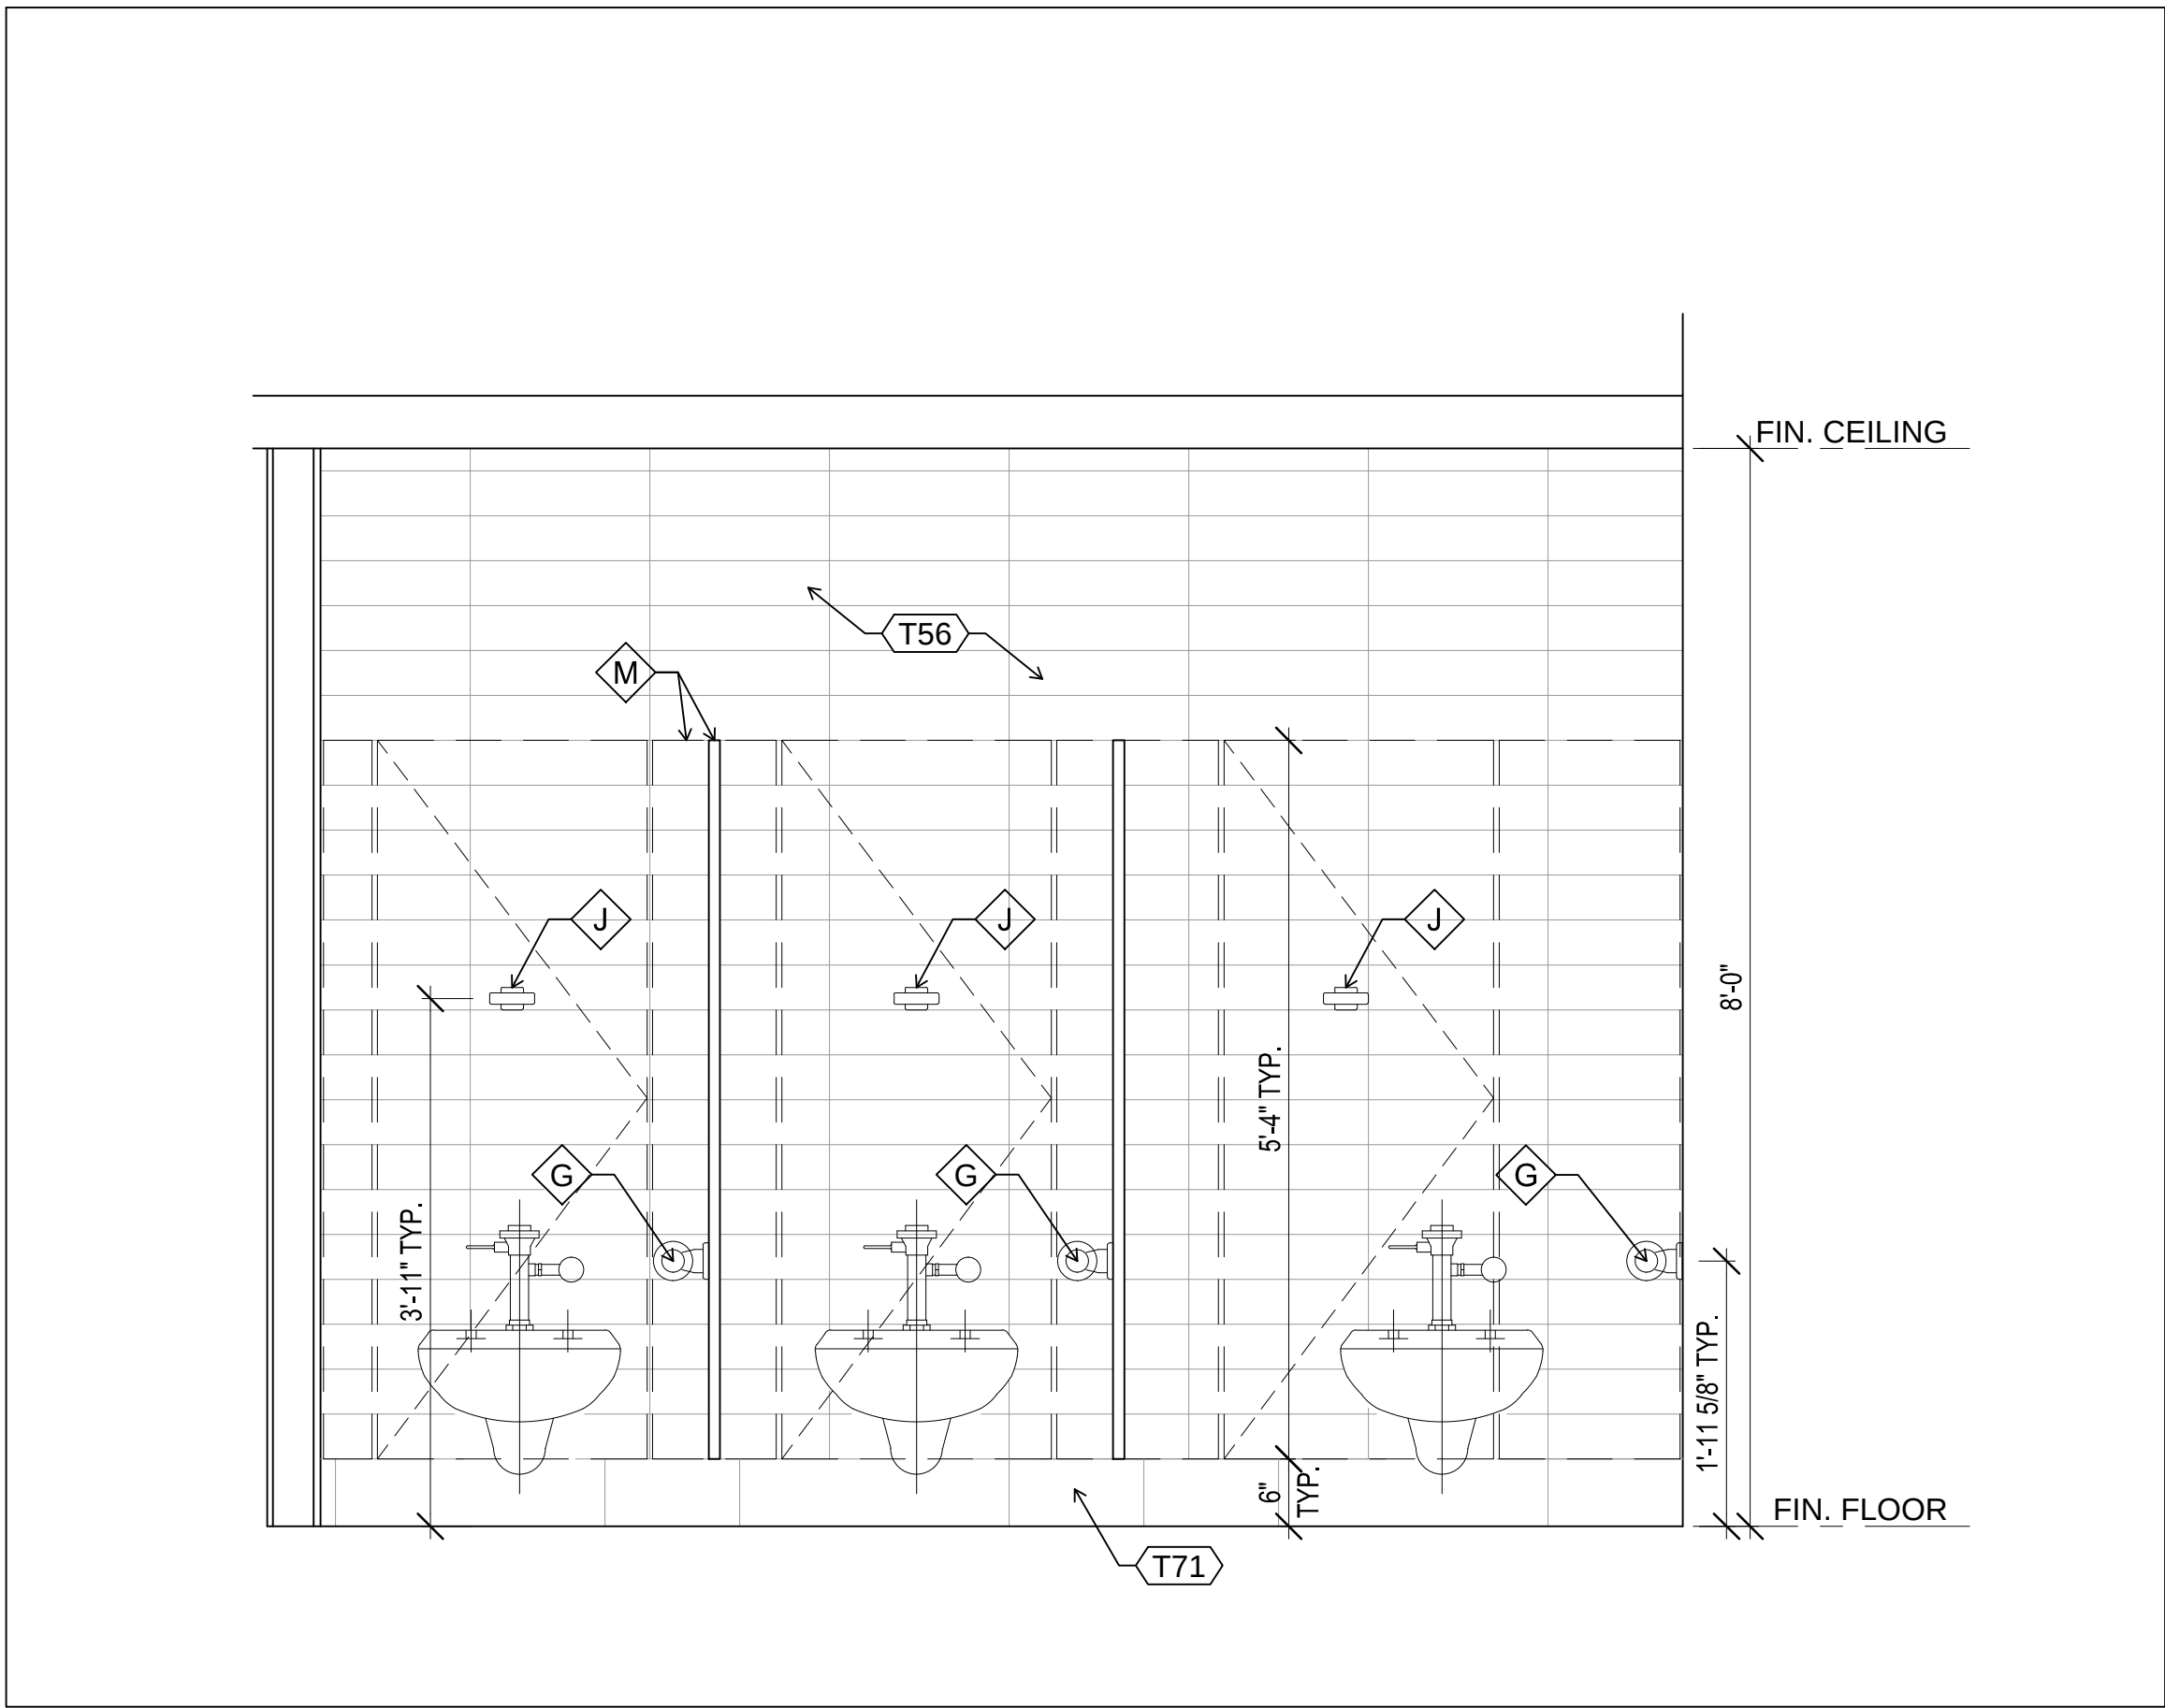


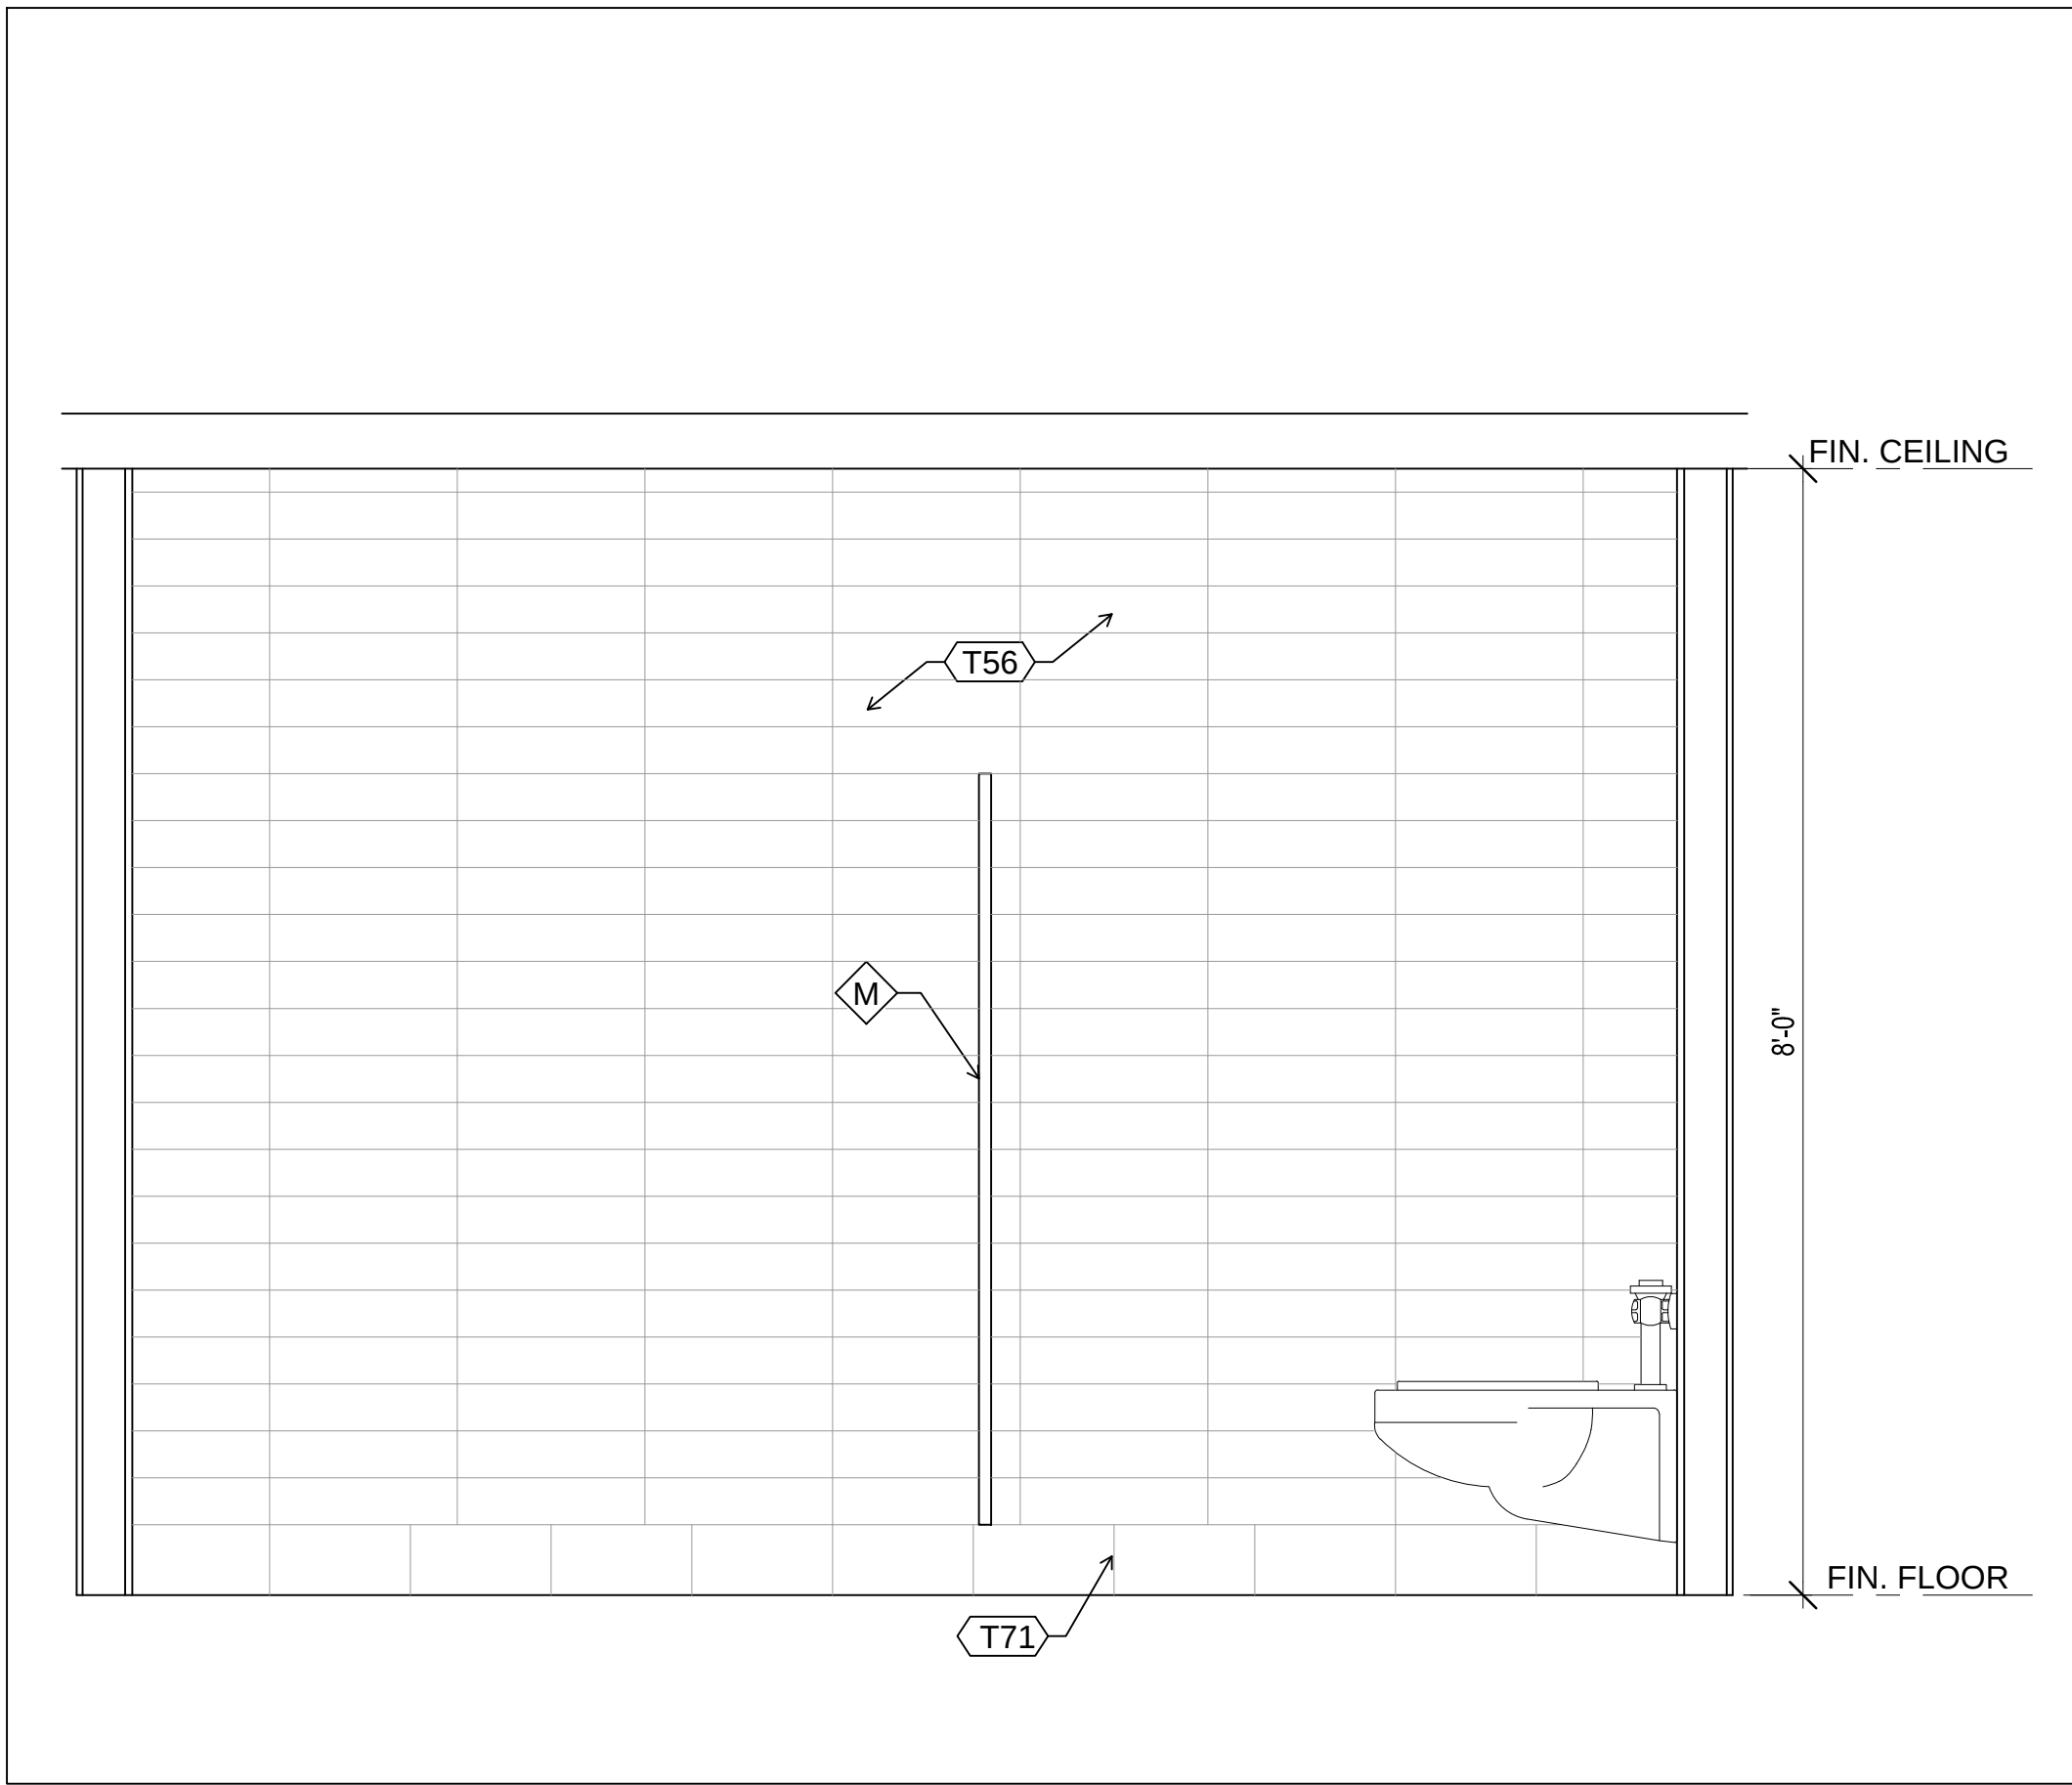

1. ALL WASHROOM ACCESSORIES SHALL BE MOUNTED AT HEIGHTS RECOMMENDED BY THE MANUFACTURERS AND TO MEET O.B.C. SECTION 3.8.

2. BARRIER FREE WASHROOMS SHALL CONFORM TO THE APPLICABLE ARTICLES OF O.B.C. SECTION 3.8

3. REFER TO FLOOR FINISH PLAN FOR FLOORING LEGEND AND NOTES.

4. REFER TO MECHANICAL SPECIFICATIONS FOR PLUMBING FIXTURE SCHEDULE AND FIXTURE SPECIFICATIONS.

5. WASHROOM MILLWORK AND ACCESSORIES ARE INCLUDED IN CONTRACT.

7 GENERAL NOTES
SCALE 1/2"=1'-0"

- A SURFACE MOUNTED DIAPER CHANGING STATION
SUPPLIED BY METRO AND INSTALLED BY GENERAL CONTRACTOR
- CONTRACTOR TO COORDINATE INSTALLATION WITH METRO
- B RESERVED
- C SOAP DISPENSER
SUPPLIED BY METRO AND INSTALLED BY GENERAL CONTRACTOR
- INSTALLED AS PER OBC 3.8.3.11 (1)(f)
- D 24" x 36" MIRROR BY BOBRICK
- E 24" x 36" TILT MIRROR BY BOBRICK #B293 2436
(AT BIF WASHROOM)
- F HAND DRYER
BY EXCEL DRYER XCELERATOR MODEL #XL-W
(AT BIF WASHROOM)
- G TOILET TISSUE DISPENSER BY CASCADES MODEL 4212
SUPPLIED BY METRO AND INSTALLED BY CONTRACTOR.
OBC 3.8.3.8 (1)(g)
- H STAINLESS STEEL GRAB BARS WITH SNAP FLANGE
- 24" AND 30" 1-1/2" DIAMETER BY BOBRICK MODEL #B-6808.
OBC 3.8.3.8 (1)(g)
- J SURFACE MOUNTED DOUBLE ROBE HOOK
BY BOBRICK MODEL #B-672
OBC 3.8.3.8 (1)(g)
- K RESERVED
- L PAPER TOWEL DISPENSER / DISPOSAL
BY METRO INSTALLED BY G.C.
- INSTALLED AS PER OBC 3.8.3.11 (1)(g)(p)
- M METAL WASHROOM PARTITIONS
COLOUR 124 PEARL GREY BY GSS, REFER TO DECOR DRAWINGS

9 WASHROOM ACCESSORIES
SCALE 1/2"=1'-0"

KEY PLAN:

ISSUED		
No.	DATE	DESCRIPTION
01	01/24/14	ISSUED FOR 40% REVIEW
02	02/14/14	ISSUED FOR 60% REVIEW
03	03/05/14	ISSUED FOR 100% REVIEW
04	04/14/14	ISSUED FOR PERMIT
05	04/28/14	ISSUED FOR TENDER
06	05/13/14	RE-ISSUED FOR TENDER
07	07/10/14	ISSUED FOR CONSTRUCTION
08		

REVISION		
No.	DATE	DESCRIPTION
01	05/20/14	ADDENDUM 1
02	06/20/14	POST TENDER ADDENDUM 01

NOTES

TRUE NORTH

CONSTRUCTION NORTH

DIMENSIONS AND CONDITIONS TO BE VERIFIED ON THE SITE

DO NOT SCALE THE DRAWINGS.

THE CONTRACTOR WILL CHECK AND VERIFY DIMENSIONS AND REPORT ERRORS AND OMISSIONS TO THE CONSULTANT.

THIS DRAWING WILL NOT BE USED FOR CONSTRUCTION PURPOSES UNTIL ISSUED FOR CONSTRUCTION BY THE CONSULTANT, WHOSE SIGNATURE IS BELOW.

ISSUED FOR CONSTRUCTION

DATE

SEAL

PAUL ARCHITECT INC.

TORONTO • VANCOUVER

2660 Sherwood Heights Dr. Suite 205, Oakville, Ontario, L6J 7Y9
www.paularchitect.com
(905)337-5890 fax (905)337-1586

CLIENT:

metro

PROJECT TITLE:

STORE #065
2208 LAKE SHORE BLVD. W
& PARK LAWN ROAD
TORONTO, ON

DRAWING TITLE:

ENLARGED WASHROOM PLANS
& INTERIOR ELEVATIONS

DRAWN BY:	CHECKED BY:	DRAWING NO.
BR	ML	A5.2

SCALE:	DATE:
AS NOTED	JAN 2014

PROJECT NO.	REV. NO.
1401137	