

## **Addendum 1**

### **Request for Quotation S25-5282 – AHU Replacement At Nahani Way PS**

**TO: ALL POTENTIAL BIDDERS**

**Question # 1:**

Please provide as built drawings for the existing duct for the entire school in order to provide an accurate price for the duct cleaning.

**Response:**

Please see attached as-built mechanical ventilation drawings for reference.

**Question # 2:**

Please provide base bid chemical treatment company contact info.

**Response:**

PDSB chemical treatment vendor is Rochester Midland. Please contact Dominick Rodigue <drodrigue@RochesterMidland.com> for information related to pricing.

All other terms and conditions shall remain the same.

Regards,  
Ron Sabha, Commodity Specialist  
Peel District School Board  
Tel. (905) 890.1010 x 2114  
E-mail: ron.sabha@peelsb.com







FAN SECTION										HEATING COIL SECTION										ACCESSORIES				WEIGHT											
UPS	ESP	TSP	MOD	FAN	ON	CES	ERT	PMN	BWP	VOL	PMG	MTR	TAG	HYT	RTY	PPF	TUR	WTH	WHI	EXT	Lat	ENT	WPO		UPS	MTD	WPO	BOX	ARY	AND	EAE	MEX	QTY		
AN-1	5,030	375	615	218	FC	22	S	63	74	1.7	208	3	7.5	H2-1	W	1	5F	94	Y	762	2515	139.7	-1.7	22.0	30.2	30.0	11.1	6.6	—	TA	125	YES	YES	LOW	936
AN-2	5,030	375	615	218	FC	22	S	60	1197	1.8	208	3	7.5	H2-2	W	1	5F	92	Y	762	2143	139.7	-1.6	22.0	30.2	30.0	11.1	6.6	—	TA	125	YES	YES	LOW	289
AN-3	5,030	375	615	218	FC	22	S	63	659	1.8	208	3	5.0	H2-3	W	1	5F	80	N	838	1296	30.3	14.4	22.0	30.2	37	0.64	11.1	—	TA	125	YES	YES	LOW	617
AN-4	1,025	200	—	—	—	—	—	—	1.2	208	3	2.0	H2-4	ELCC	—	—	—	—	—	—	—	—	—	—	—	—	—	—	—	—	—	YES	—	LOW	510

LEGEND	
1/2	1/2 IN. SUPPLY LINE
1/4	1/4 IN. SUPPLY LINE
1/8	1/8 IN. SUPPLY LINE
1/16	1/16 IN. SUPPLY LINE
1/32	1/32 IN. SUPPLY LINE
1/64	1/64 IN. SUPPLY LINE
1/128	1/128 IN. SUPPLY LINE
1/256	1/256 IN. SUPPLY LINE
1/512	1/512 IN. SUPPLY LINE
1/1024	1/1024 IN. SUPPLY LINE
1/2048	1/2048 IN. SUPPLY LINE
1/4096	1/4096 IN. SUPPLY LINE
1/8192	1/8192 IN. SUPPLY LINE
1/16384	1/16384 IN. SUPPLY LINE
1/32768	1/32768 IN. SUPPLY LINE
1/65536	1/65536 IN. SUPPLY LINE
1/131072	1/131072 IN. SUPPLY LINE
1/262144	1/262144 IN. SUPPLY LINE
1/524288	1/524288 IN. SUPPLY LINE
1/1048576	1/1048576 IN. SUPPLY LINE
1/2097152	1/2097152 IN. SUPPLY LINE
1/4194304	1/4194304 IN. SUPPLY LINE
1/8388608	1/8388608 IN. SUPPLY LINE
1/16777216	1/16777216 IN. SUPPLY LINE
1/33554432	1/33554432 IN. SUPPLY LINE
1/67108864	1/67108864 IN. SUPPLY LINE
1/134217728	1/134217728 IN. SUPPLY LINE
1/268435456	1/268435456 IN. SUPPLY LINE
1/536870912	1/536870912 IN. SUPPLY LINE
1/1073741824	1/1073741824 IN. SUPPLY LINE
1/2147483648	1/2147483648 IN. SUPPLY LINE
1/4294967296	1/4294967296 IN. SUPPLY LINE
1/8589934592	1/8589934592 IN. SUPPLY LINE
1/17179869184	1/17179869184 IN. SUPPLY LINE
1/34359738368	1/34359738368 IN. SUPPLY LINE
1/68719476736	1/68719476736 IN. SUPPLY LINE
1/137438953472	1/137438953472 IN. SUPPLY LINE
1/274877906944	1/274877906944 IN. SUPPLY LINE
1/549755813888	1/549755813888 IN. SUPPLY LINE
1/1099511627776	1/1099511627776 IN. SUPPLY LINE
1/2199023255552	1/2199023255552 IN. SUPPLY LINE
1/4398046511104	1/4398046511104 IN. SUPPLY LINE
1/8796093022208	1/8796093022208 IN. SUPPLY LINE
1/17592186044416	1/17592186044416 IN. SUPPLY LINE
1/35184372088832	1/35184372088832 IN. SUPPLY LINE
1/70368744177664	1/70368744177664 IN. SUPPLY LINE
1/140737488355328	1/140737488355328 IN. SUPPLY LINE
1/281474976710656	1/281474976710656 IN. SUPPLY LINE
1/562949953421312	1/562949953421312 IN. SUPPLY LINE
1/1125899906842624	1/1125899906842624 IN. SUPPLY LINE
1/2251799813685248	1/2251799813685248 IN. SUPPLY LINE
1/4503599627370496	1/4503599627370496 IN. SUPPLY LINE
1/9007199254740992	1/9007199254740992 IN. SUPPLY LINE
1/18014398509481984	1/18014398509481984 IN. SUPPLY LINE
1/36028797018963968	1/36028797018963968 IN. SUPPLY LINE
1/72057594037927936	1/72057594037927936 IN. SUPPLY LINE
1/144115188075855872	1/144115188075855872 IN. SUPPLY LINE
1/288230376151711744	1/288230376151711744 IN. SUPPLY LINE
1/576460752303423488	1/576460752303423488 IN. SUPPLY LINE
1/1152921504606846976	1/1152921504606846976 IN. SUPPLY LINE
1/2305843009213693952	1/2305843009213693952 IN. SUPPLY LINE
1/4611686018427387904	1/4611686018427387904 IN. SUPPLY LINE
1/9223372036854775808	1/9223372036854775808 IN. SUPPLY LINE
1/18446744073709551616	1/18446744073709551616 IN. SUPPLY LINE
1/36893488147419103232	1/36893488147419103232 IN. SUPPLY LINE
1/73786976294838206464	1/73786976294838206464 IN. SUPPLY LINE
1/147573952589676412928	1/147573952589676412928 IN. SUPPLY LINE
1/295147905179352825856	1/295147905179352825856 IN. SUPPLY LINE
1/590295810358705651712	1/590295810358705651712 IN. SUPPLY LINE
1/1180591620717411303424	1/1180591620717411303424 IN. SUPPLY LINE
1/2361183241434822606848	1/2361183241434822606848 IN. SUPPLY LINE
1/4722366482869645213696	1/4722366482869645213696 IN. SUPPLY LINE
1/9444732965739290427392	1/9444732965739290427392 IN. SUPPLY LINE
1/18889465931478580854784	1/18889465931478580854784 IN. SUPPLY LINE
1/37778931862957161709568	1/37778931862957161709568 IN. SUPPLY LINE
1/75557863725914323419136	1/75557863725914323419136 IN. SUPPLY LINE
1/151115727451828646838272	1/151115727451828646838272 IN. SUPPLY LINE
1/3022314549036	1/3022314549036 IN. SUPPLY LINE
1/6044629098072	1/6044629098072 IN. SUPPLY LINE
1/12089258196144	1/12089258196144 IN. SUPPLY LINE
1/24178516392288	1/24178516392288 IN. SUPPLY LINE
1/48357032784576	1/48357032784576 IN. SUPPLY LINE
1/96714065569152	1/96714065569152 IN. SUPPLY LINE
1/193428131138304	1/193428131138304 IN. SUPPLY LINE
1/386856262276608	1/386856262276608 IN. SUPPLY LINE
1/773712524553216	1/773712524553216 IN. SUPPLY LINE
1/1547425049106432	1/1547425049106432 IN. SUPPLY LINE
1/3094850098212864	1/3094850098212864 IN. SUPPLY LINE
1/6189700196425728	1/6189700196425728 IN. SUPPLY LINE
1/12379400392851456	1/12379400392851456 IN. SUPPLY LINE
1/24758800785702912	1/24758800785702912 IN. SUPPLY LINE
1/49517601571405824	1/49517601571405824 IN. SUPPLY LINE
1/99035203142811648	1/99035203142811648 IN. SUPPLY LINE
1/198070406285623296	1/198070406285623296 IN. SUPPLY LINE
1/396140812571246592	1/396140812571246592 IN. SUPPLY LINE
1/792281625142493184	1/792281625142493184 IN. SUPPLY LINE
1/1584563250284986368	1/1584563250284986368 IN. SUPPLY LINE
1/3169126500569972736	1/3169126500569972736 IN. SUPPLY LINE
1/6338253001139945472	1/6338253001139945472 IN. SUPPLY LINE
1/12676506002279890944	1/12676506002279890944 IN. SUPPLY LINE
1/25353012004559781888	1/25353012004559781888 IN. SUPPLY LINE
1/50706024009119563776	1/50706024009119563776 IN. SUPPLY LINE
1/101412048018239127552	1/101412048018239127552 IN. SUPPLY LINE
1/202824096036478255104	1/202824096036478255104 IN. SUPPLY LINE
1/405648192072956510208	1/405648192072956510208 IN. SUPPLY LINE
1/811296384145913020416	1/811296384145913020416 IN. SUPPLY LINE
1/1622592768291826040832	1/1622592768291826040832 IN. SUPPLY LINE
1/3245185536583652081664	1/3245185536583652081664 IN. SUPPLY LINE
1/6490371073167304163328	1/6490371073167304163328 IN. SUPPLY LINE
1/12980742146334608326656	1/12980742146334608326656 IN. SUPPLY LINE
1/25961484292669216653312	1/25961484292669216653312 IN. SUPPLY LINE
1/51922968585338433306624	1/51922968585338433306624 IN. SUPPLY LINE
1/103845937170676866613248	1/103845937170676866613248 IN. SUPPLY LINE
1/207691874341353733226496	1/207691874341353733226496 IN. SUPPLY LINE
1/415383748682707466452992	1/415383748682707466452992 IN. SUPPLY LINE
1/830767497365414932905984	1/830767497365414932905984 IN. SUPPLY LINE
1/1661534994730829865811968	1/1661534994730829865811968 IN. SUPPLY LINE
1/3323069989461659731623936	1/3323069989461659731623936 IN. SUPPLY LINE
1/6646139978923319463247872	1/6646139978923319463247872 IN. SUPPLY LINE
1/13292279957846638926495744	1/13292279957846638926495744 IN. SUPPLY LINE
1/26584559915693277852991488	1/26584559915693277852991488 IN. SUPPLY LINE
1/53169119831386555705982976	1/53169119831386555705982976 IN. SUPPLY LINE
1/106338239662773111411965952	1/106338239662773111411965952 IN. SUPPLY LINE
1/212676479325546222823931904	1/212676479325546222823931904 IN. SUPPLY LINE
1/425352958651092445647863808	1/425352958651092445647863808 IN. SUPPLY LINE
1/850705917302184891295727616	1/850705917302184891295727616 IN. SUPPLY LINE
1/1701411834604369782591455232	1/1701411834604369782591455232 IN. SUPPLY LINE
1/3402823669208739565182910464	1/3402823669208739565182910464 IN. SUPPLY LINE
1/6805647338417479130365820928	1/6805647338417479130365820928 IN. SUPPLY LINE
1/13611294676834958260731641856	1/13611294676834958260731641856 IN. SUPPLY LINE
1/27222589353669916521463283712	1/27222589353669916521463283712 IN. SUPPLY LINE
1/54445178707339833042926567424	1/54445178707339833042926567424 IN. SUPPLY LINE
1/108890357414679666085853134848	1/108890357414679666085853134848 IN. SUPPLY LINE
1/217780714829359332171706269696	1/217780714829359332171706269696 IN. SUPPLY LINE
1/435561429658718664343412539392	1/435561429658718664343412539392 IN. SUPPLY LINE
1/871122859317437328686825078784	1/871122859317437328686825078784 IN. SUPPLY LINE
1/1742245718634874657373650157568	1/1742245718634874657373650157568 IN. SUPPLY LINE
1/3484491437269749314747300315136	1/3484491437269749314747300315136 IN. SUPPLY LINE
1/6968982874539498629494600630272	1/6968982874539498629494600630272 IN. SUPPLY LINE
1/13937965749078997258989201260544	1/13937965749078997258989201260544 IN. SUPPLY LINE
1/27875931498157994517978402521088	1/27875931498157994517978402521088 IN. SUPPLY LINE
1/55751862996315989035956805042176	1/55751862996315989035956805042176 IN. SUPPLY LINE
1/111503725992631978071913610084352	1/111503725992631978071913610084352 IN. SUPPLY LINE
1/223007451985263956143827220168704	1/223007451985263956143827220168704 IN. SUPPLY LINE
1/446014903970527912287654440337408	1/446014903970527912287654440337408 IN. SUPPLY LINE
1/892029807941055824575308880674816	1/892029807941055824575308880674816 IN. SUPPLY LINE
1/1784059615882111649150617761349632	1/1784059615882111649150617761349632 IN. SUPPLY LINE
1/3568119231764223298301235522699264	1/3568119231764223298301235522699264 IN. SUPPLY LINE
1/7136238463528446596602471045398528	1/7136238463528446596602471045398528 IN. SUPPLY LINE
1/14272476927056893193204942090797056	1/14272476927056893193204942090797056 IN. SUPPLY LINE
1/28544953854113786386409884181594112	1/28544953854113786386409884181594112 IN. SUPPLY LINE
1/57089907708227572772819768363188224	1/57089907708227572772819768363188224 IN. SUPPLY LINE
1/114179815416455145545639536726376448	1/114179815416455145545639536726376448 IN. SUPPLY LINE
1/228359630832910291091279073452752896	1/228359630832910291091279073452752896 IN. SUPPLY LINE
1/456719261665820582182558146905505792	1/456719261665820582182558146905505792 IN. SUPPLY LINE
1/913438523331641164365116293811011584	1/913438523331641164365116293811011584 IN. SUPPLY LINE
1/1826877046663282328730232587622023168	1/1826877046663282328730232587622023168 IN. SUPPLY LINE
1/3653754093326564657460465175244046336	1/3653754093326564657460465175244046336 IN. SUPPLY LINE
1/7307508186653129314920930350488092672	1/7307508186653129314920930350488092672 IN. SUPPLY LINE
1/14615016373306258629841860700976185344	1/14615016373306258629841860700976185344 IN. SUPPLY LINE
1/29230032746612517259683721401952370688	1/29230032746612517259683721401952370688 IN. SUPPLY LINE
1/58460065493225034519367442803904741376	1/58460065493225034519367442803904741376 IN. SUPPLY LINE
1/116920130986450069038734885607809482752	1/116920130986450069038734885607809482752 IN. SUPPLY LINE
1/233840261972900138077469771215618965504	1/233840261972900138077469771215618965504 IN. SUPPLY LINE
1/467680523945800276154939542431237931008	1/467680523945800276154939542431237931008 IN. SUPPLY LINE
1/935361047891600552309879084862475862016	1/935361047891600552309879084862475862016 IN. SUPPLY LINE
1/1870722095783201104619758169724951724032	1/1870722095783201104619758169724951724032 IN. SUPPLY LINE
1/3741444191566402209239516339449903448064	1/3741444191566402209239516339449903448064 IN. SUPPLY LINE
1/7482888383132804418479032678899806896128	1/7482888383132804418479032678899806896128 IN. SUPPLY LINE
1/14965776766265608836958065357799613792256	1/14965776766265608836958065357799613792256 IN. SUPPLY LINE
1/29931553532531217673916130715599227584512	1/29931553532531217673916130715599227584512 IN. SUPPLY LINE
1/59863107065062435347832261431198455169024	1/59863107065062435347832261431198455169024 IN. SUPPLY LINE
1/119726214130124870695664522862396910338048	1/119726214130124870695664522862396910338048 IN. SUPPLY LINE
1/239452428260249741391329045724793820676096	1/239452428260249741391329045724793820676096 IN. SUPPLY LINE
1/478904856520499482782658091449587641352192	1/478904856520499482782658091449587641352192 IN. SUPPLY LINE
1/957809713040998965565316182899175282704384	1/957809713040998965565316182899175282704384 IN. SUPPLY LINE
1/1915619426081997931130632365798350565408768	1/1915619426081997931130632365798350565408768 IN. SUPPLY LINE
1/3831238852163995862261264731596701130817536	1/3831238852163995862261264731596701130817536 IN. SUPPLY LINE
1/7662477704327991724522529463193402261635072	1/7662477704327991724522529463193402261635072 IN. SUPPLY LINE
1/15324955408655983449045058926386804523270144	1/15324955408655983449045058926386804523270144 IN. SUPPLY LINE
1/30649910817311966898090117852773609046540288	1/30649910817311966898090117852773609046540288 IN. SUPPLY LINE
1/61299821634623933796180235705547218093080576	1/61299821634623933796180235705547218093080576 IN. SUPPLY LINE
1/122599643269247867592360471411094436186161152	1/122599643269247867592360471411094436186161152 IN. SUPPLY LINE
1/245199286538495735184720942822188872372322304	1/245199286538495735184720942822188872372322304 IN. SUPPLY LINE
1/490398573076991470369441885644377744744644608	1/

[illegible]

		SOUND PRESSURE LEVEL									
		140	125	250	500	1000	2000	4000	8000		
A1-1	94	87	83	79	77	72	67				
A1-2	98	90	86	82	78	65	59				
A2-1	92	82	86	82	78	76	71				
A4-4	88	80	80	76	72	66	65				
R1-1	93.1	80.9	77.7	72.6	66.7	62.5	57.5				
R2-2	85.1	71.1	71.1	67.1	66.1	61.1	56.1				
R3-3	83.7	81.7	78.4	73.3	67.4	63.1	58.1				
E1-1	92.5	81.5	77.6	73.4	68.9	64.3	58.4				
E2-2	74.9	80.0	71.1	64.6	57.3	49.0	43.7				

T/c	125	250	500	1000	2000	4000	8000
Al-1	94	87	83	79	77	72	67
Al-2	88	80	76	72	68	65	59
Al-3	92	86	82	78	76	71	65
Al-4	88	80	76	72	68	65	59
Rf-1	83.1	80.9	77.7	72.6	66.7	62.5	57.5
Rf-2	68	71	71	71	66	61	58
Rf-3	83.7	81.7	78.4	73.3	67.4	63.1	56.1
Ep-1	82.5	81.5	77.6	73.4	68.9	64.3	58.4
Ep-2	74.9	80.0	71.7	64.6	57.3	49.0	43.7

LEGEND	TAG	EQUIPMENT IDENTIFICATION
	125	dB @ 125 Hz
	250	dB @ 250 Hz
	500	dB @ 500 Hz
	1000	dB @ 1000 Hz
	2000	dB @ 2000 Hz
	4000	dB @ 4000 Hz
	8000	dB @ 8000 Hz

 
DISCHARGE COMPONENT FOR AIR HANDLING UNITS

TAG	UPS	QUT	NOT	WOT	125	250	400
SL-1	5,030	2.2	600	1200	26	27	100
SL-2	1,520	2.0	600	600	20	100	200
SL-3	1,520	1.5	600	1000	5	16	100
SL-4	3,210	1.7	600	800	24	26	100
SL-5	2,525	1.8	600	600	20	26	100
SL-6	2,137	1.8	600	700	20	26	100
SL-7	1,600	1.5	600	600	15	22	100
SL-8	4,030	1.8	250	1300	20	100	200
SL-9	1,520	2.1	250	500	20	100	200
SL-10	565	1.5	400	400	20	100	200
SL-11	700	1.5	400	400	7	20	100

Tag	UPS	LOT	HQT	WQT	250	400
SL-1	5,030	2,2	600	1200	26	27
SL-2	1,520	20	600	600	20	20
SL-3	1,520	15	600	1000	5	16
SL-4	3,220	1,7	600	800	24	26
SL-5	2,515	1,8	600	700	20	26
SL-6	2,737	1,8	600	600	20	26
SL-7	1,400	15	400	600	15	22
SL-8	1,030	1,8	250	1000	20	20
SL-9	475	2,1	250	500	20	100
SL-10	555	2,1	250	500	20	100
SL-11	700	1,5	400	400	7	20

LEGEND	
TAG	EQUIPMENT IDENTIFICATION
APF	AIR FLOW, l/s
LG1	LENGTH, m
LG2	LENGTH, mm
WGT	WEIGHT, kg
WOT	WOT
250	INSERTION LOSS @ 125 Hz, dB
125	INSERTION LOSS @ 250 Hz, dB
APD	MAXIMUM AIR PRESSURE DROP, Pa

DIMENSIONS OF SILENCERS SHALL BE COORDINATED ON SITE WITH THE SUPPLIER OF SILENCERS AND ADJUSTED AS REQUIRED TO ACHIEVE DESIGN SOUND POWER INSERTION LOSS AS REQUIRED.

[illegible]

AS NOTED	89111	J.JAKOB CZYK
DATE 1990 05 24	9022	
DRAWN	M.BORAGINA	CHECKED

MOTORIZED DAMPER  
SUPPLIED BY DIV.17  
INSTALLED BY THIS  
CONTRACTOR

EXTEND 500x300  
DUCT TO 150mm  
ABOVE FINISHED FLOOR—  
PROVIDE INSECT SCREEN

AIROLITE MODEL K6774  
FREE AREA MIN 50%  
INSTALL AS HIGH AS POSSIBLE  
BY GENERAL TRADES

AIROLITE MODEL K6774  
FREE AREA MIN 50%  
TOP @ 3400mm A.F.F.

100mm HAUSKEEPING  
PAID BY GEN. TRACES

[illegible]

RF-2

ALL EQUIPMENT  
TO BE SUPPLIED  
BY THIS CONTRACTOR  
CURB INSTALL

SECTION C - C  
SCALE 1 : 50

ROOF EXHAUSTER (EF-3,EF-4,EF-7,EF-8,EF-9)

SCALE: N.T.S.

FOR CONTINUATION REFER TO CONTINUATION PAGE.

SECTION A - A


SECTION B - B  
SCALE 1 : 50

SCALE 1 - 50


FIRE RATED CEILING DIFFUSER DETAIL  
SCALE: 1/8" = 1'-0"

2000




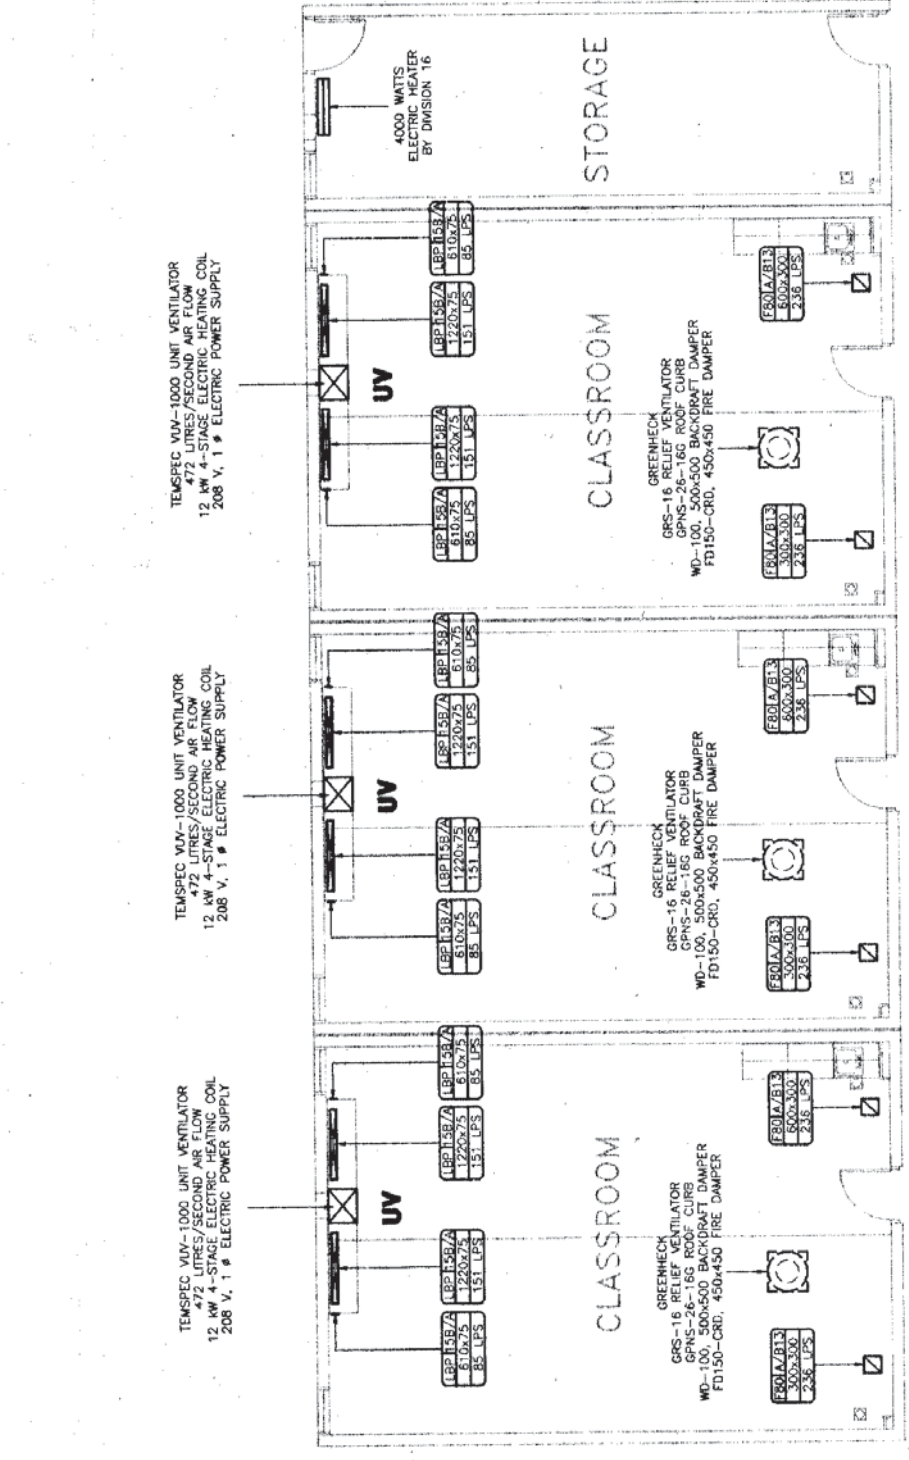


MECHANICAL FLOOR PLAN - SIDE OF SCHOOL  
SCALE 1:100

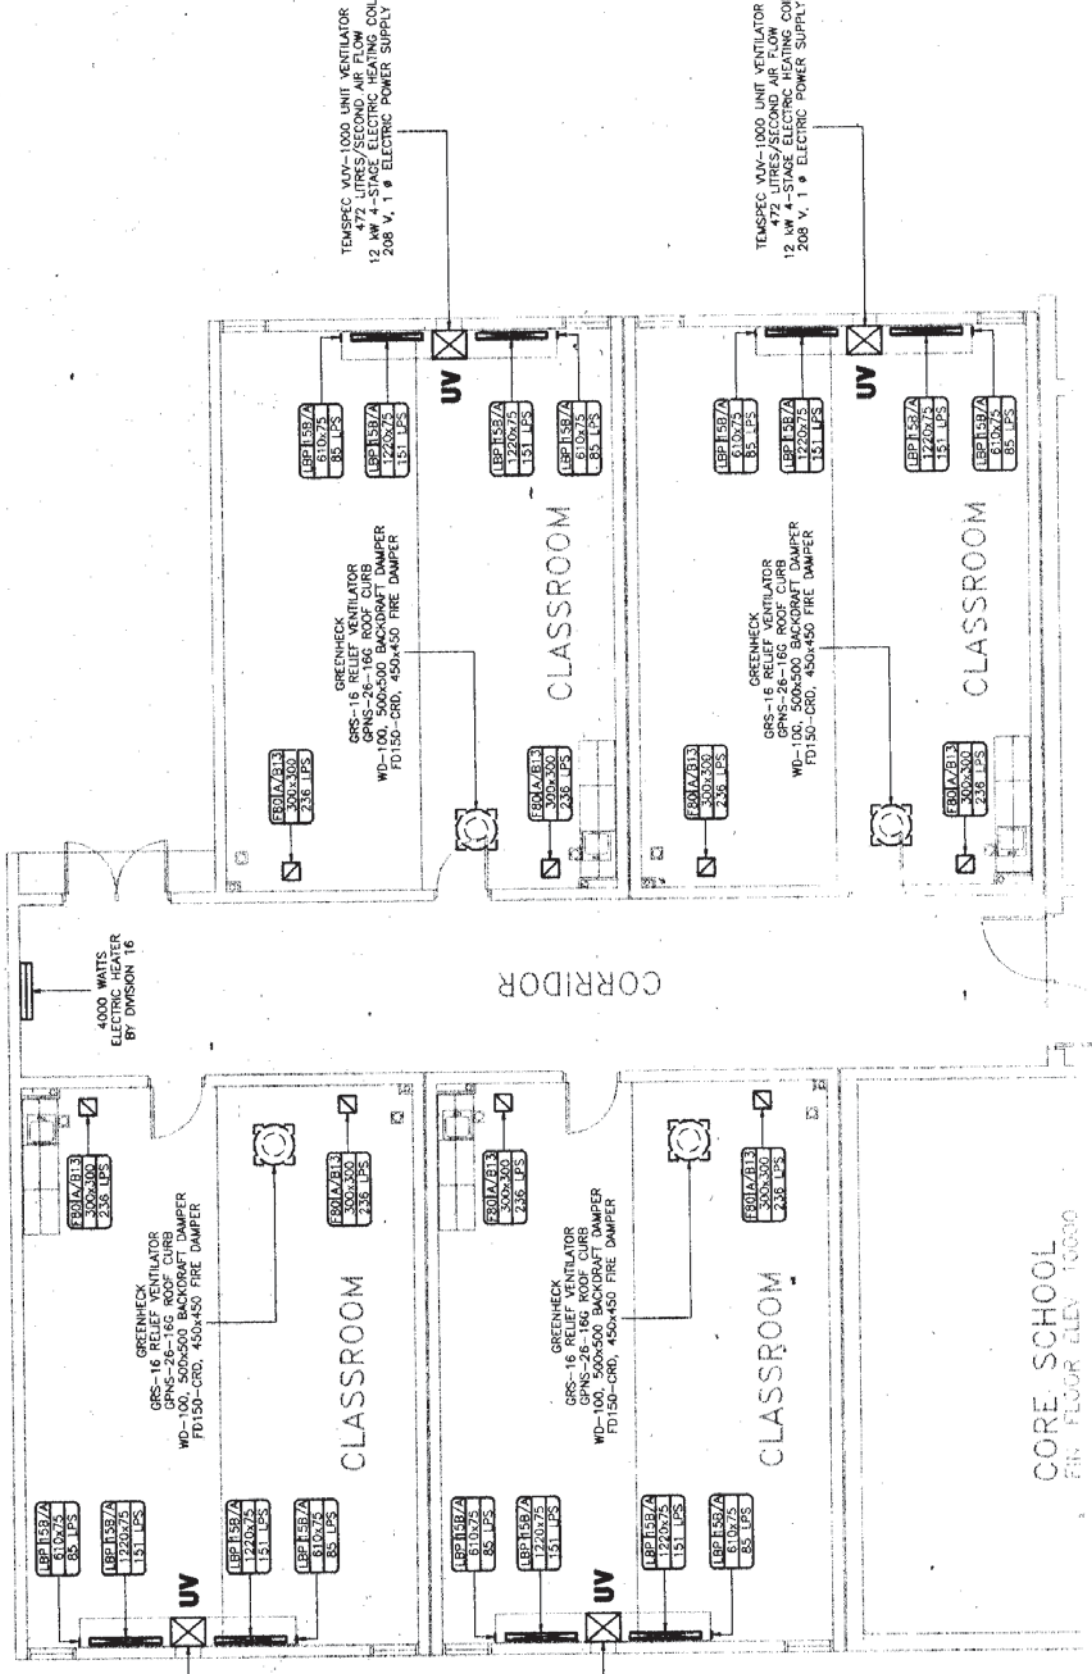

MECHANICAL FLOOR PLAN - REAR OF SCHOOL  
SCALE 1:100

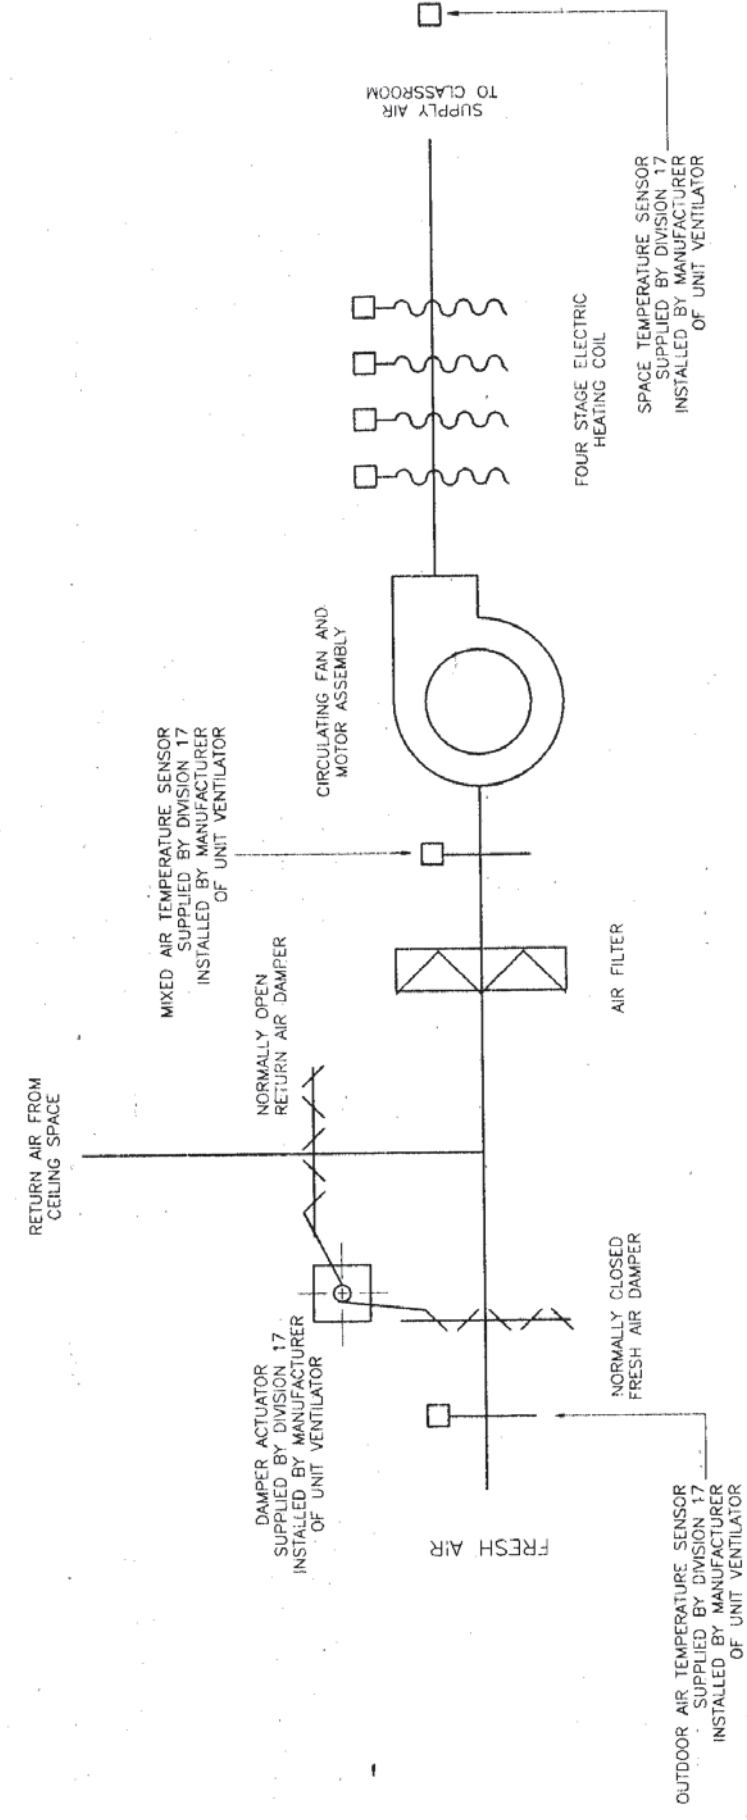

UV UNIT VENTILATOR - FUNCTIONAL DIAGRAM  
N.T.S.

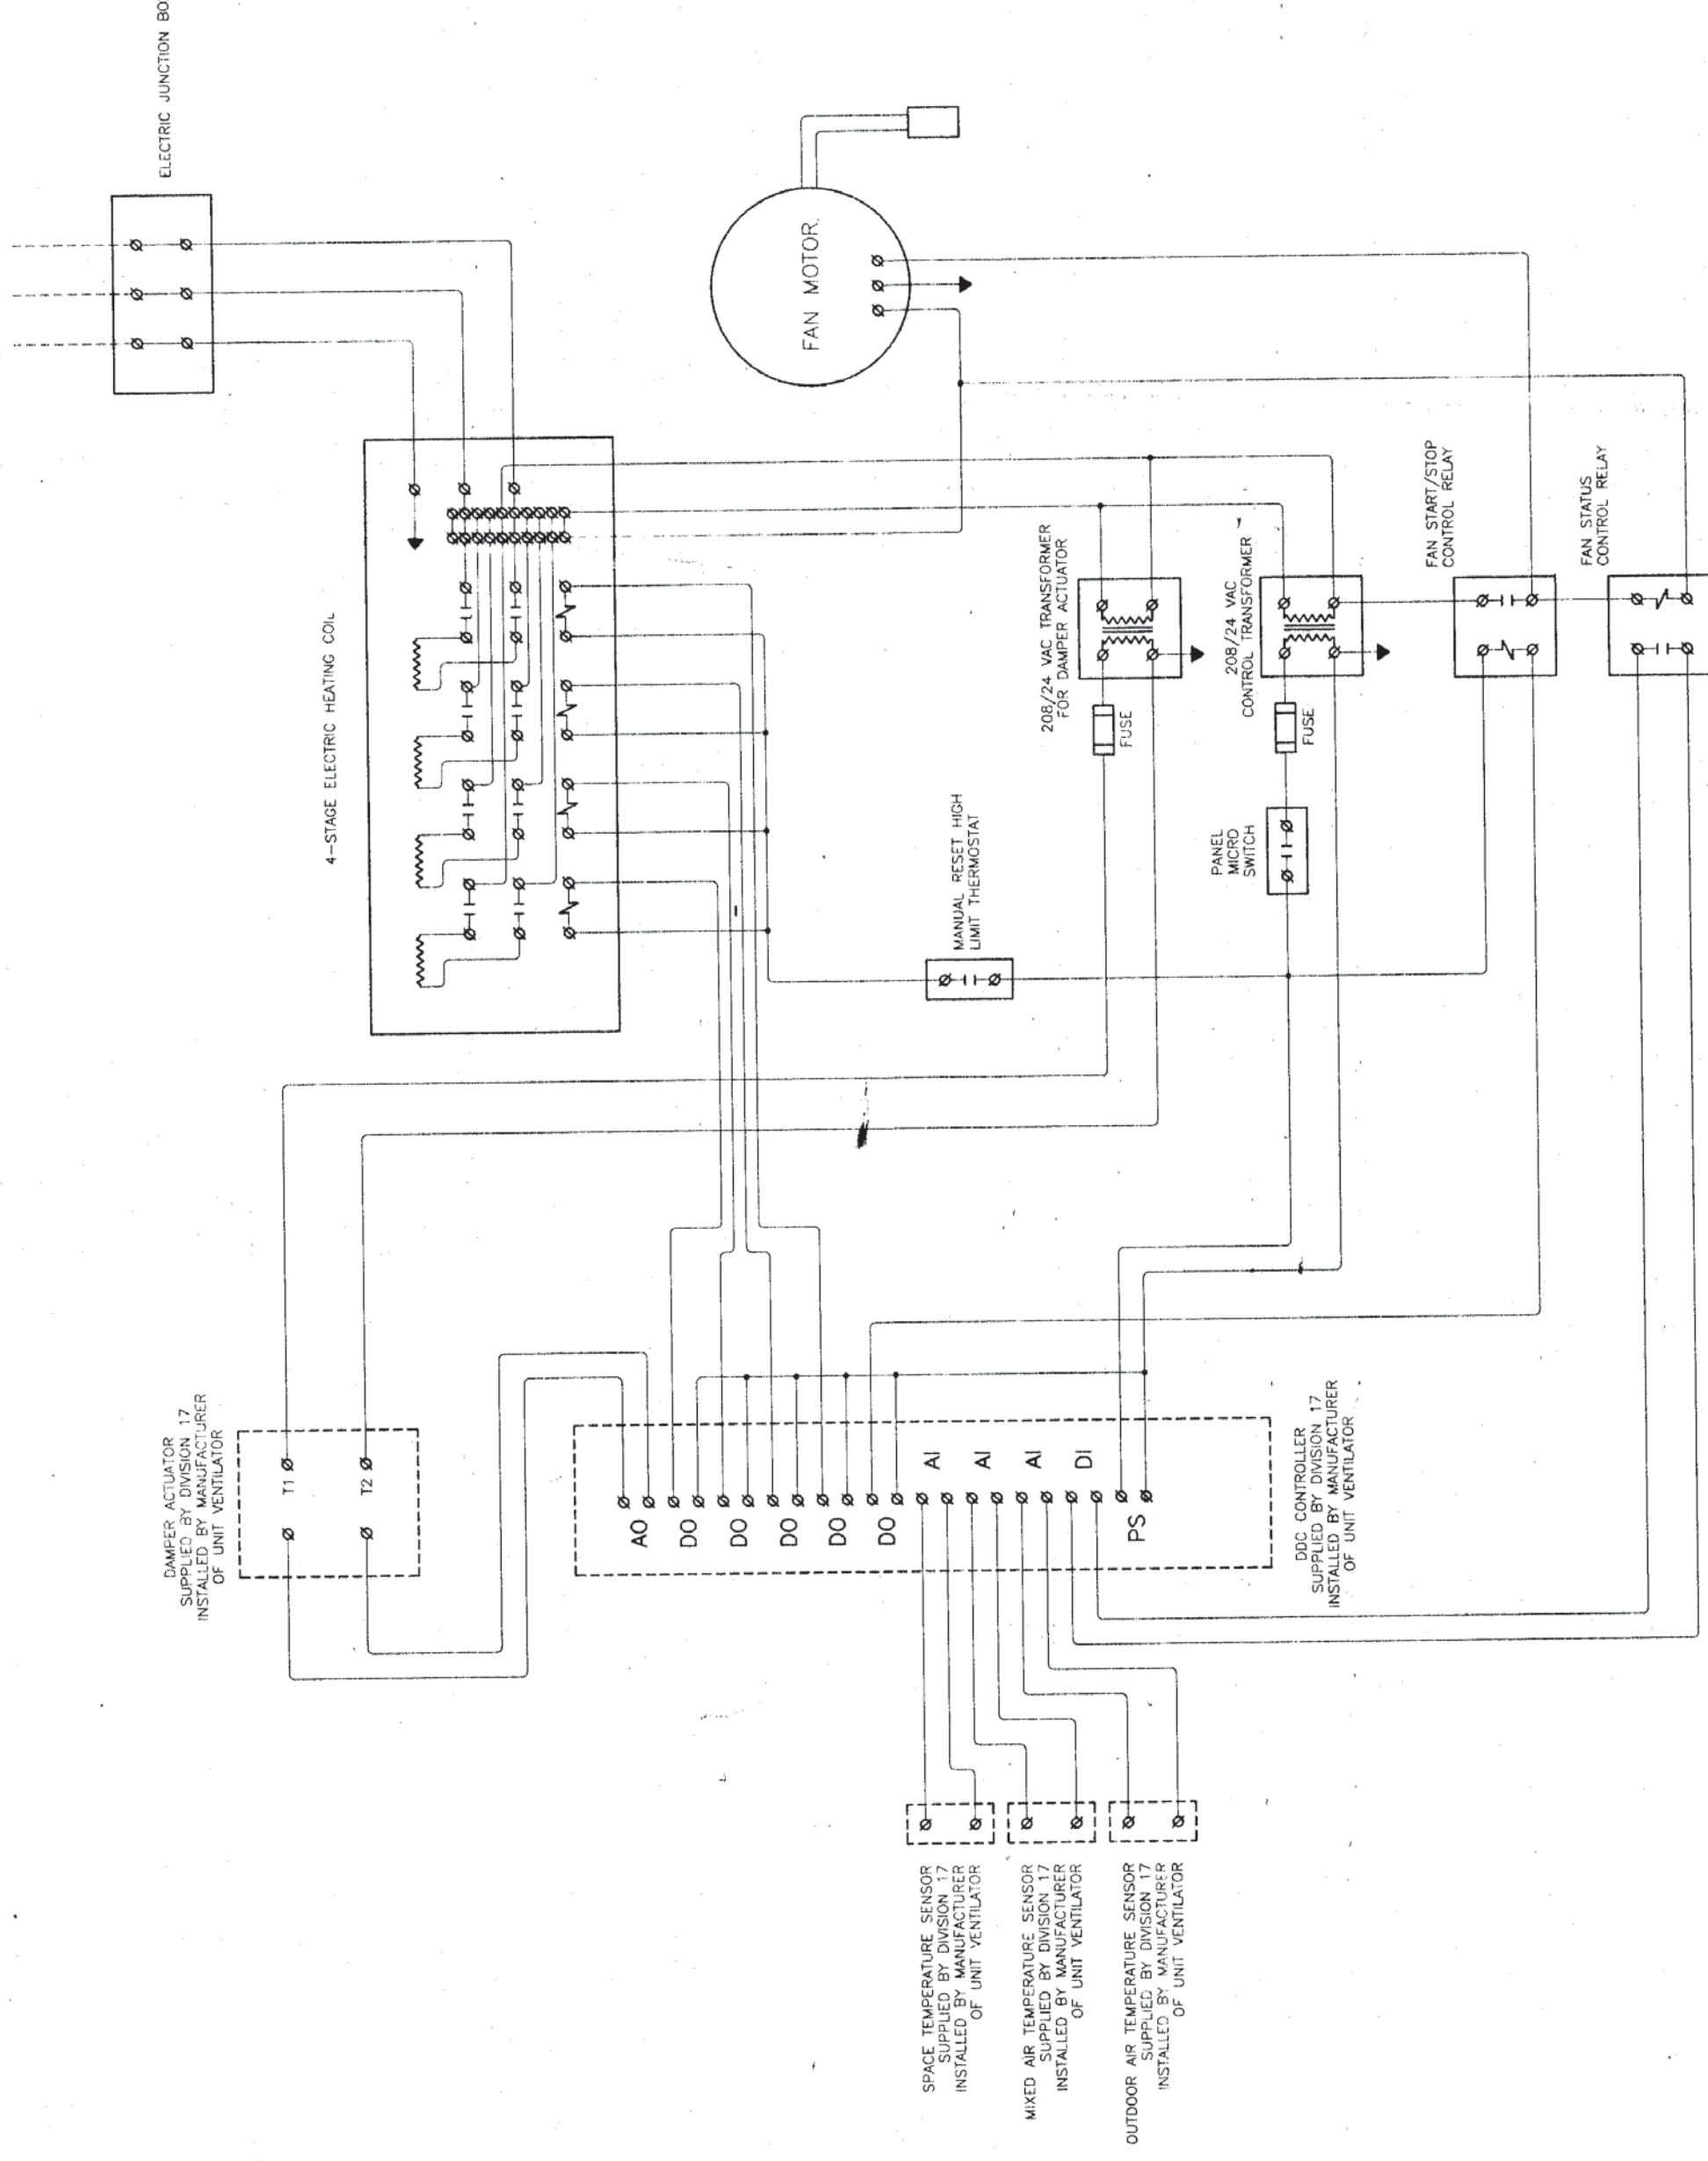

DIRECT DIGITAL CONTROL SCHEMATIC  
N.T.S.

INCRA-PAK UNITS: HEATING & VENTILATION

V3

NO.	DESCRIPTION	DATE

REVISIONS/DRAWING ISSUE

CONTRACTOR TO CHECK AND VERIFY ALL DIMENSIONS AND MATERIALS TO BE USED IN THE CONSTRUCTION OF THE WORK. THE CONTRACTOR SHALL BE RESPONSIBLE FOR THE ACCURACY OF THE DIMENSIONS AND MATERIALS. THE CONTRACTOR SHALL BE RESPONSIBLE FOR THE ACCURACY OF THE DIMENSIONS AND MATERIALS. THE CONTRACTOR SHALL BE RESPONSIBLE FOR THE ACCURACY OF THE DIMENSIONS AND MATERIALS.

fenar group  
limited  
consulting engineers

132 KENNEDY AVENUE, SUITE 201  
MARKHAM, ONTARIO L3R 9S2  
TEL: (416) 947-2100 FAX: (416) 947-2105



HURONTARIO NO. 3  
PUBLIC SCHOOL  
235 NAHANI WAY  
MISSISSAUGA, ONTARIO



stafford  
haensli  
architects

INCORPORATED

STAFFORD HAENSLI ARCHITECTS INC.  
235 NAHANI WAY, SUITE 201  
MISSISSAUGA, ONTARIO L3R 9S2  
TEL: (416) 947-2100 FAX: (416) 947-2105

SCALE  
AS NOTED  
DATE  
1990 05 22  
DRAWN  
M. BOBAGINA  
CHECKED  
J. JAKOBCEK

1. FAN MOTOR  
2. 4-STAGE ELECTRIC HEATING COIL  
3. SPACE TEMPERATURE SENSOR  
4. MIXED AIR TEMPERATURE SENSOR  
5. OUTDOOR AIR TEMPERATURE SENSOR  
6. DAMPER ACTUATOR  
7. SUPPLY AIR TEMPERATURE SENSOR  
8. RETURN AIR TEMPERATURE SENSOR  
9. FAN SPEED CONTROL RELAY  
10. FAN START/STOP CONTROL RELAY  
11. FAN STOP CONTROL RELAY  
12. FAN STOP CONTROL RELAY  
13. FAN STOP CONTROL RELAY  
14. FAN STOP CONTROL RELAY  
15. FAN STOP CONTROL RELAY  
16. FAN STOP CONTROL RELAY  
17. FAN STOP CONTROL RELAY  
18. FAN STOP CONTROL RELAY  
19. FAN STOP CONTROL RELAY  
20. FAN STOP CONTROL RELAY

SUPPLY GRILLES - DETAILS

RETURN GRILLES - DETAILS